



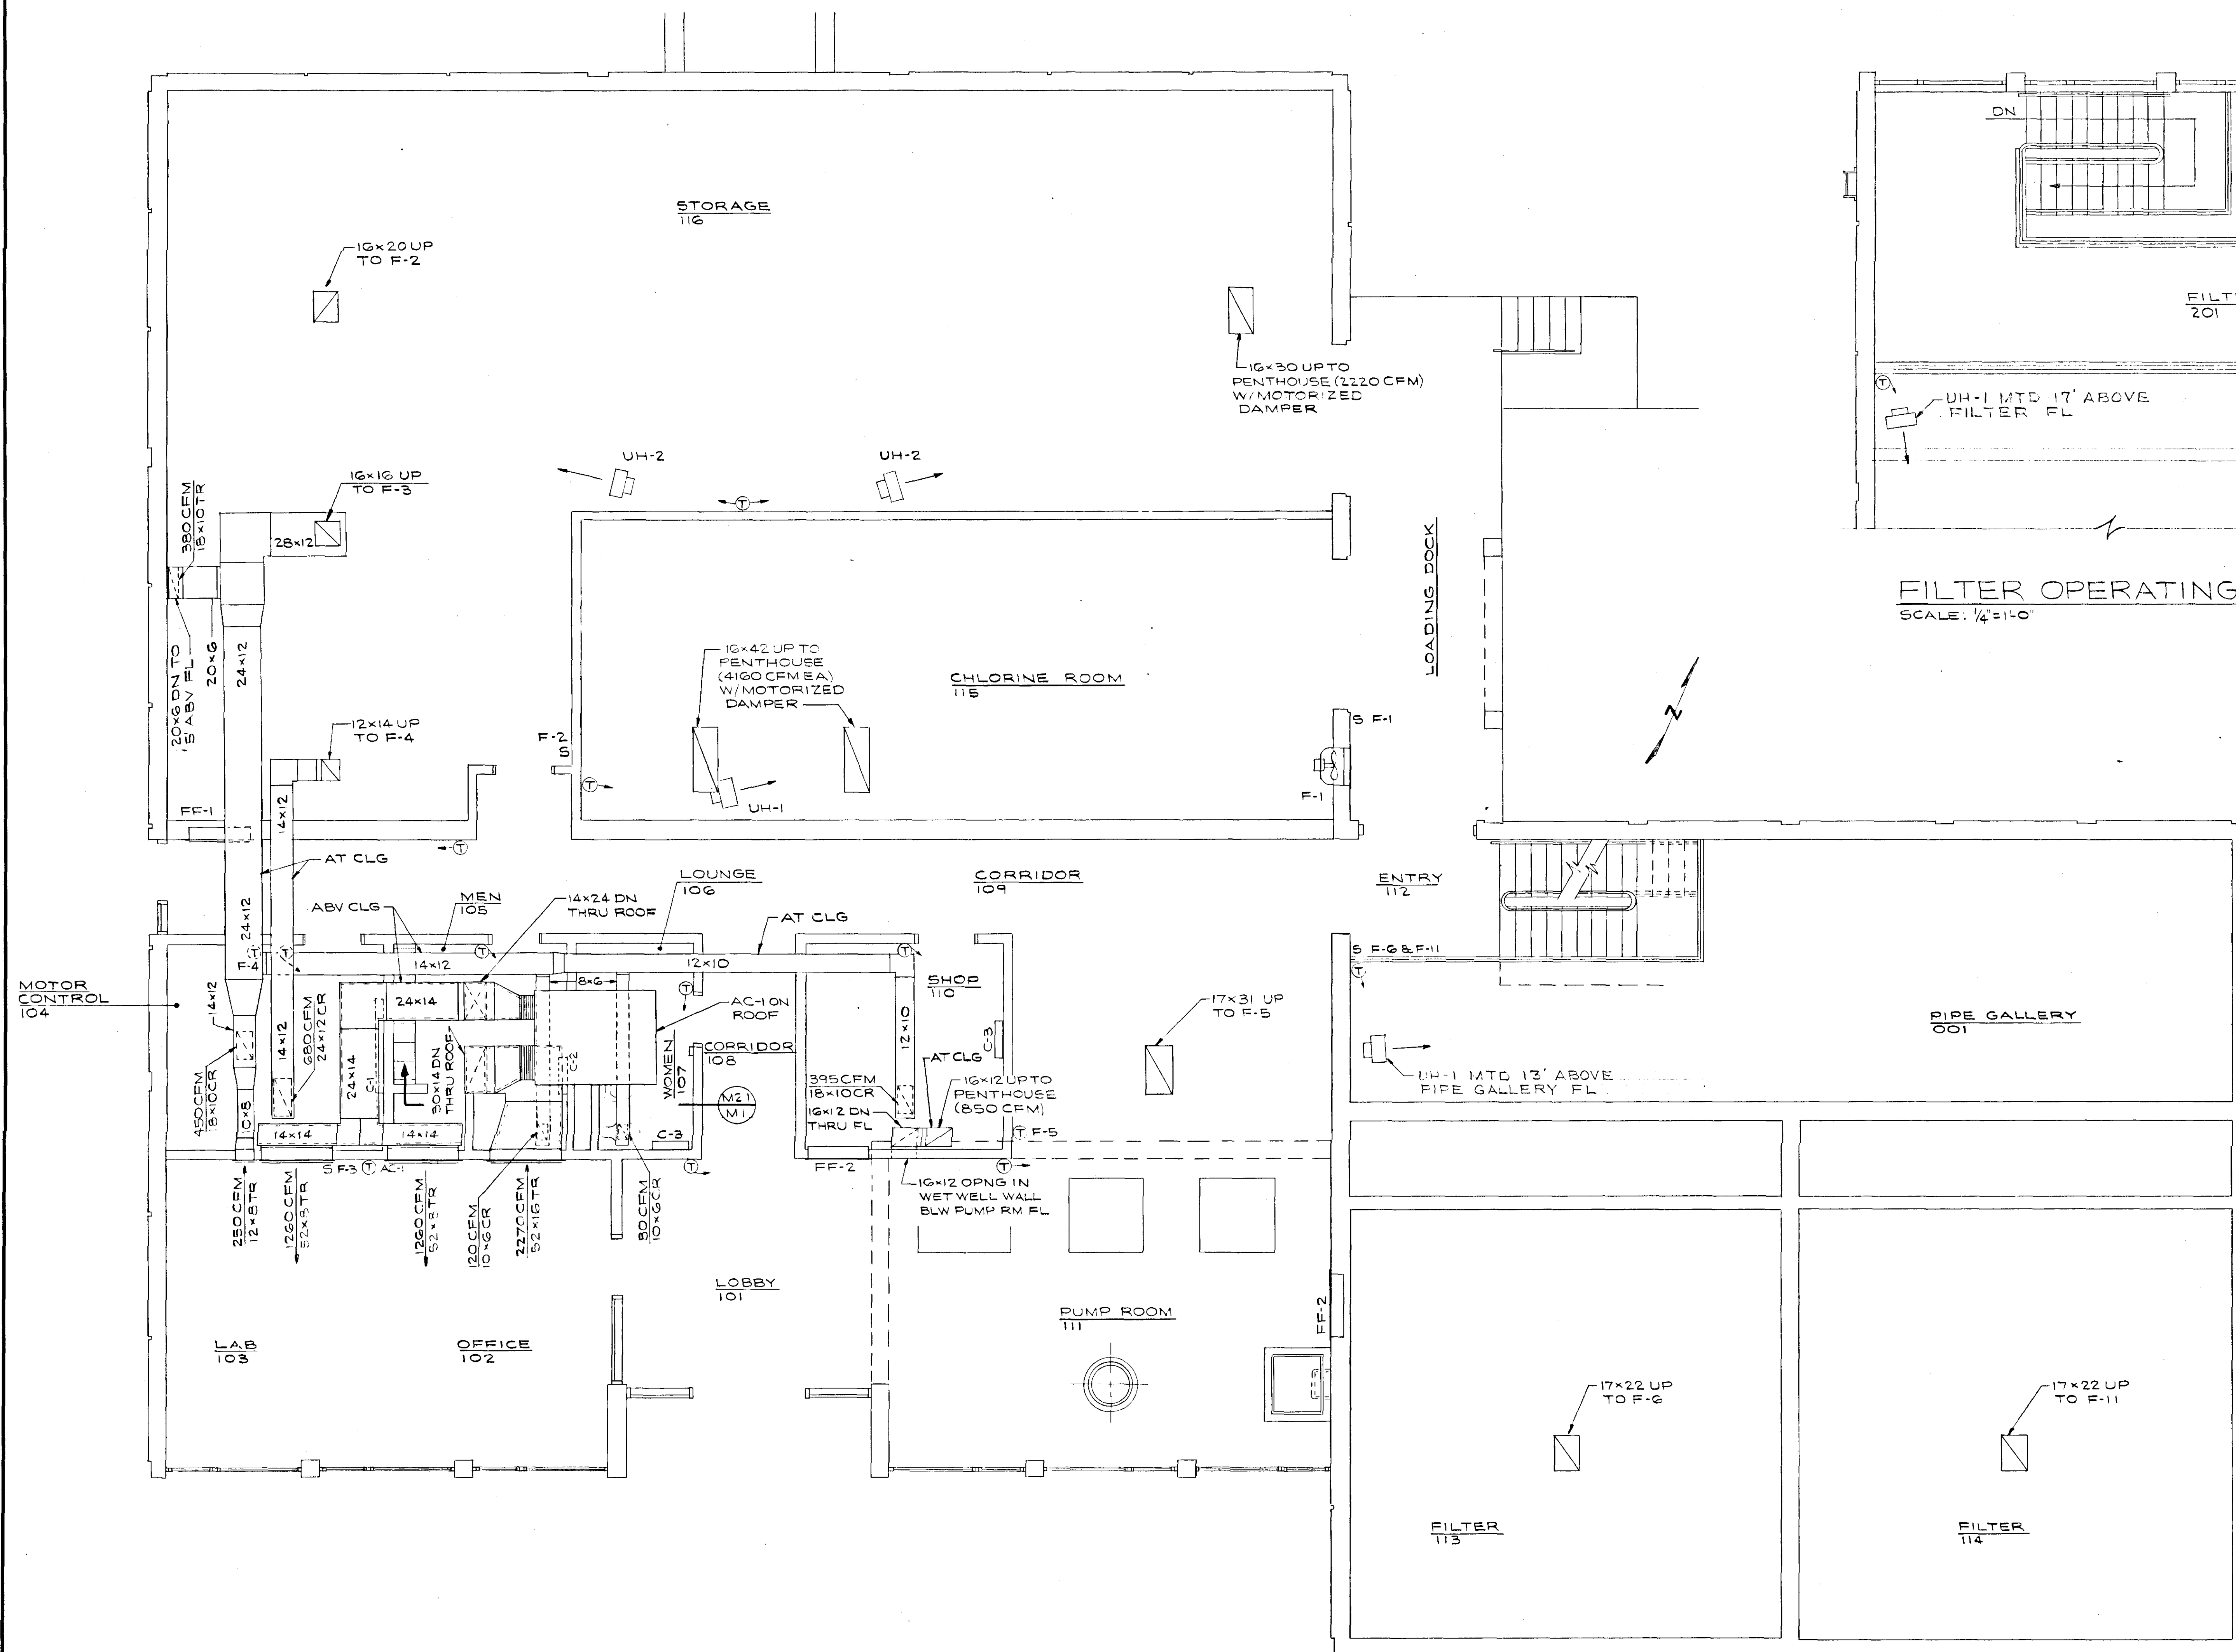

GROUND FLOOR PLAN
SCALE: 1/4"=1'-0"

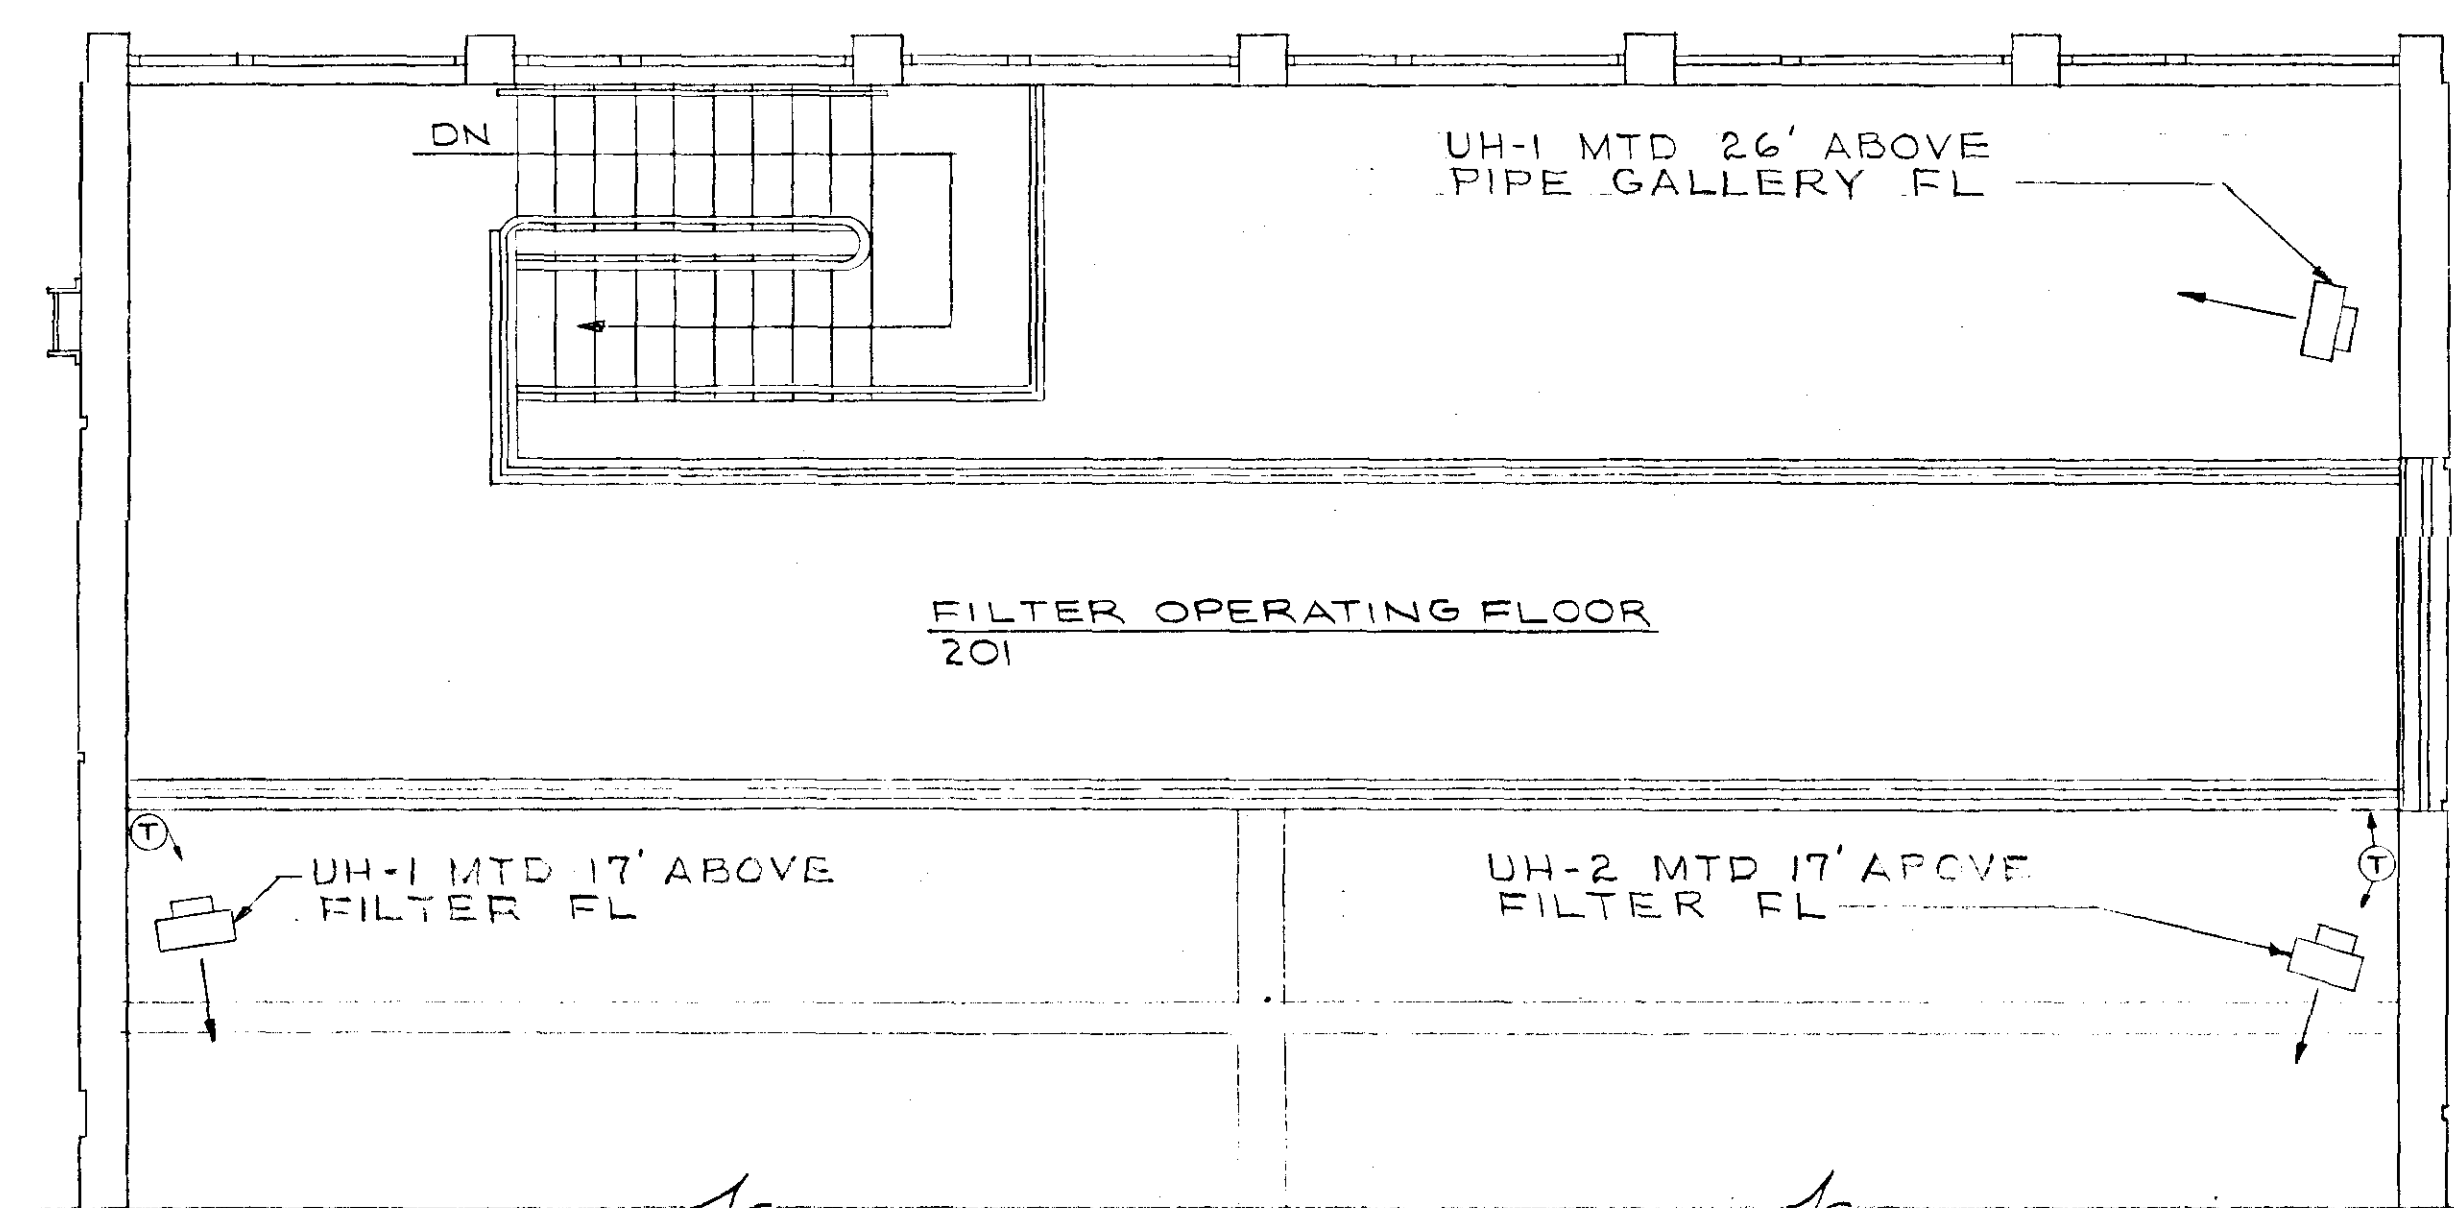

FILTER OPERATING FLOOR PLAN
SCALE: 1/4"=1'-0"

REVISION	DATE	DESCRIPTION	BY	APP.
DESIGNED	AWW	WATER FILTRATION PLANT CITY OF SALEM, VIRGINIA HEATING, VENTILATING AND AIR CONDITIONING FLOOR PLANS		
DRAWN	BA			
CHECKED	SRL			
APPROVED	JMS			
SUBMITTED	11/11			
HAYES, SEAY, MATTERN & MATTERN ARCHITECTS-ENGINEERS ROANOKE, VIRGINIA		SCALE AS NOTED DATE APRIL 1970	COMM. NO. 3627-A SHEET M-1	