



PLAN	SUBMITTED	DATE
	BY	
NOTE BOOK	PLANNED	
	CHECKED	

PROFILE	SUBMITTED	DATE
	BY	
NOTE BOOK	PLANNED	
	CHECKED	

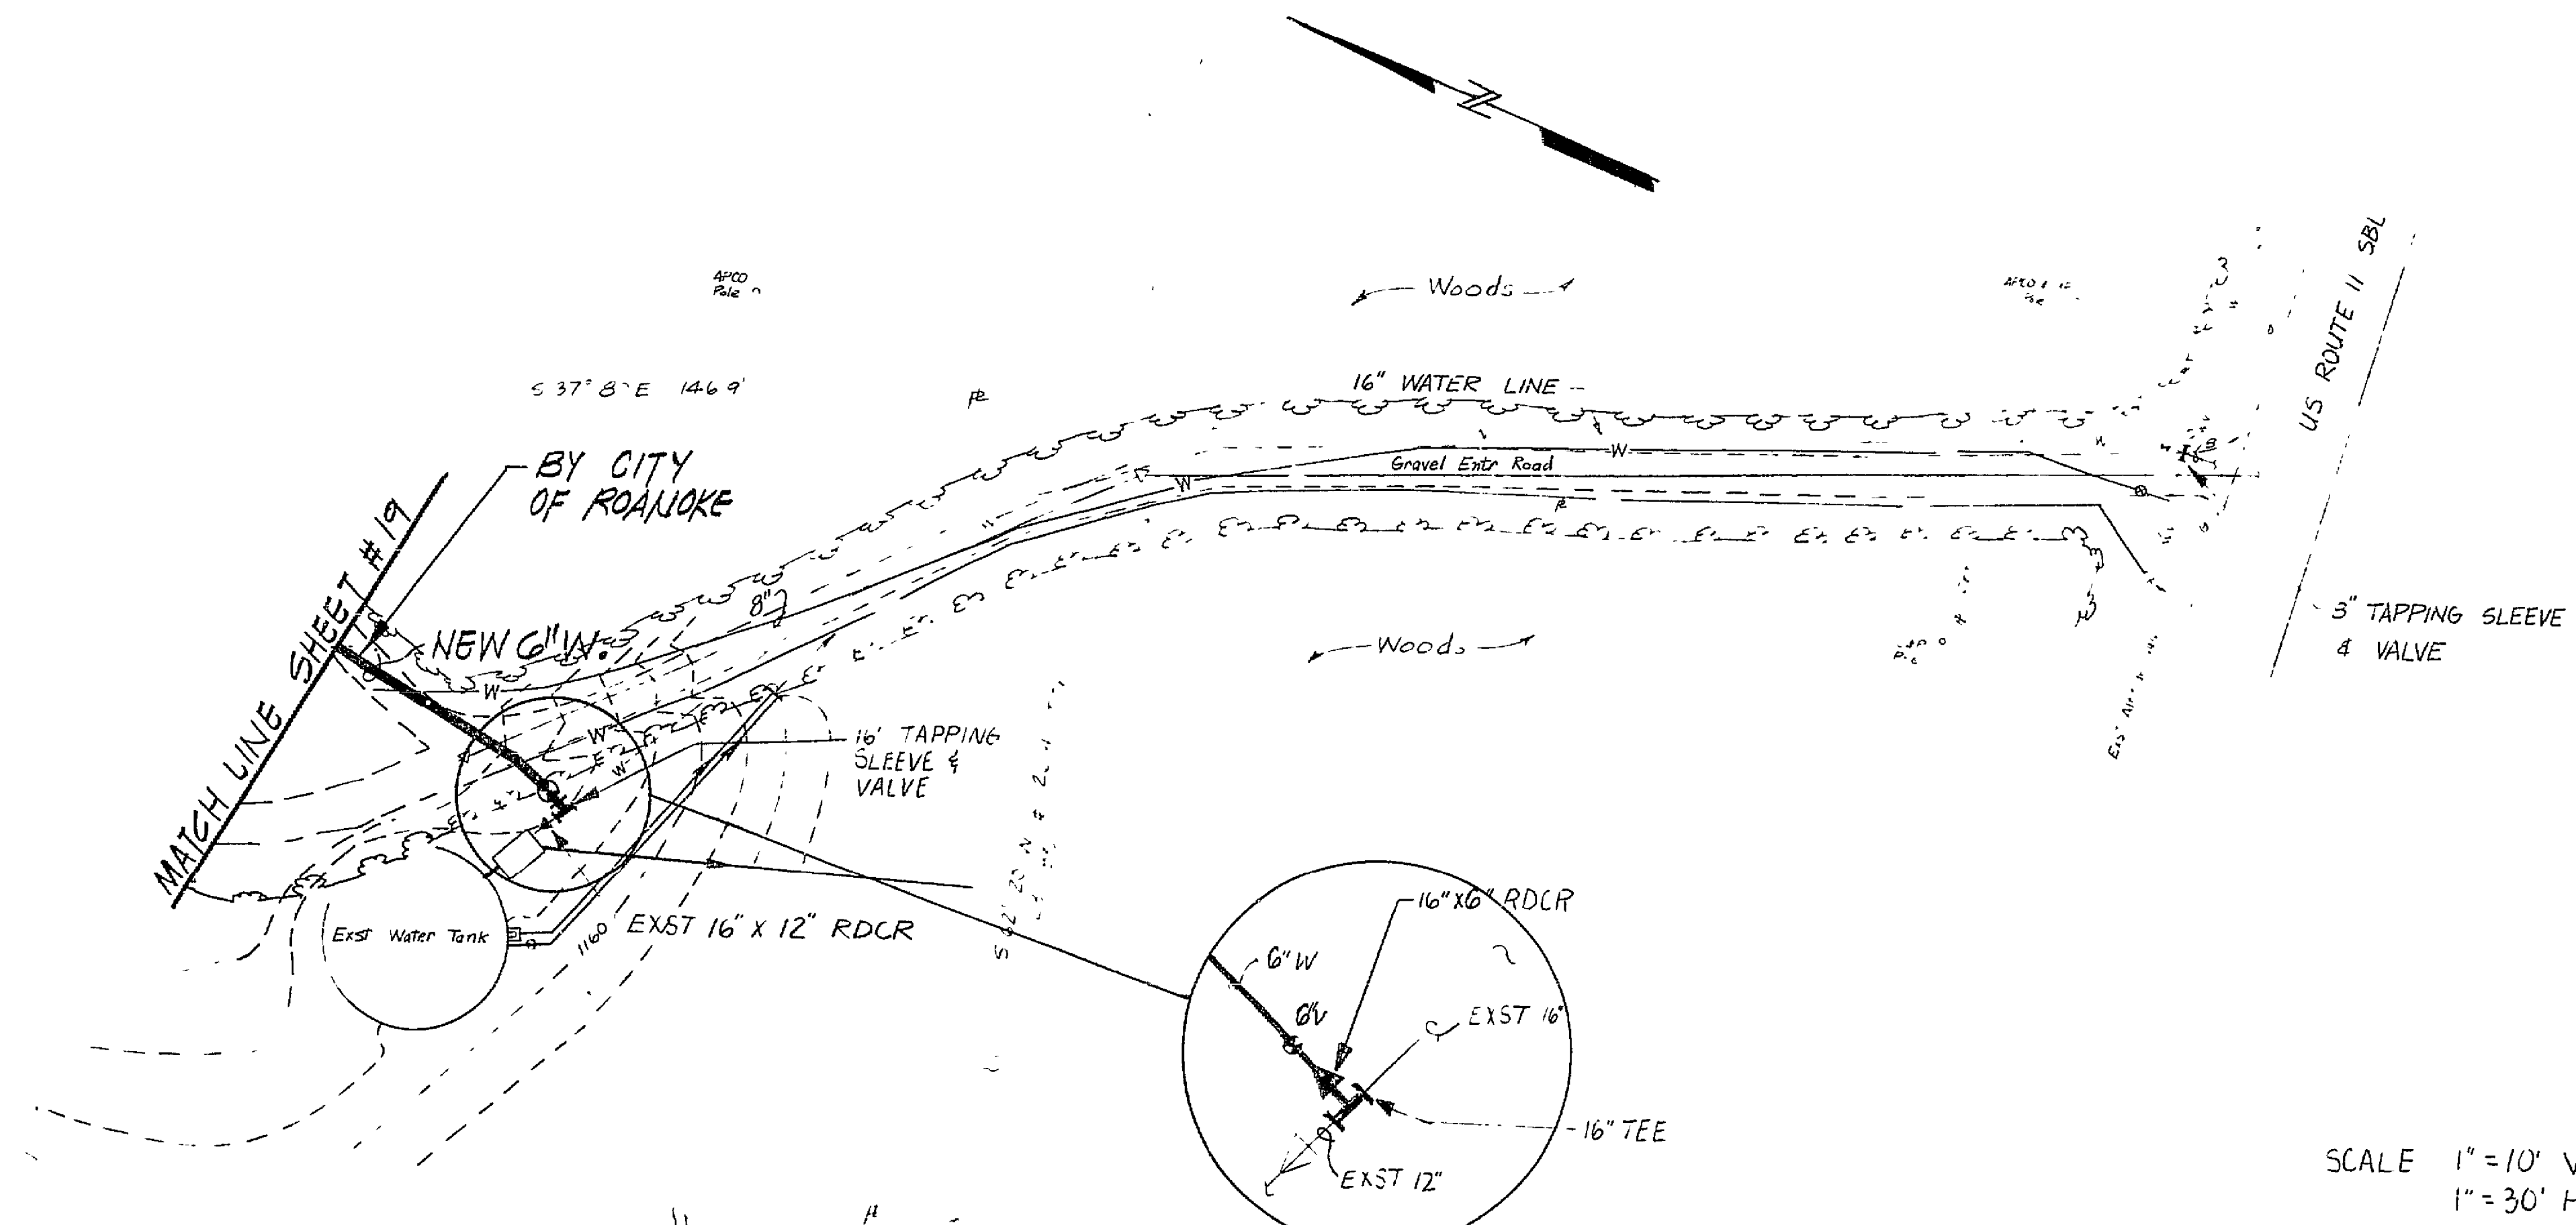

SCALE 1" = 10' VERT
1" = 30' HORIZ.

CONTRACT MATERIAL FOR CONN.
16" RDCR NEW 6" WATERLINE
TO THE RIGHT OF WAY LINE,
METER VAULT & 6" VALVES WILL
BE PROVIDED BY THE CITY OF
ROANOKE. ALL COSTS FOR THIS
WORK WILL BE PAID BY
THE CONTRACTOR.

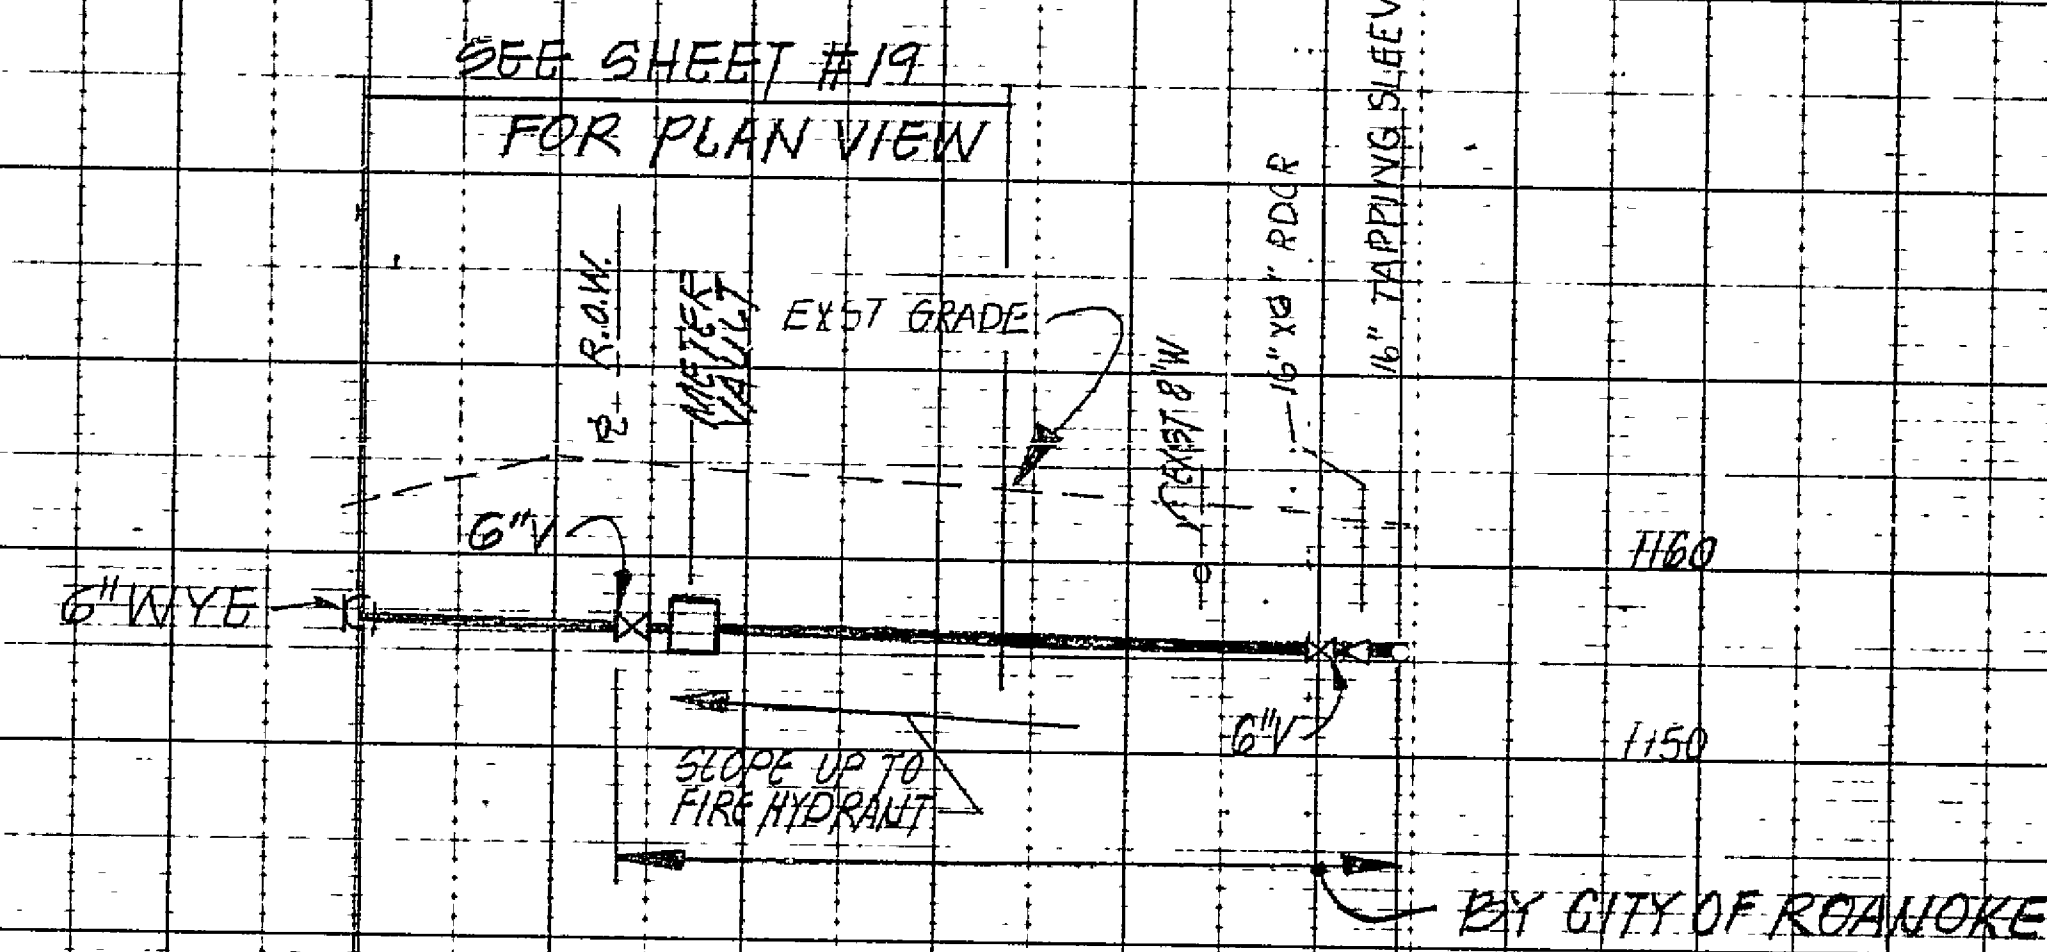

PROFILE - 6" WATERLINE

1 12/ 88 RECORD DRAWINGS		JLJ
REVISION	DATE	DESCRIPTION
DESIGNED	CAT	
DRAWN	CAT	
CHECKED	JWC	
APPROVED		
SUBMITTED		

PLAN AND PROFILE
(EXST. WATER TANK & 'C')
(CONNECTION TO
EXST. WATER SYSTEM)

SCALE AS NOTED	COMM. NO. 491
DATE AUG 88	SHEET 30

RECORD DRAWING

86-09-W/S

