



FALLING CREEK WATER PROJECT-PHASE II

TOWN OF VINTON, VIRGINIA


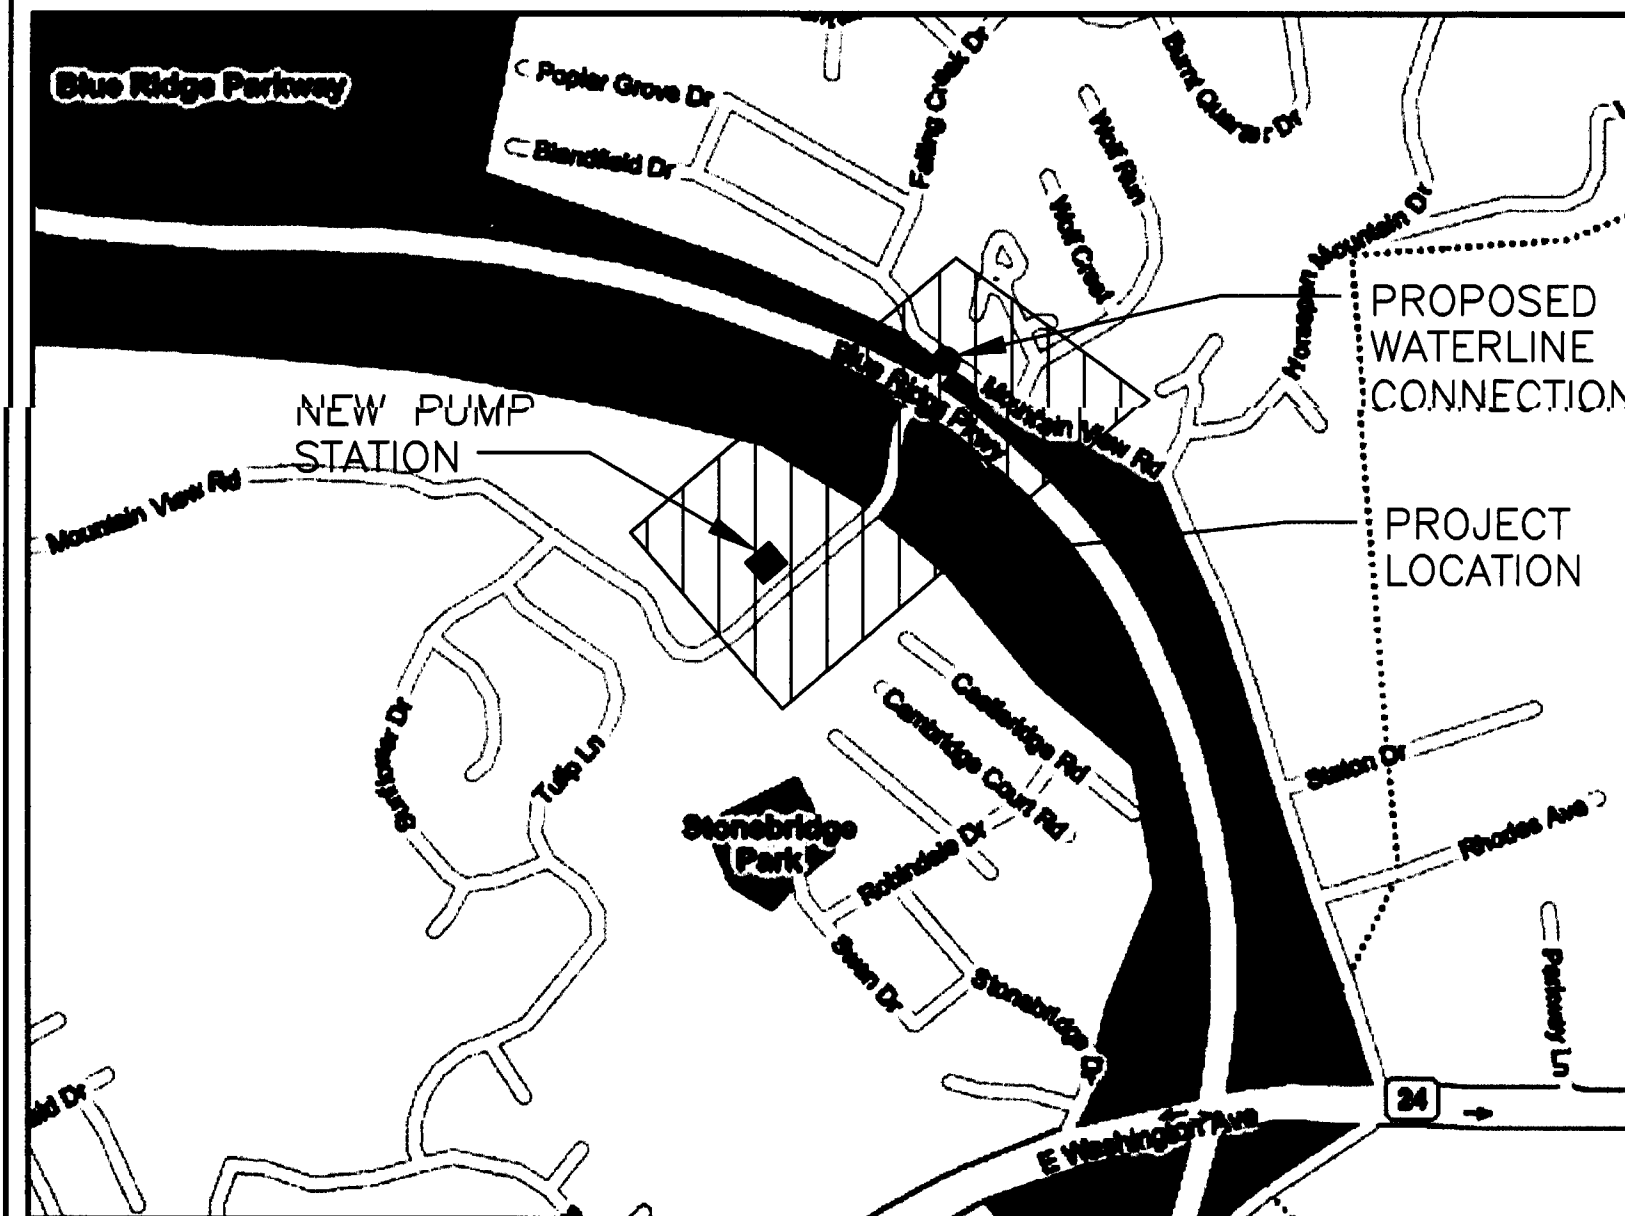


LOCATION MAP
NTS

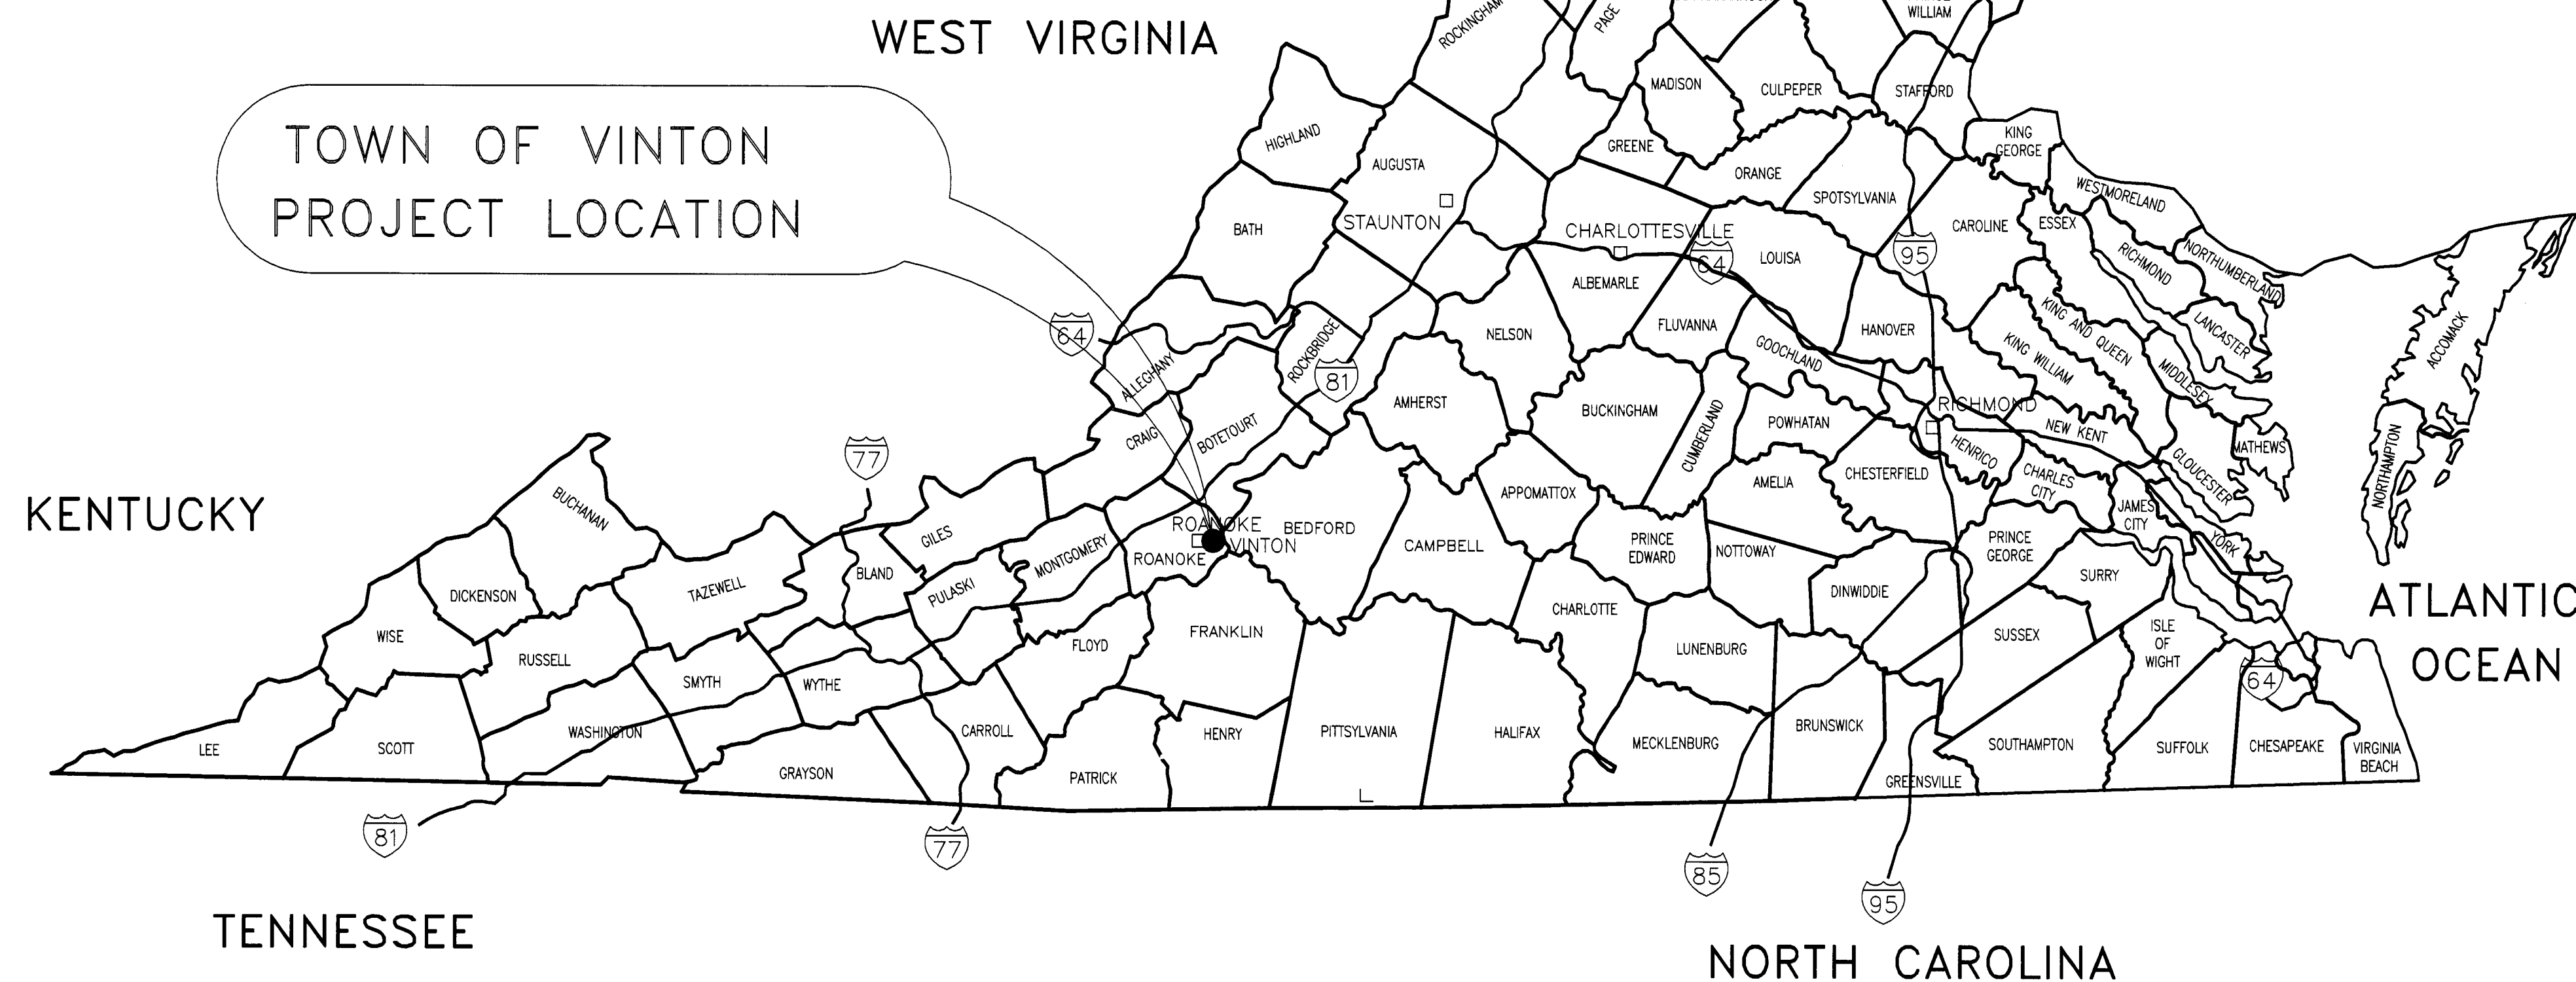

SHEET LIST


- C-1 TITLE SHEET
- C-2 ABBREVIATIONS & LEGEND
- C-3 PUMP STATION- SITE PLAN
- C-4 PUMP STATION- FLOOR PLAN
- C-5 PUMP STATION- ELEVATIONS
- C-6 PUMP STATION- SECTIONS AND DETAILS
- C-7 PLAN & PROFILE- 8" WATERLINE
- M-1 PUMP STATION- PLANS, SCHEDULES- MECHANICAL & ELECTRICAL

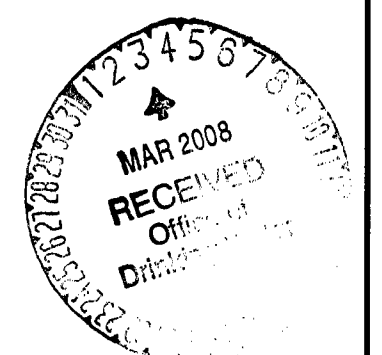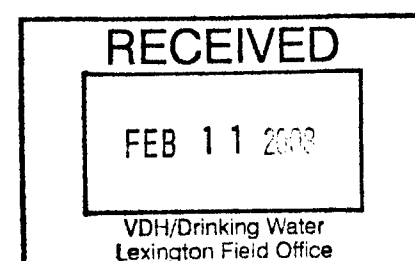

COMMONWEALTH OF VIRGINIA/Department of Health
Office of Drinking Water
Lexington Environmental Engineering Field Office

☒ Plans & Specifications	☒ Approved
☒ Operation & Maintenance Manual	☒ Disapproved
☒ Addendum	
☒ Change Order	
☒ Revised Plan Sheet(s)	
☒ Revised Specification Sheet(s)	
☒ Water Line Extension	
☒ Report	


2-29-08 Date *Douglas M. Caldwell* Engineering Field Director

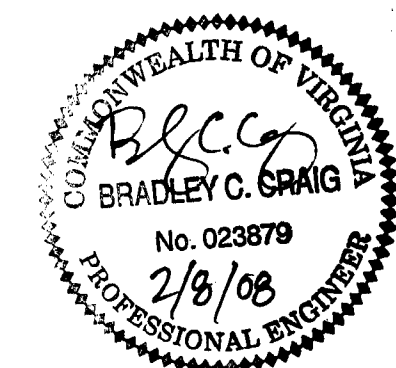

COMM. NO. 1955-K

SET NC

FIELD OFFICE LEXINGTON
CITY/COUNTY LEXINGTON
PROJECT NO. 26724
TITLE FALLING CREEK - PHASE II - TOWN OF VINTON
APPROVAL DATE 2-29-08
WATERWORKS FALLING CREEK ESTIMATES
PWSID # 2161830

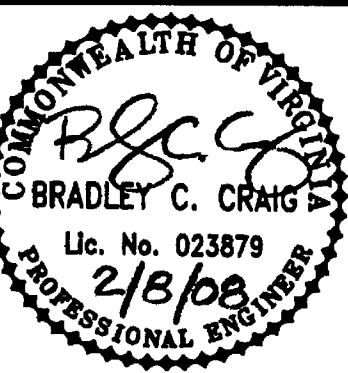

Date	
Revisions	

Issue Date: FEBRUARY, 2008
Drawn By: BCC
Designed By: BCC
Checked By: BCC
Date: FEB., 2008

Mattern & Craig
CONSULTING ENGINEERS • SURVEYORS
701 FIRST STREET, S.W.
ROANOKE, VIRGINIA 24016
(540) 345-9342
FAX (540) 345-7691

FALLING CREEK WATER PROJECT-PHASE II
TITLE SHEET
TOWN OF VINTON, VIRGINIA

Vertical Scale: N/A
Horizontal Scale: N/A
Commission Number: 1955-K
Sheet No.:

C-1

Mattern & Craig, Inc.
CONSULTING ENGINEERS • SURVEYORS
701 FIRST STREET, S.W.
ROANOKE, VIRGINIA 24016
(540) 345-9342
(540) 345-7691 FAX