


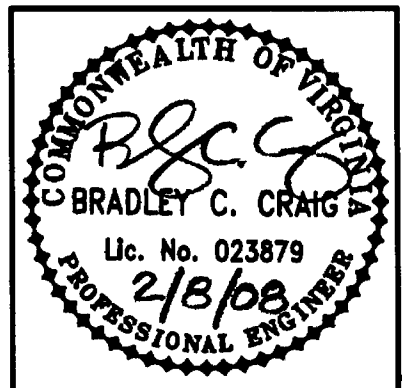

Revisions	Date

Issue Date:	February, 2008
Drawn By:	BCC
Designed By:	BCC
Checked By:	BCC
Date:	FEB., 2008

Matter & Craig
CONSULTING ENGINEERS • SURVEYORS
701 FIRST STREET, S.W.
ROANOKE, VIRGINIA 24016
(540) 545-9342
FAX (540) 345-7691


FALLING CREEK WATER PROJECT—PHASE II

**PUMP STATION—
ELEVATIONS**


TOWN OF VINTON, VIRGINIA

Vertical Scale:	N/A
Horizontal Scale:	AS NOTED
Commission Number:	1955-K
Sheet No.:	C-5


C-5

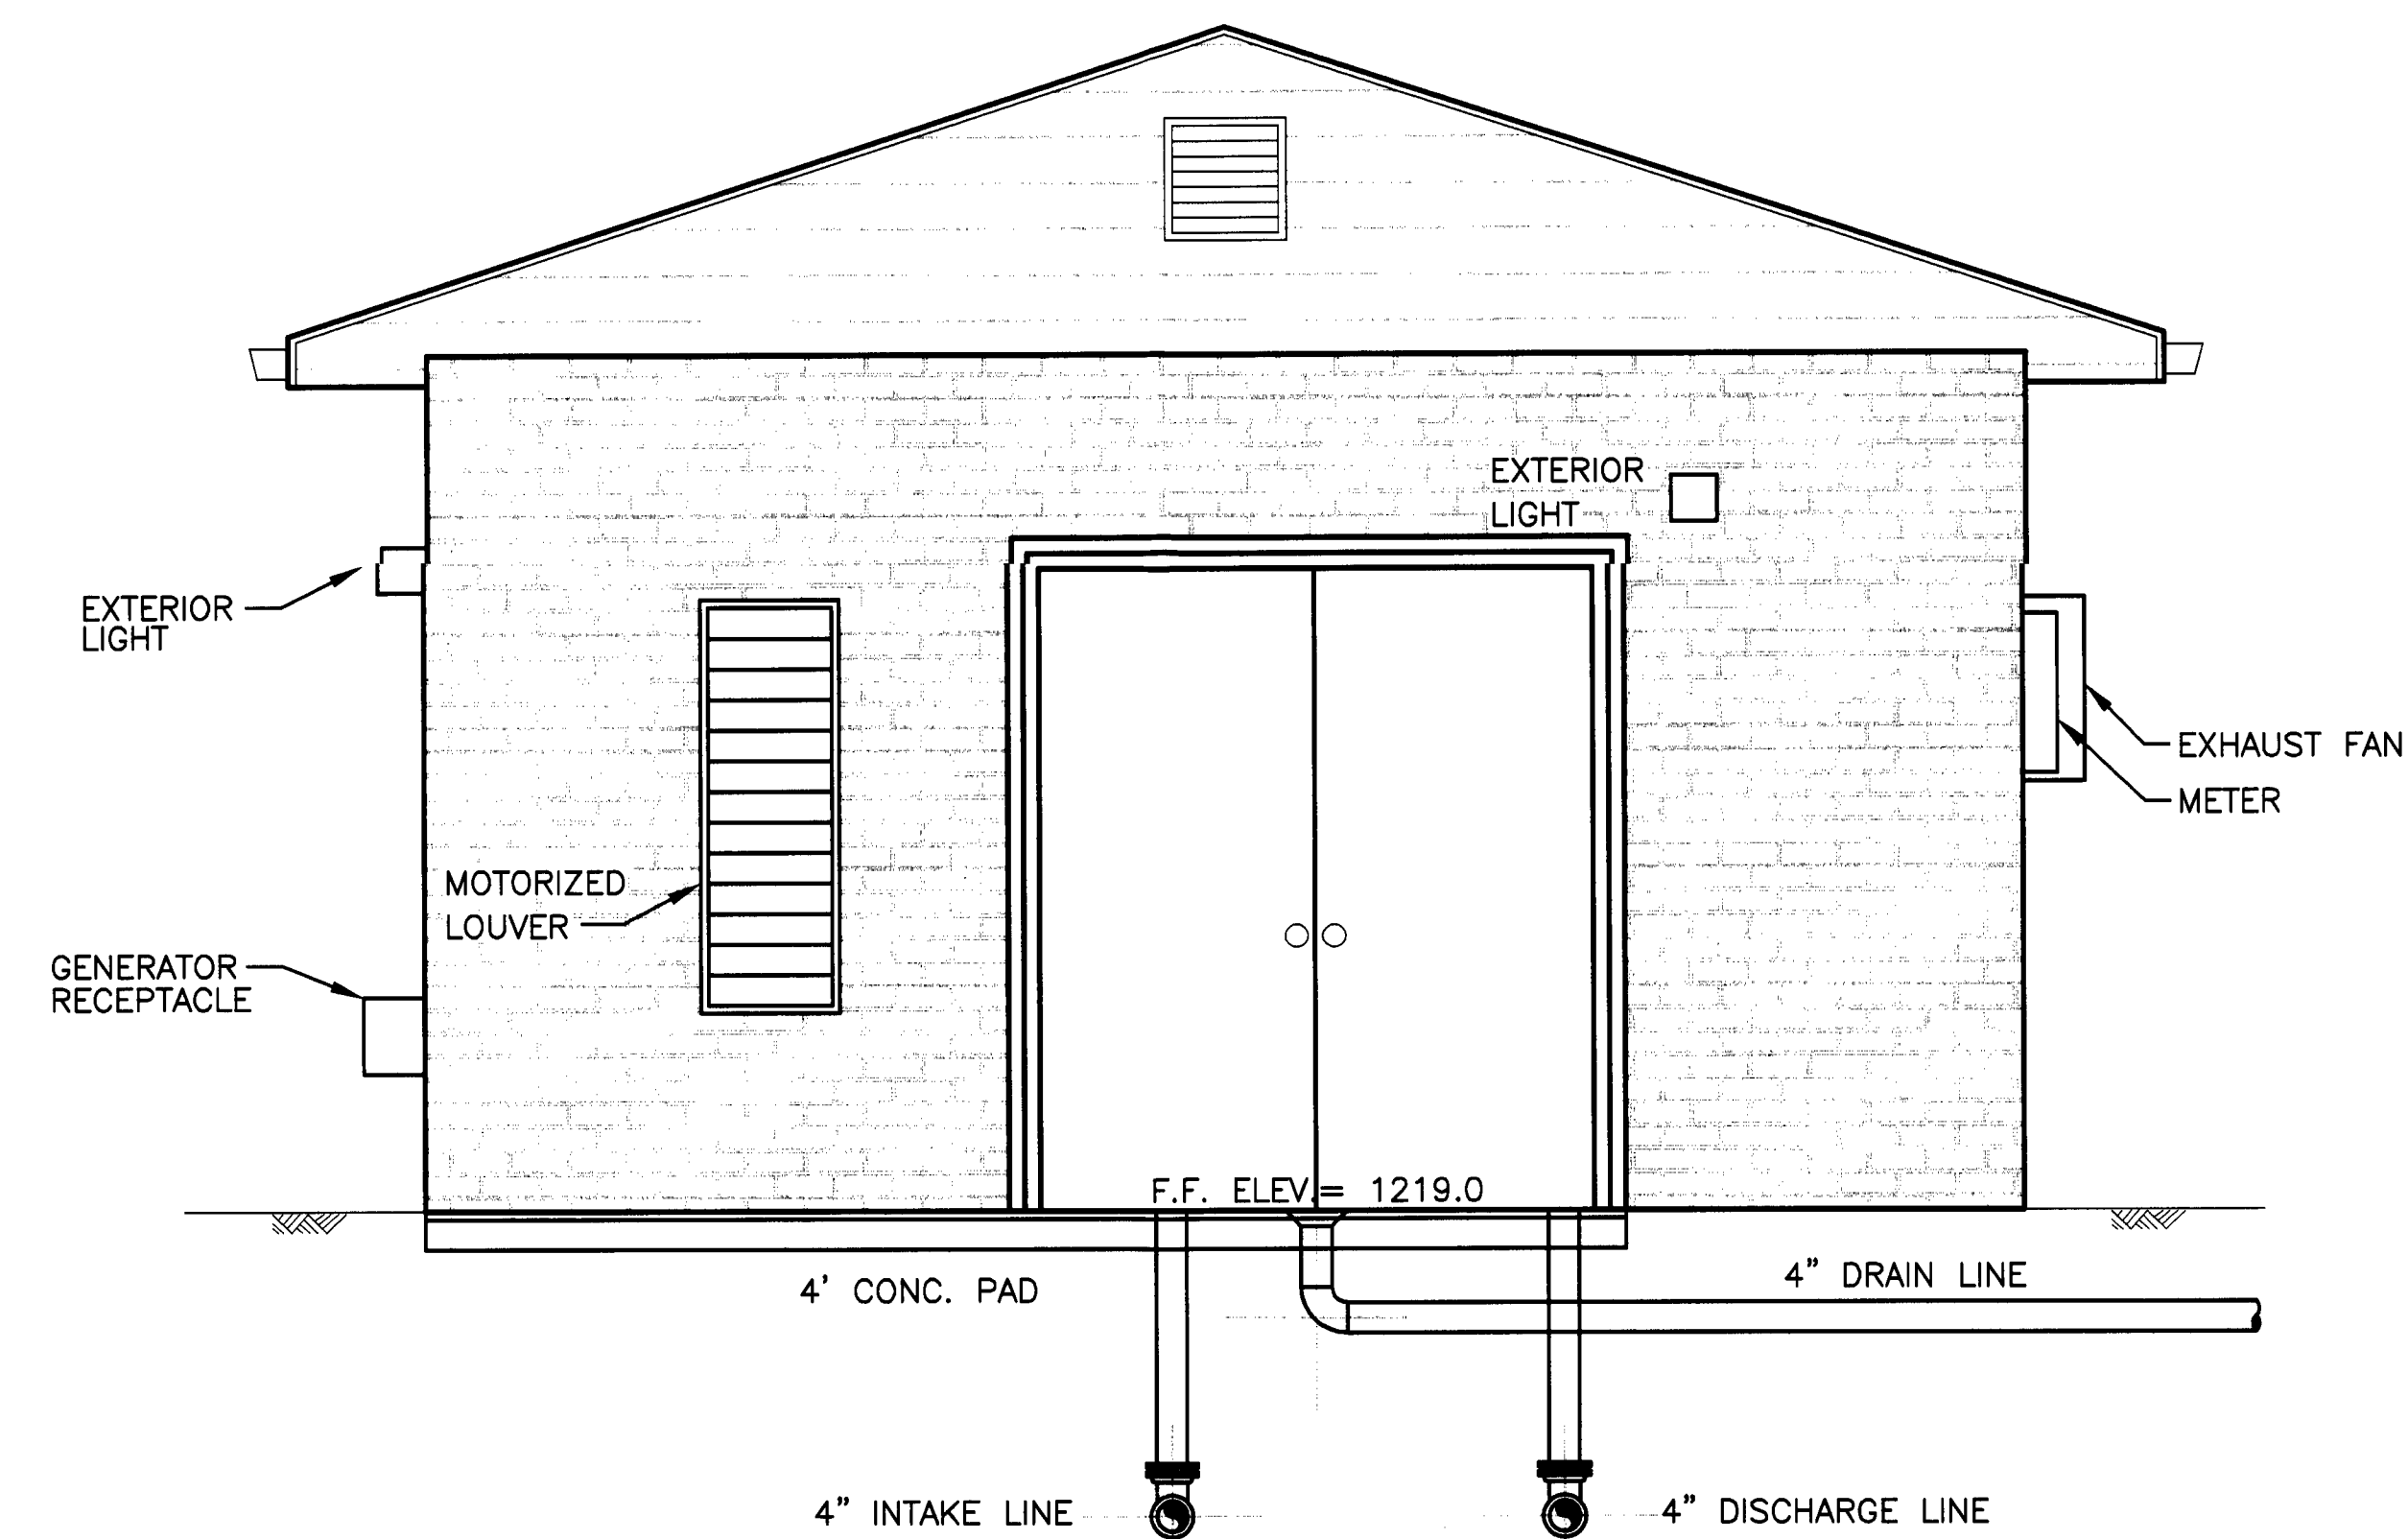


SOUTH ELEVATION
SCALE: 1/2" = 1'-0"

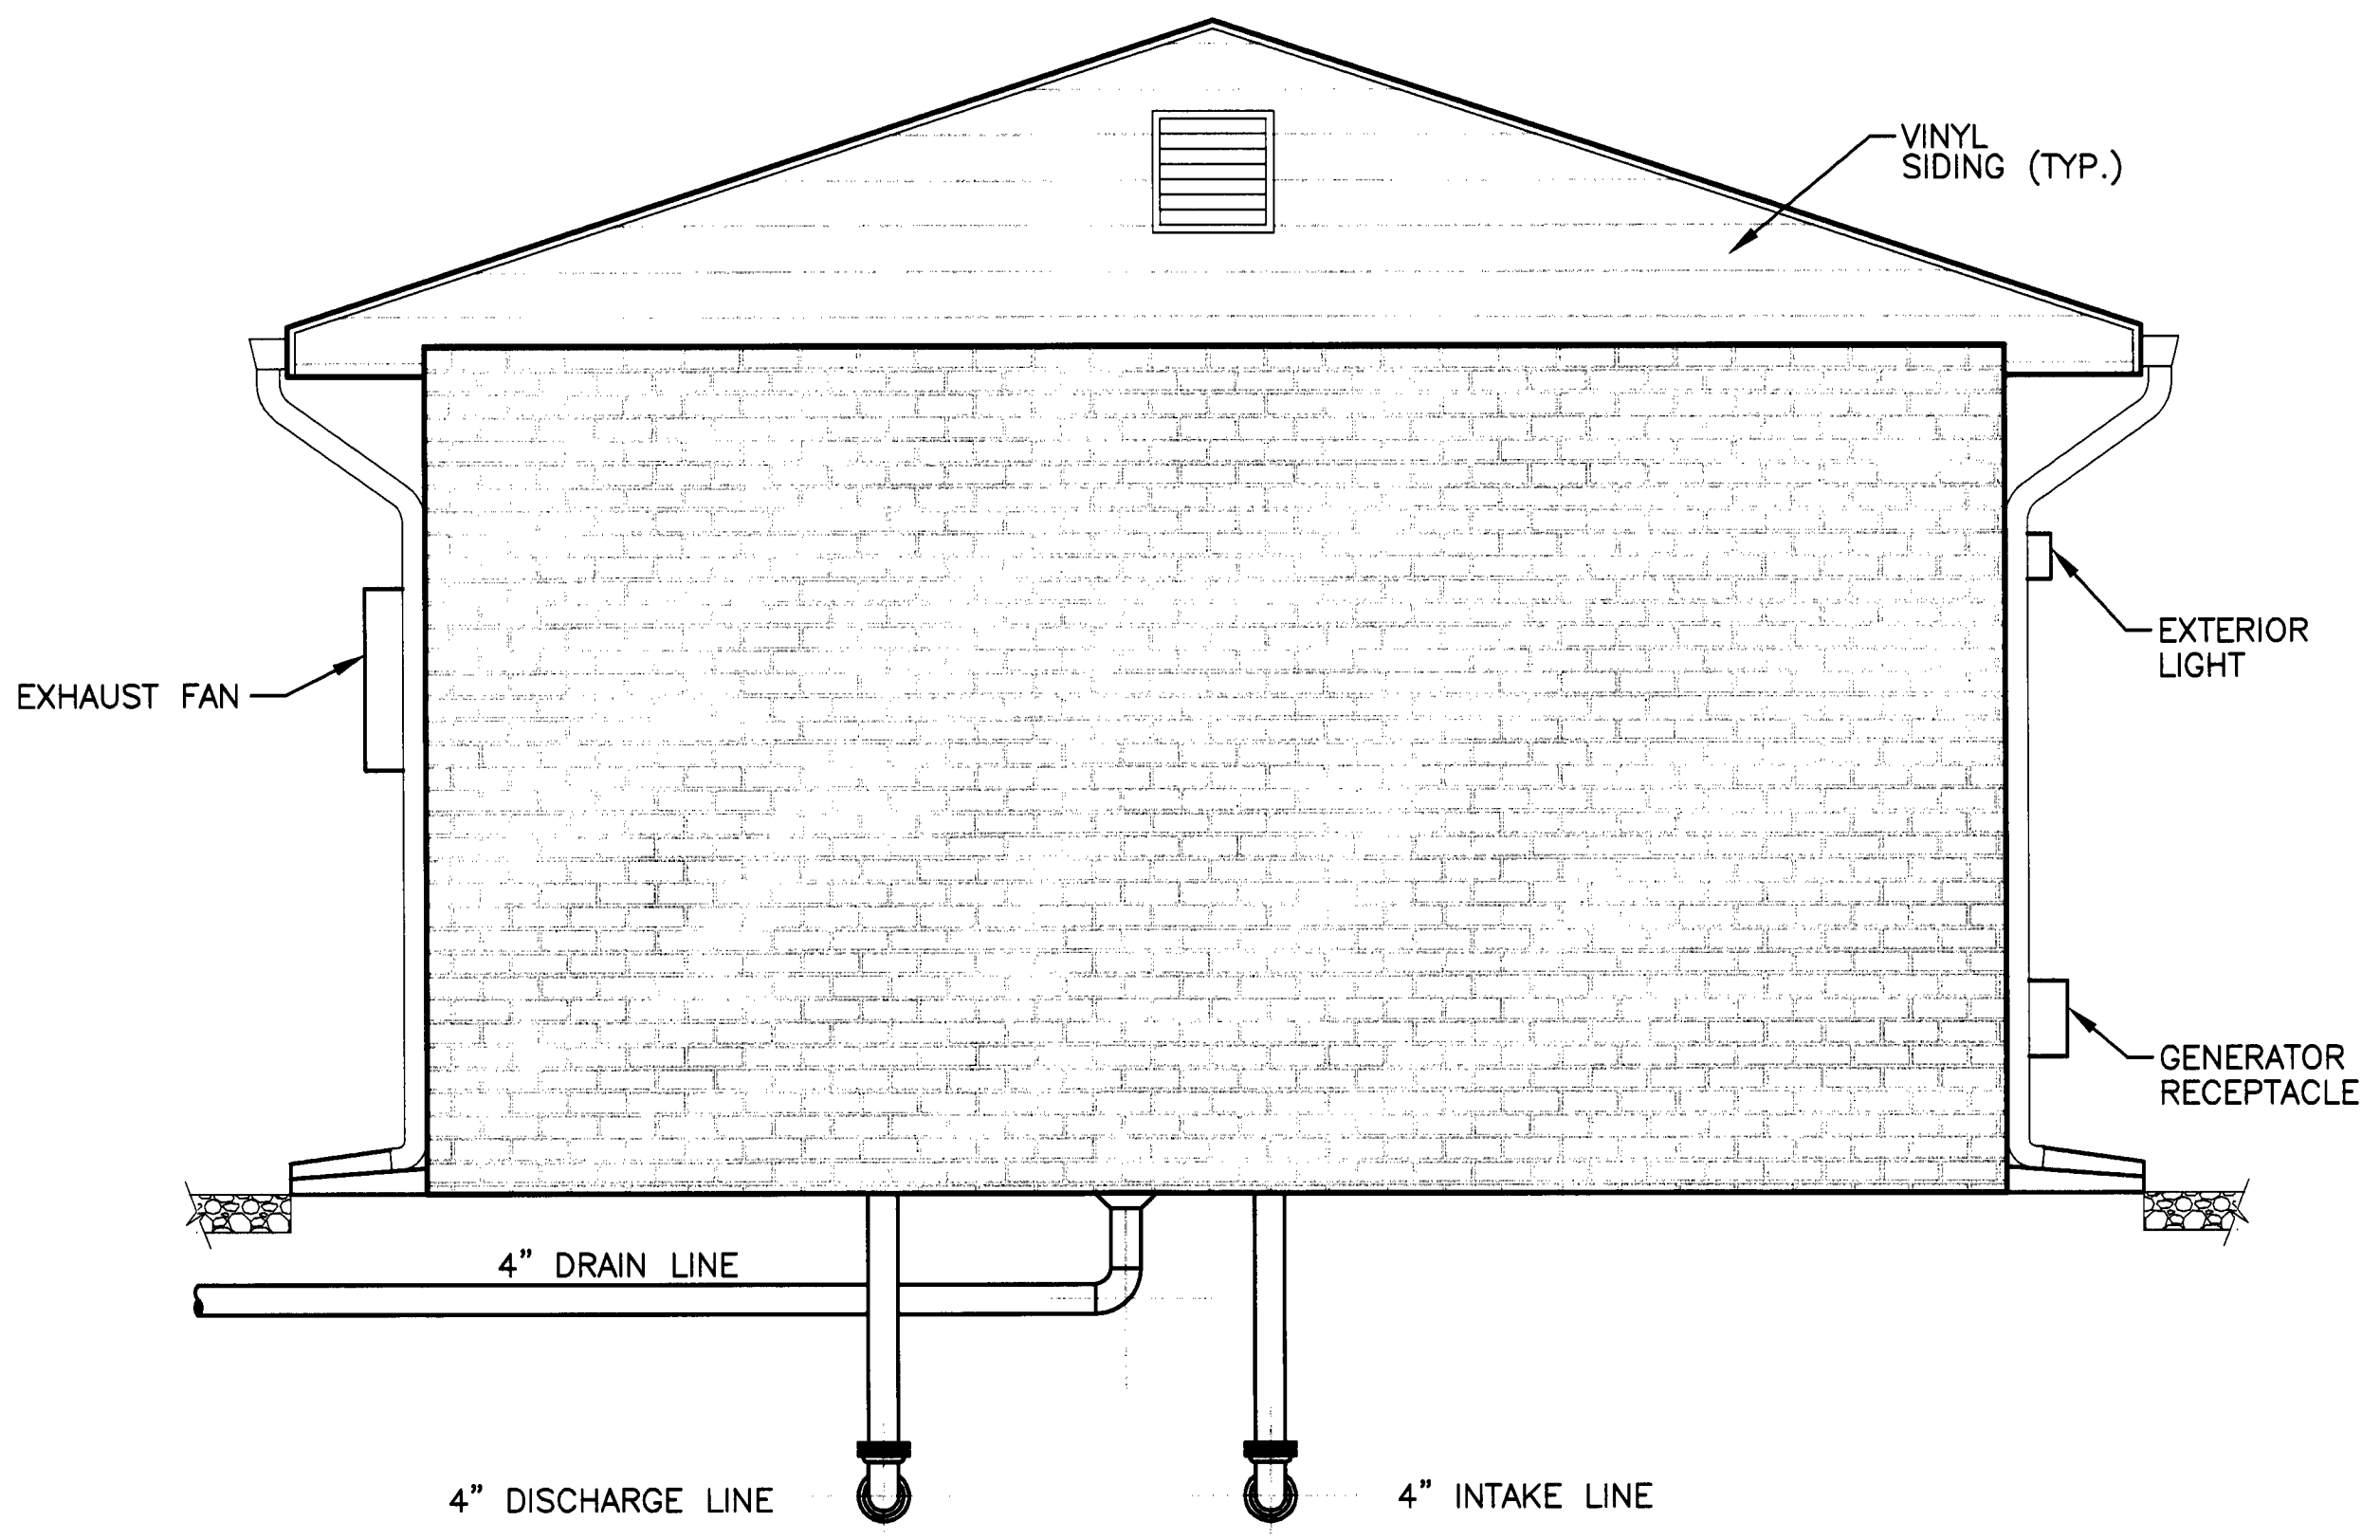

NORTH ELEVATION
SCALE: 1/2" = 1'-0"

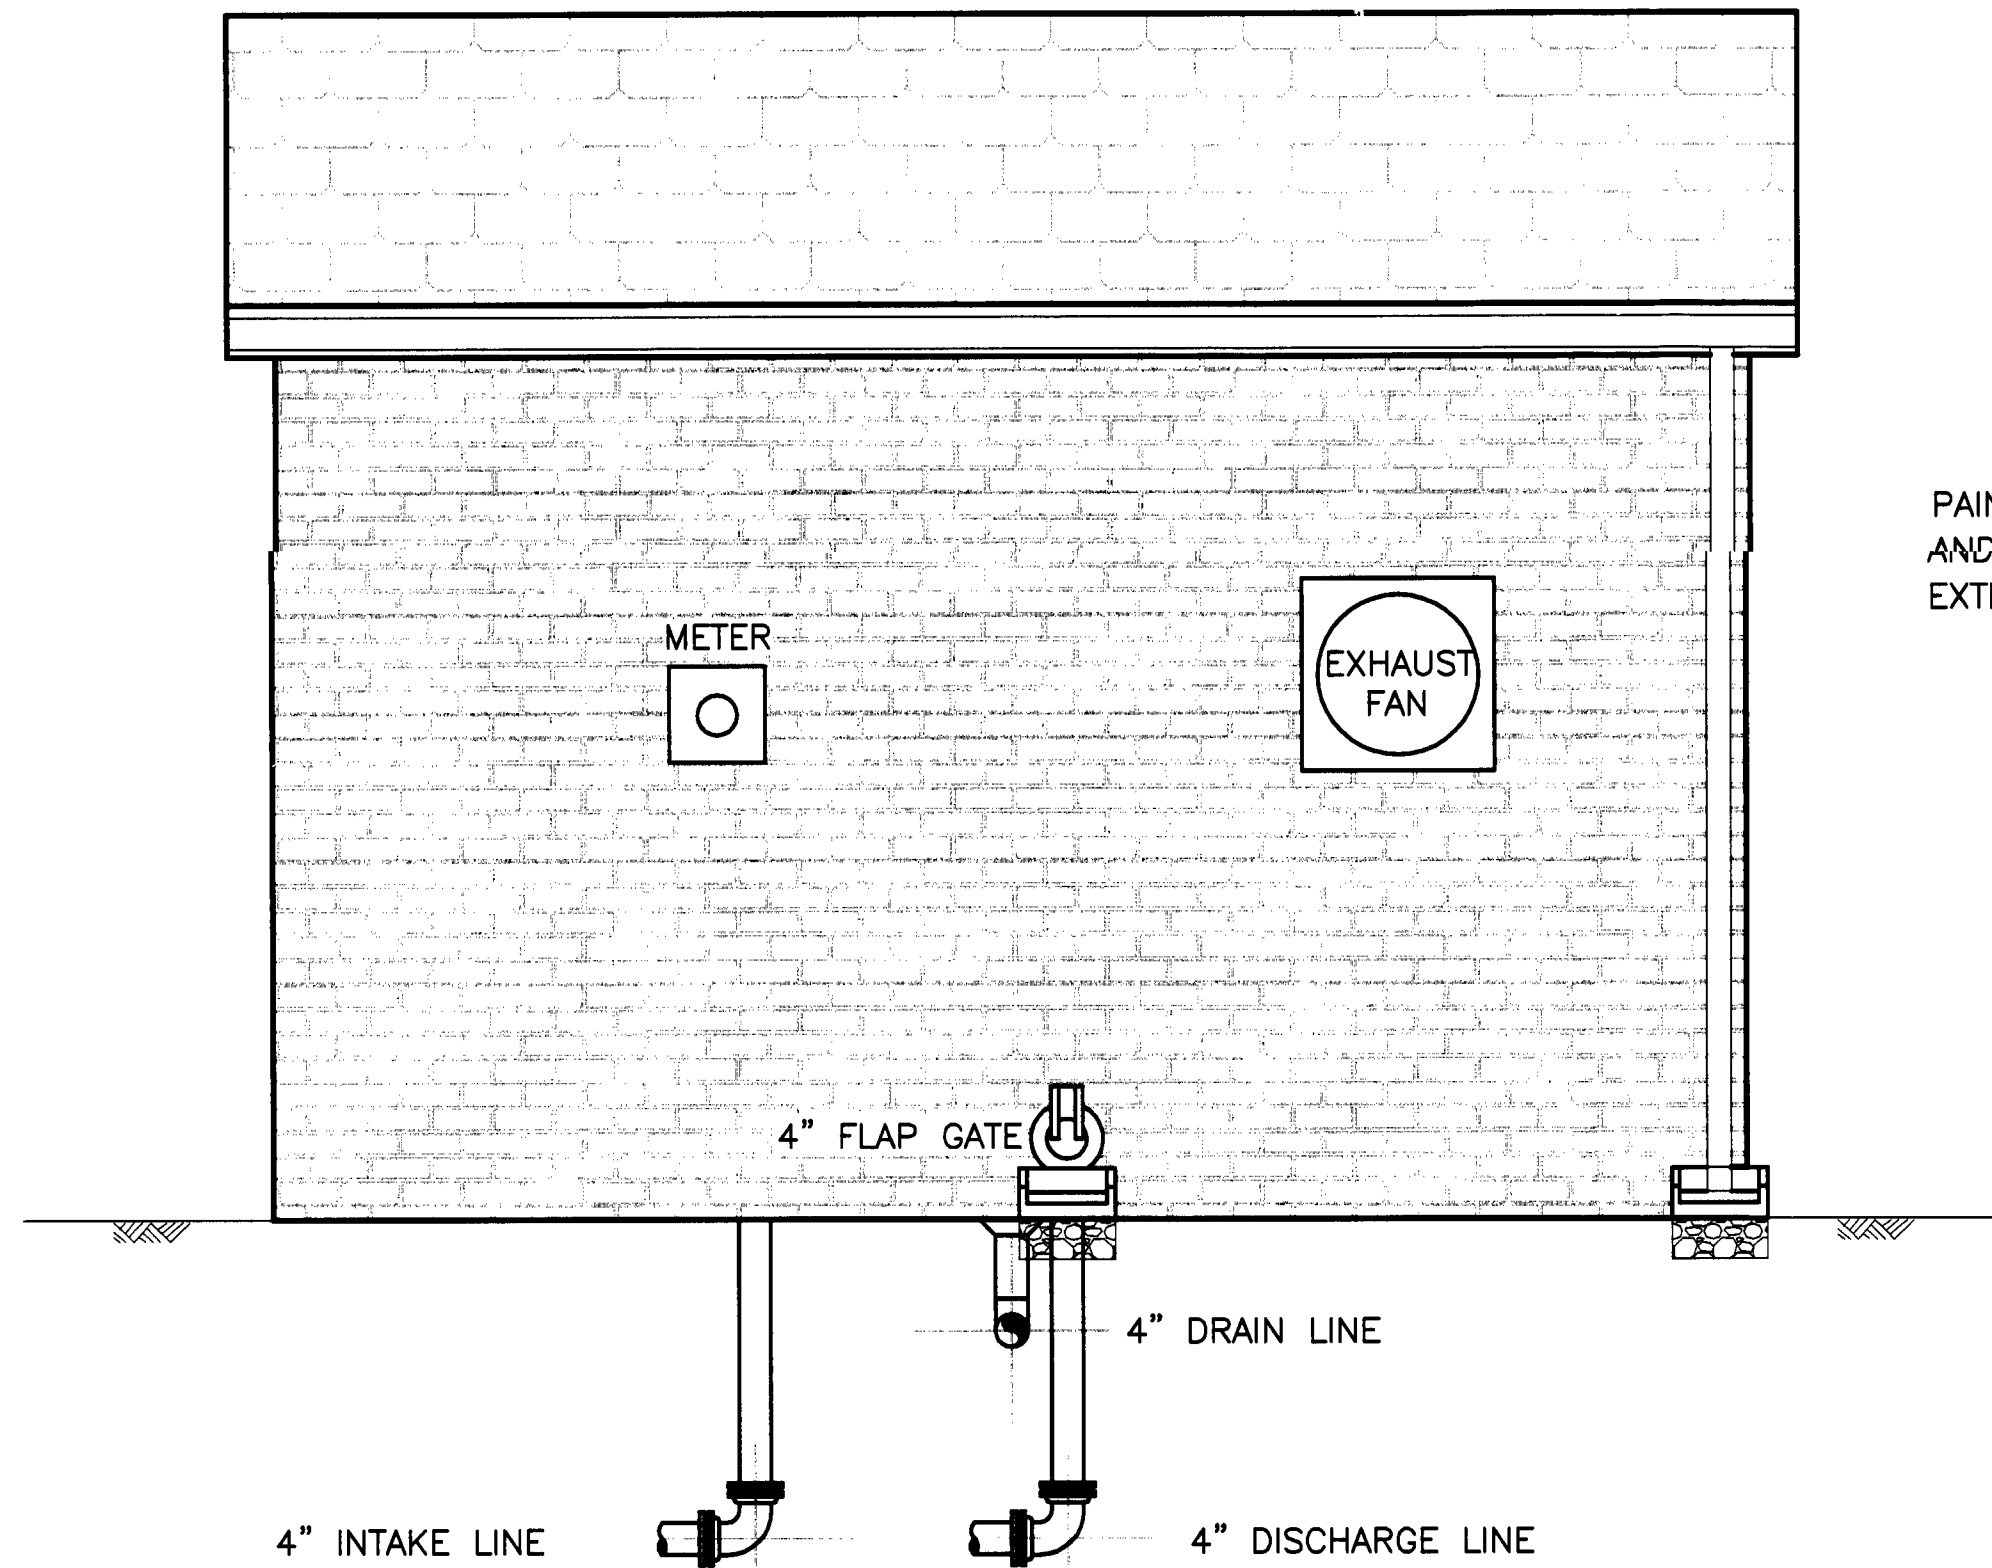

EAST ELEVATION
SCALE: 1/2" = 1'-0"

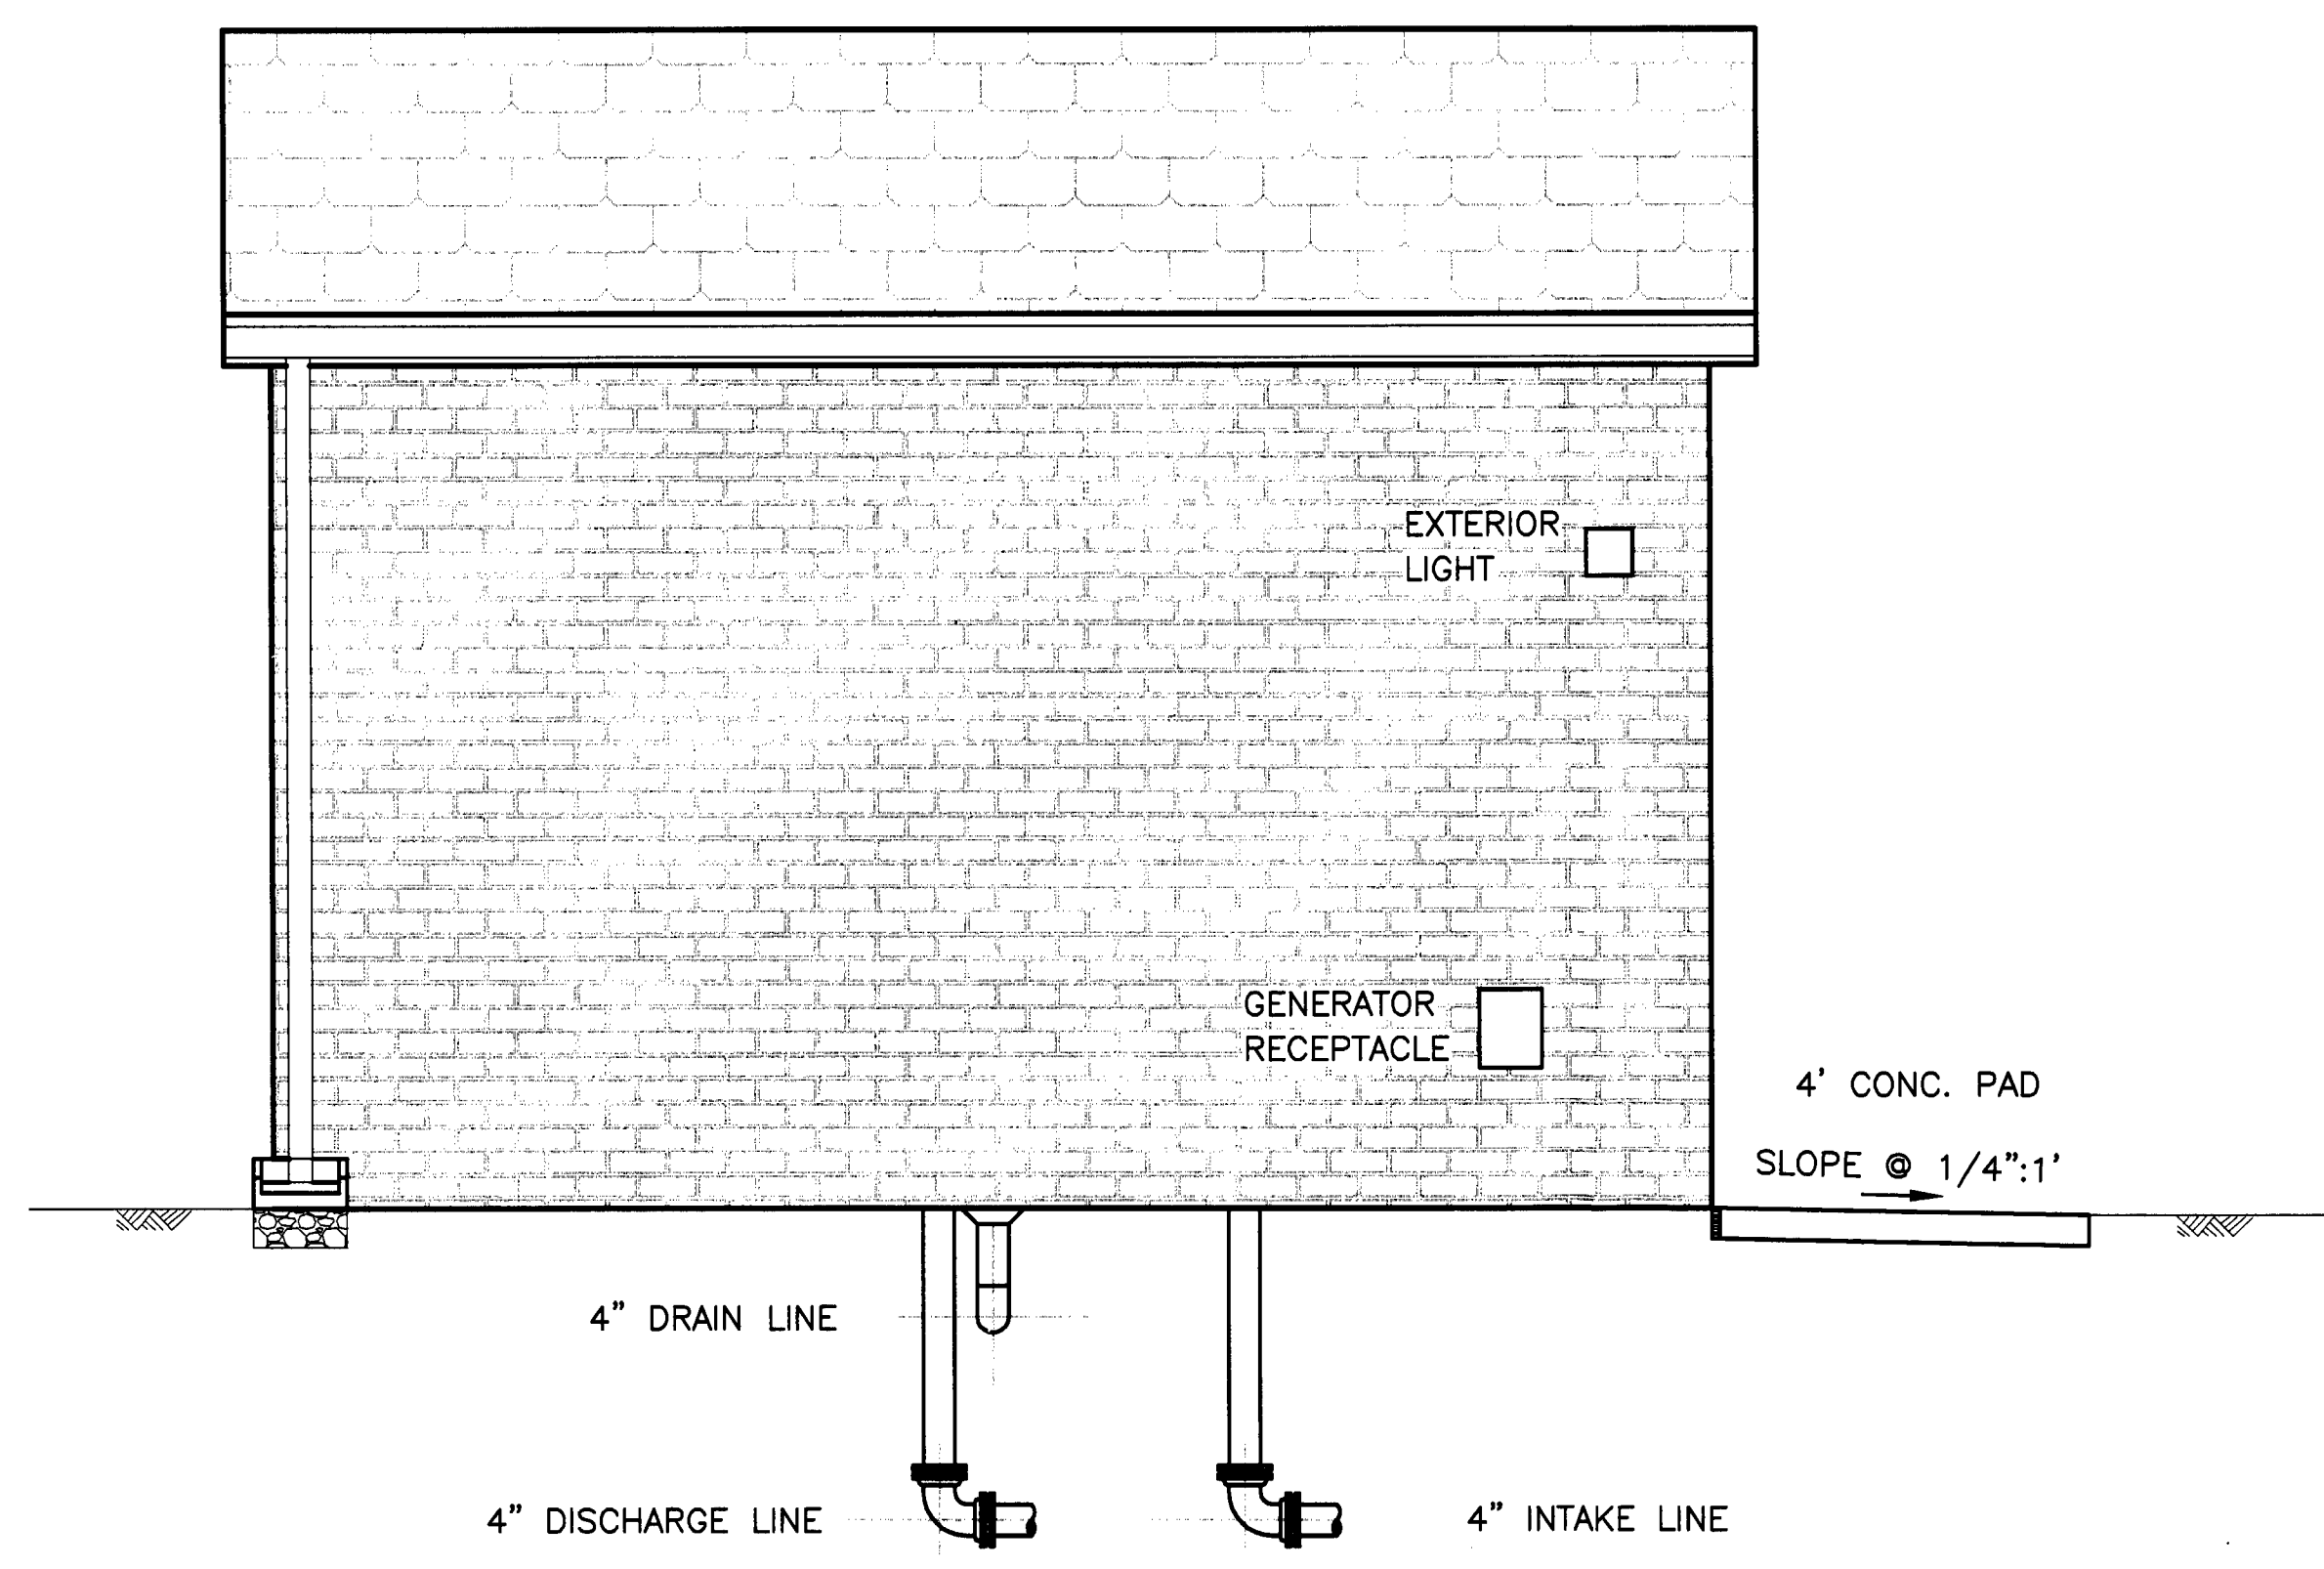

WEST ELEVATION
SCALE: 1/2" = 1'-0"

PAINT FAN, CABINET
AND METER TO MATCH
EXTERIOR DOOR COLOR