


WATERWORKS IMPROVEMENTS

FOR THE TOWN OF VINTON


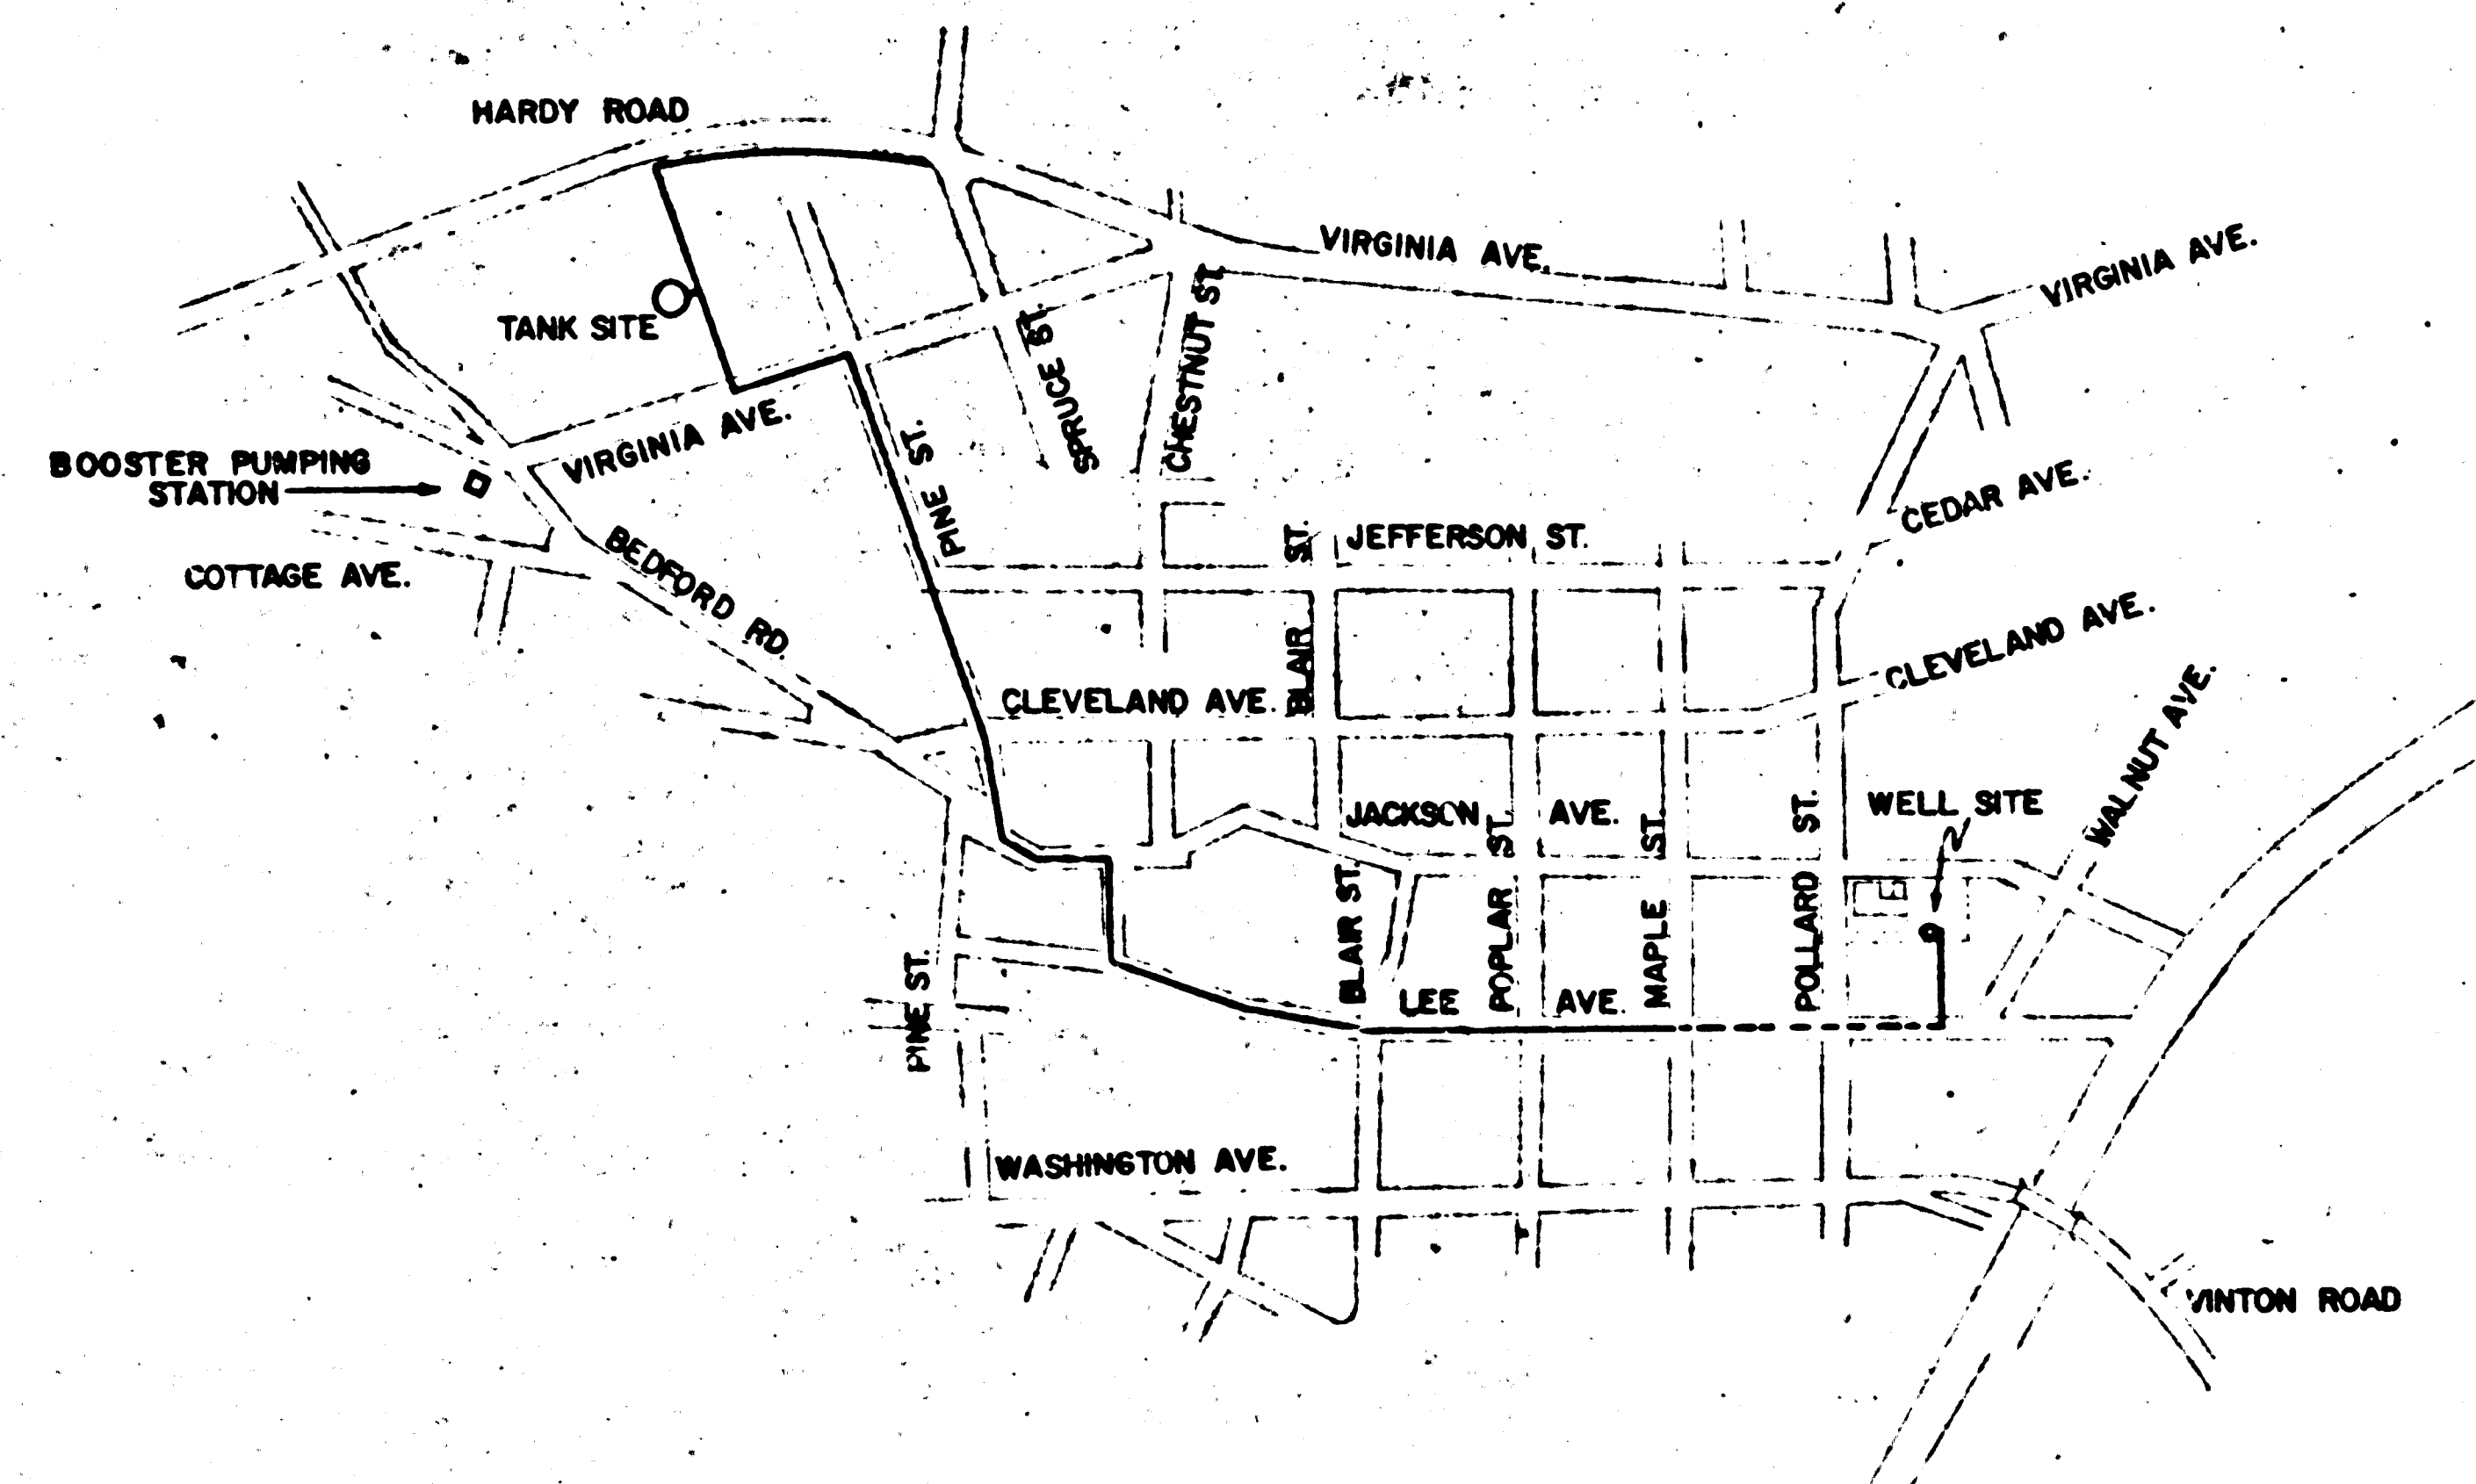


PROJECT LOCATION MAP

VINTON, VIRGINIA


LIST OF DRAWINGS

1. TITLE SHEET
2. SOFTENER BUILDING SITE PLAN-CONTACT TANK VALVE VAULT PLAN & PROFILE
3. SOFTENER BUILDING ARCHITECTURE
4. SOFTENER BUILDING ELECTRICAL AND PIPE PLANS
5. TANK SITE AND VALVE VAULT PLAN AND PROFILE
6. PUMP STATION-SITE PLAN-PIPING & ARCHITECTURE
7. WATER LINE - MAPLE STREET TO JACKSON AVE.
8. WATER LINE - JACKSON AVE. TO PINE STREET & SOFTENER BUILDING TO LEE AVE.
9. WATER LINE - PINE STREET TO TANK SITE
10. WATER LINE - TANK SITE TO SPRUCE STREET & DRAIN LINE - TANK SITE TO HARDY RD.

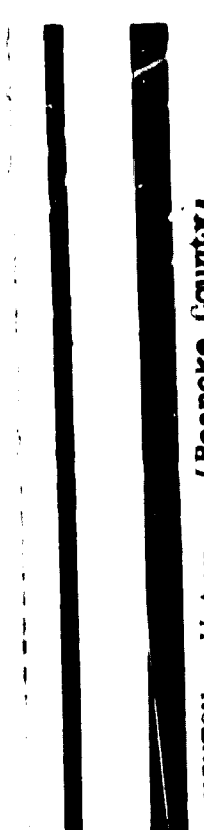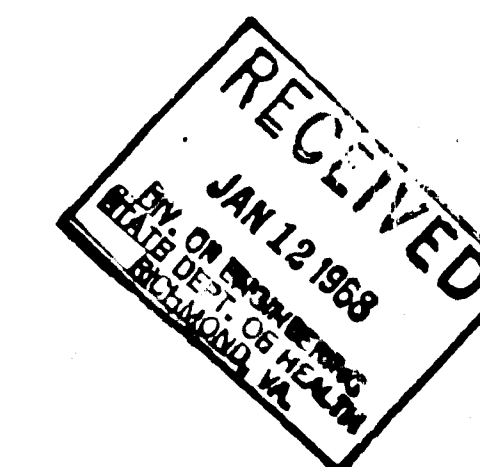

COVER SHEET

WATERWORKS IMPROVEMENTS
FOR THE
TOWN OF VINTON
VINTON, VIRGINIA

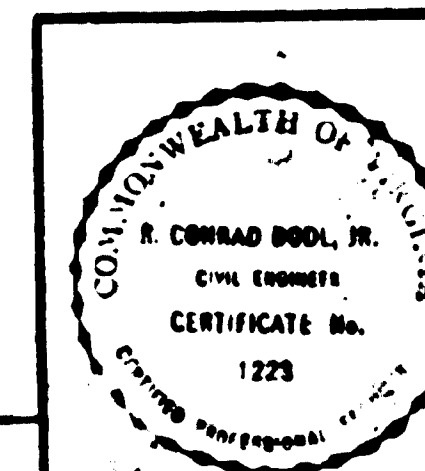

WILEY & WILSON
CONSULTING ENGINEERS
LYNCHBURG, VA. RICHMOND, VA.

DESIGNED BY: J.L.T. SCALE: AS SHOWN
DRAWN BY: J.L.T. DATE: NOV. 1967
APPROVED BY: R.C.D. CORRAL NO.: 70210
PERMANENT FILE NO. DWG. 1 OF 10

110-78-3932.1-1