



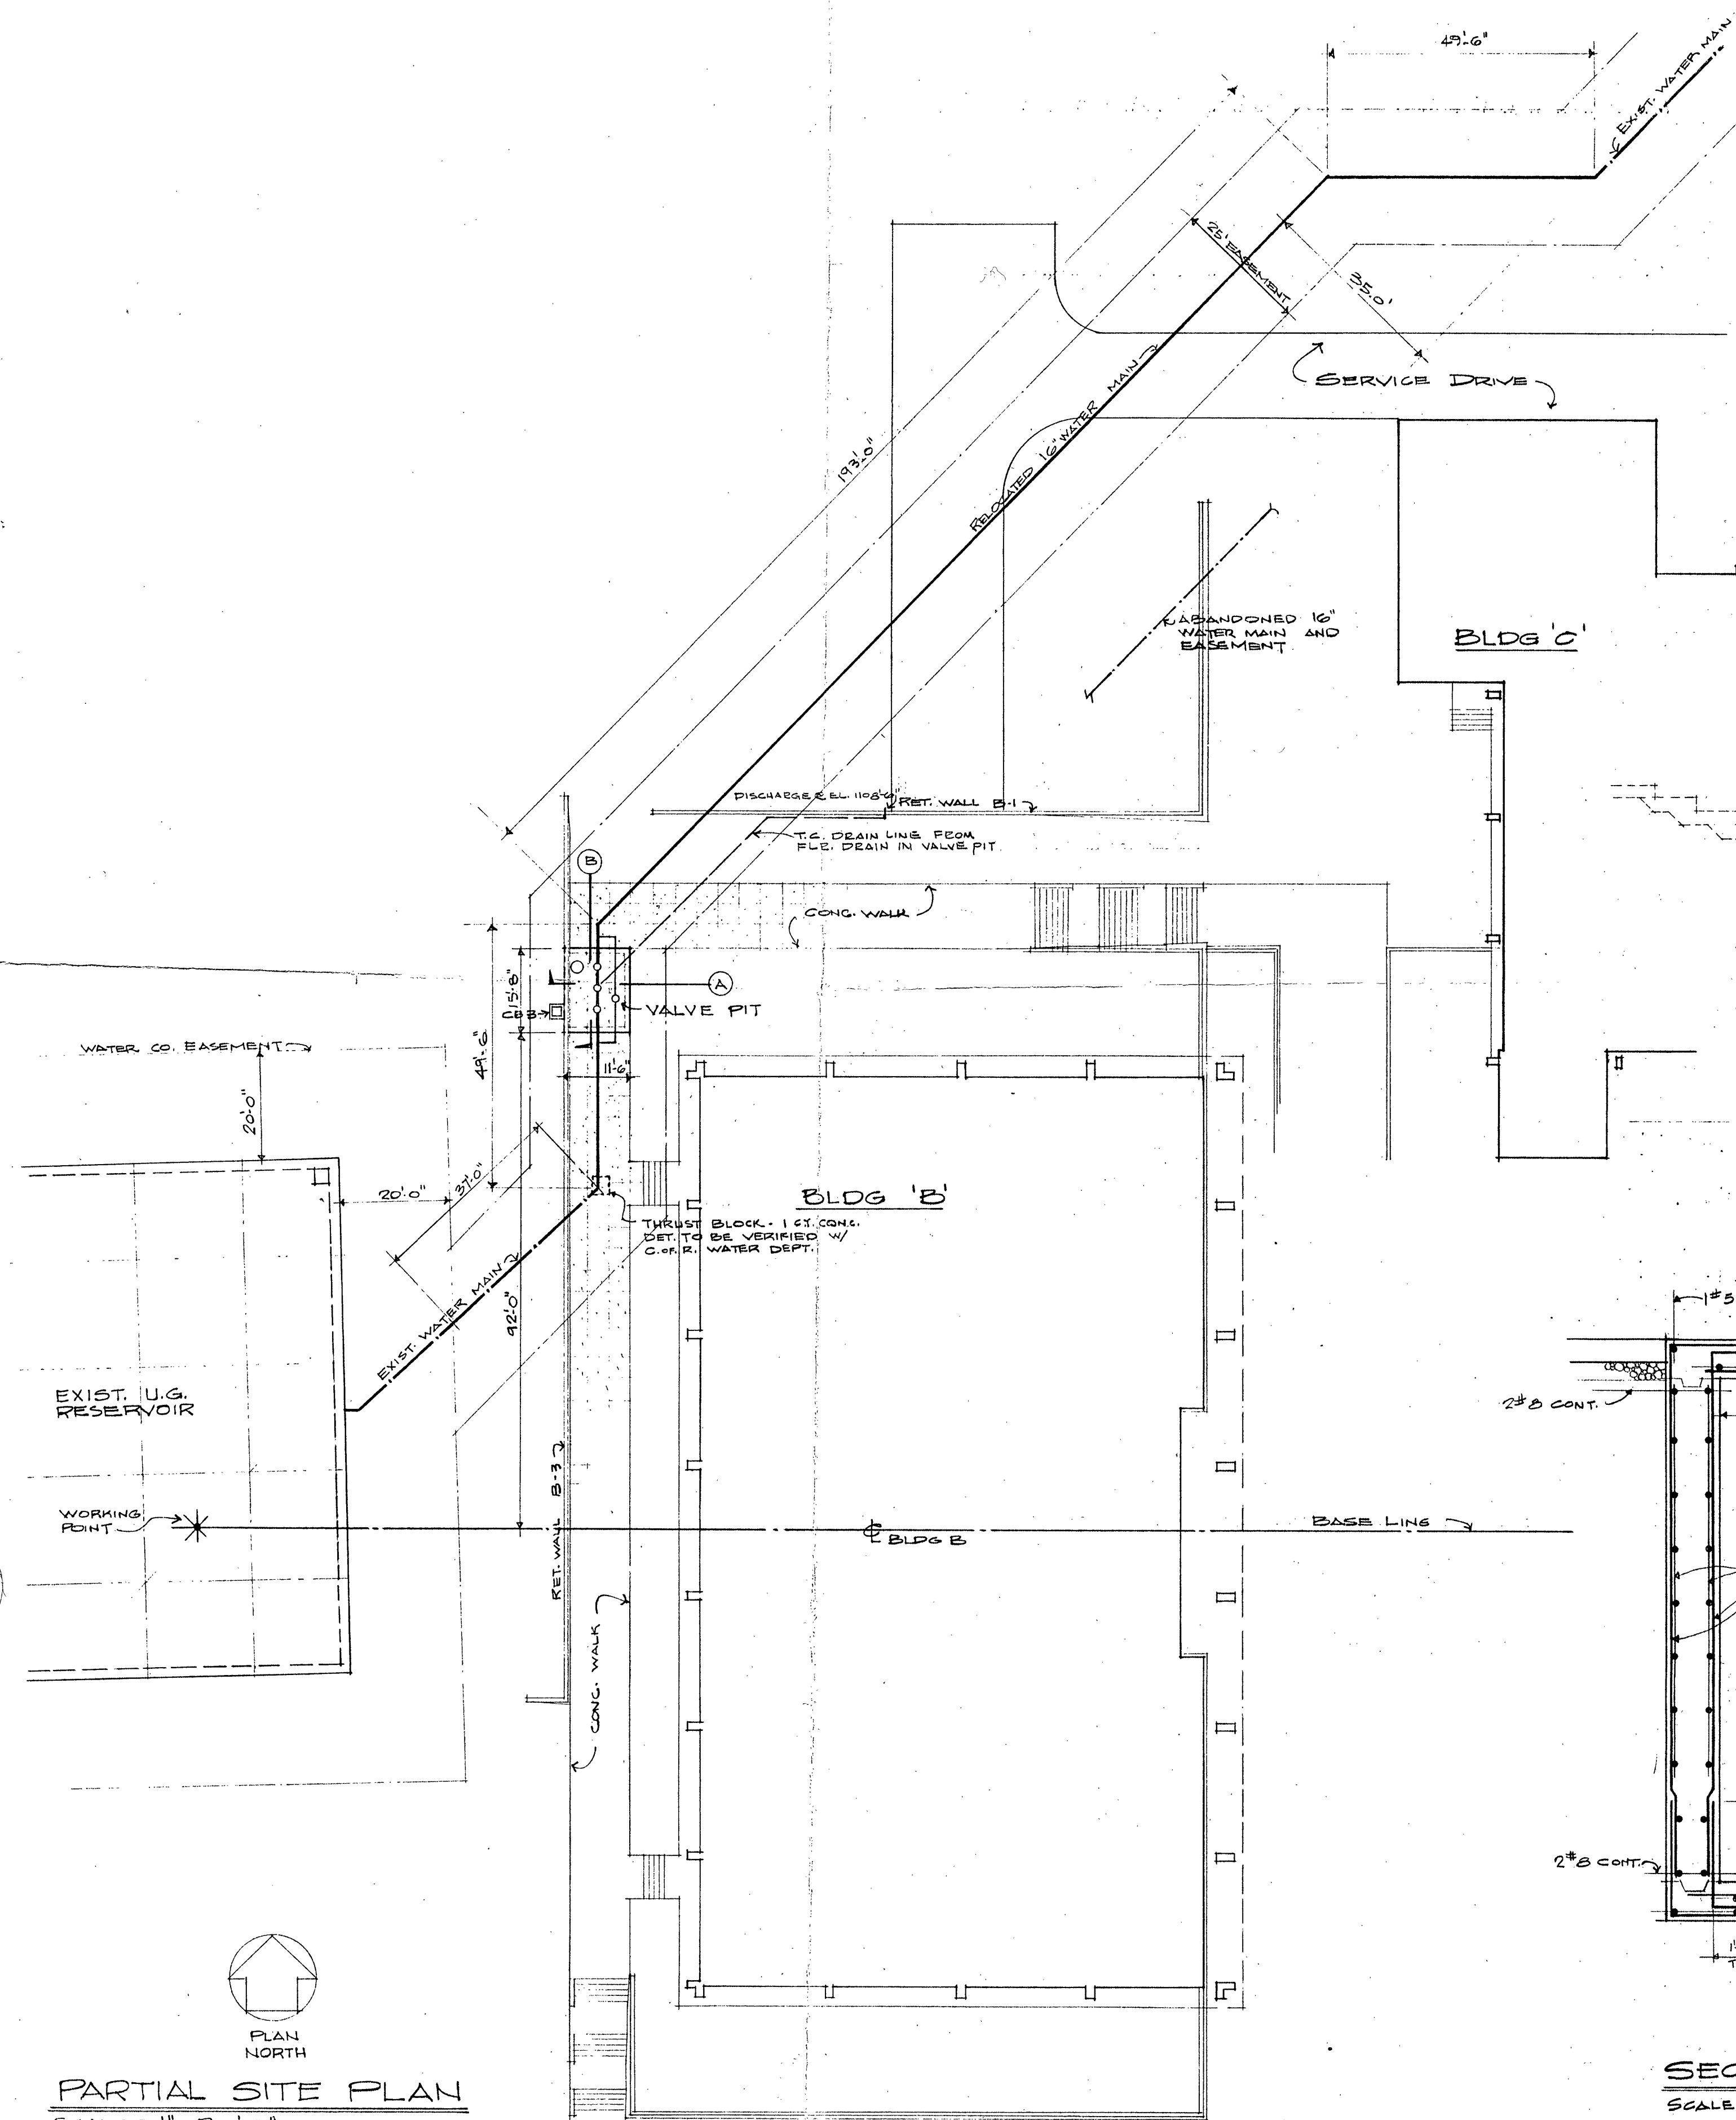


PLAN NORTH
PARTIAL SITE PLAN
SCALE: 1" = 20'-0"


- NOTES:
1. INSTALL NEW PIPING & VALVE PIT
 2. MAKE CONNECTIONS OF NEW PIPING TO EXISTING PIPING
 3. REMOVE EXISTING PIPING & PIT
 4. DO NO WORK WHICH WILL UNNECESSARILY DISRUPT THE WATER SYSTEM AND TAKE ALL PRECAUTIONS TO PROTECT THE EXISTING RESERVOIR & PIPING SYSTEM.

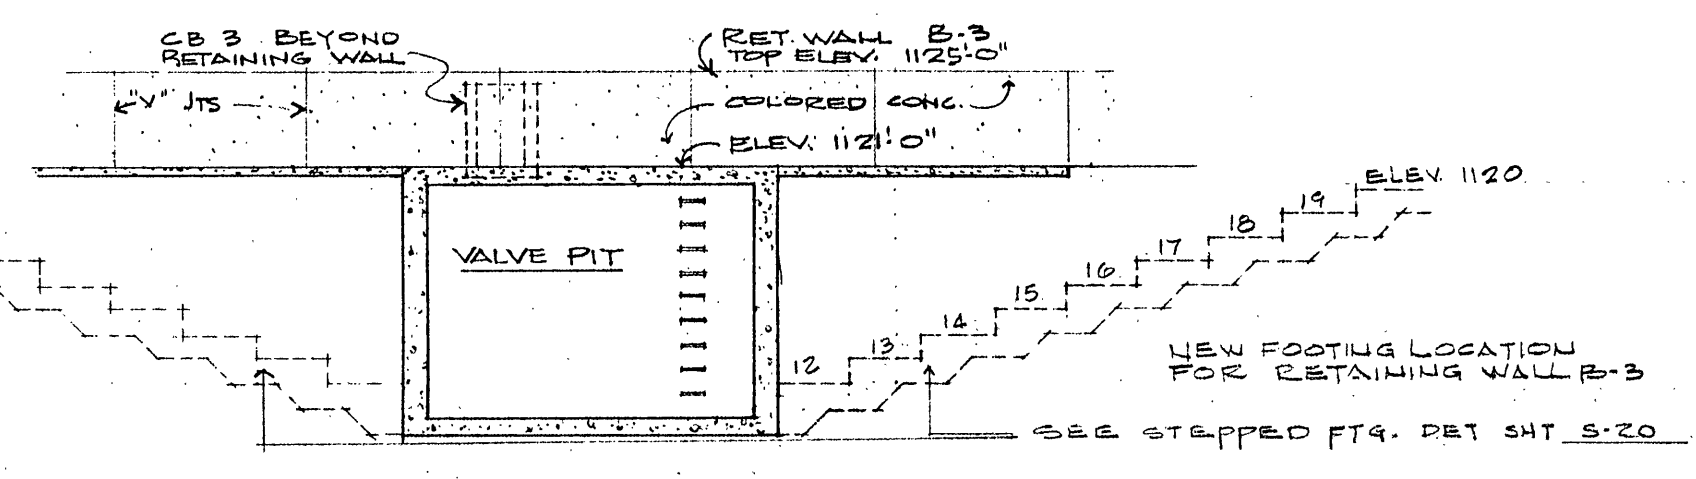


SECTION THRU VALVE PIT SHOWING RETAINING WALL B-3
SCALE: 1/2" = 1'-0"

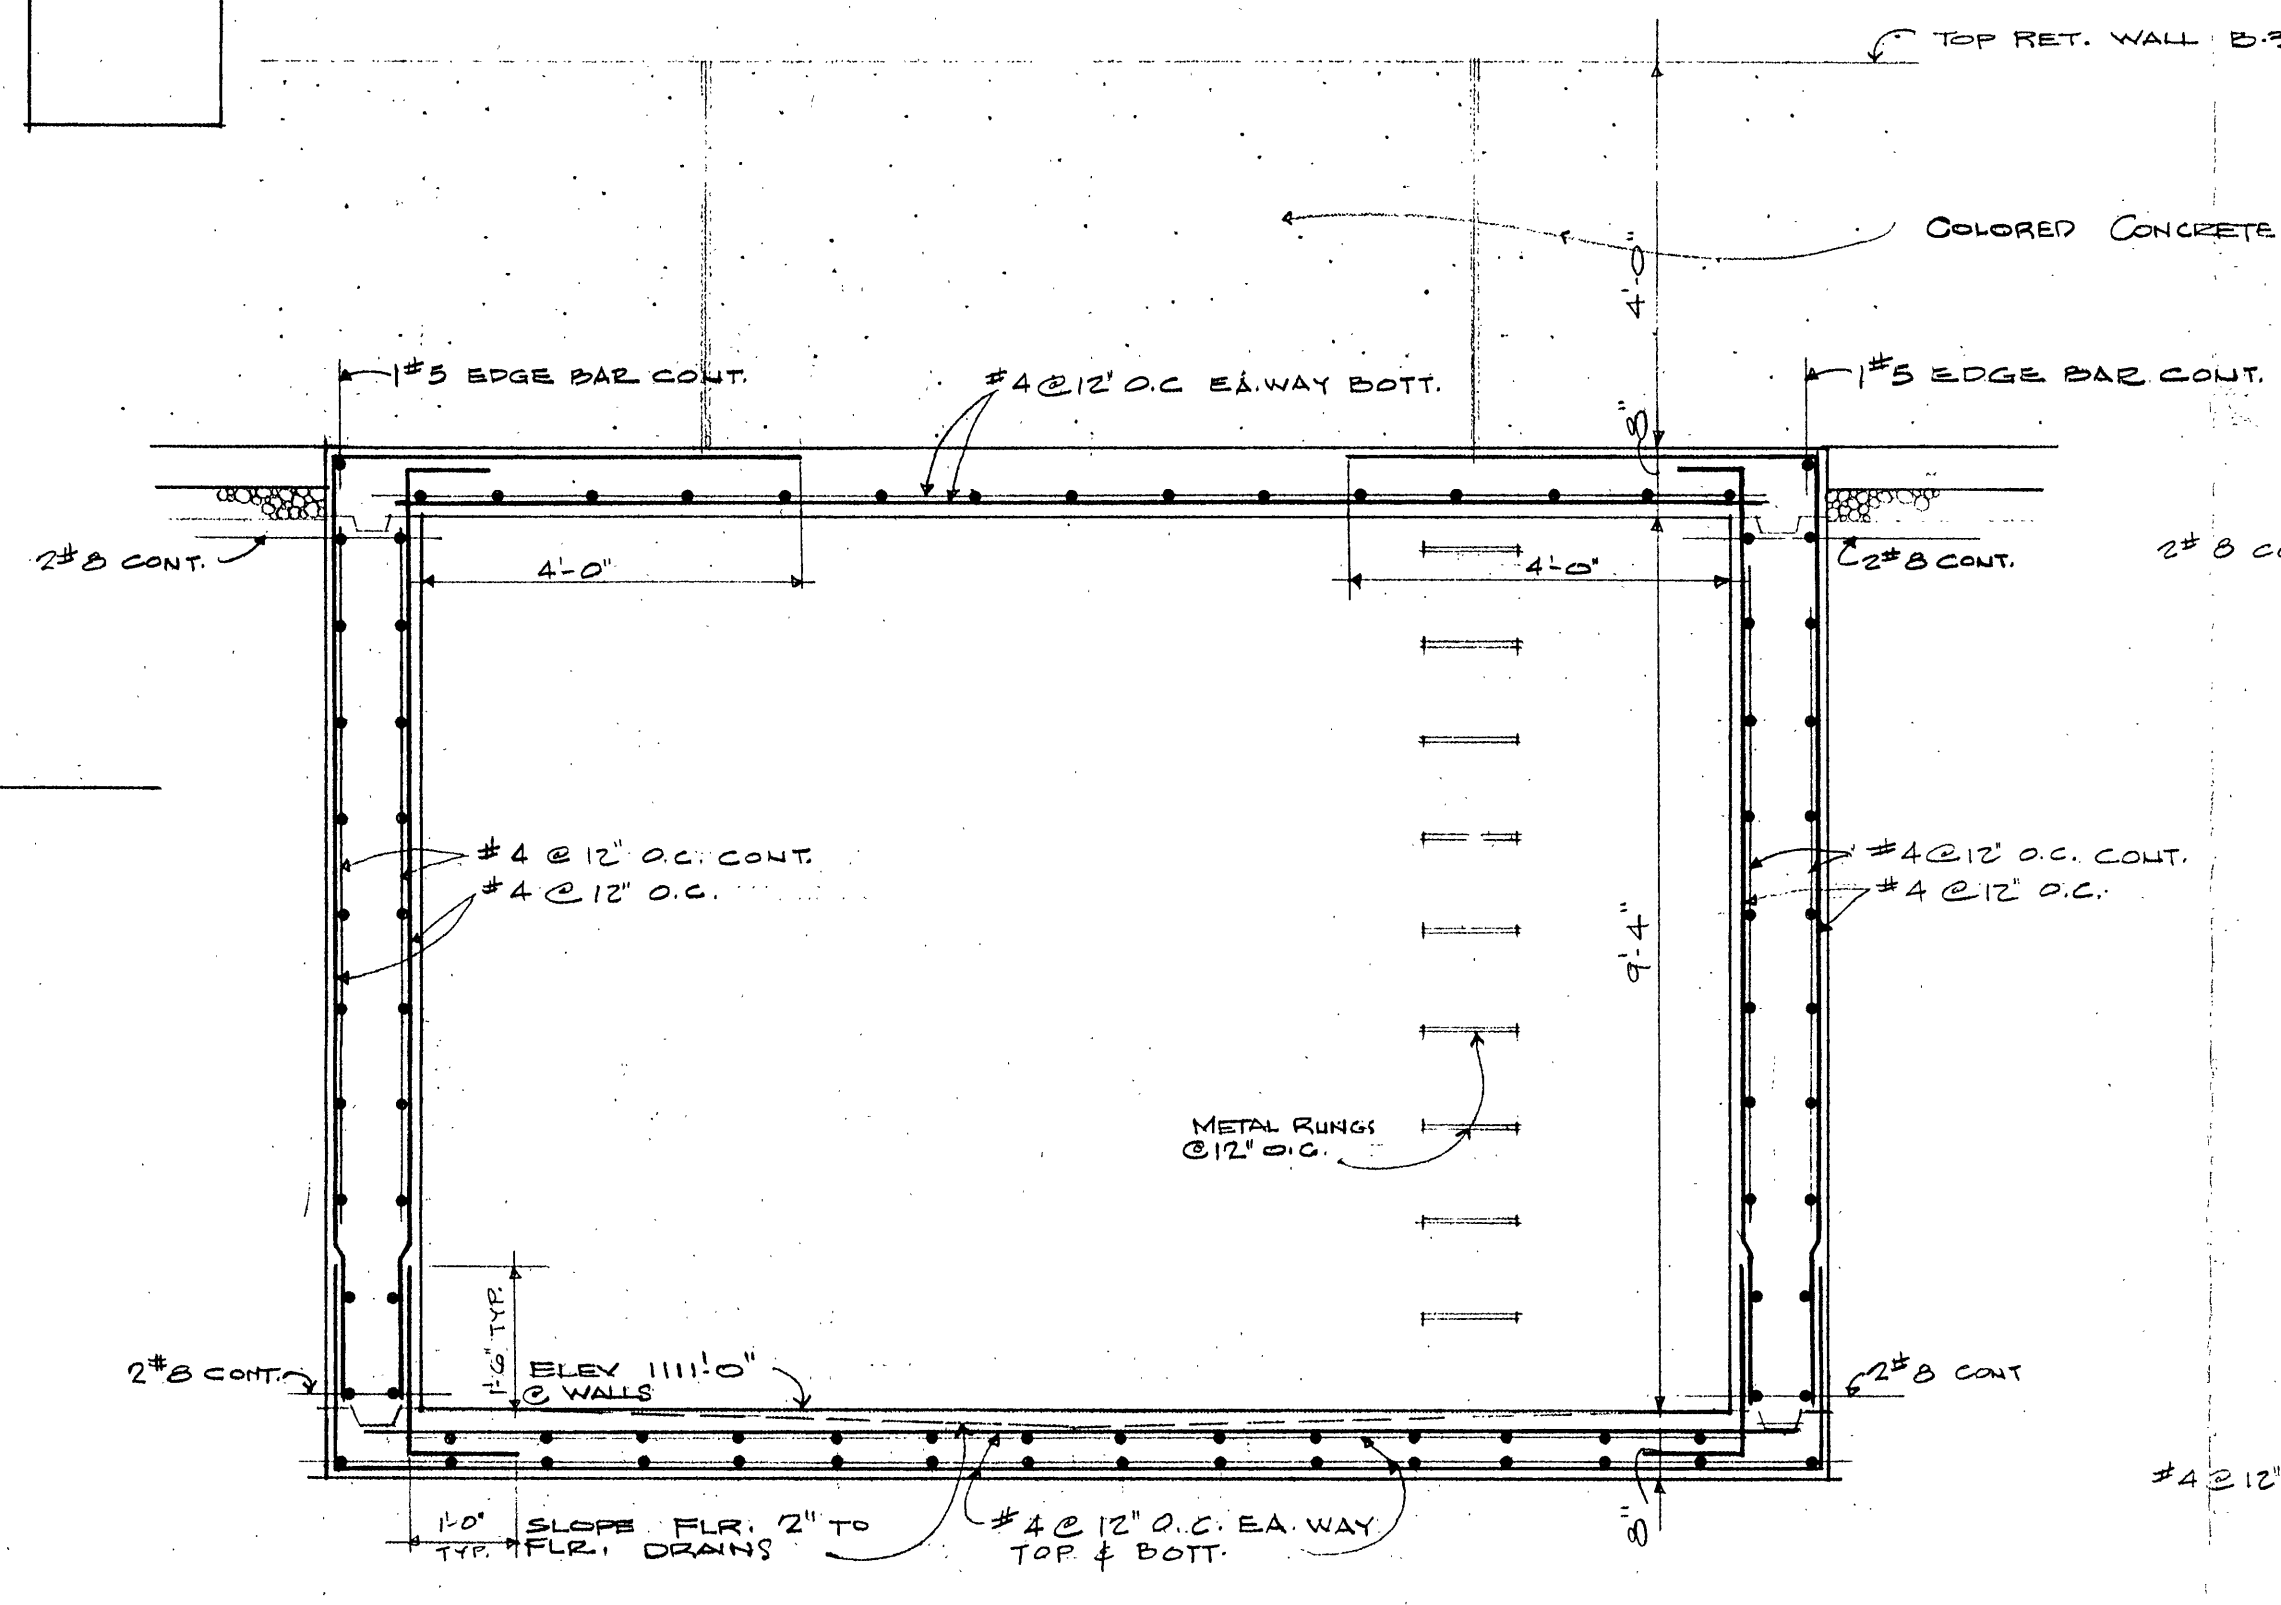

SECTION B
SCALE: 1/2" = 1'-0"

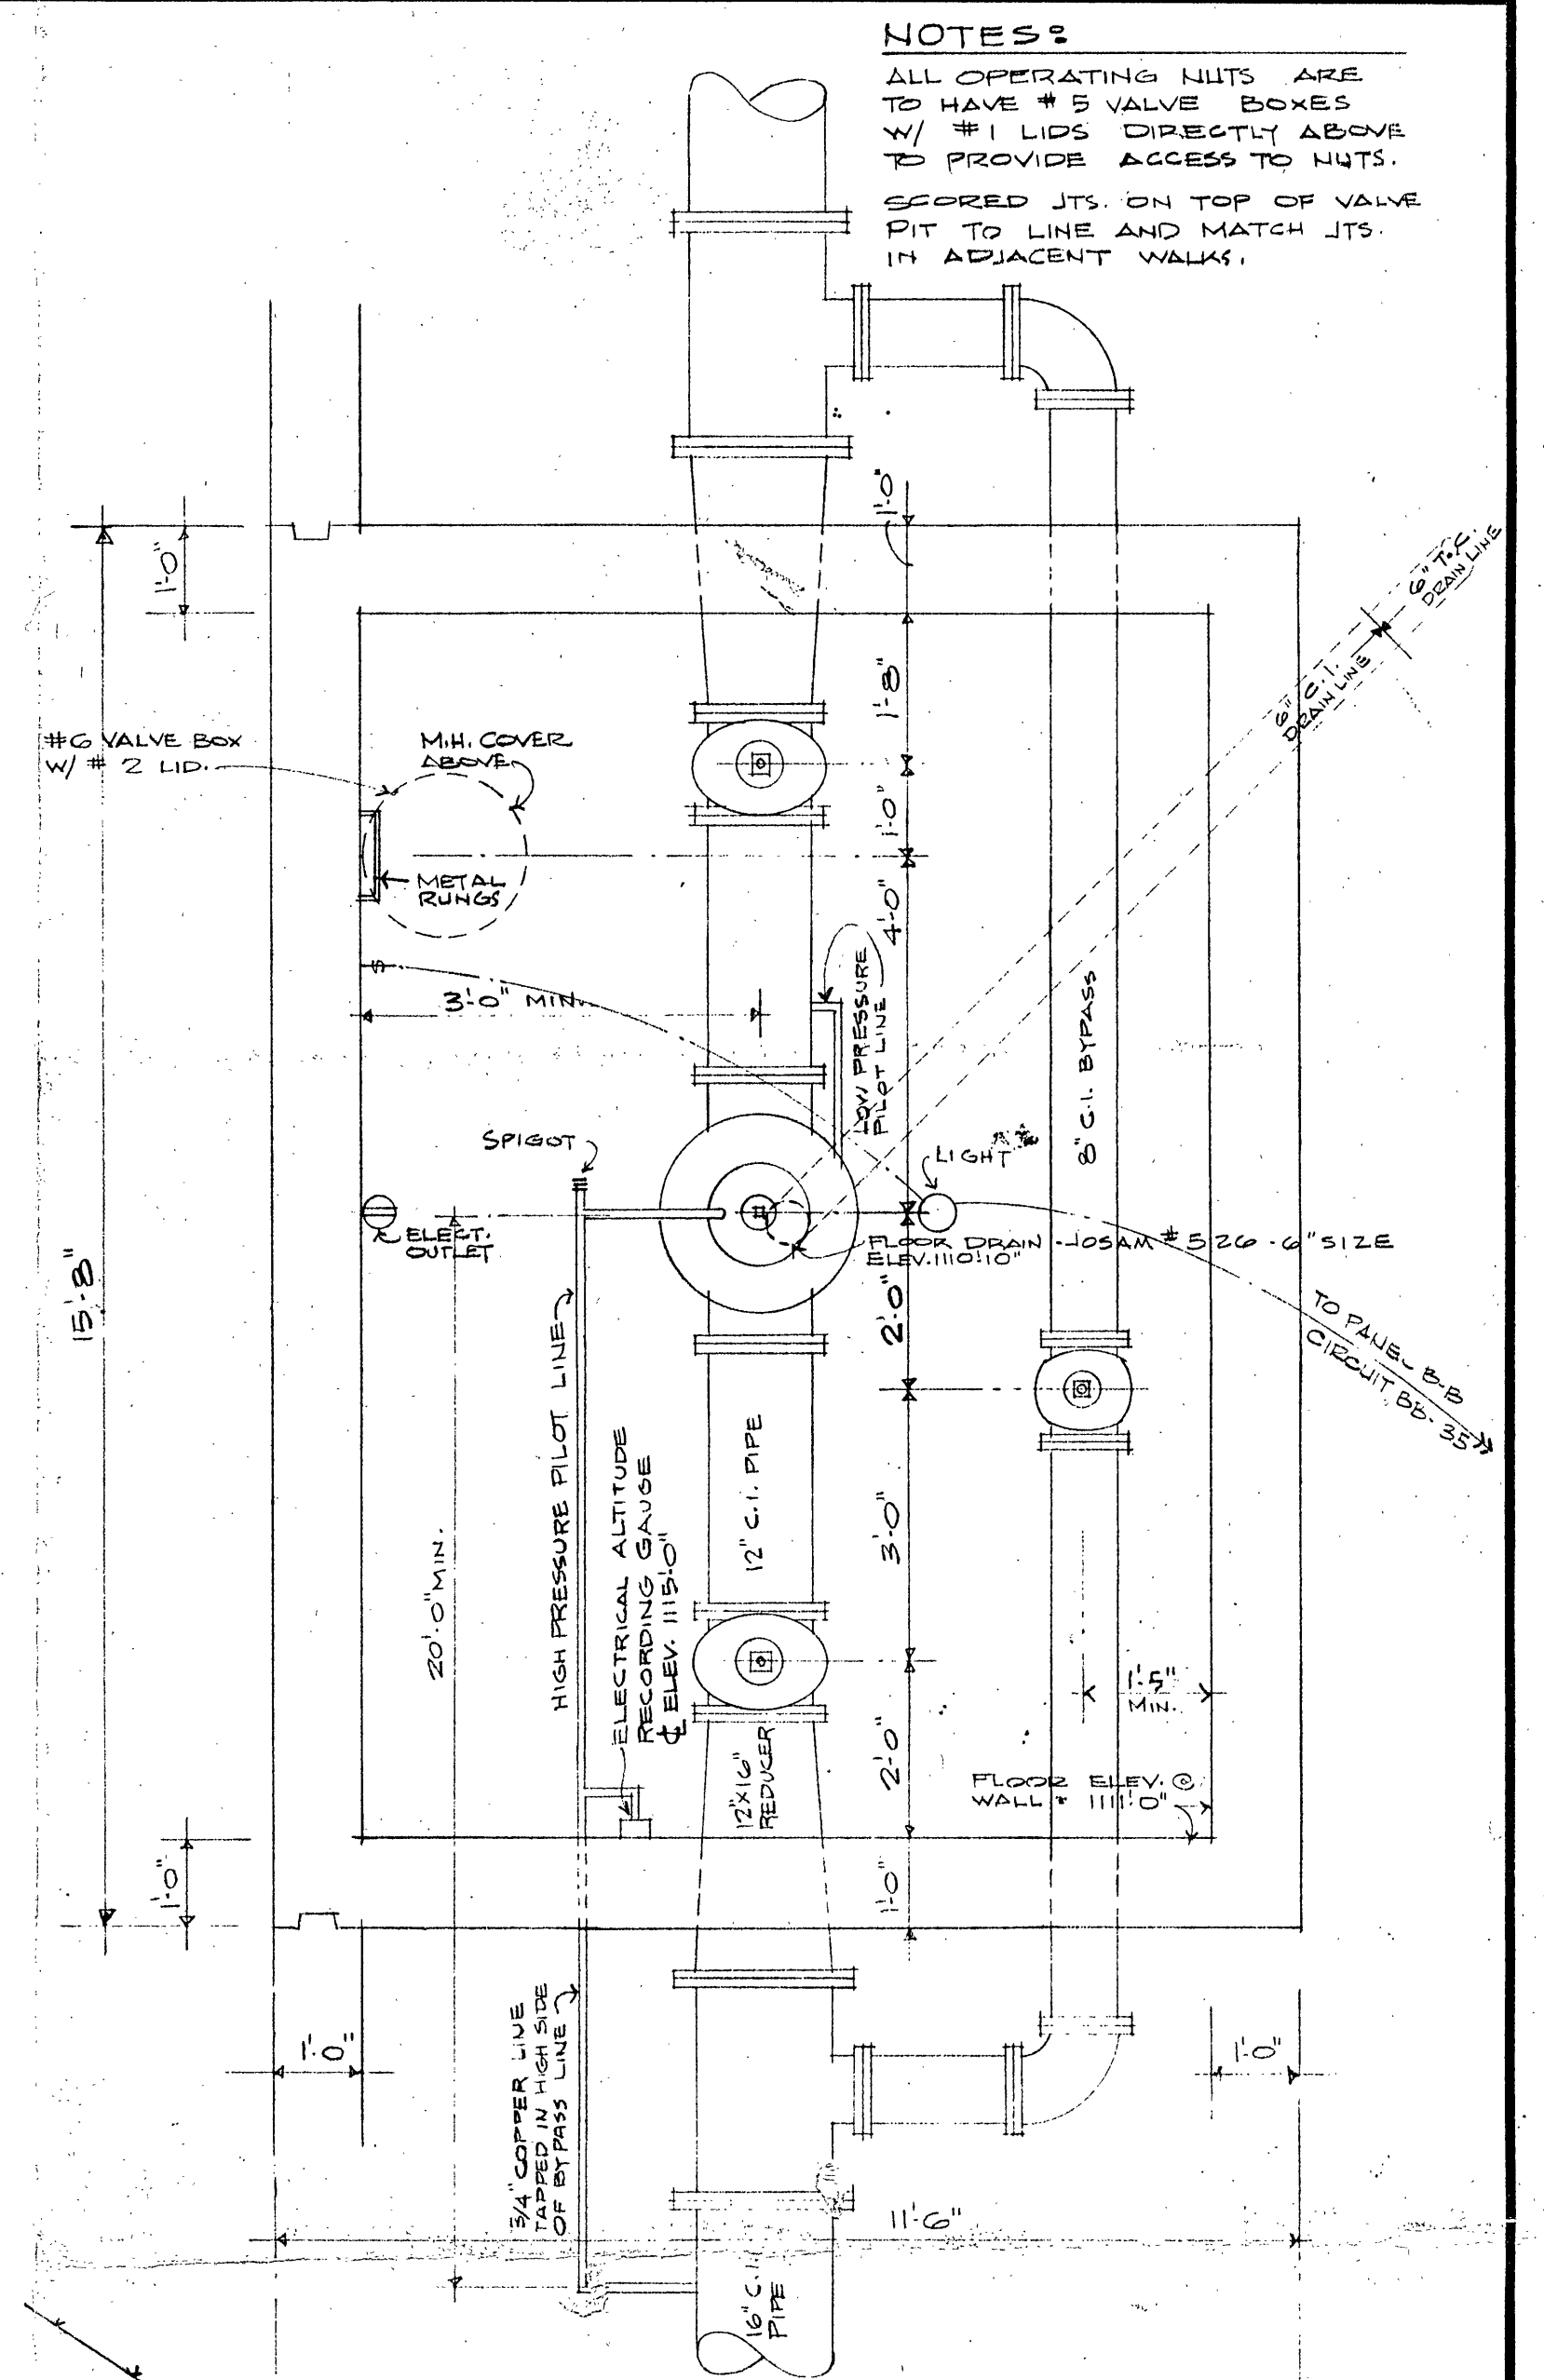

PLAN OF VALVE PIT
SCALE: 1/2" = 1'-0"

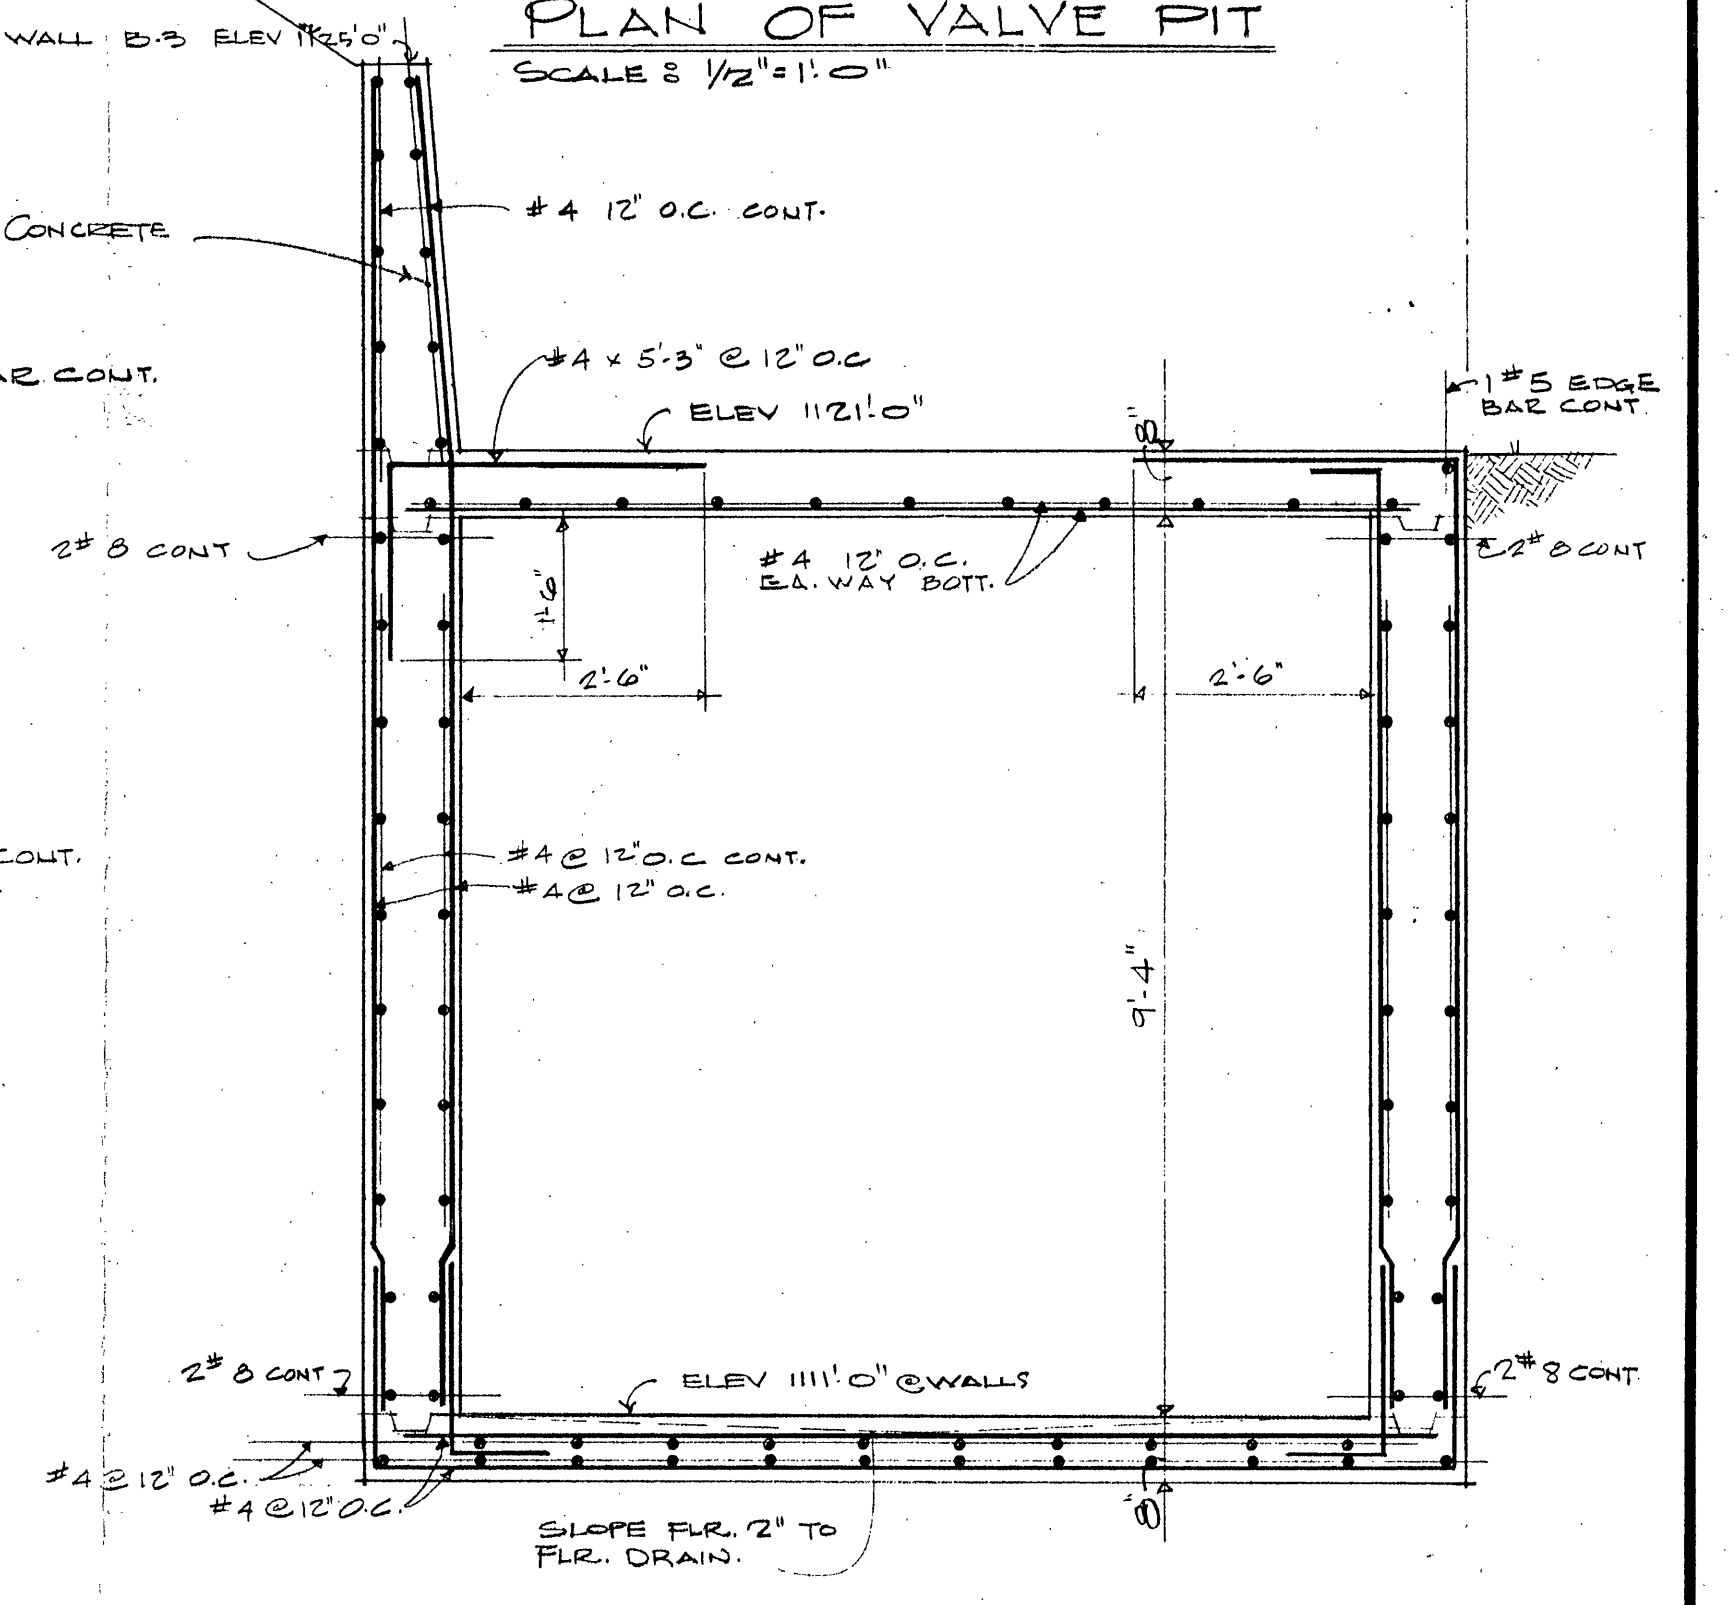

SECTION A
SCALE: 1/2" = 1'-0"

REVISIONS

VIRGINIA WESTERN COMMUNITY COLLEGE
COLONIAL AVENUE
ROANOKE, VIRGINIA
SMITHEY & BOYNTON-RANDOLPH FRANTZ & JOHN CHAPPELEAR
ASSOCIATED ARCHITECTS
ROANOKE, VIRGINIA

DETAILS & LOCATION OF
VALVE PIT
CITY FARM RESERVOIR
360
F3-D5-S6

SHEET NO.
D-1
DATE
DEC. 21, 1967