


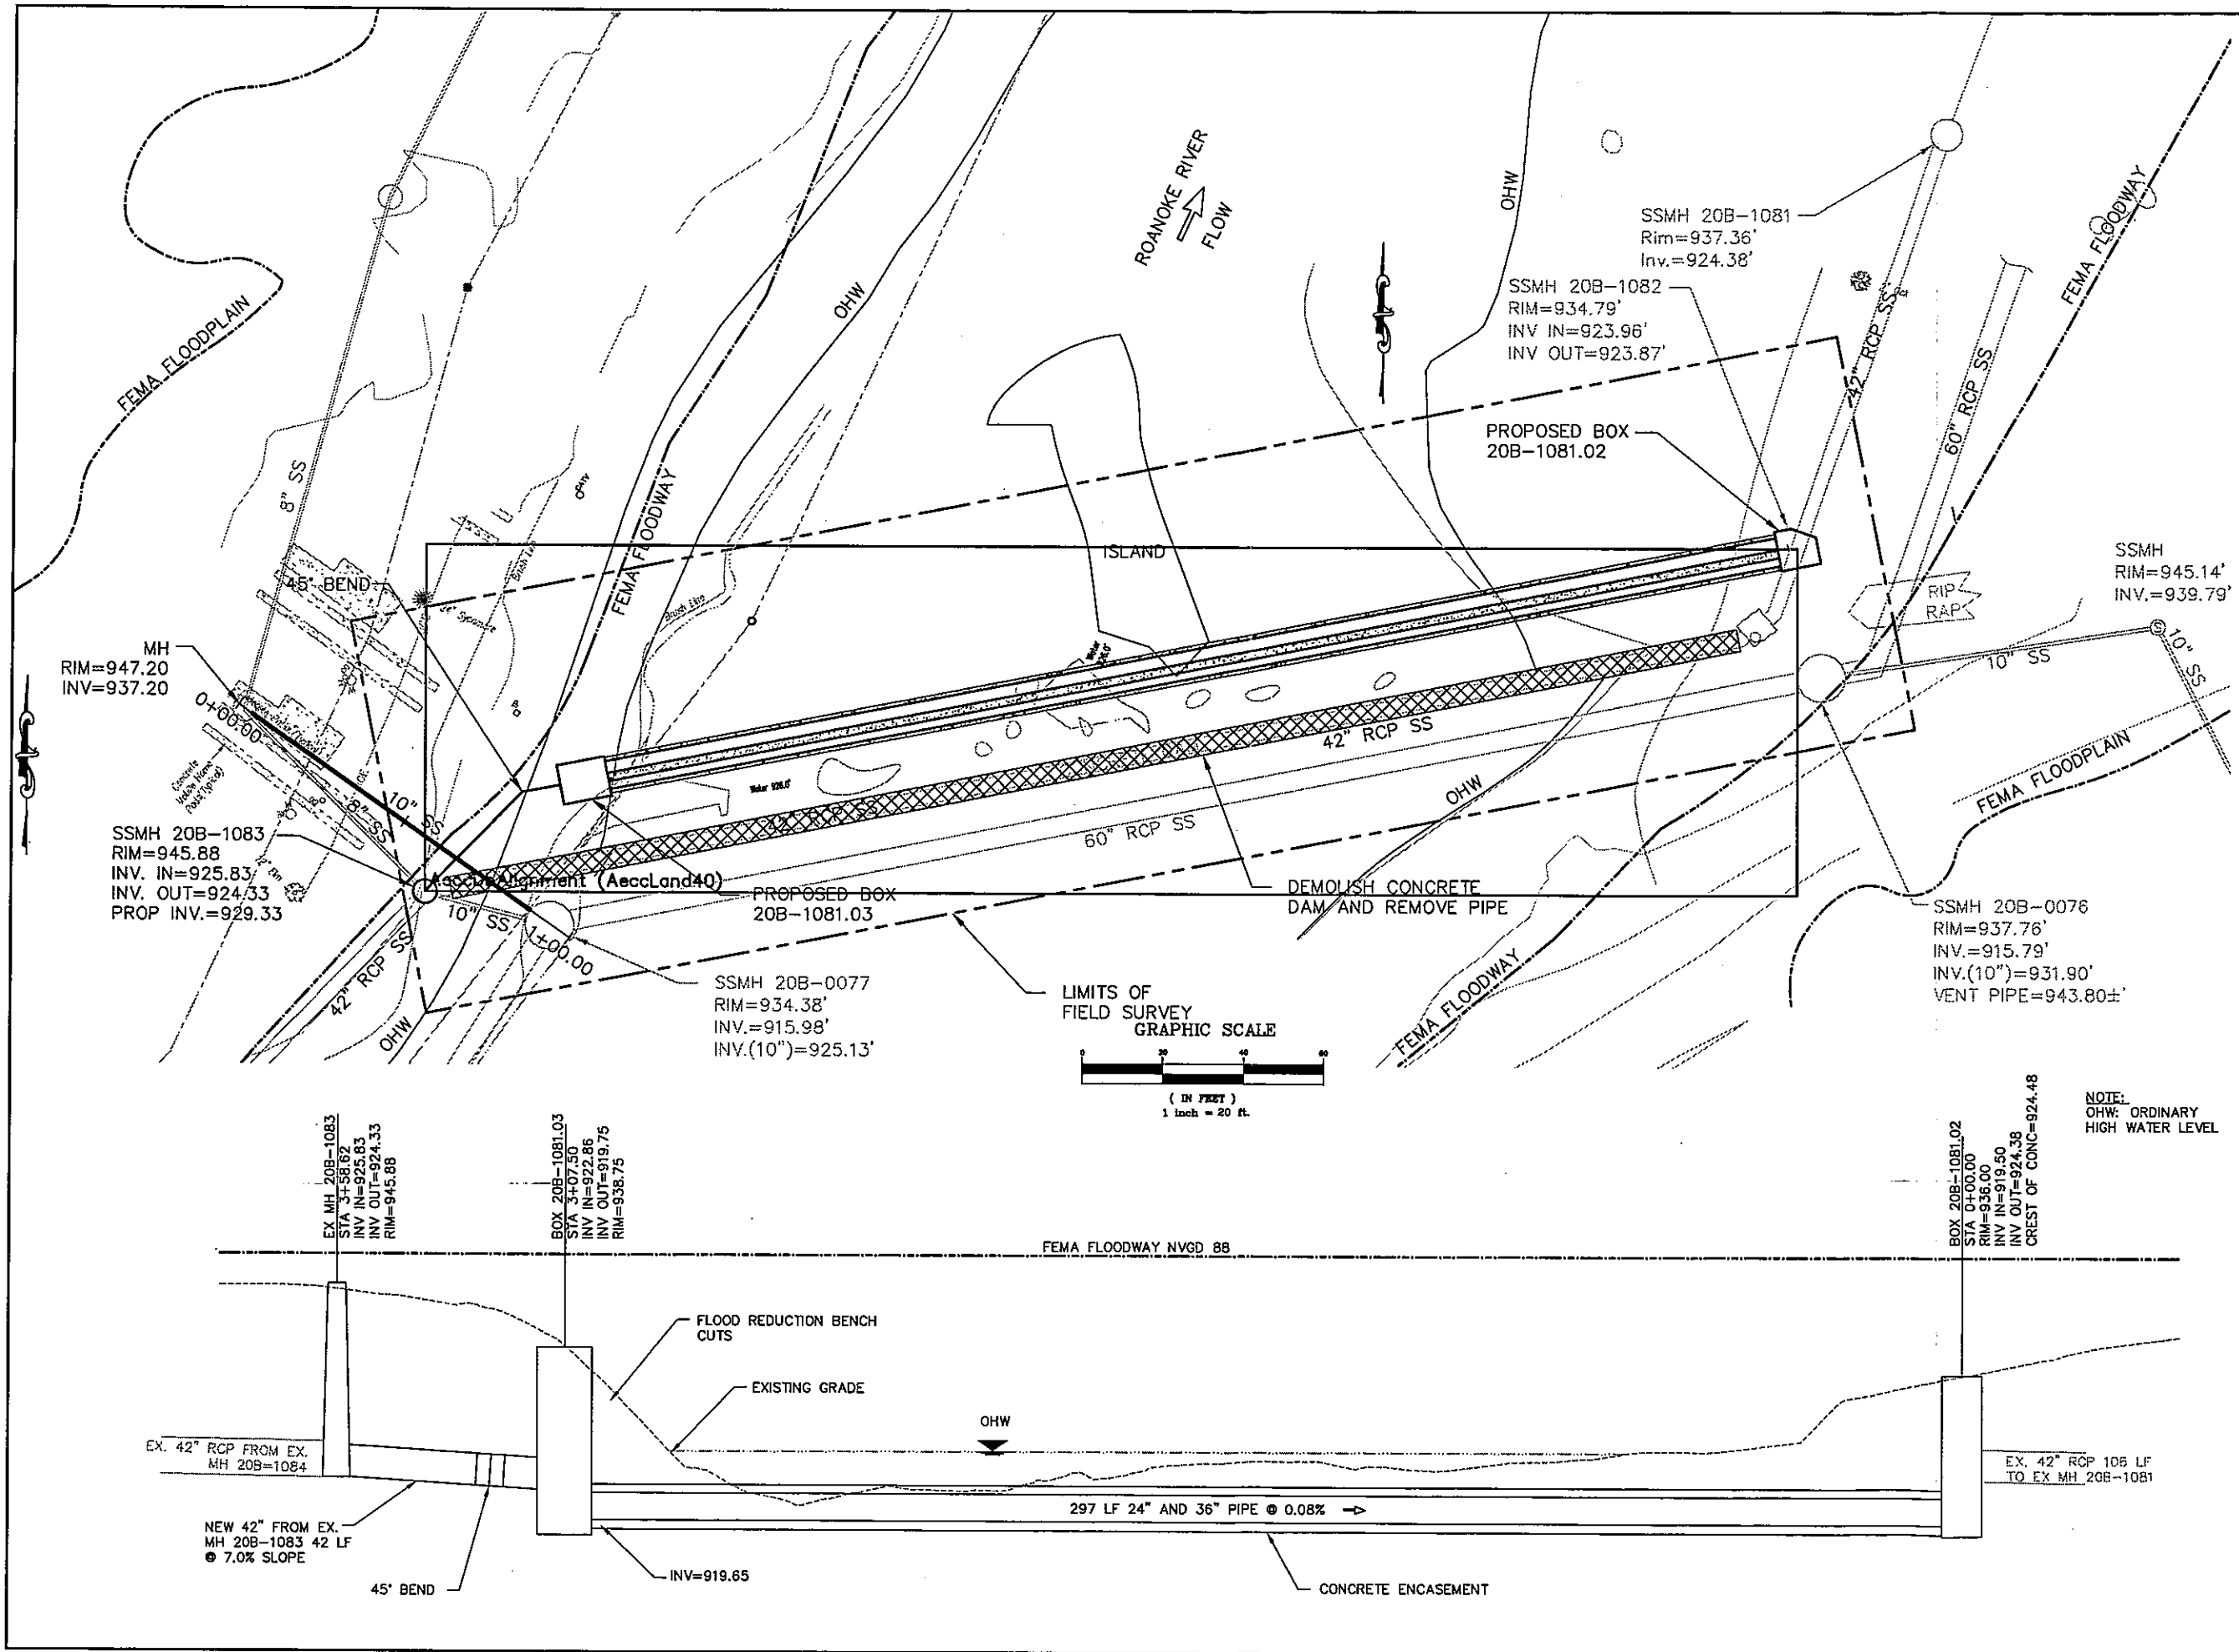

OLVER INCORPORATED
Consulting Engineers & Applied Scientists

1116 SOUTH MAIN STREET
BLACKSBURG, VIRGINIA 24060
(540) 552-5548

WESTERN VIRGINIA WATER AUTHORITY

INTERCEPTOR IMPROVEMENTS AT WASENA PARK

PROPOSED RIVER CROSSING
PLAN AND PROFILE

Rev.	Description	Date	By
B	BID ISSUE/VDI REVIEW	8/27/08	DBH
A	CLIENT REVIEW	8/20/08	DBH

Designed: ETA
 Drawn: MJM
 Checked: DBH
 Date: AUG 08
 Scale: AS SHOWN
 Job No. 12306.08
 Archived File Name:

C101