

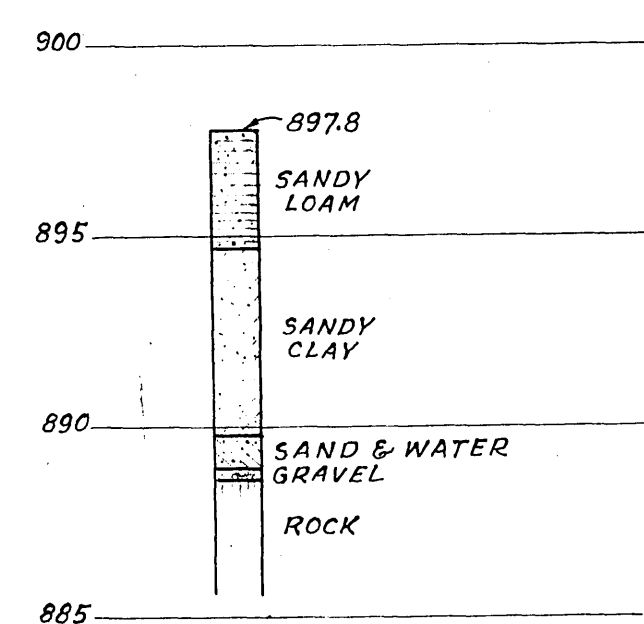


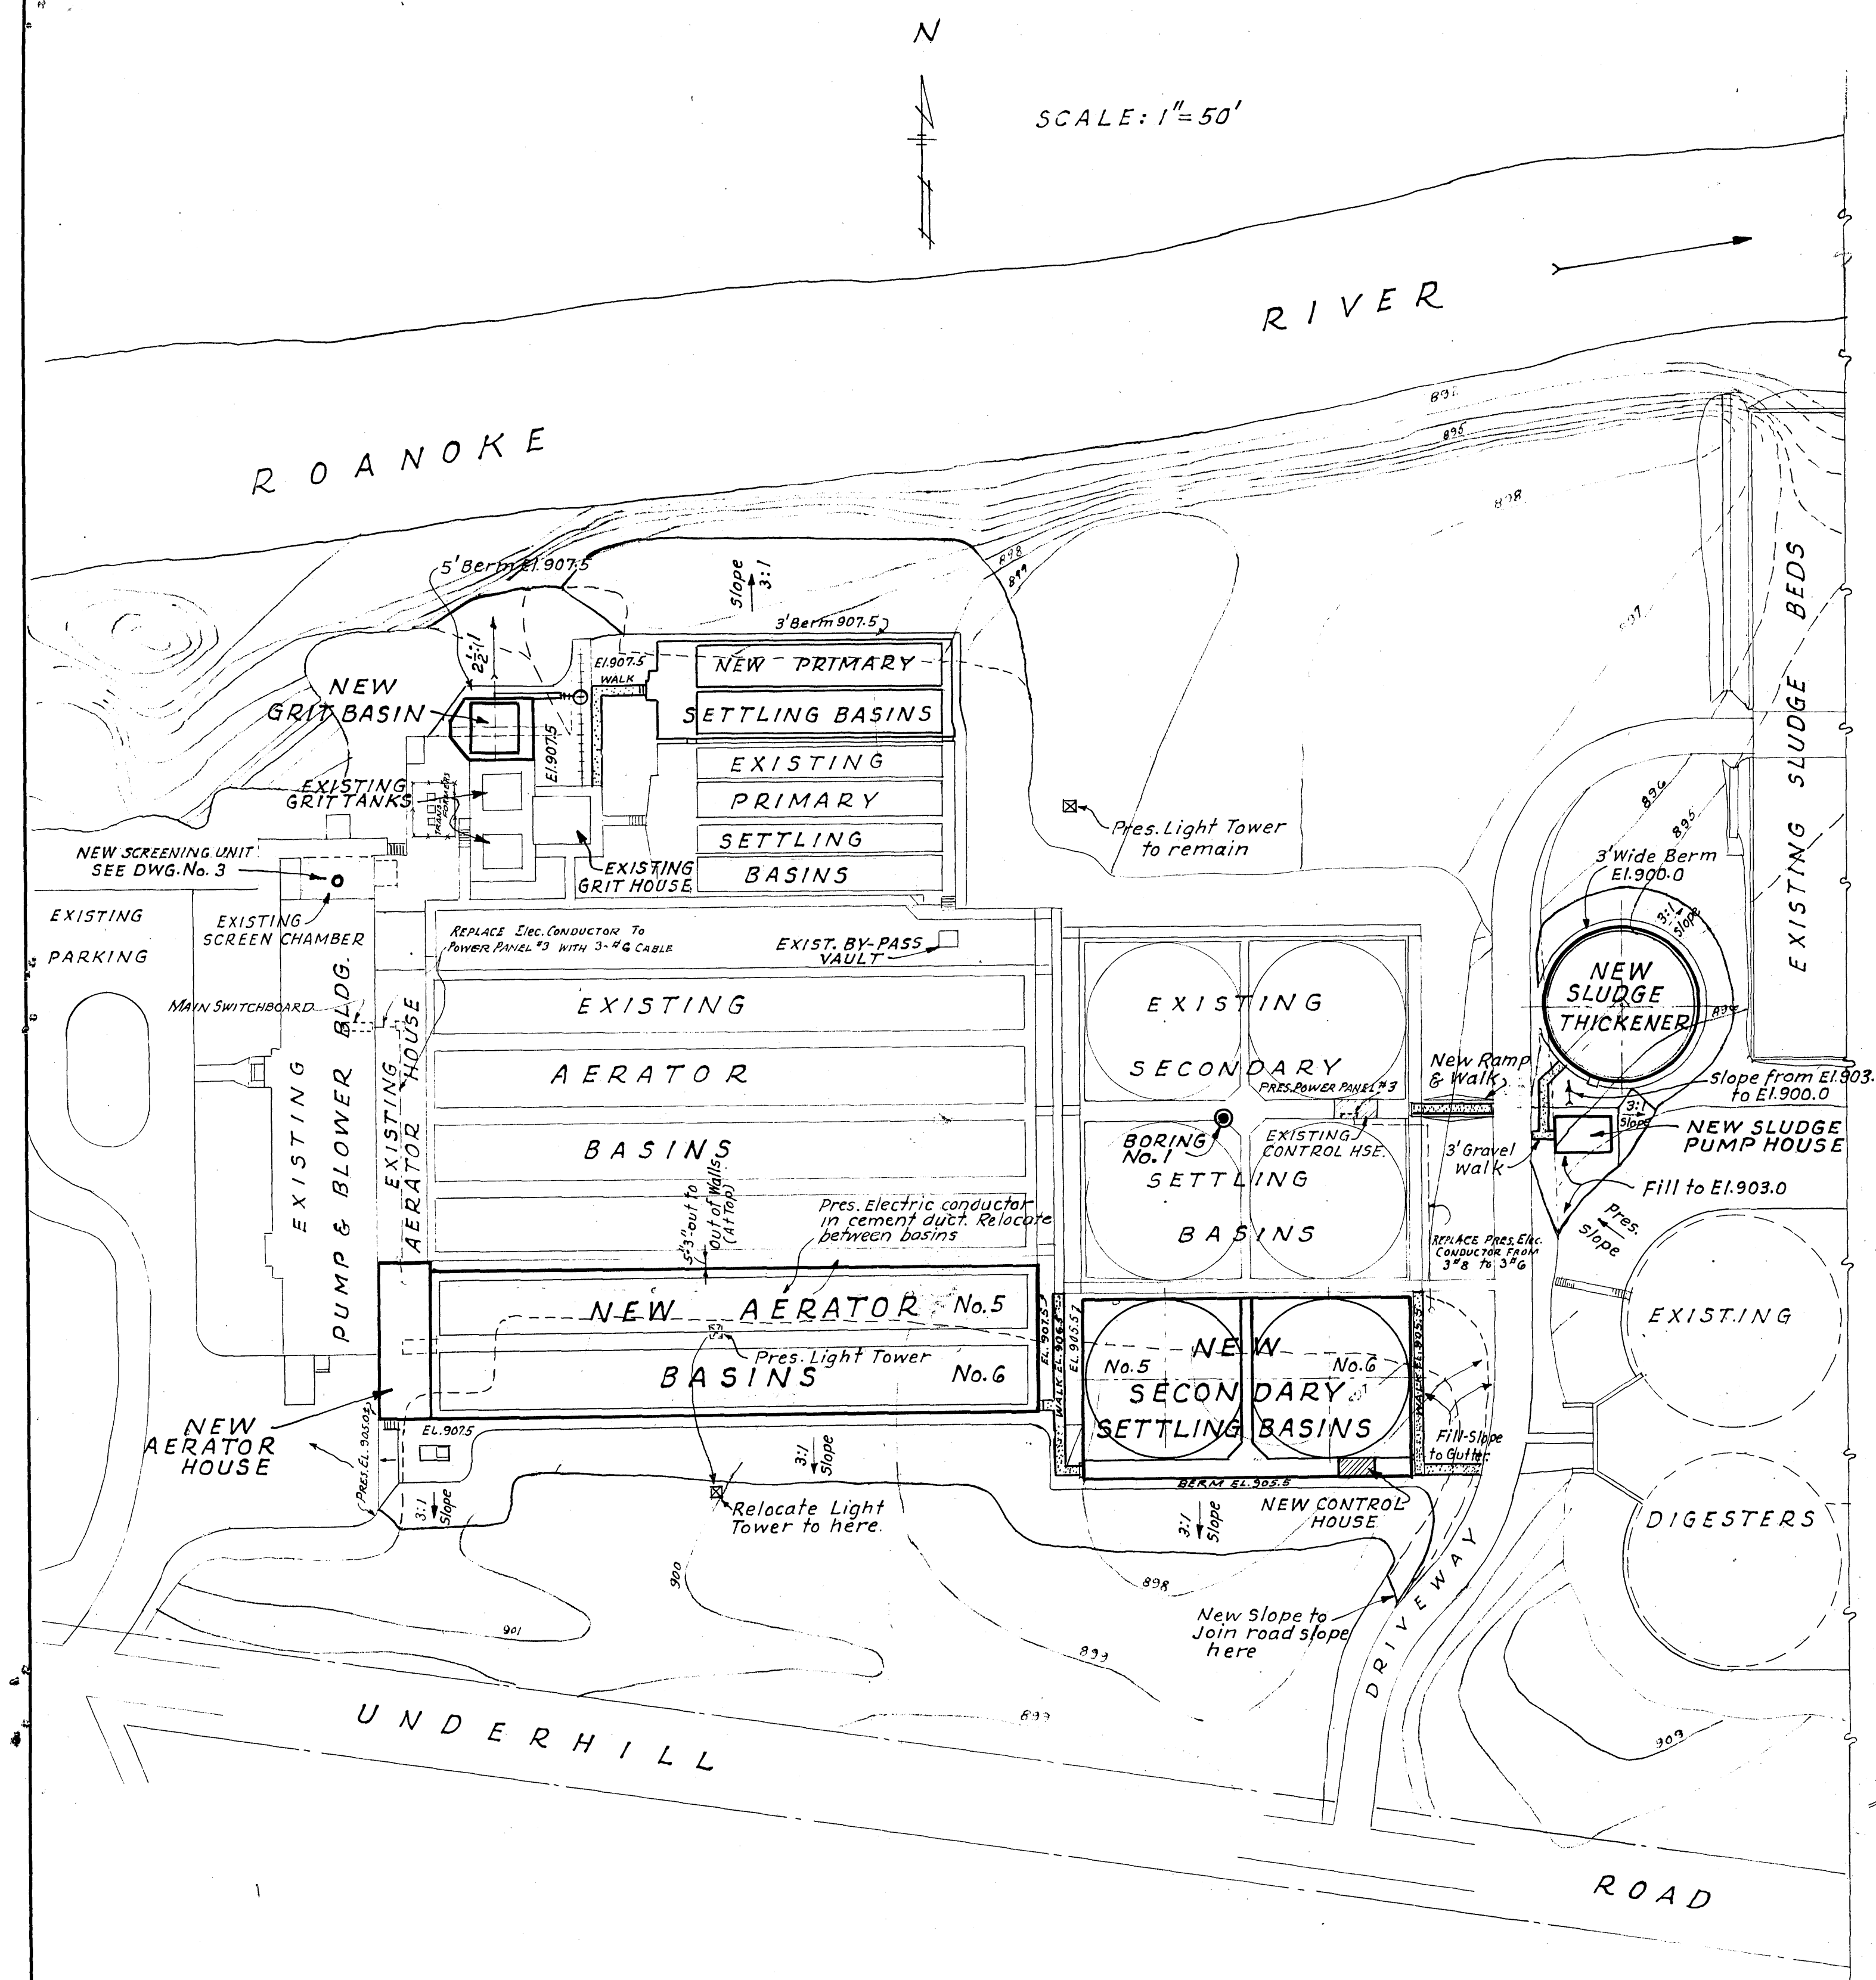

GENERAL PLAN
SCALE: 1" = 50'

LIST OF DRAWINGS

1. GENERAL PLANS
2. GRIT BASIN DETAILS
3. " " & SCREENING UNIT DETAILS
4. PRIMARY SETTLING BASIN DETAILS
5. " " " "
6. AERATOR BASIN PLANS
7. " " CONCRETE DETAILS
8. " " PIPING
9. " " CONTROL HOUSE-DETAILS
10. " " " " -SUPERSTRUCTURE
11. SLUDGE THICKENER- DETAILS
12. " " - CONTROL HOUSE
13. SECONDARY SETTLING BASINS -DETAILS & PIPING
14. " " " " " "
15. " " " " " "
16. MISCELLANEOUS DETAILS

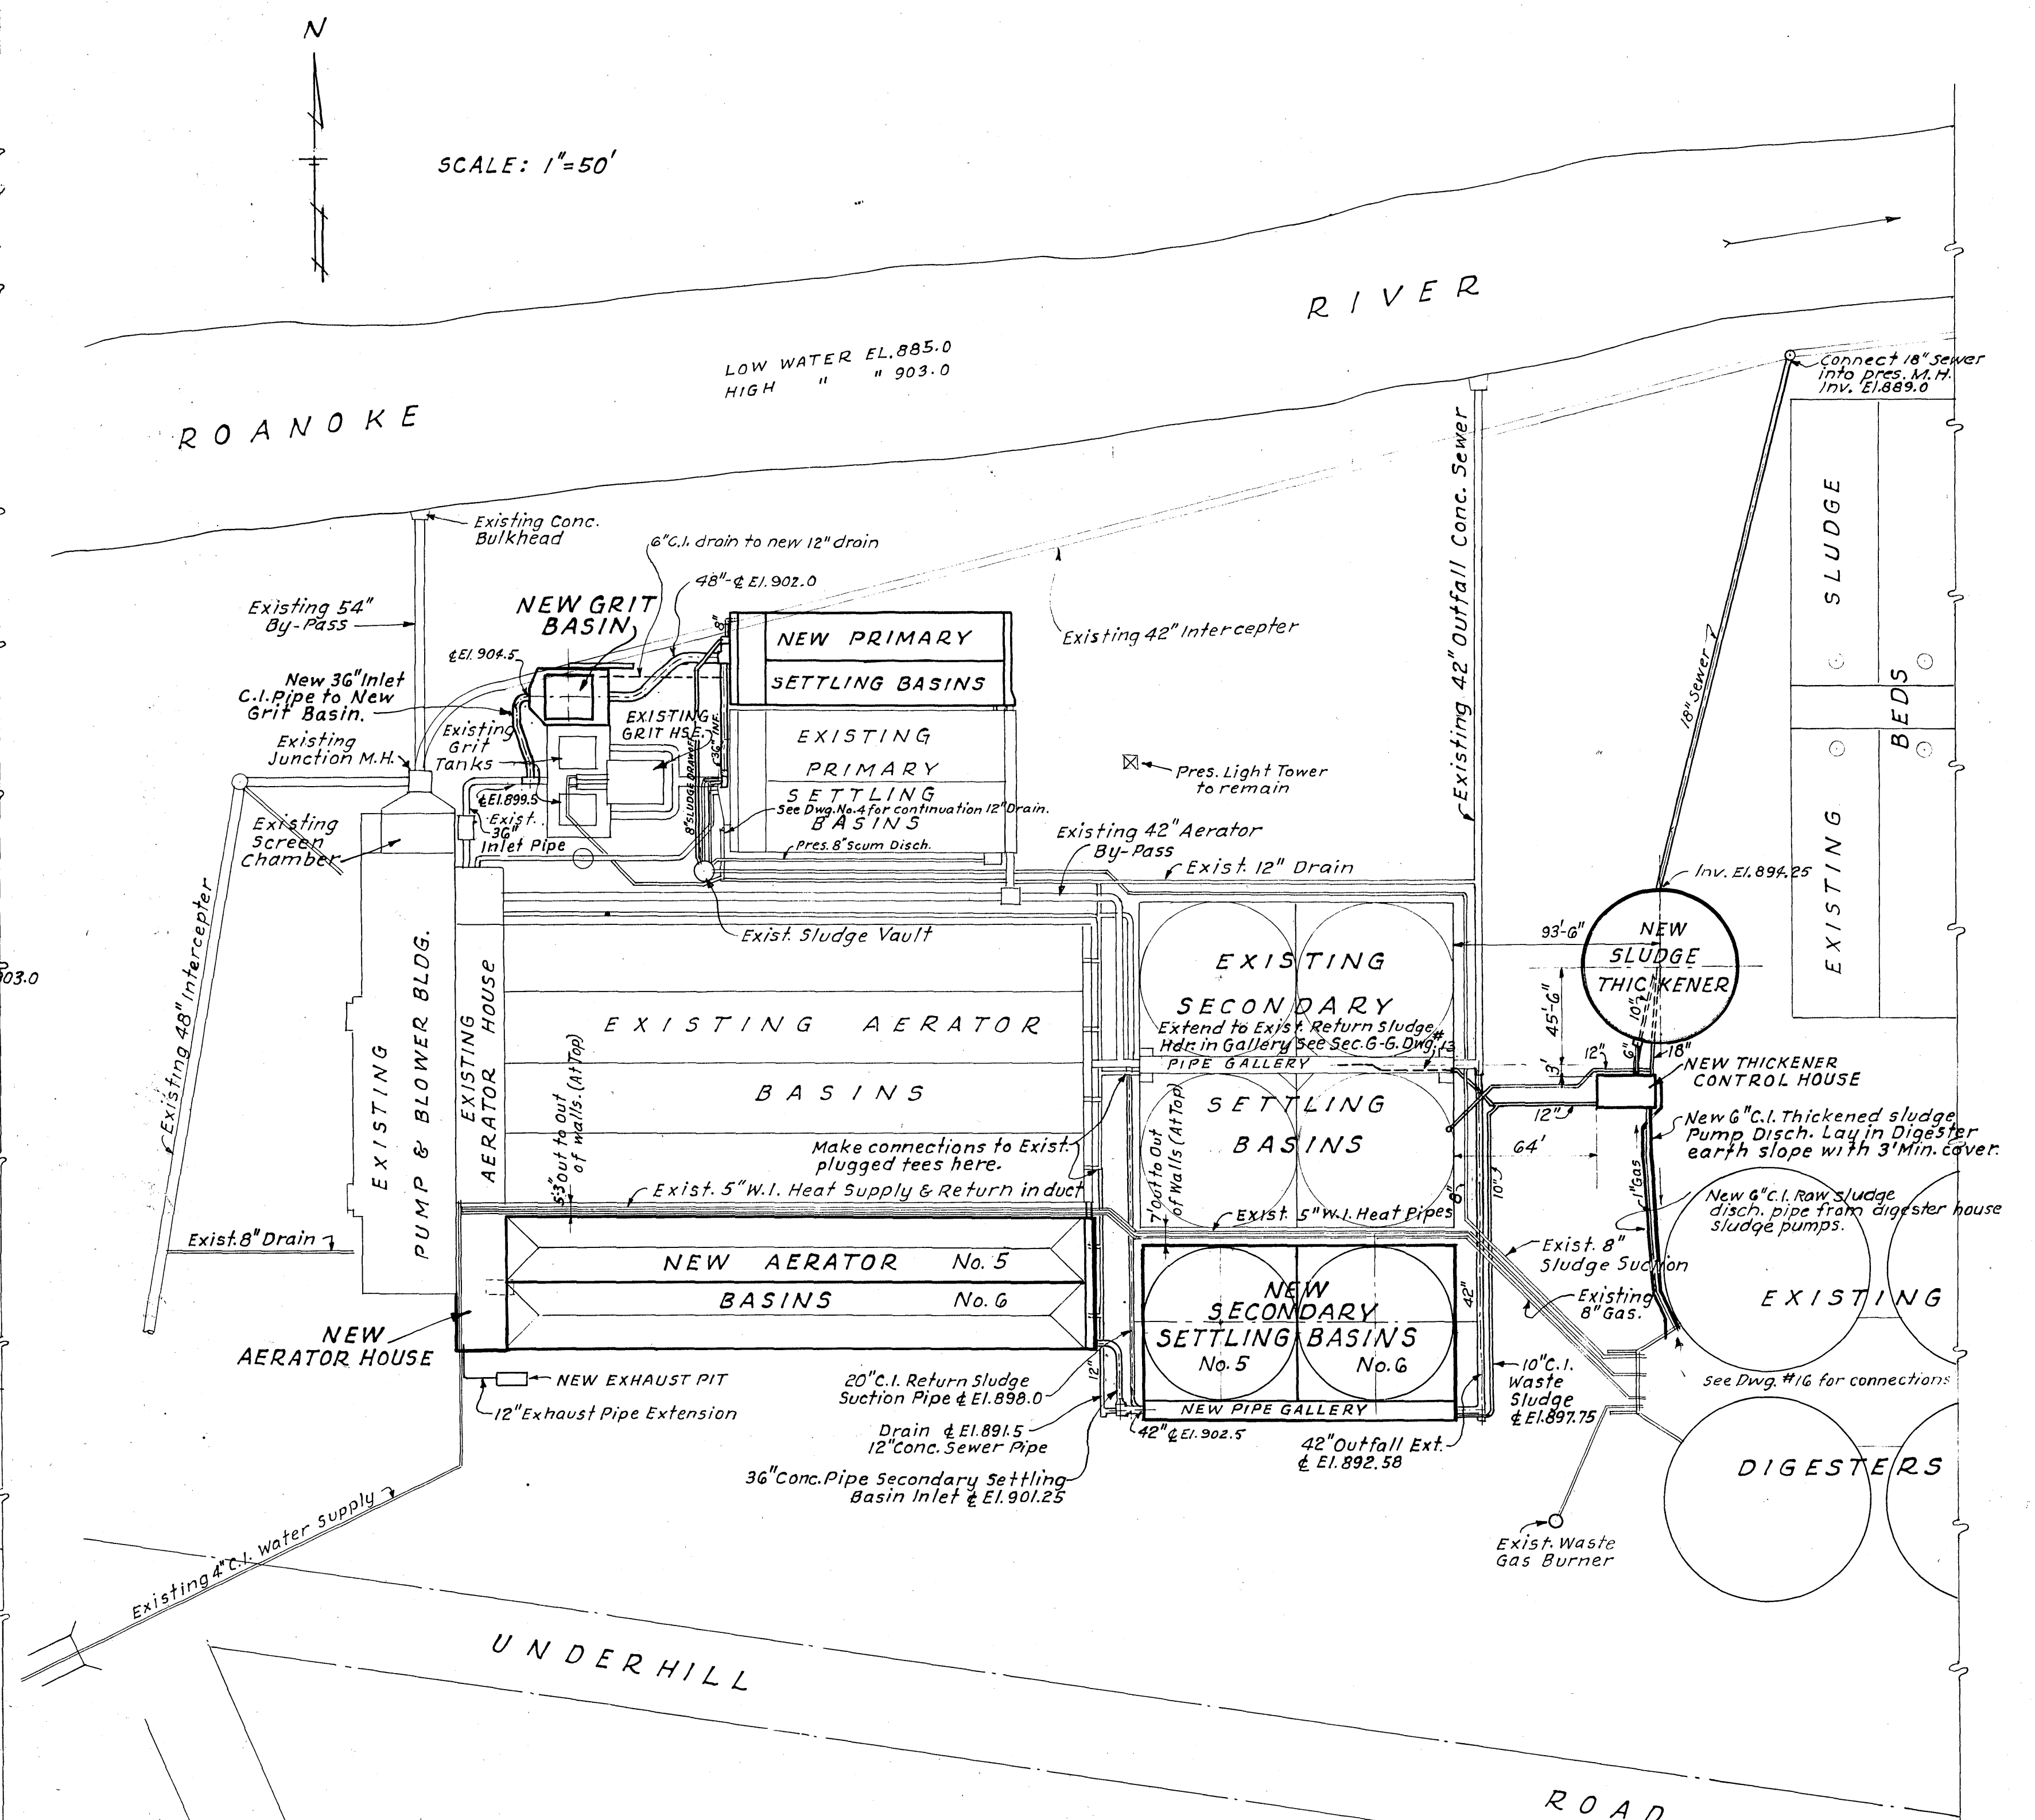

*For details of piping between aerator basins and secondary settling basins, see Dwg.No.15
For details of piping between final settling basins and sludge thickener see Dwg.No. 11
East wall of New Secondary Settling Basins to line up with present Basins.*

YARD PIPING PLAN

SCALE: 1"=50'

plans and specifications attached hereto
and referred to in paragraph (1.) of Certifi-
cate No. 1195 dated Feb. 25, 1959
and have been approved by the State Water
Control Board, 415 W. Franklin Street,
Richmond 20, Va.

A. H. Passler
Executive Secretary

SEWAGE TREATMENT PLANT ADDITIONS

GENERAL PLANS

CITY OF ROANOKE
VIRGINIA

ALVORD, BURDICK & HOWSON
ENGINEERS 1959 CHICAGO