



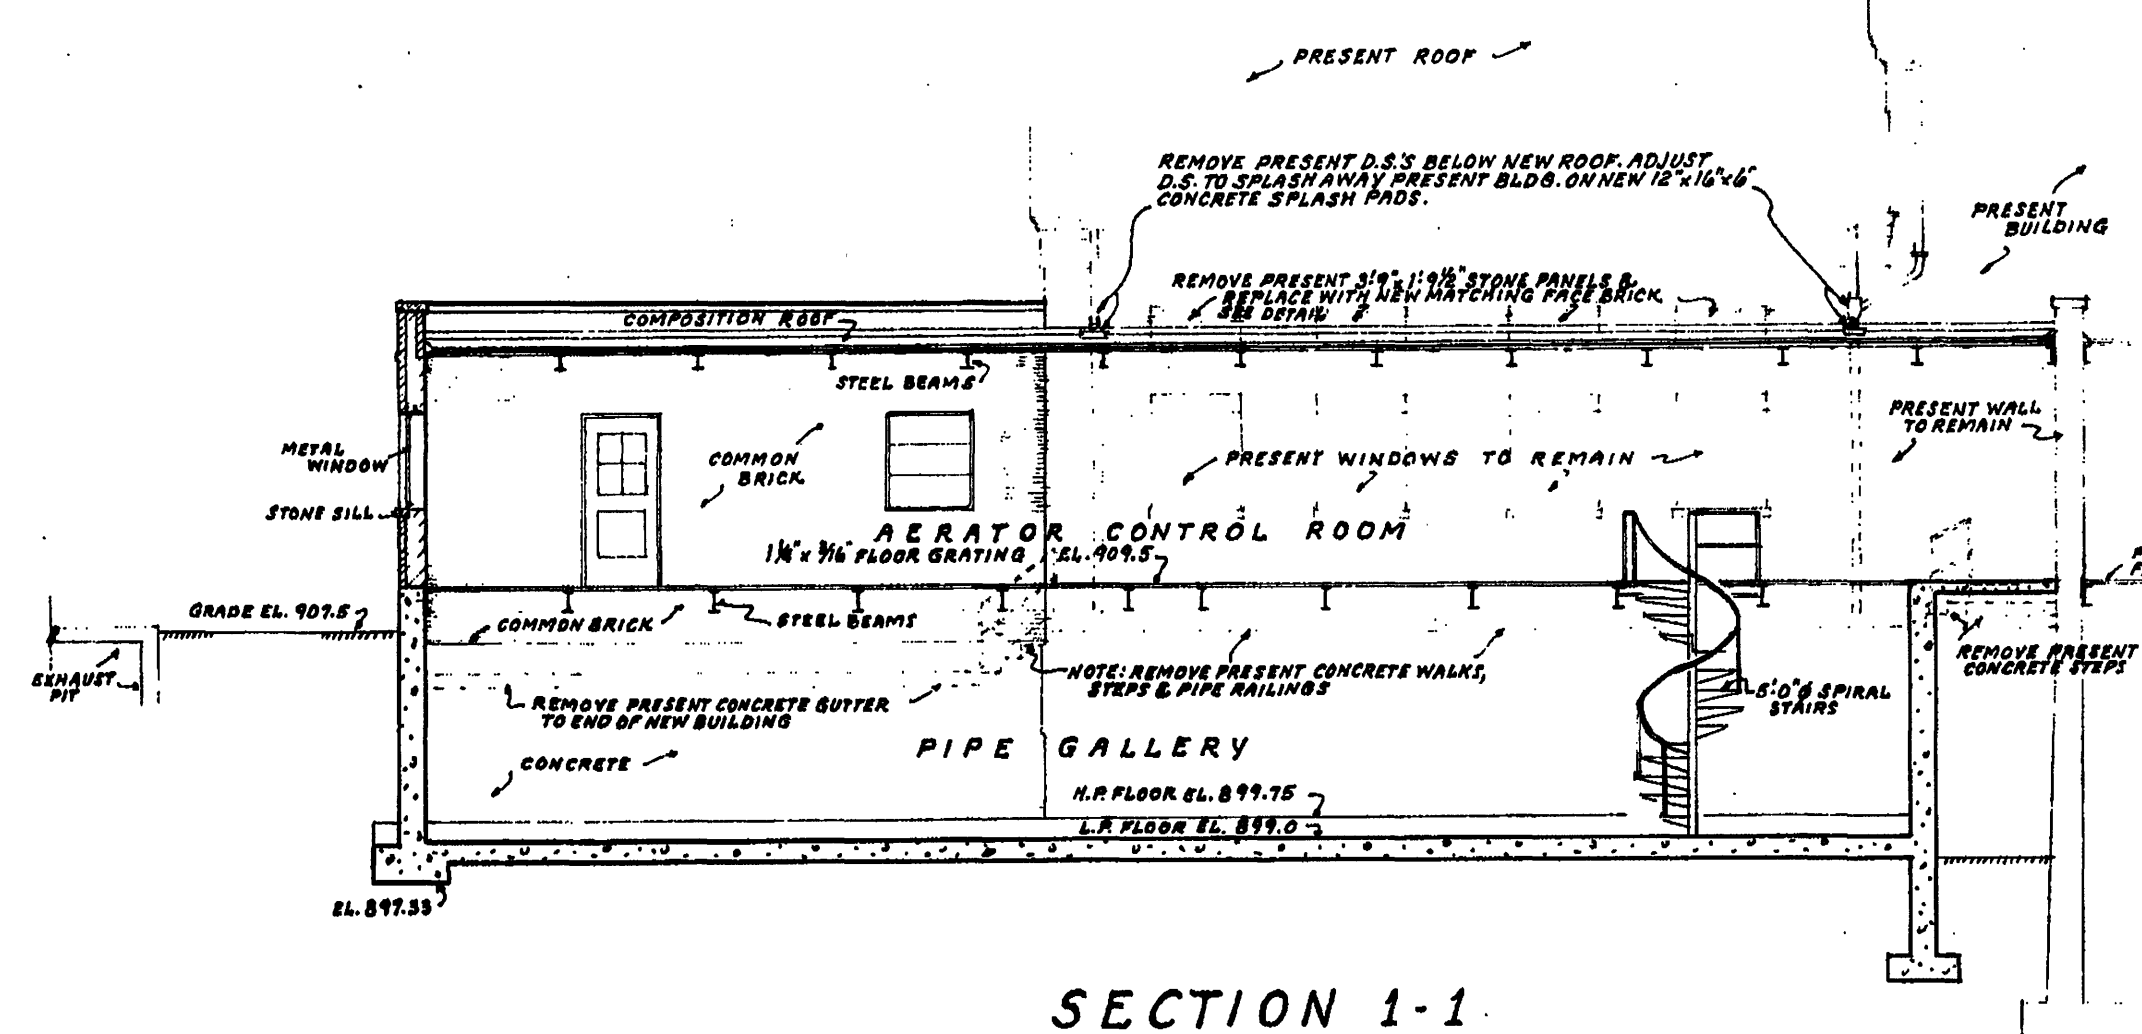


SECTION 1-1
SCALE 1/8" = 1'-0"

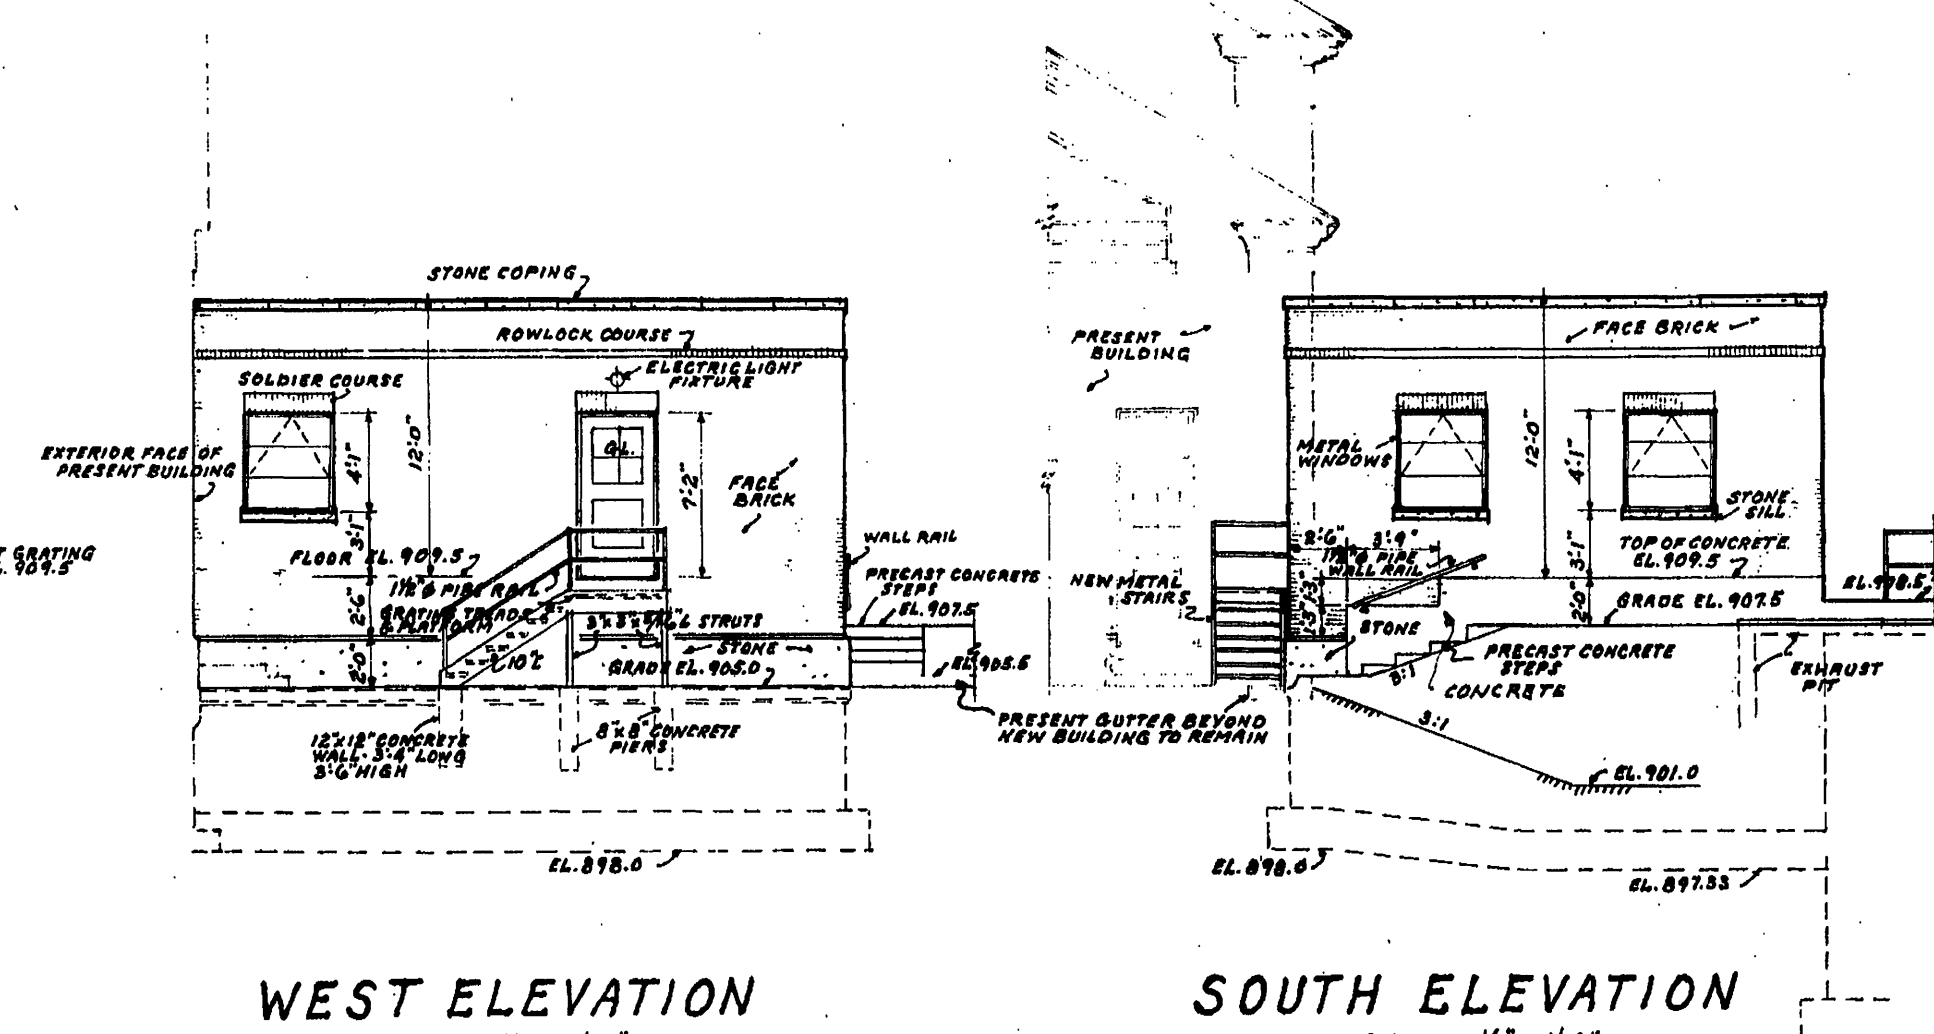


WEST ELEVATION
SCALE 1/8" = 1'-0"


SOUTH ELEVATION
SCALE 1/8" = 1'-0"

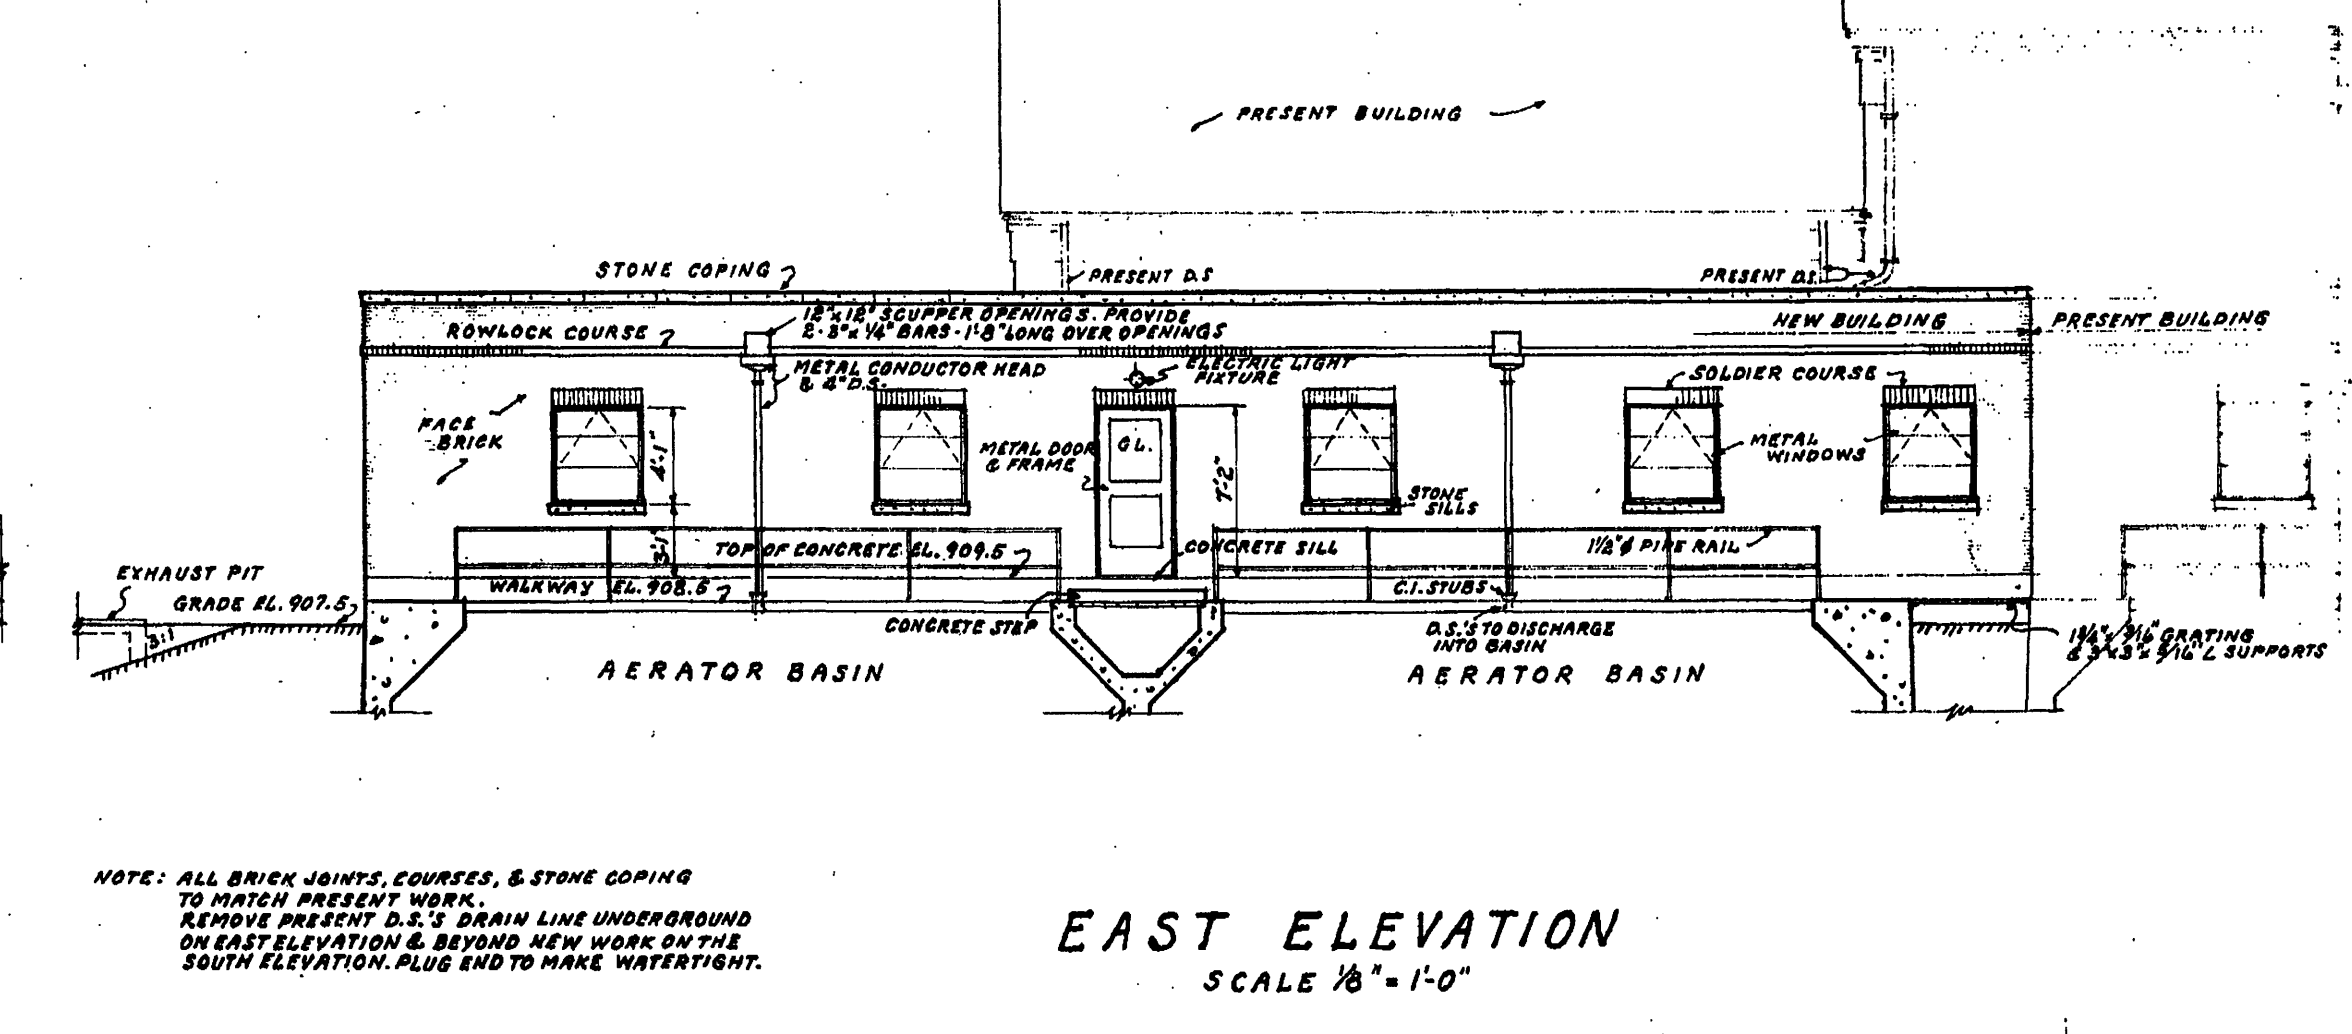


EAST ELEVATION
SCALE 1/8" = 1'-0"

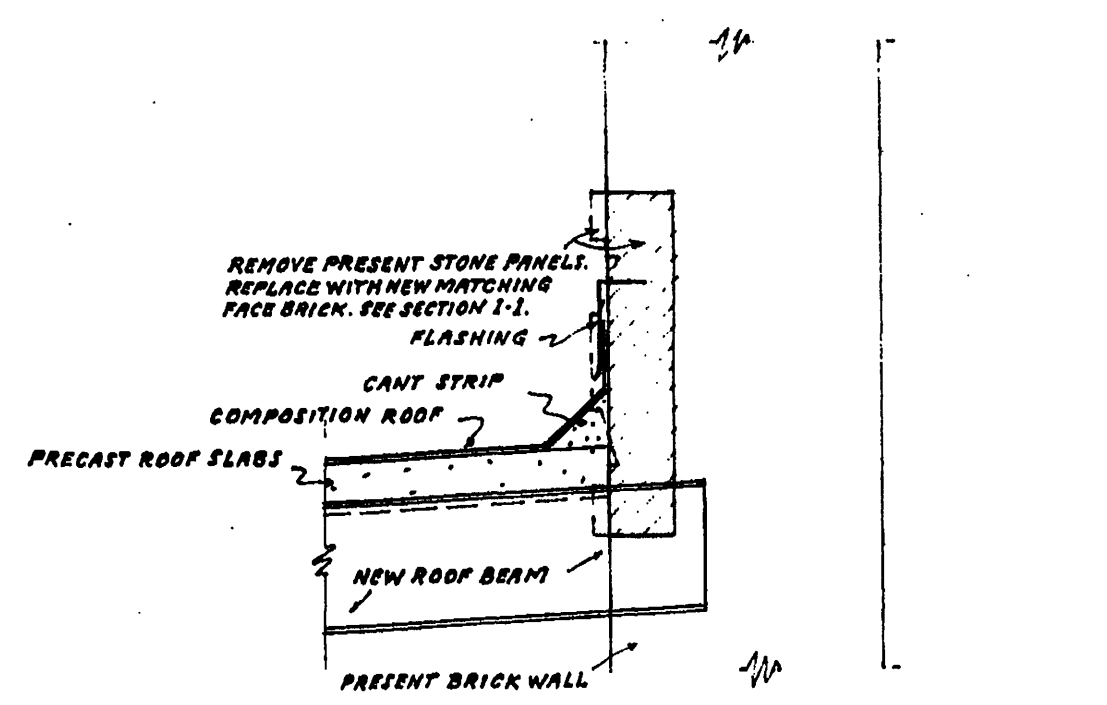


SECTION THRU PRESENT STONE PANELS
SCALE 1" = 1'-0"

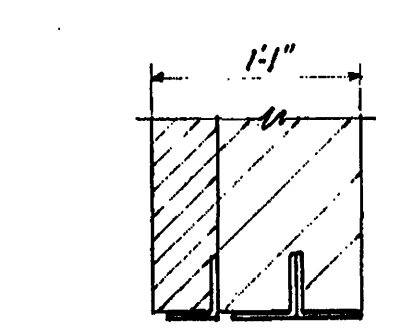


LINTEL DETAILS
SCALE 1" = 1'-0"

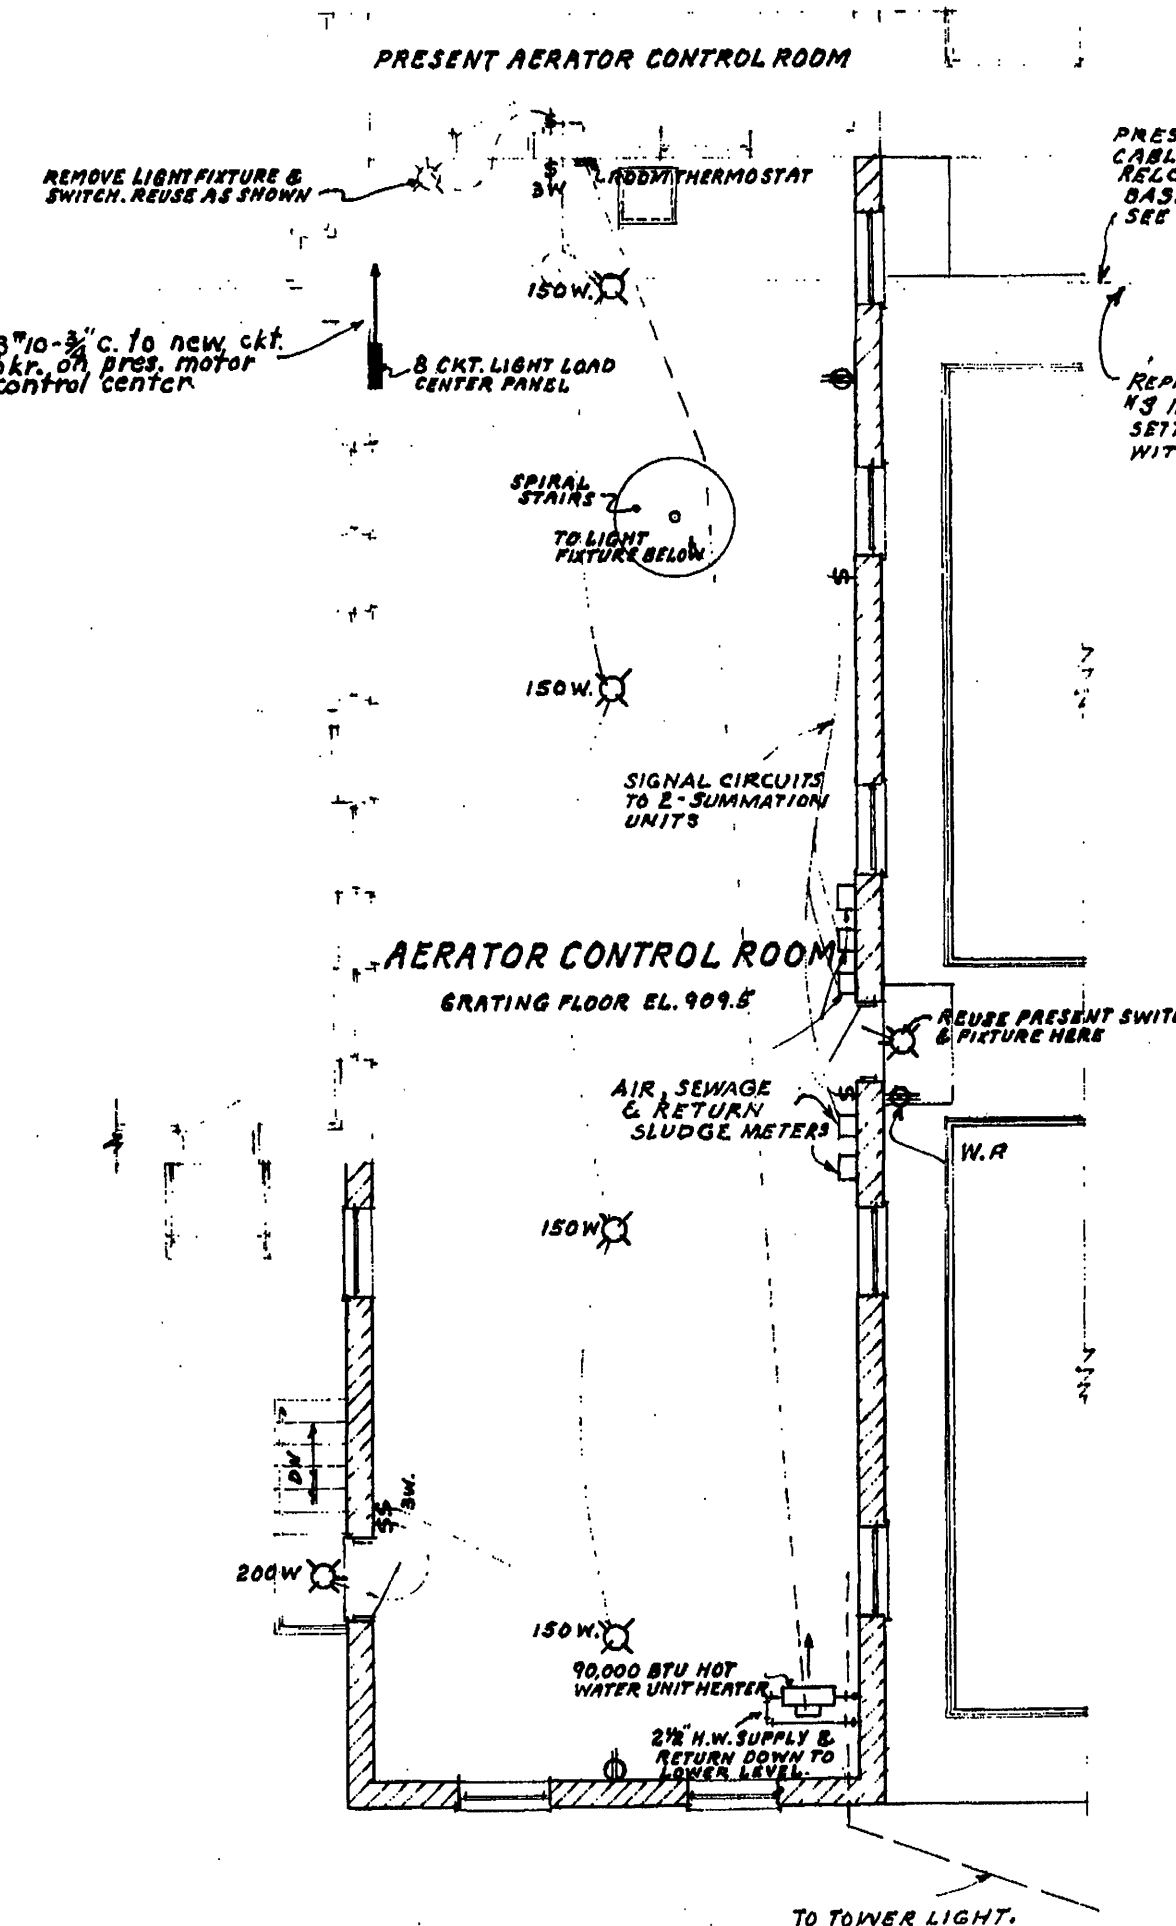


ELECTRICAL & HEATING LAYOUT
FOR MAIN FLOOR PLAN
SCALE 1/8" = 1'-0"

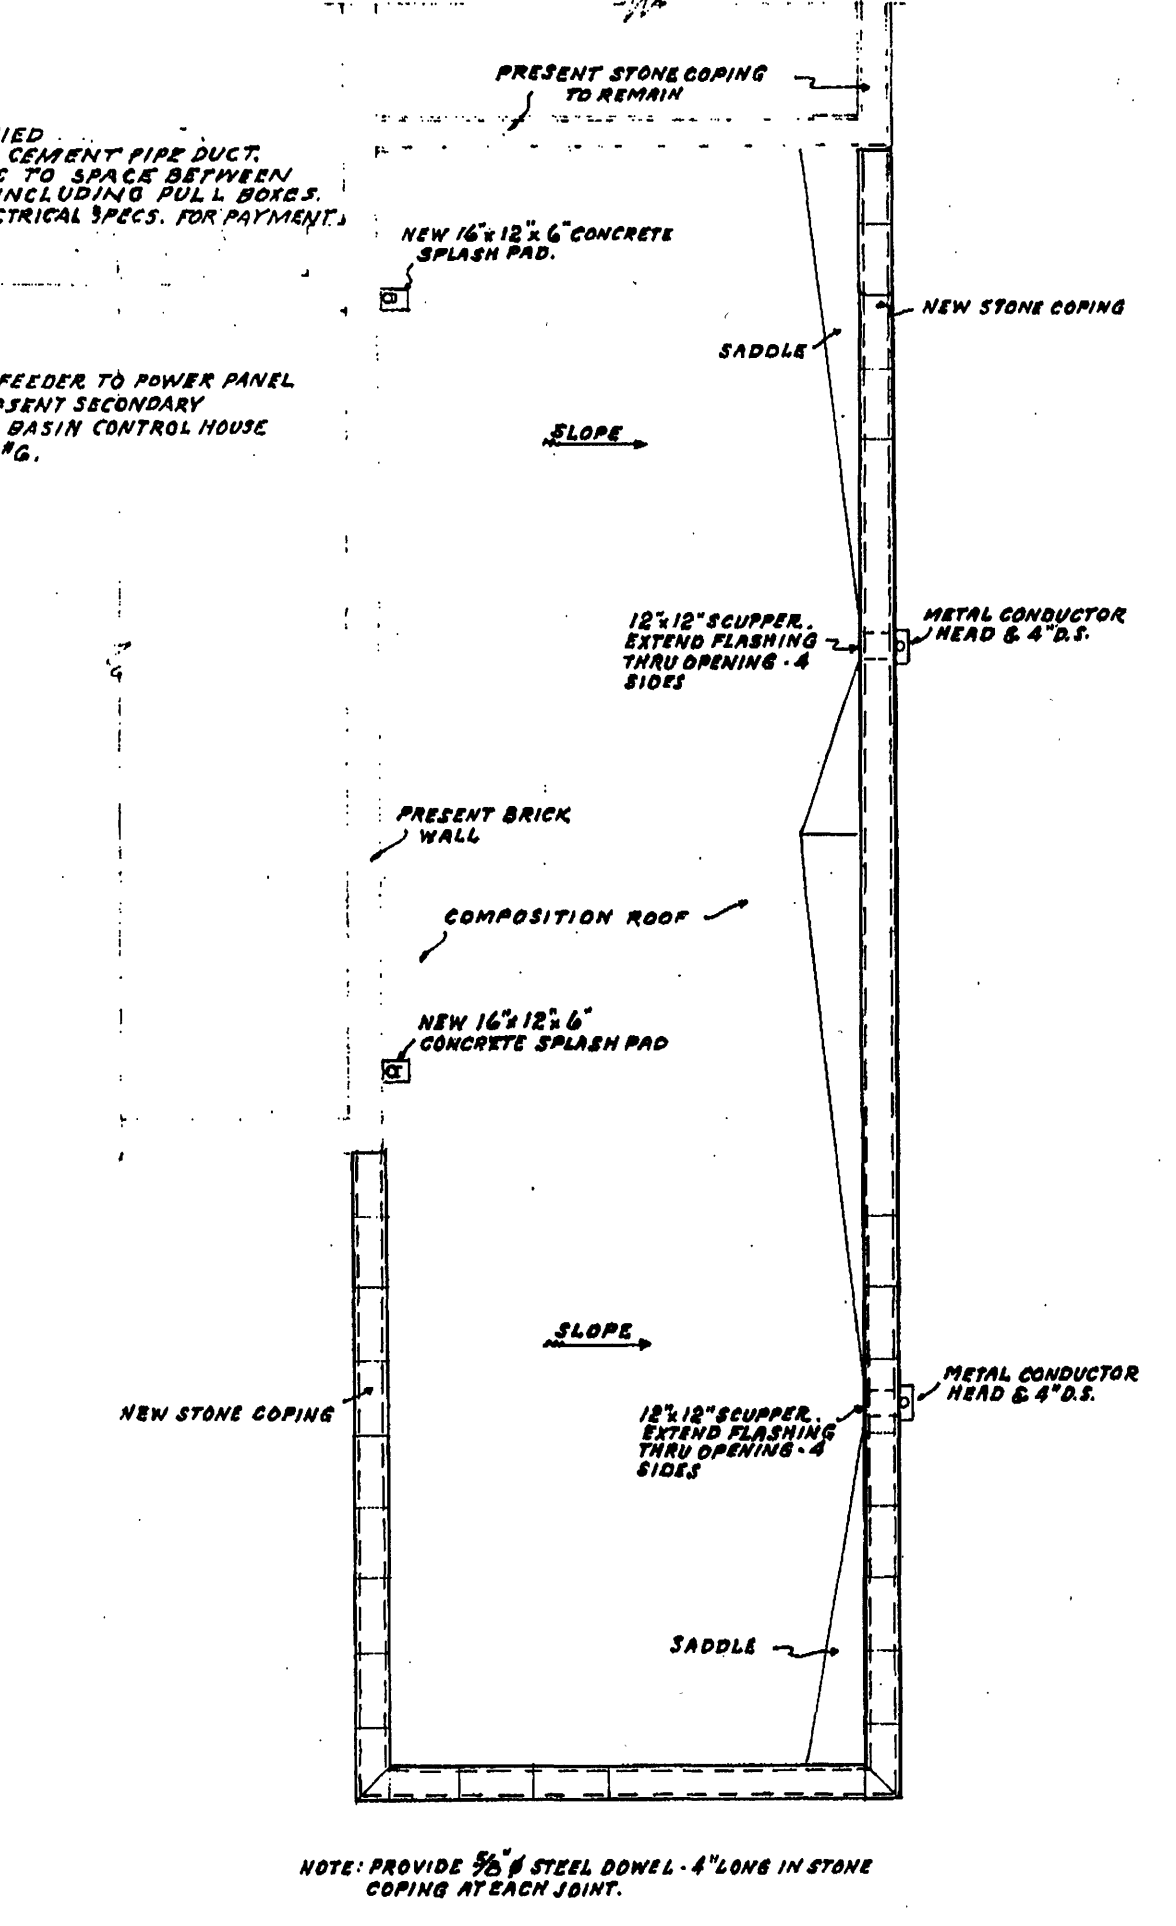

ROOF PLAN
SCALE 1/8" = 1'-0"

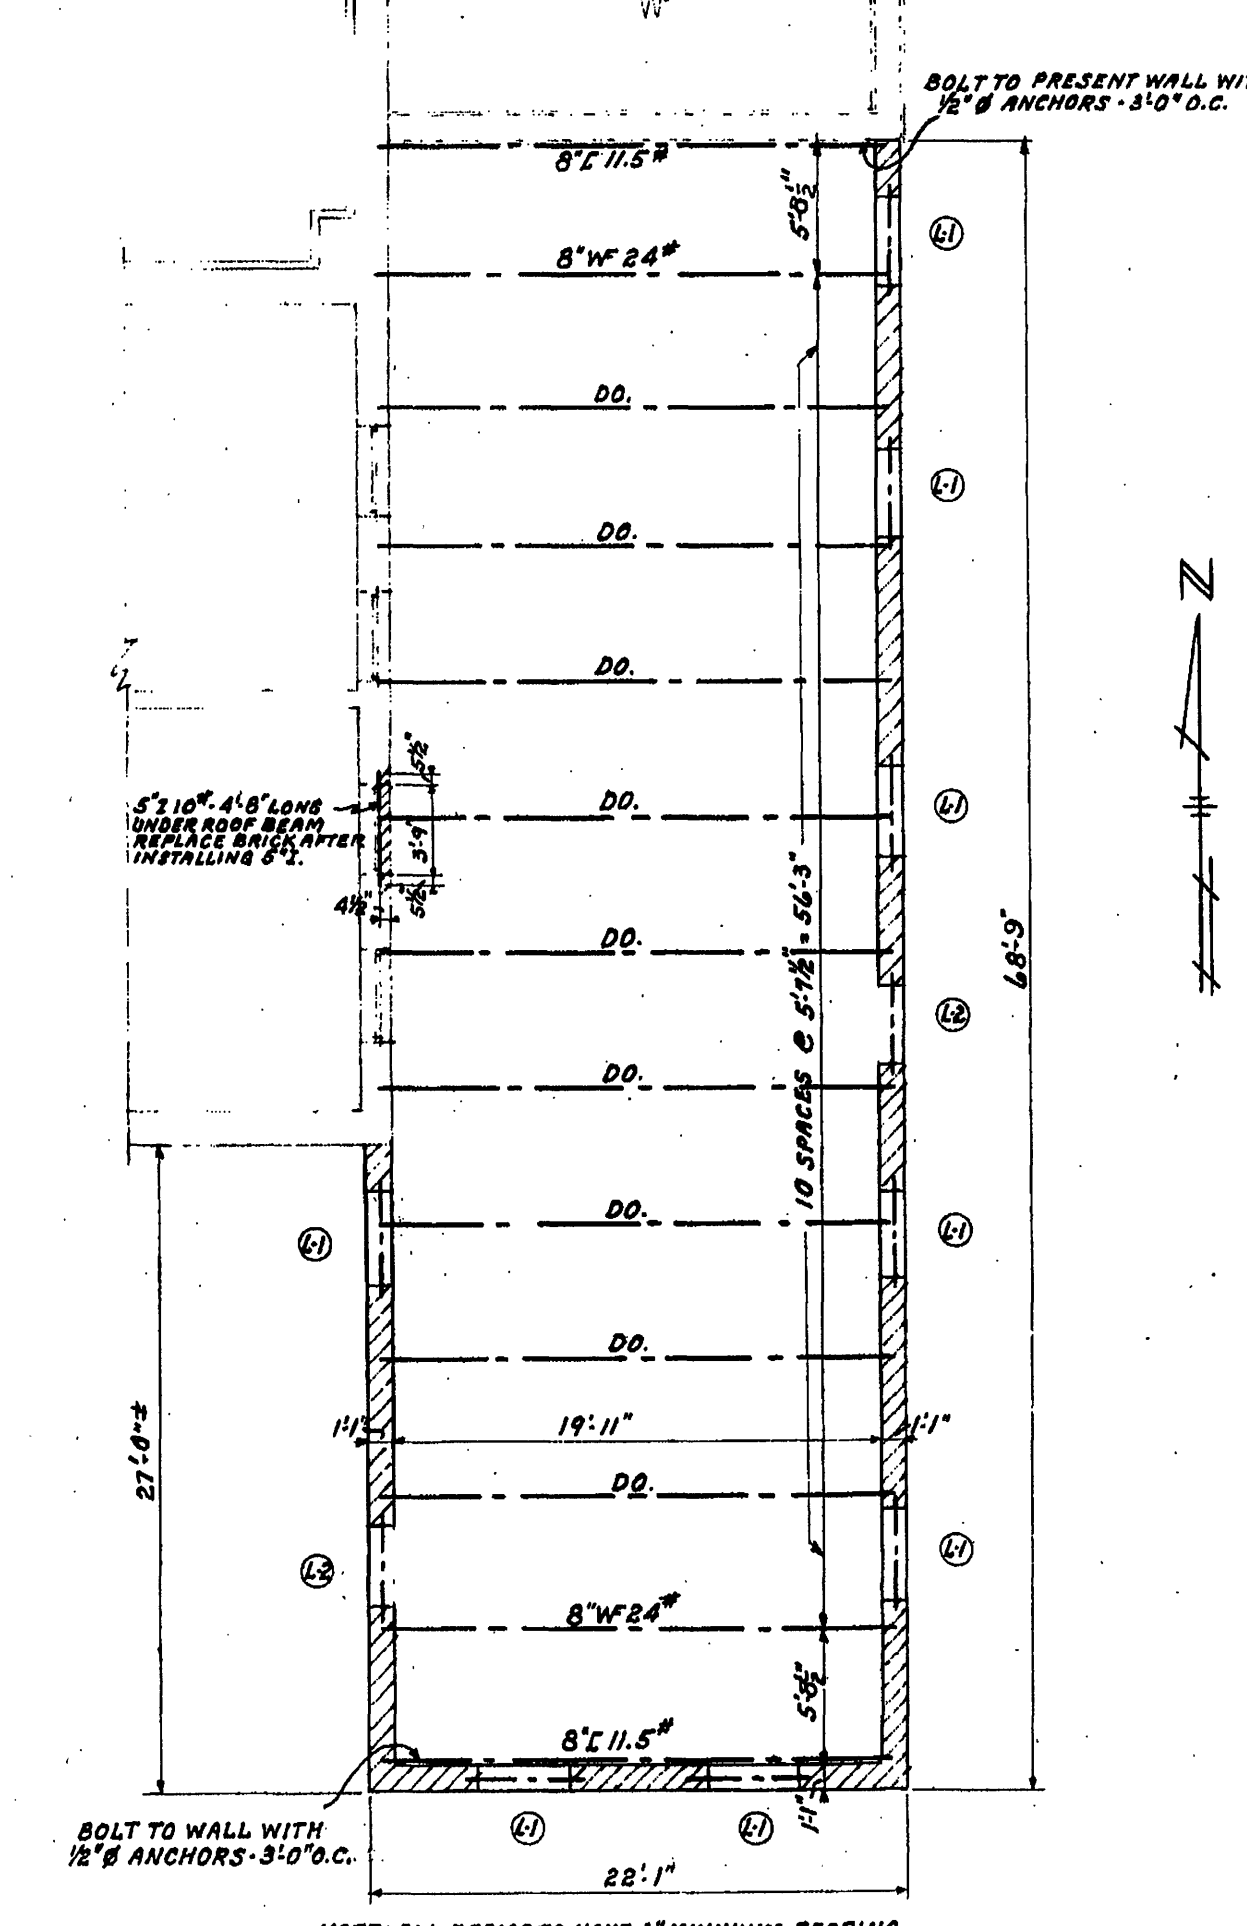

ROOF FRAMING PLAN
SCALE 1/8" = 1'-0"

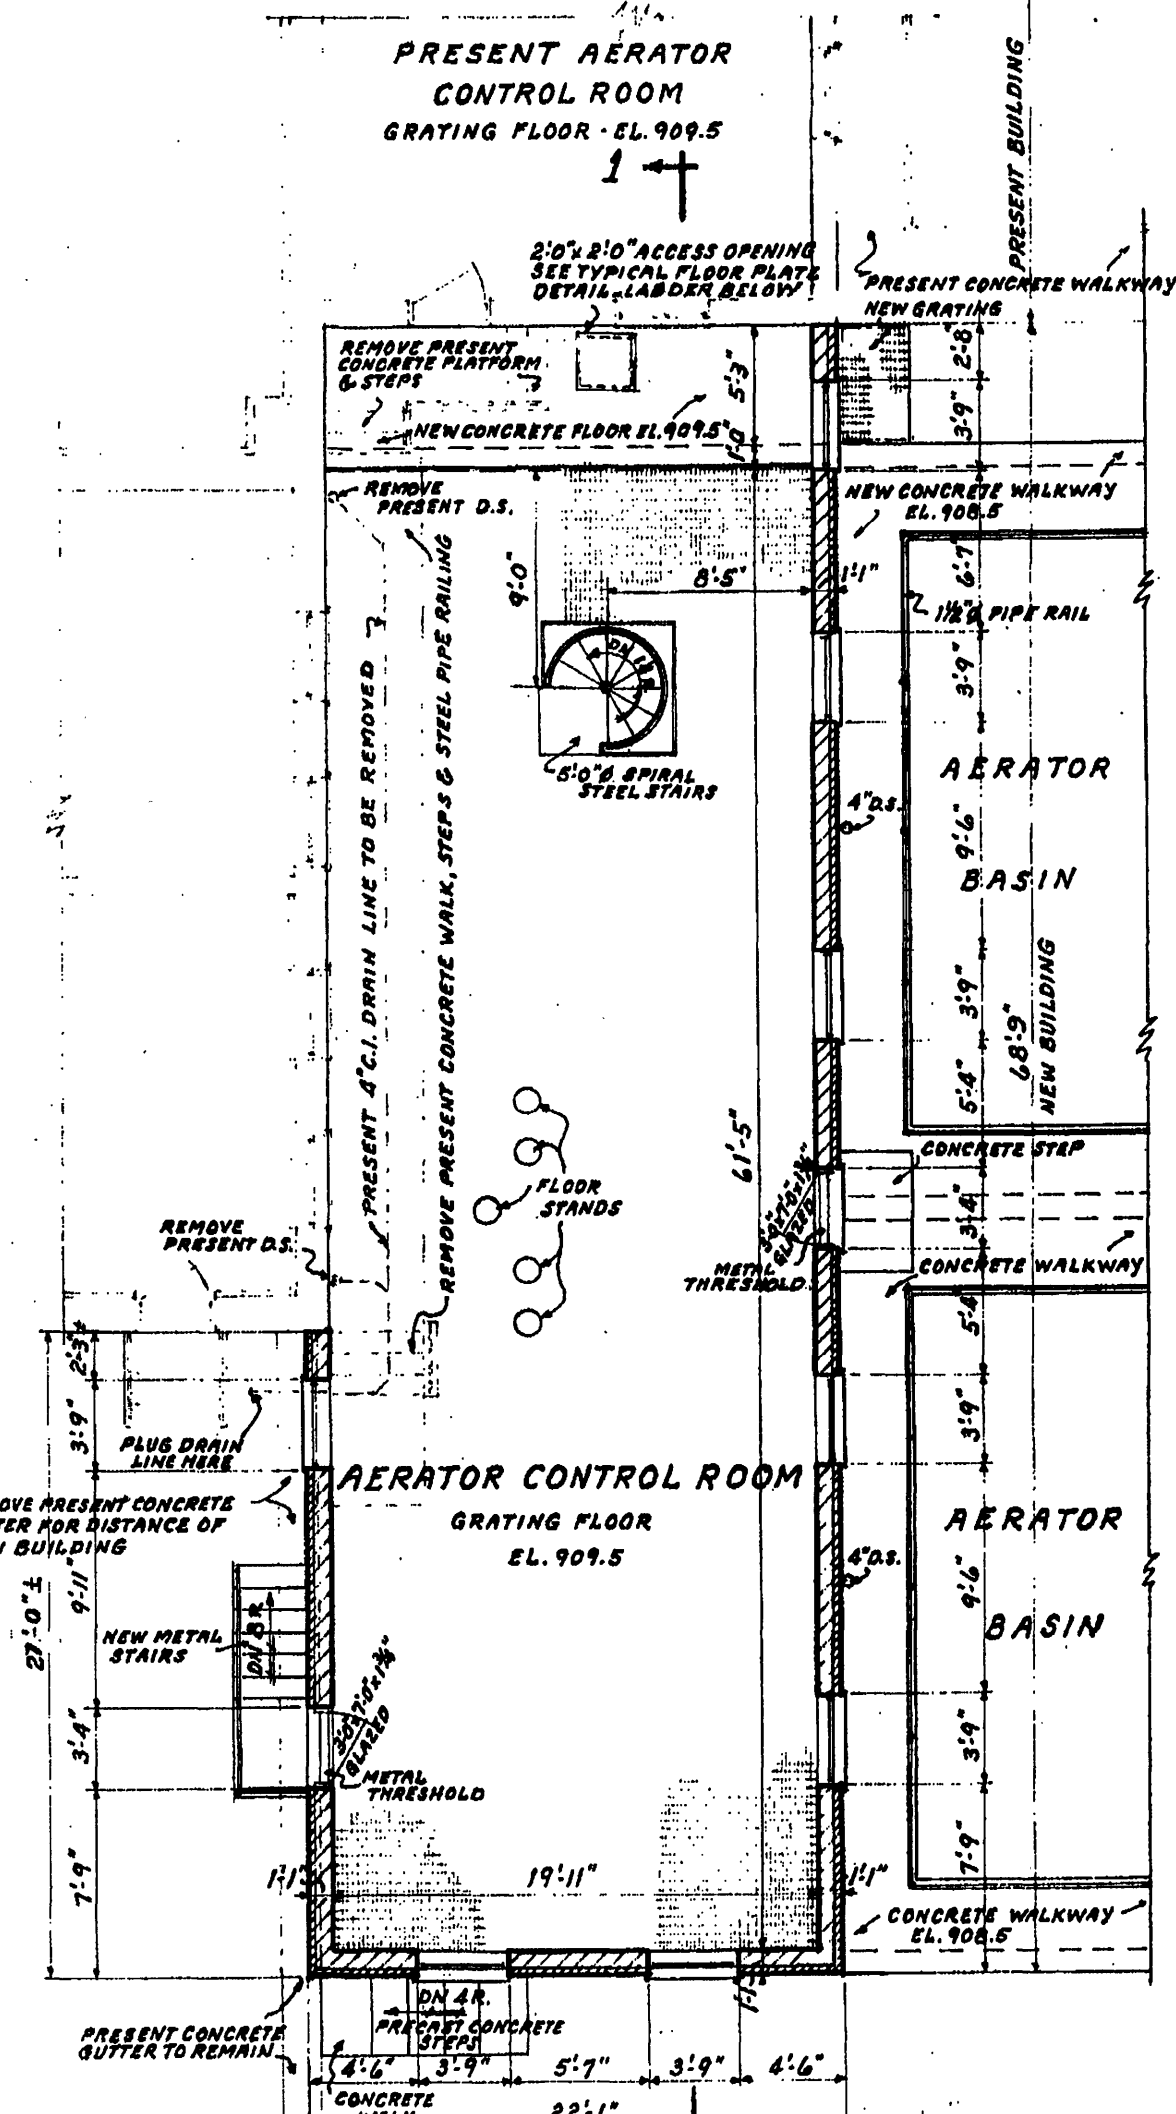

MAIN FLOOR PLAN
SCALE 1/8" = 1'-0"