


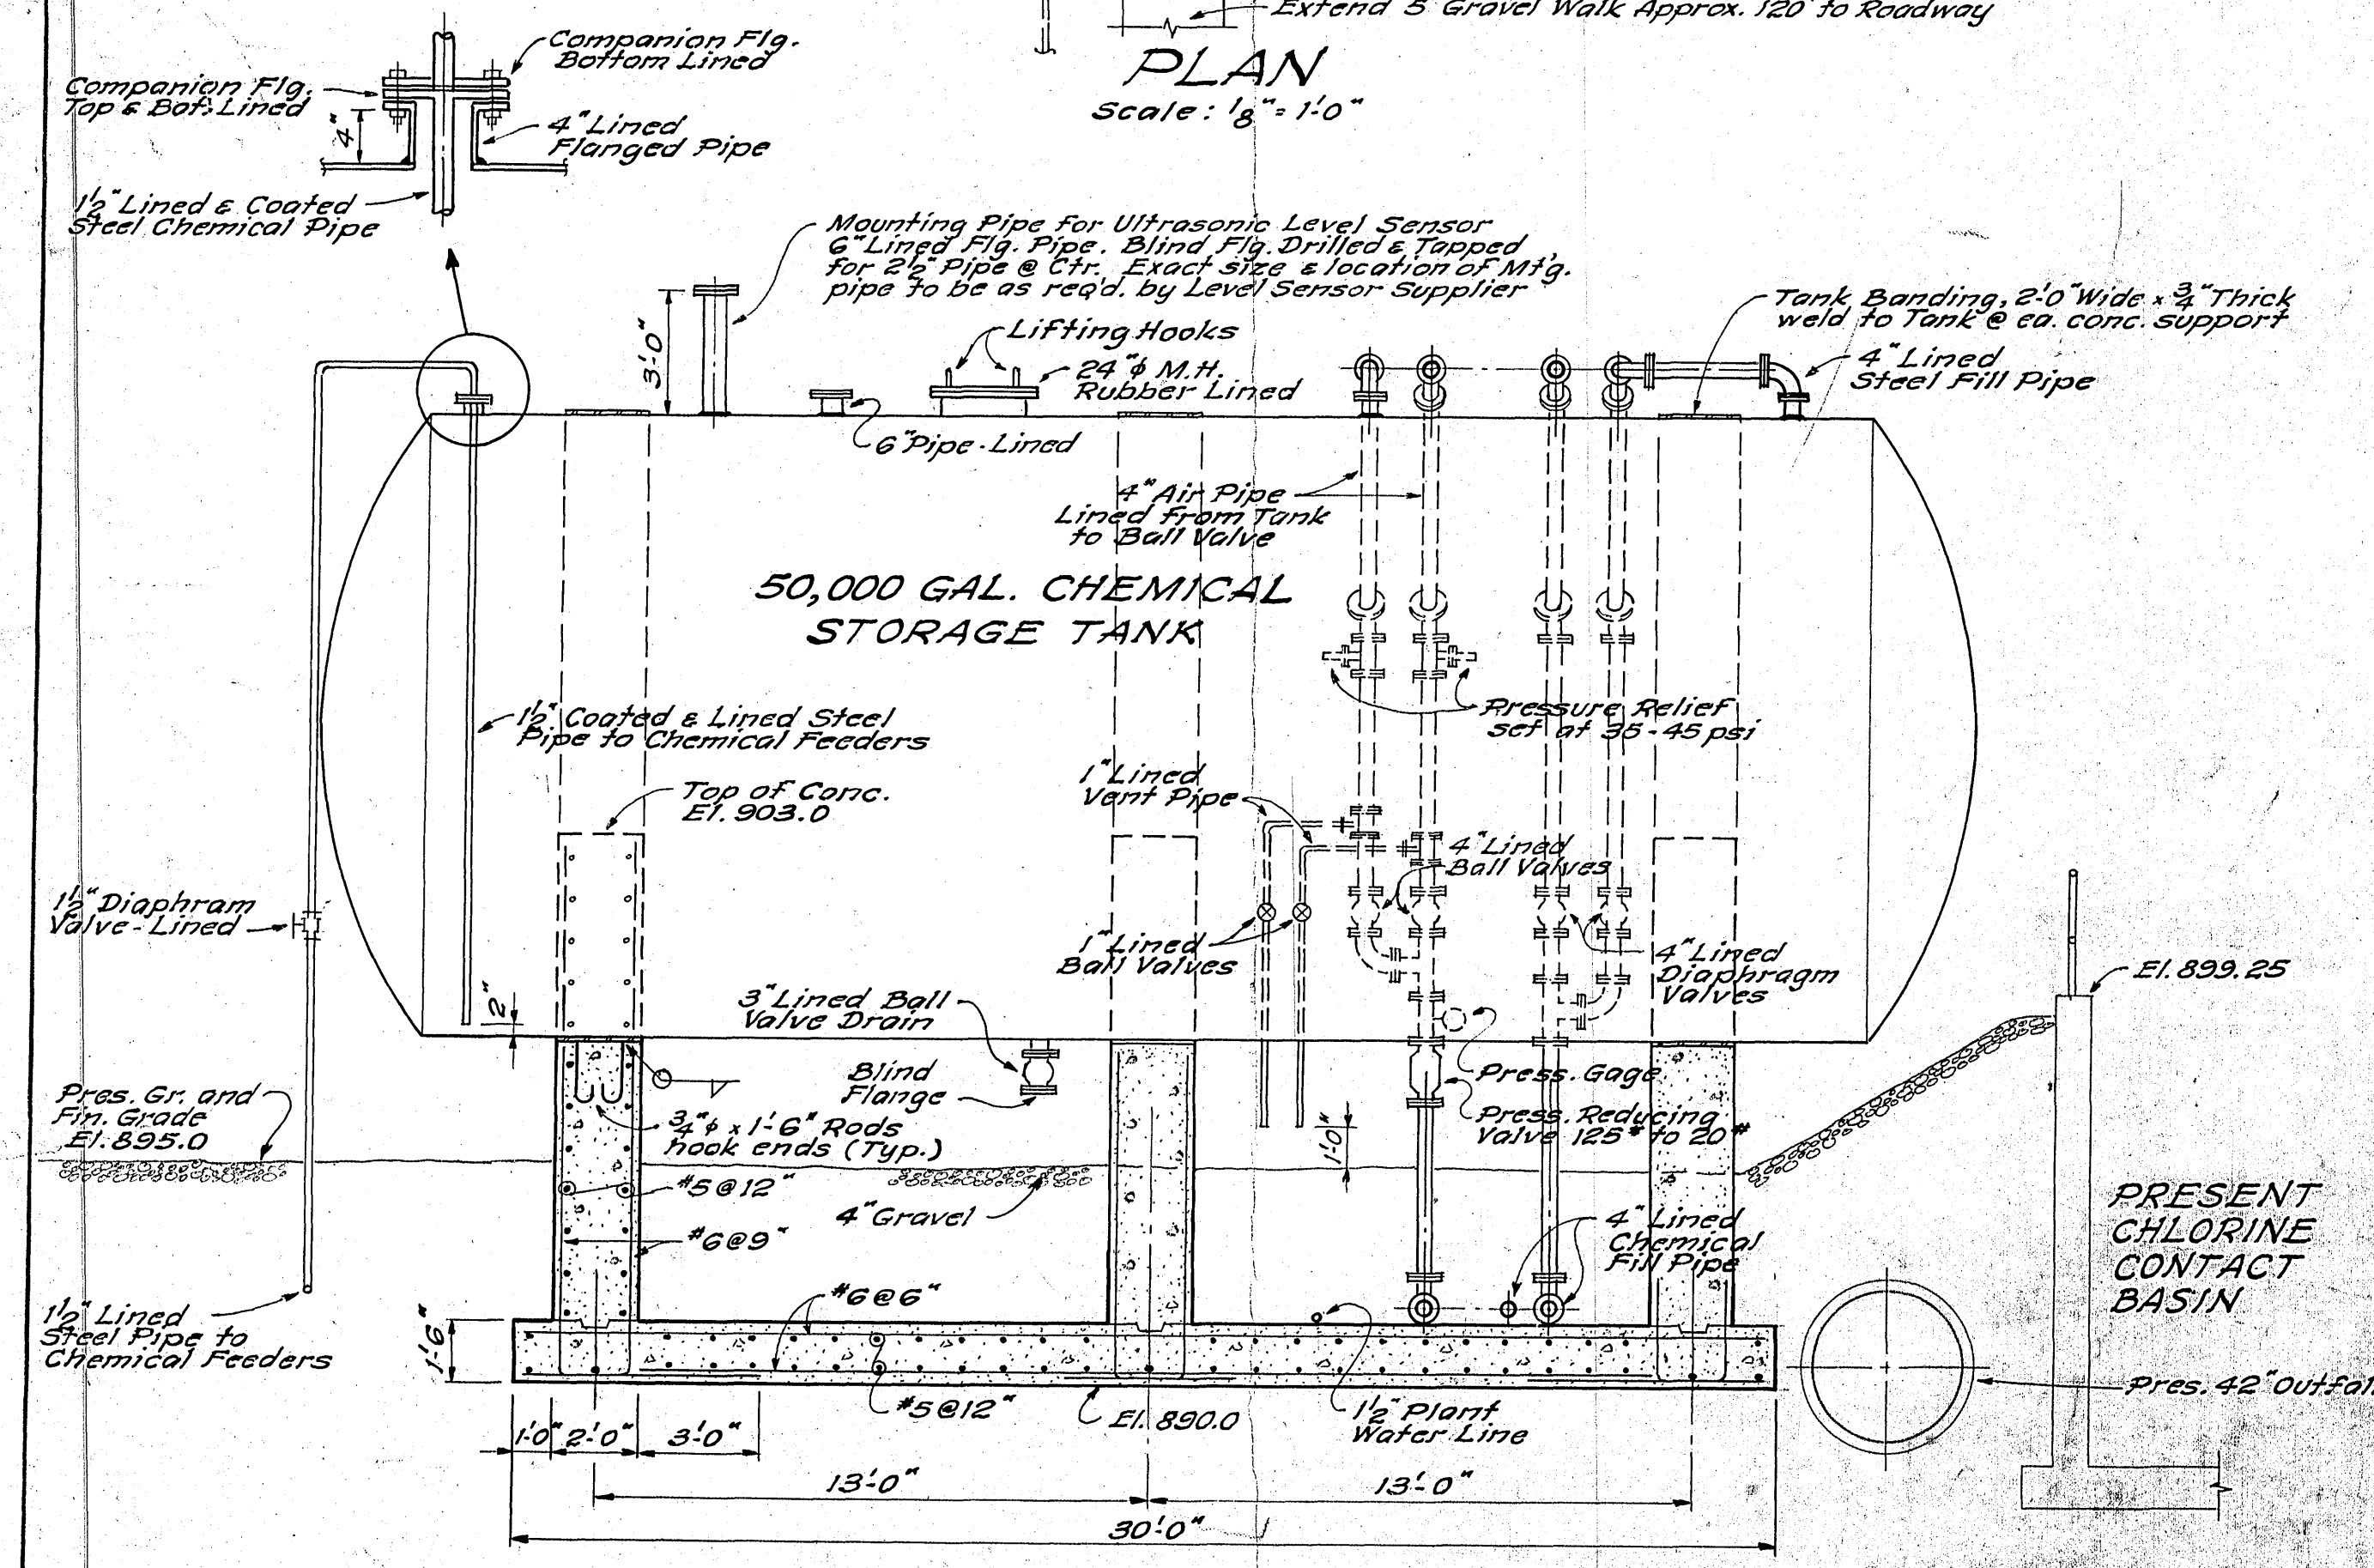


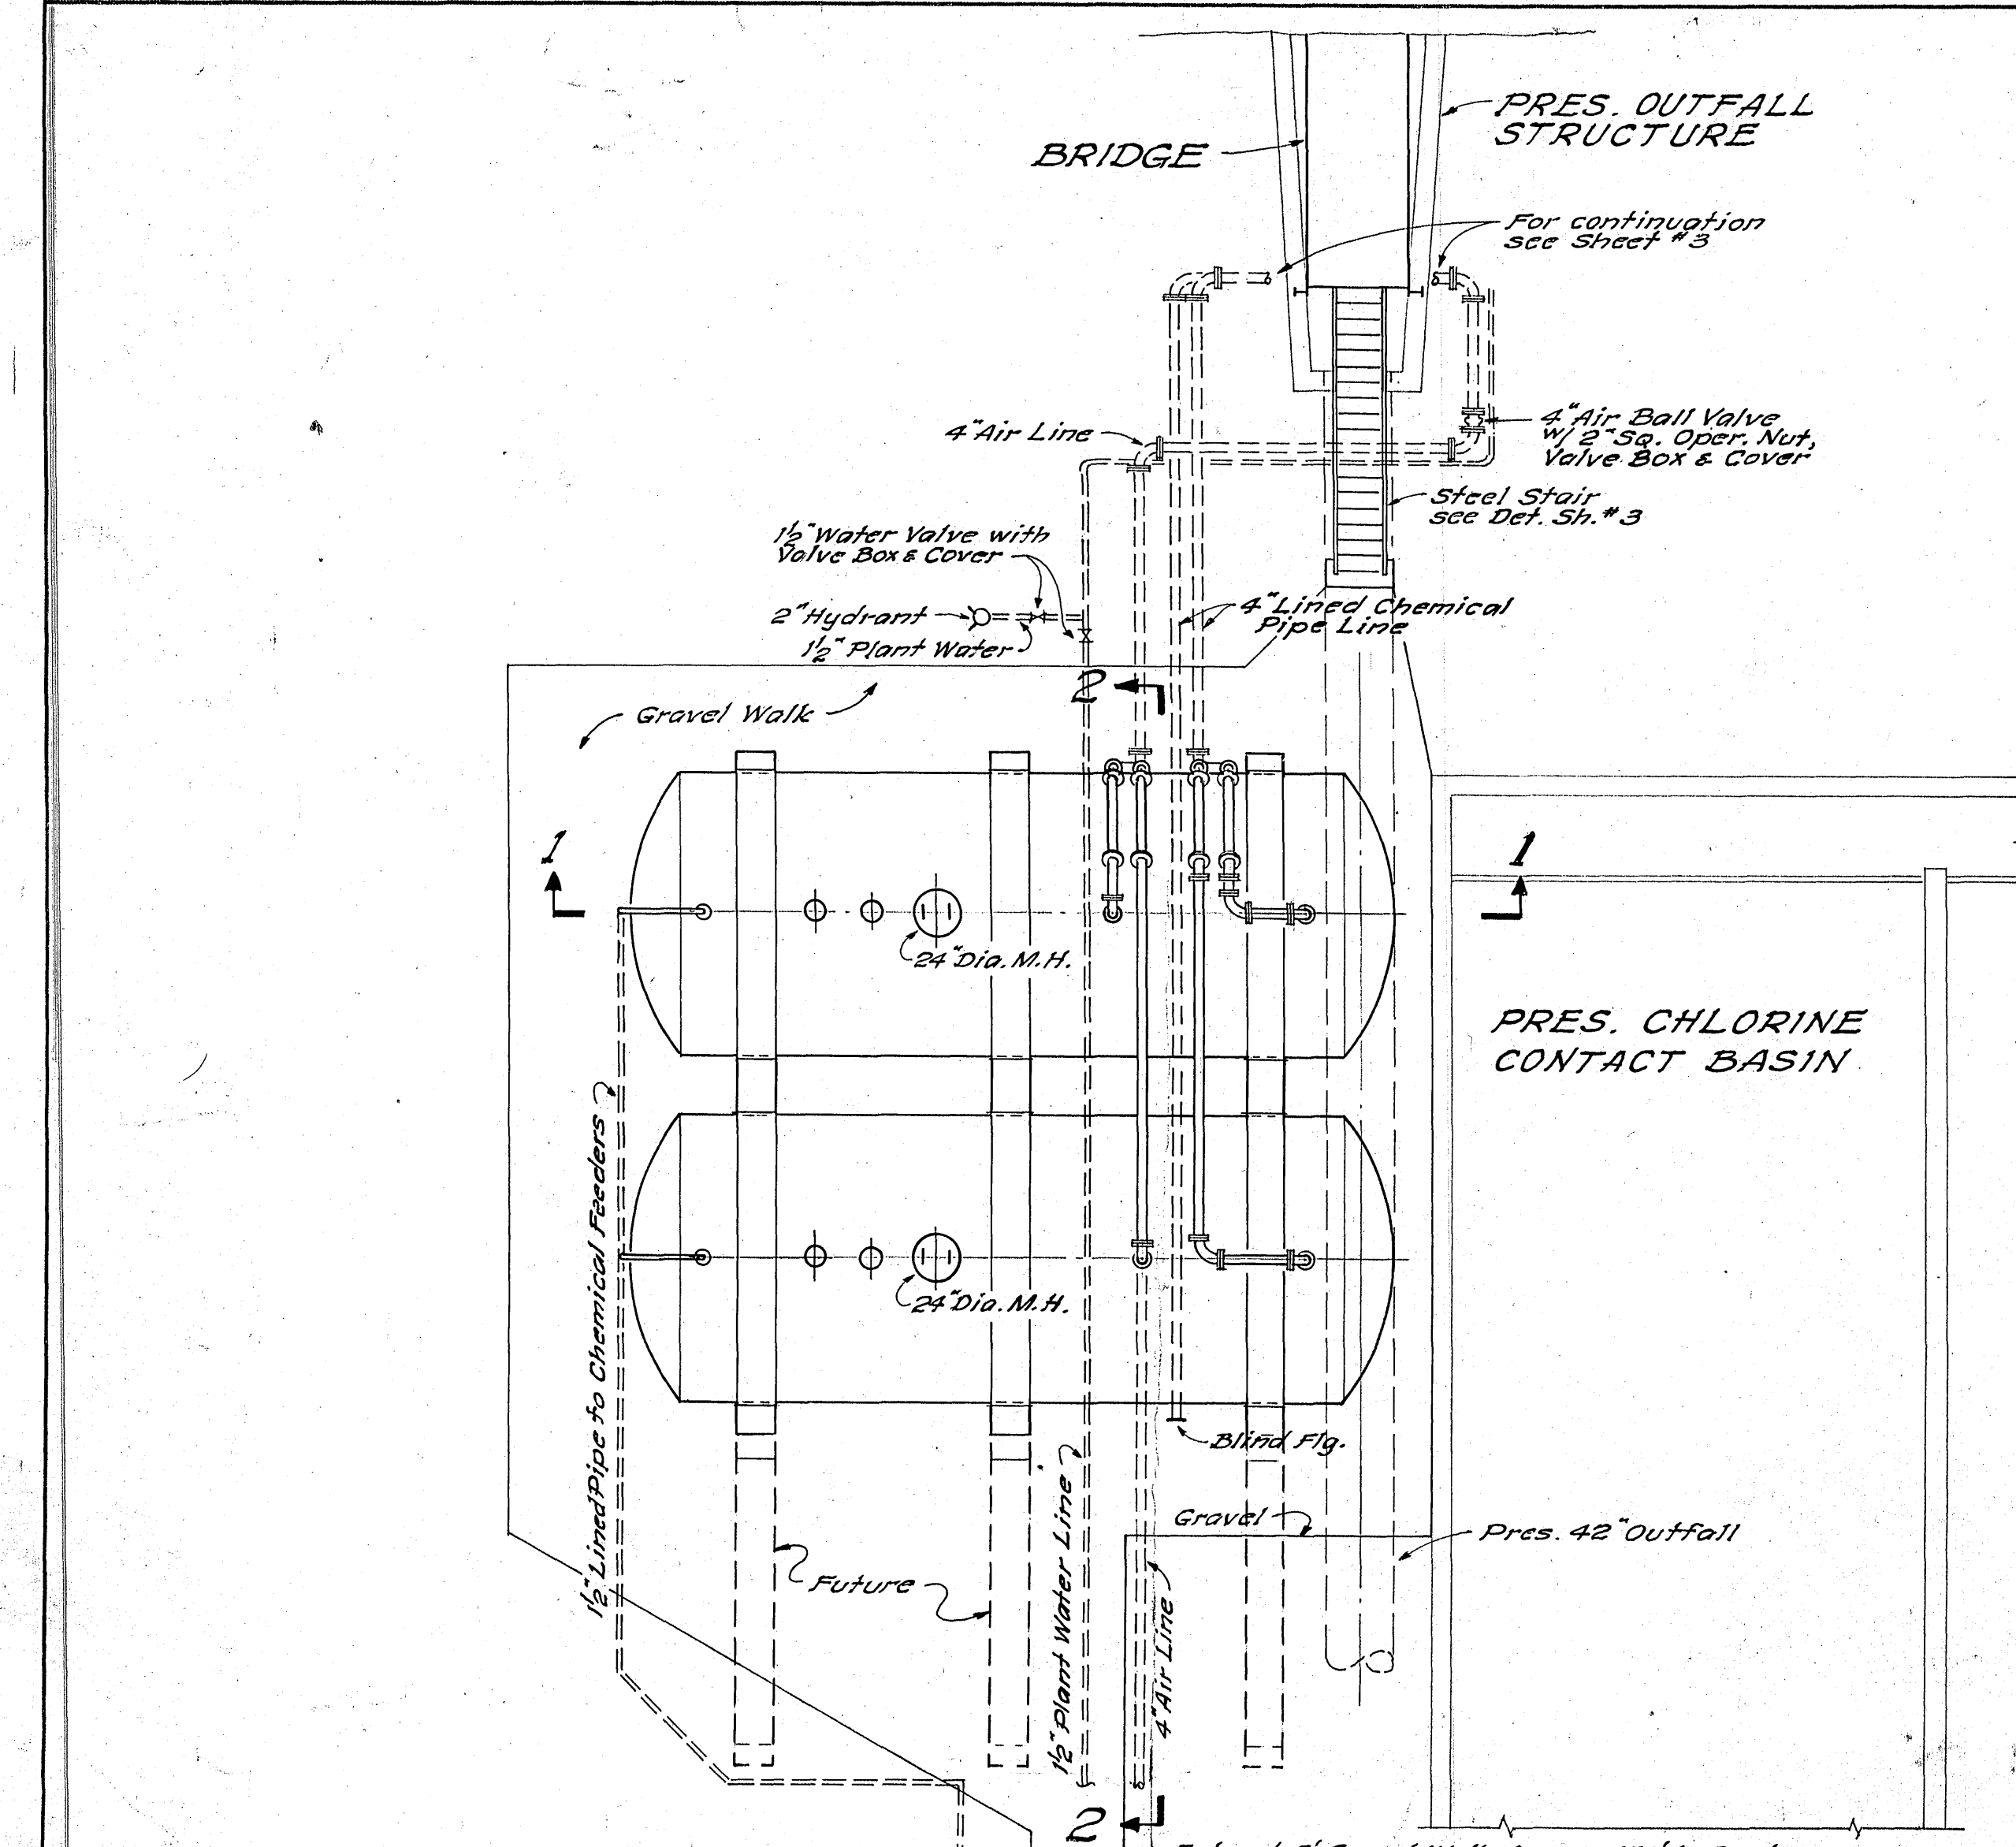


SECTION 1-1
Scale: 1/4" = 1'-0"

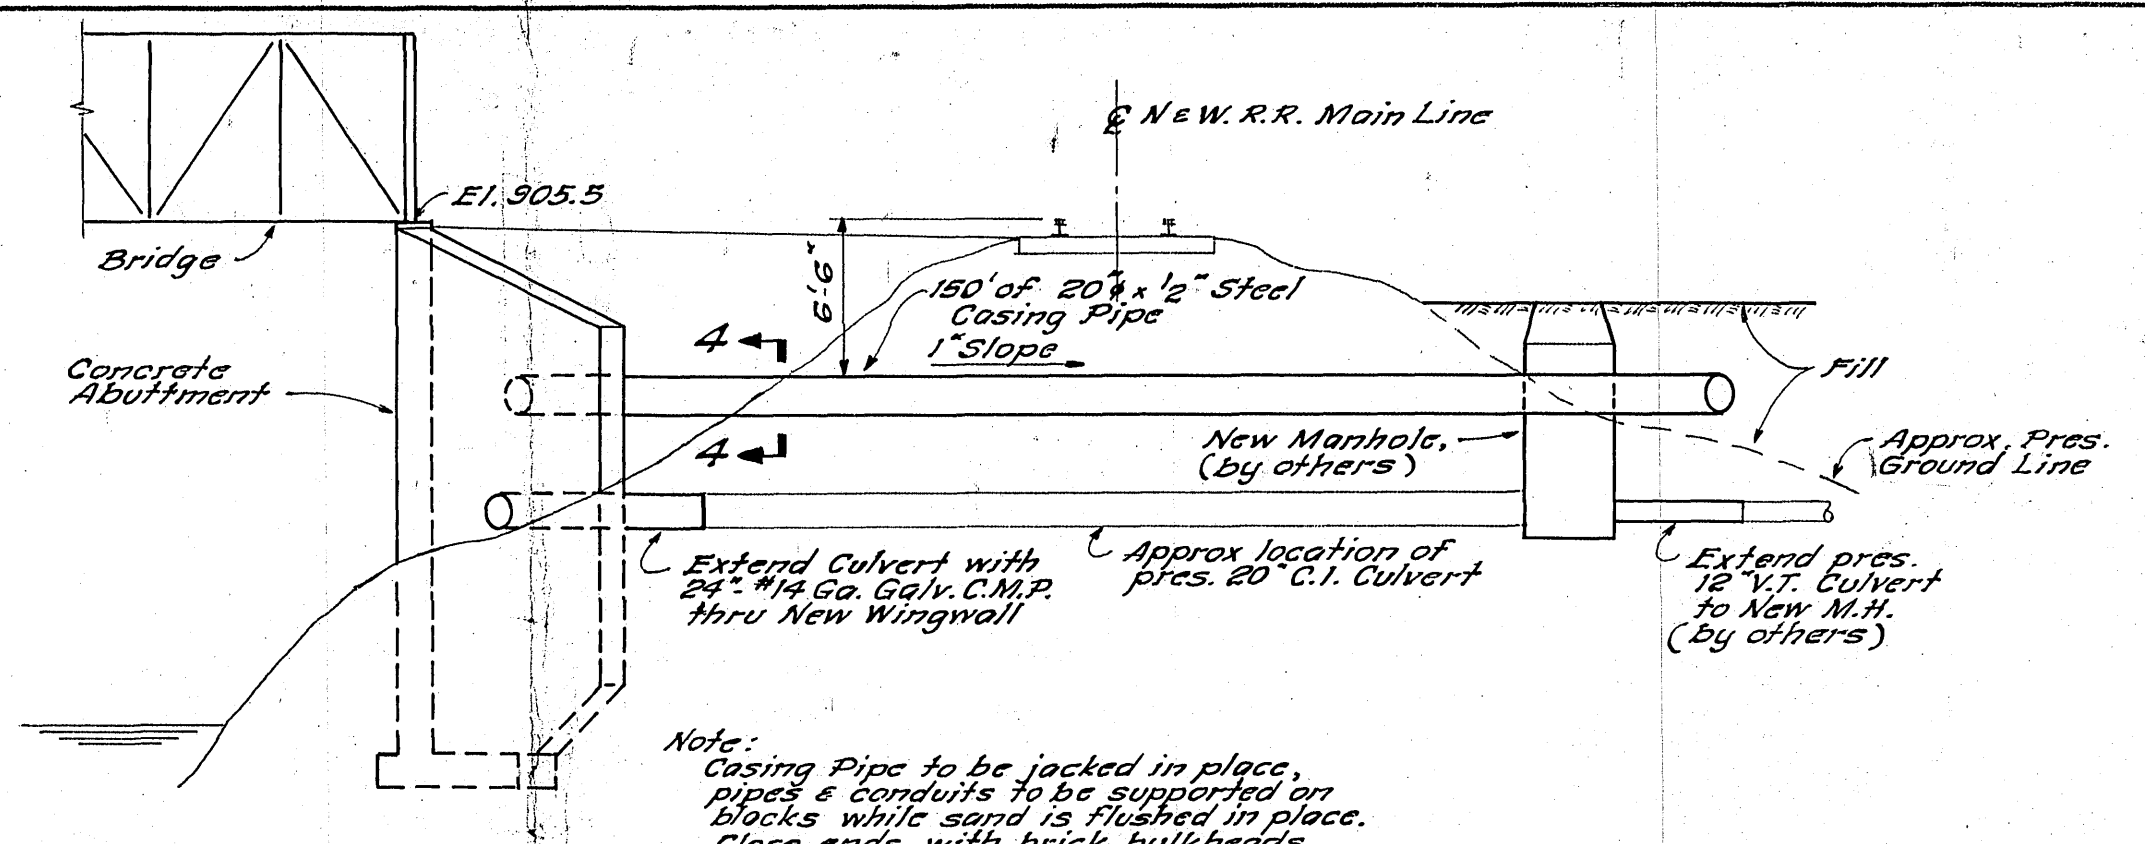


SECTION 3-3
Scale: 1/8" = 1'-0"

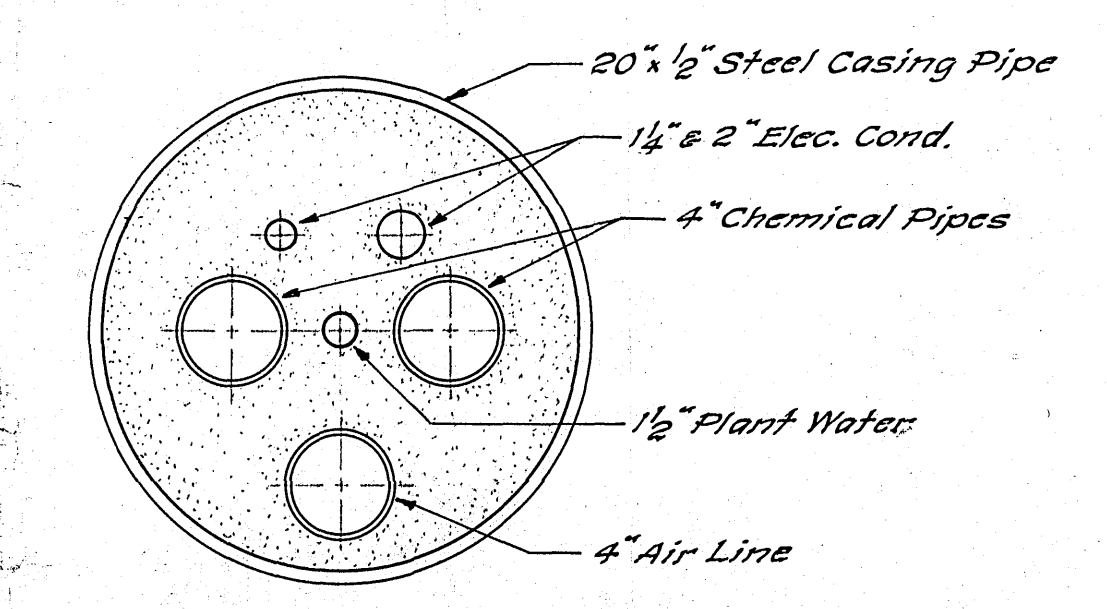

SECTION 4-4
Scale: 1/2" = 1'-0"

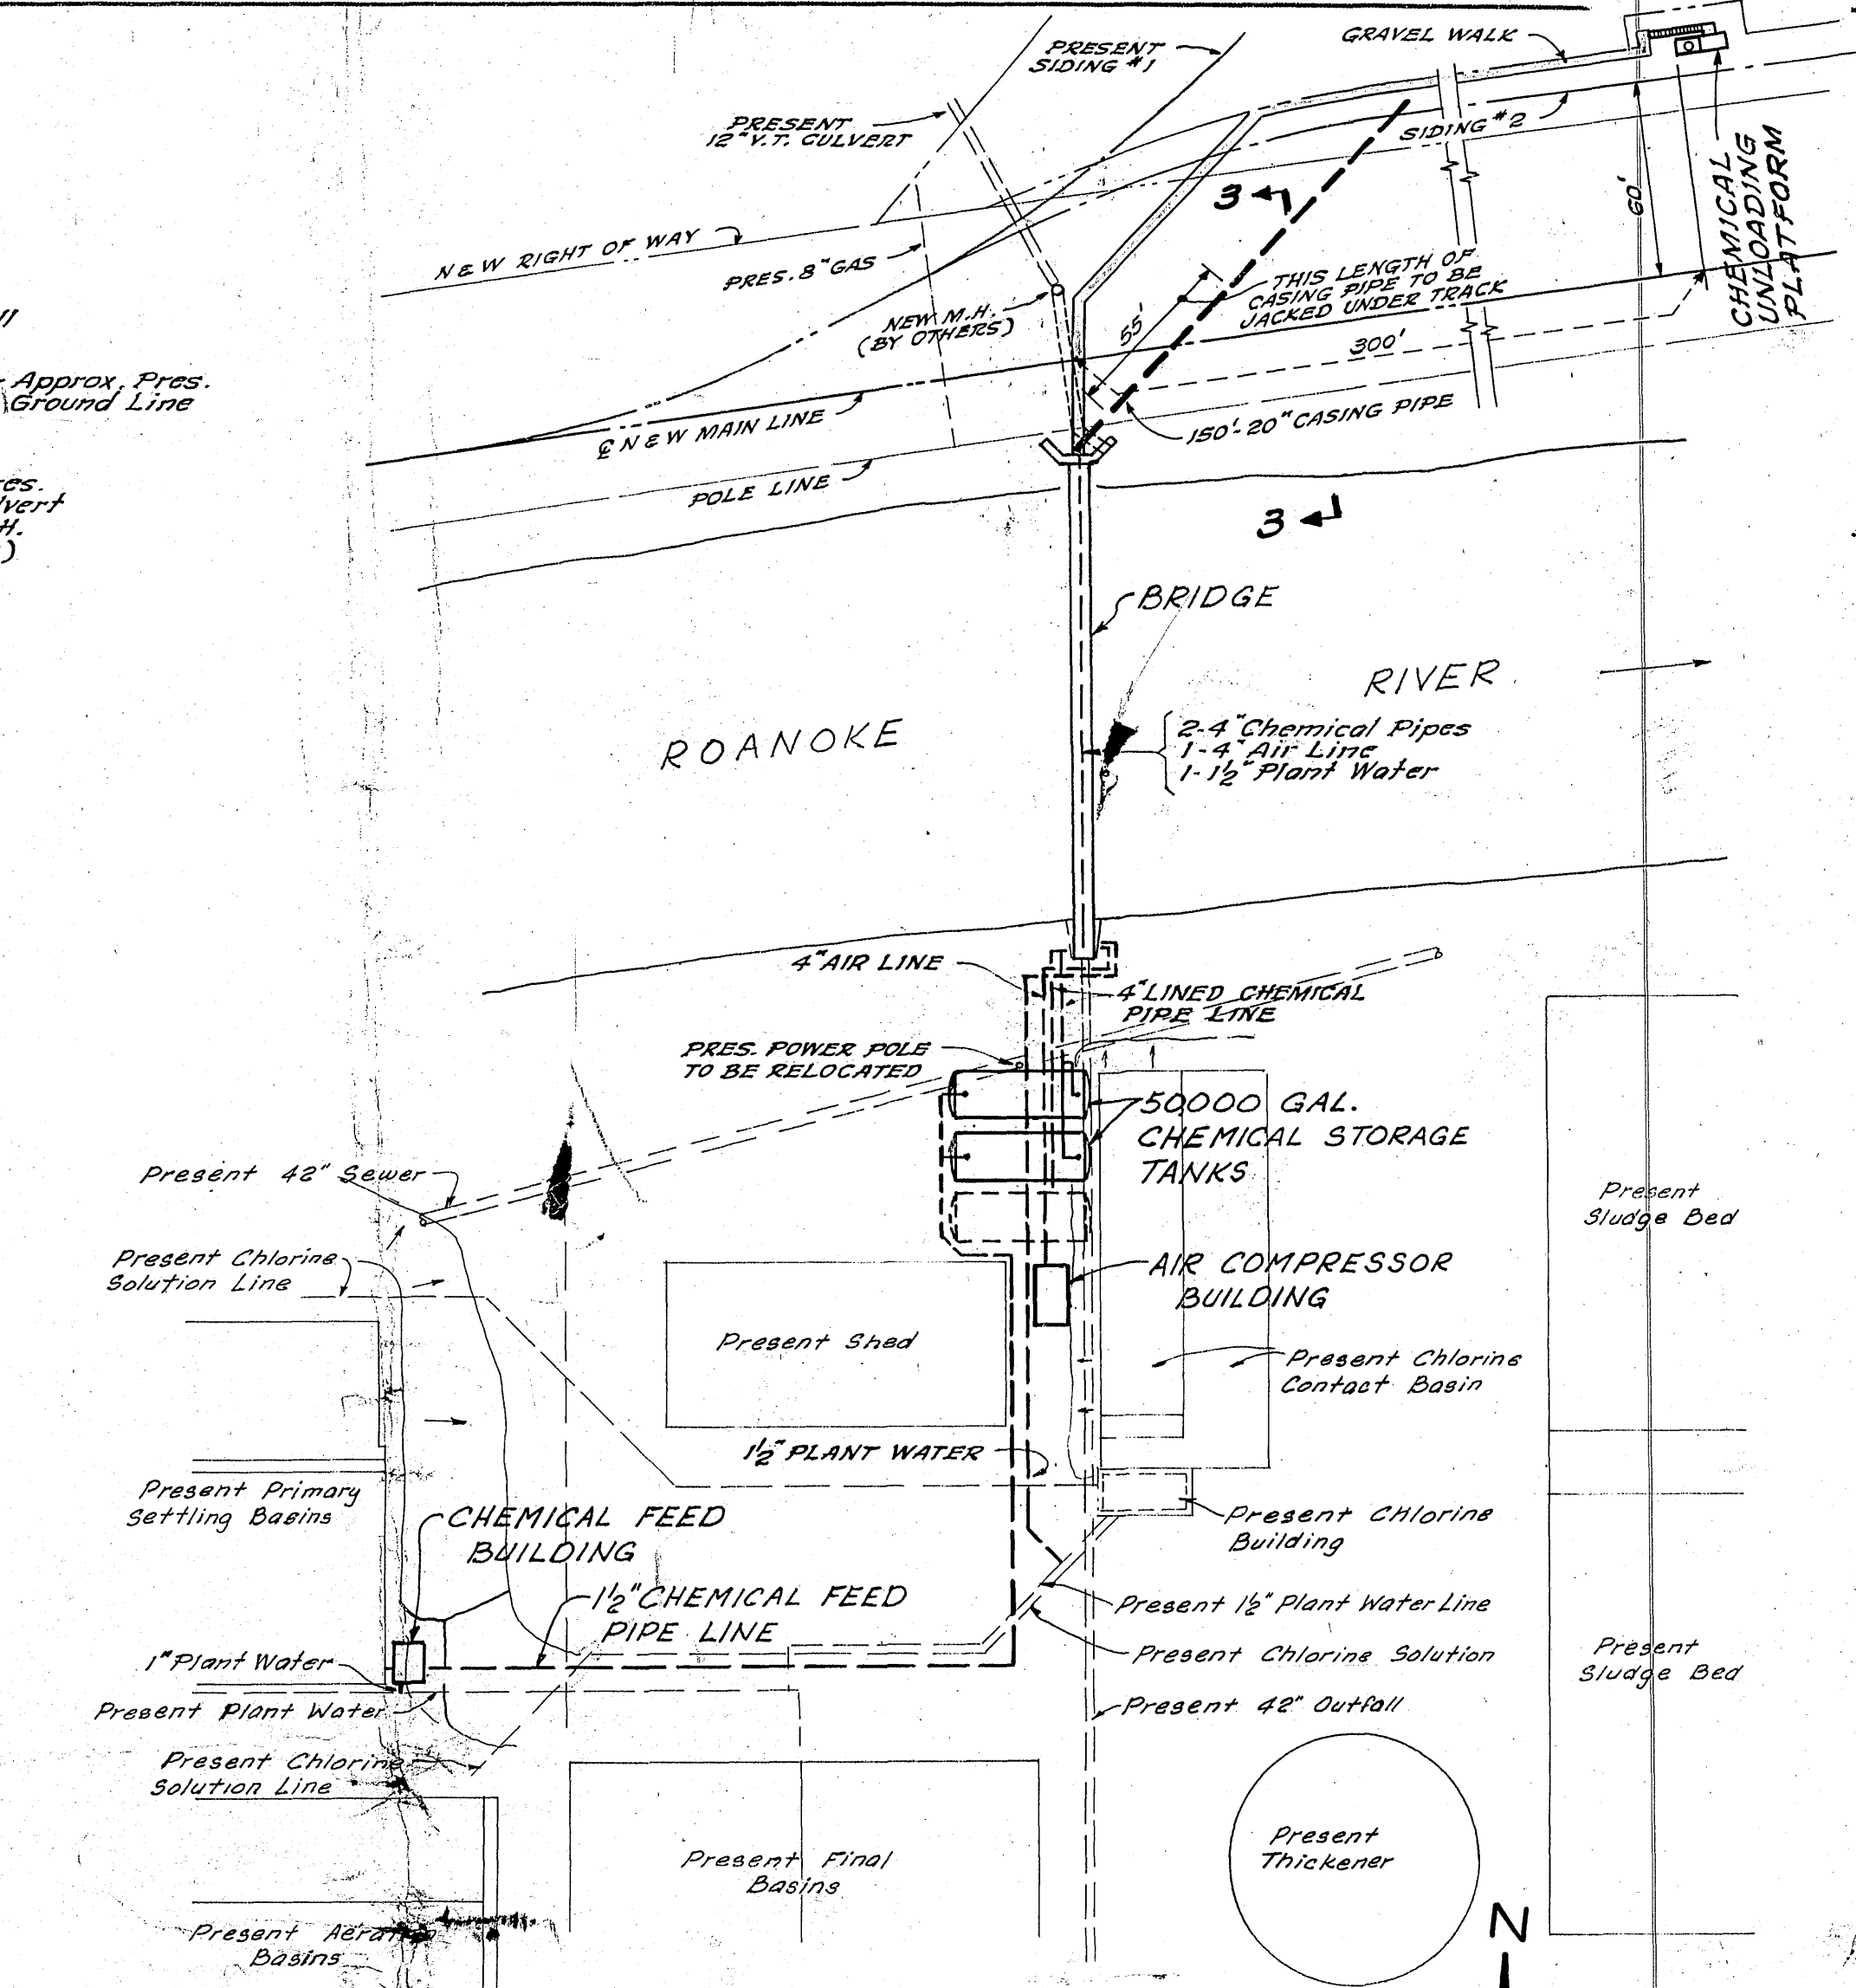

SITE PLAN
Scale: 1" = 50'

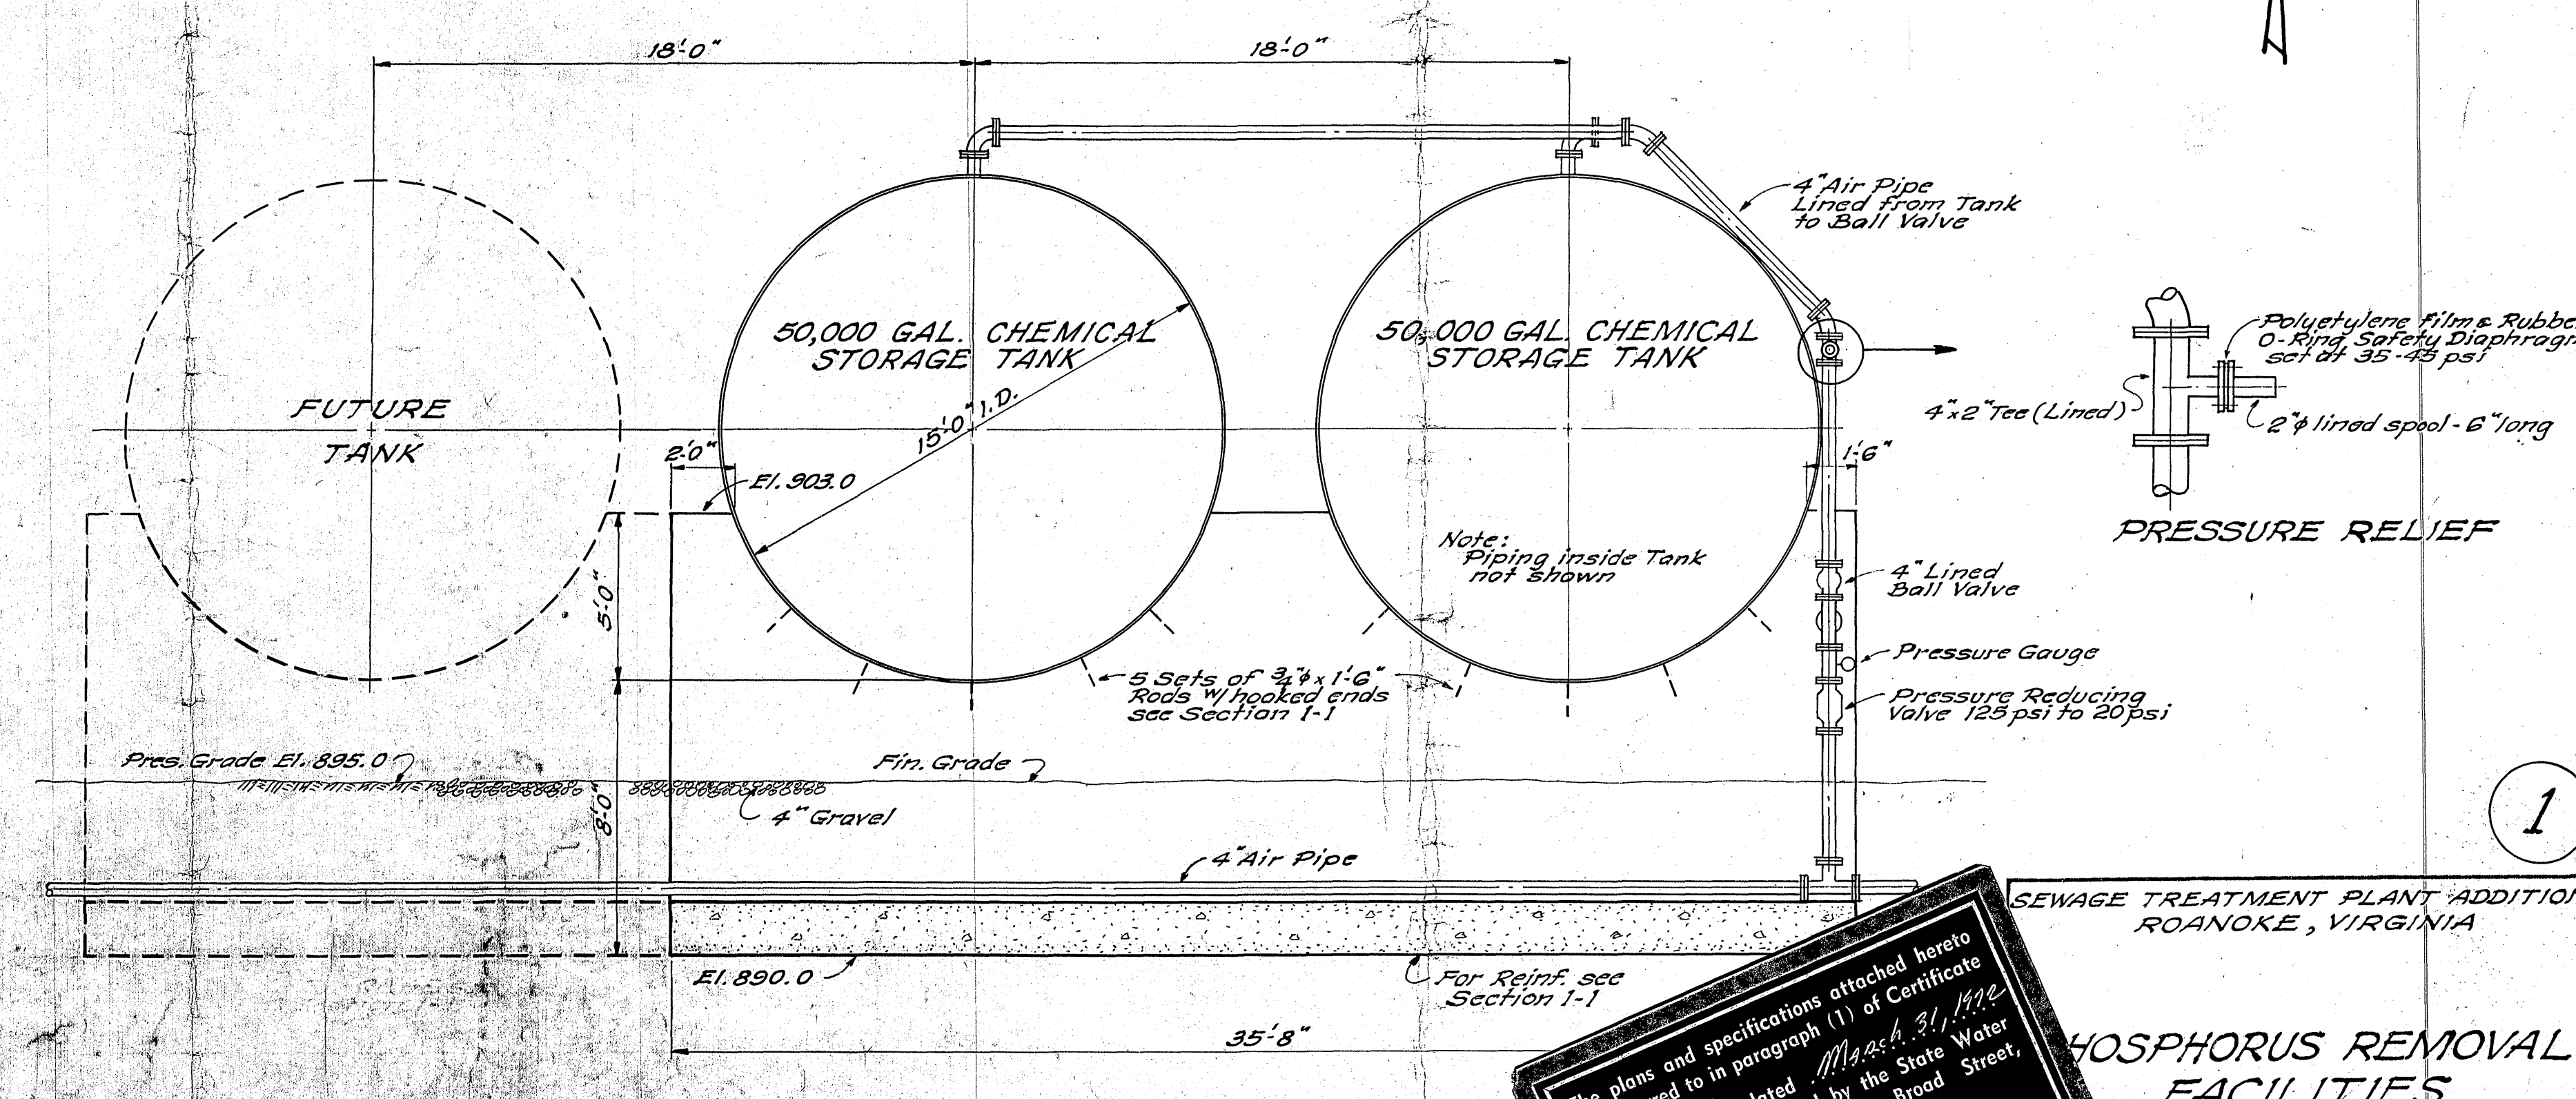

SECTION 2-2
Scale: 1/4" = 1'-0"

The plans and specifications attached hereto are referred to in paragraph (1) of Certificate No. 2236, dated March 31, 1972, and have been approved by the State Water Control Board, 4010 West Broad Street, Richmond, Virginia 23230.

ALP
Executive Secretary

SEWAGE TREATMENT PLANT ADDITIONS
ROANOKE, VIRGINIA

PHOSPHORUS REMOVAL
FACILITIES

ALVORD BURDICK & HOWSON
ENGINEERS
CHICAGO
1972

Revised: March 3, 1972