
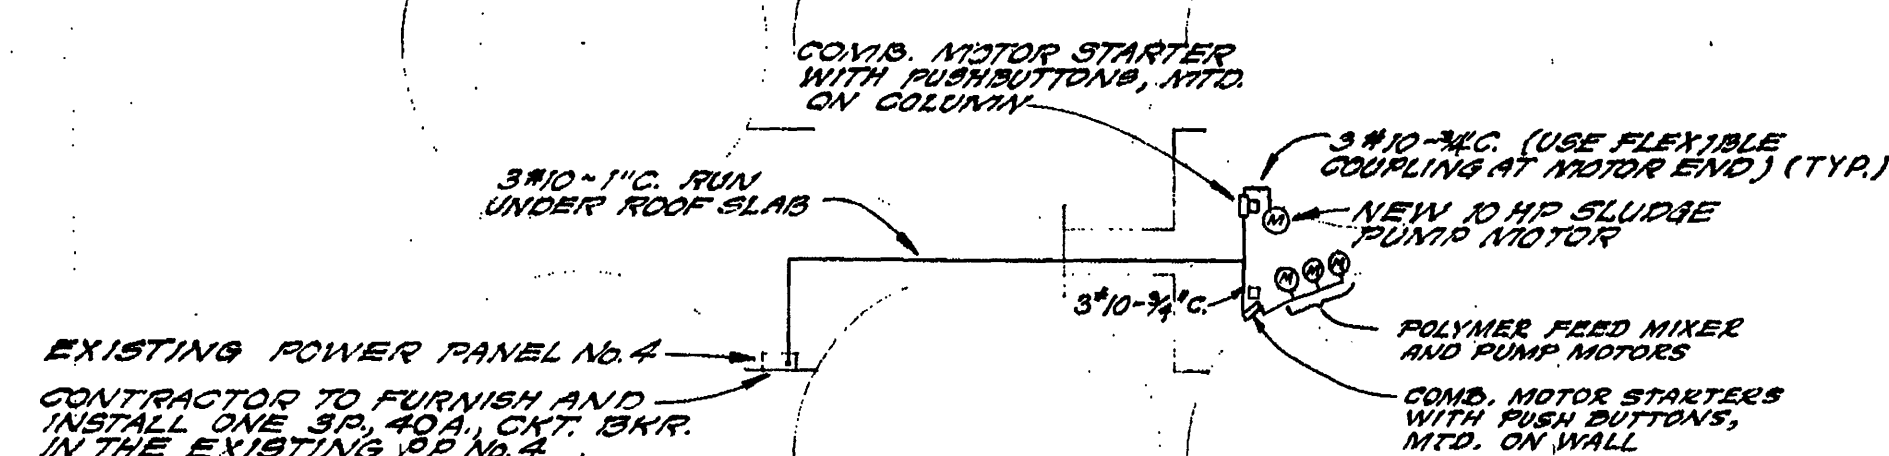
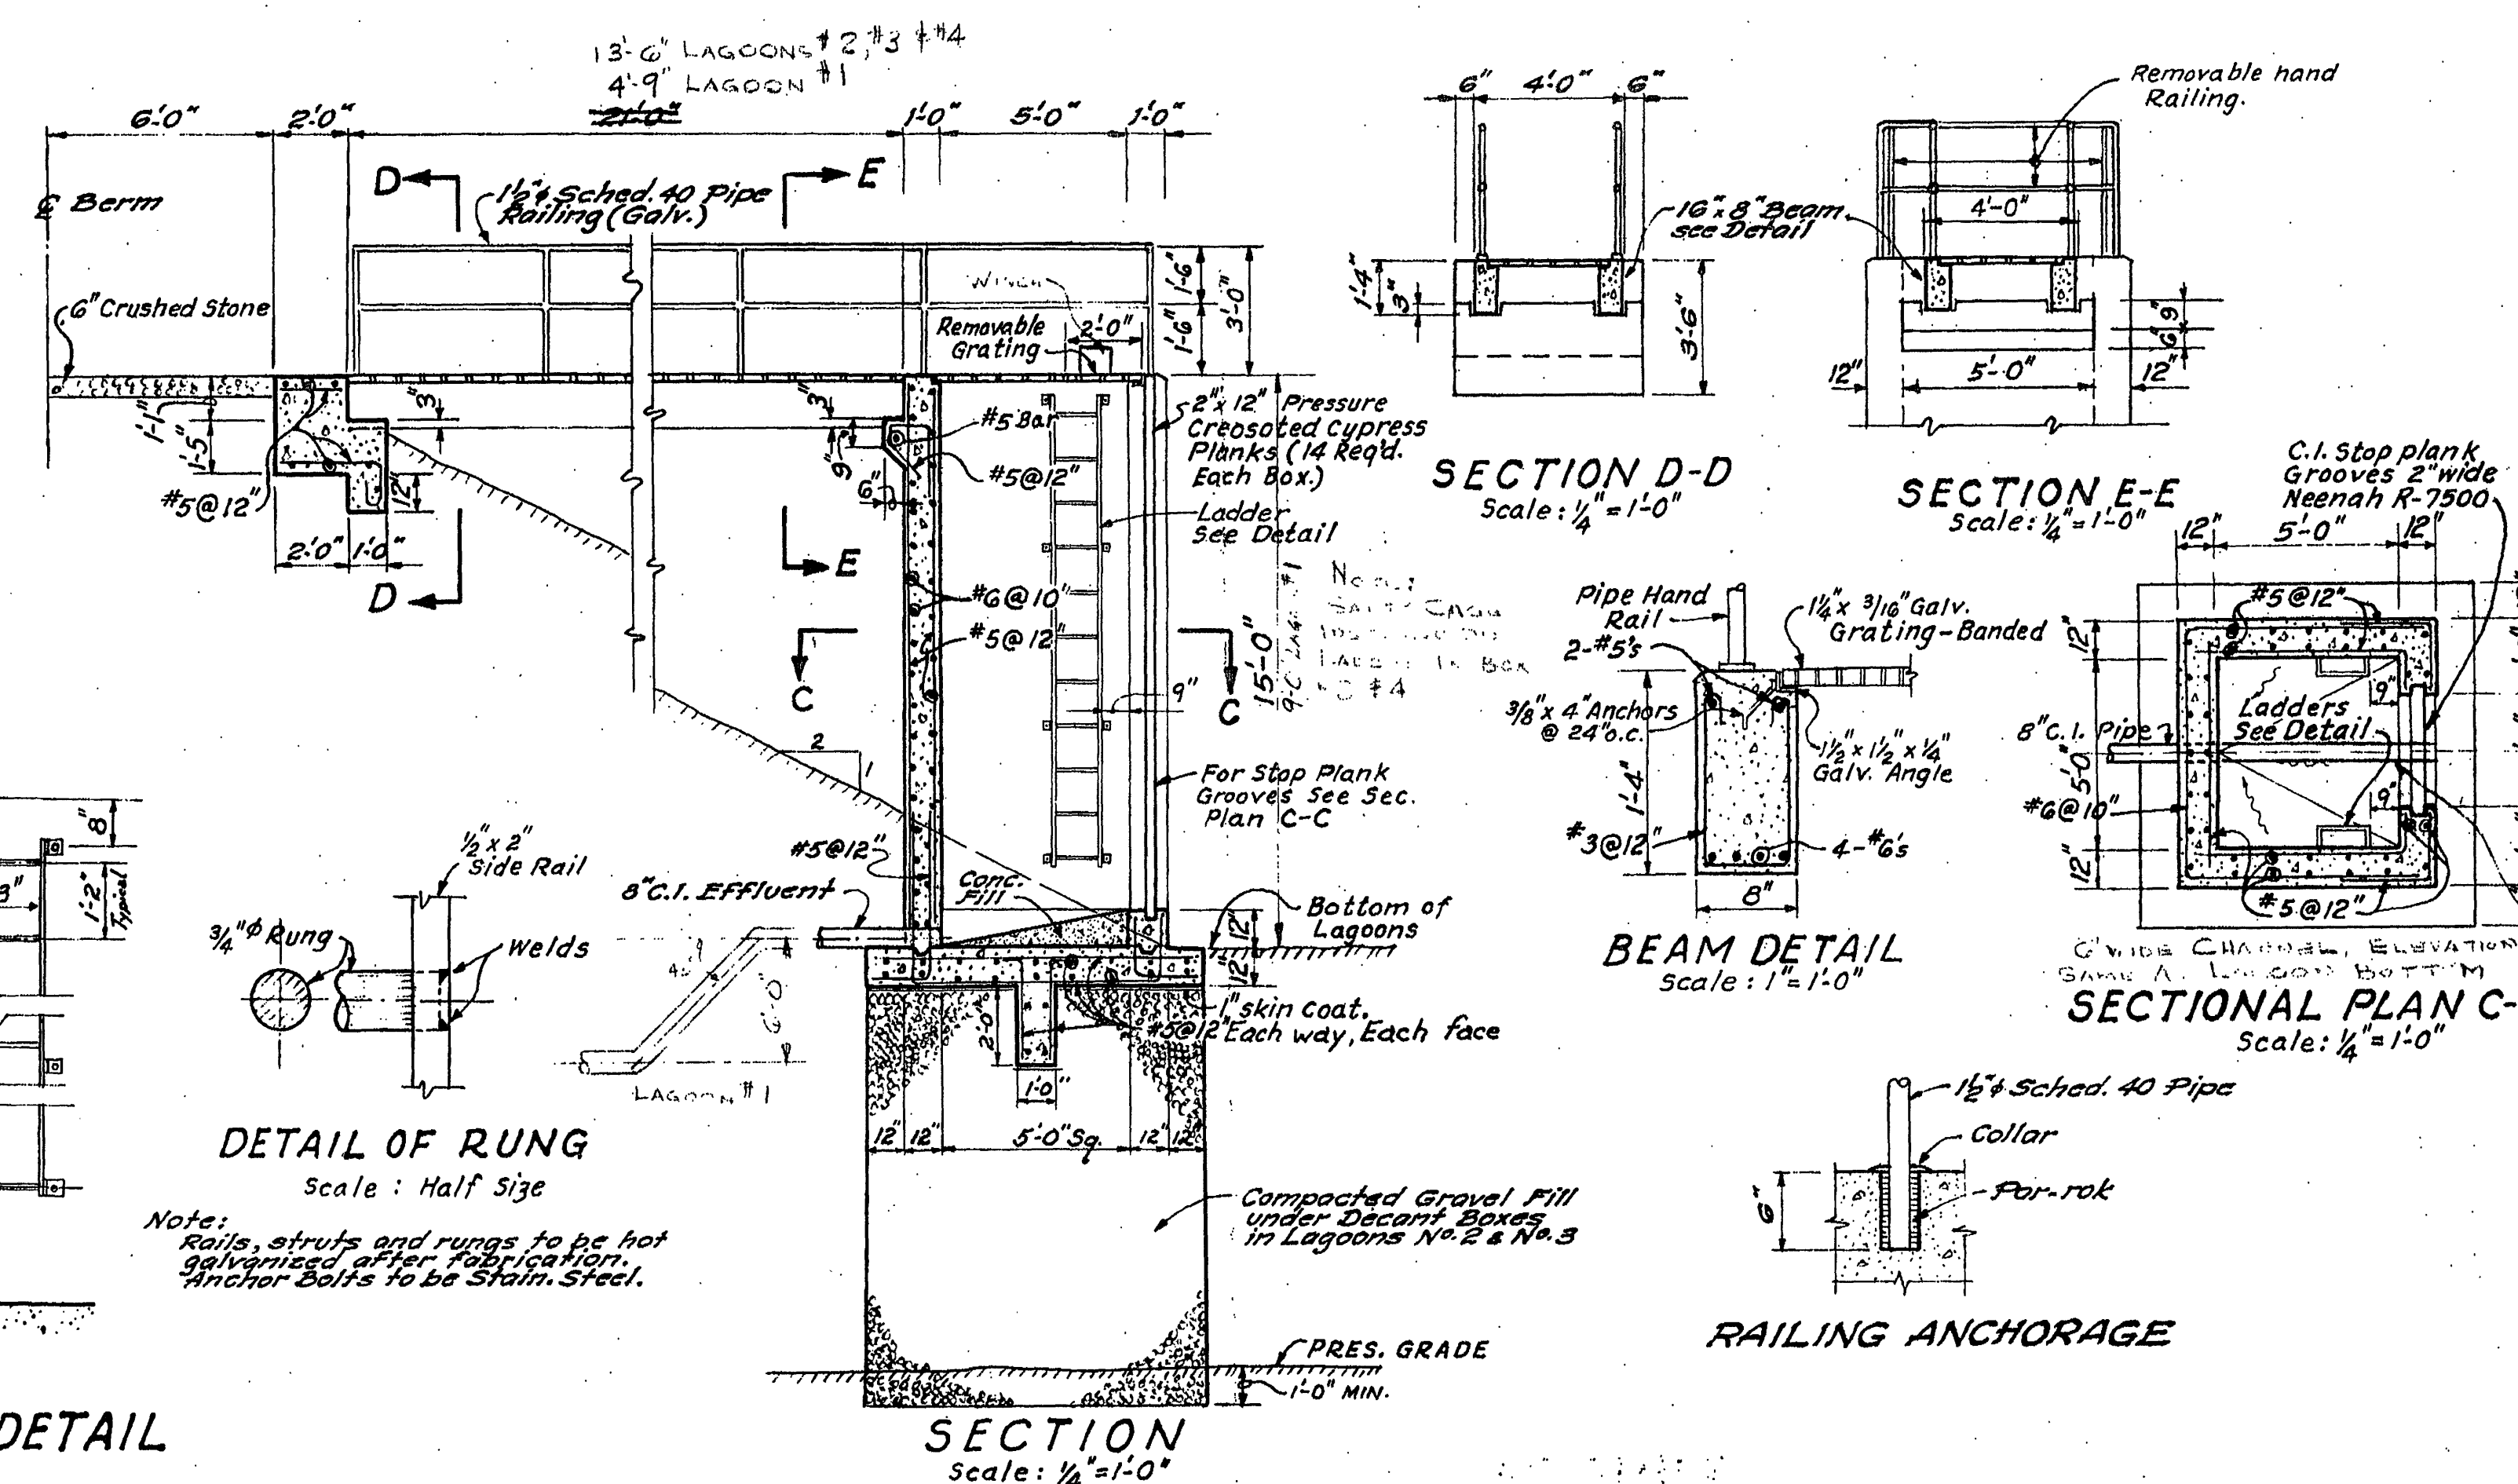
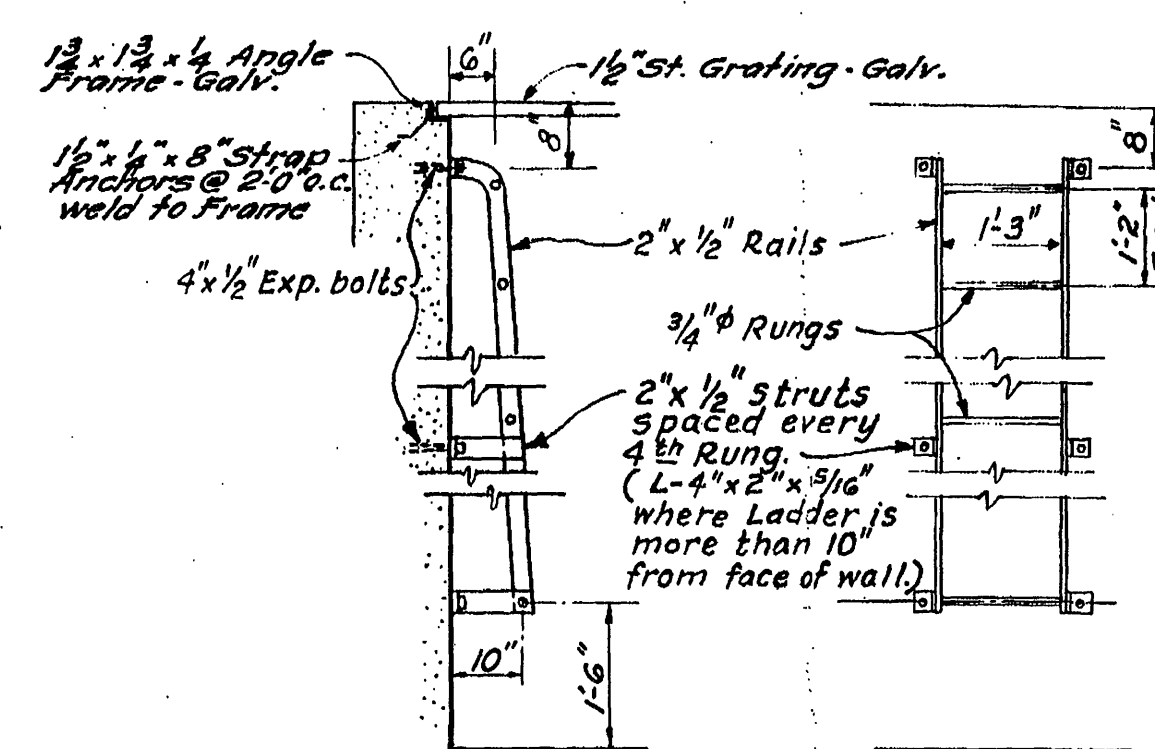
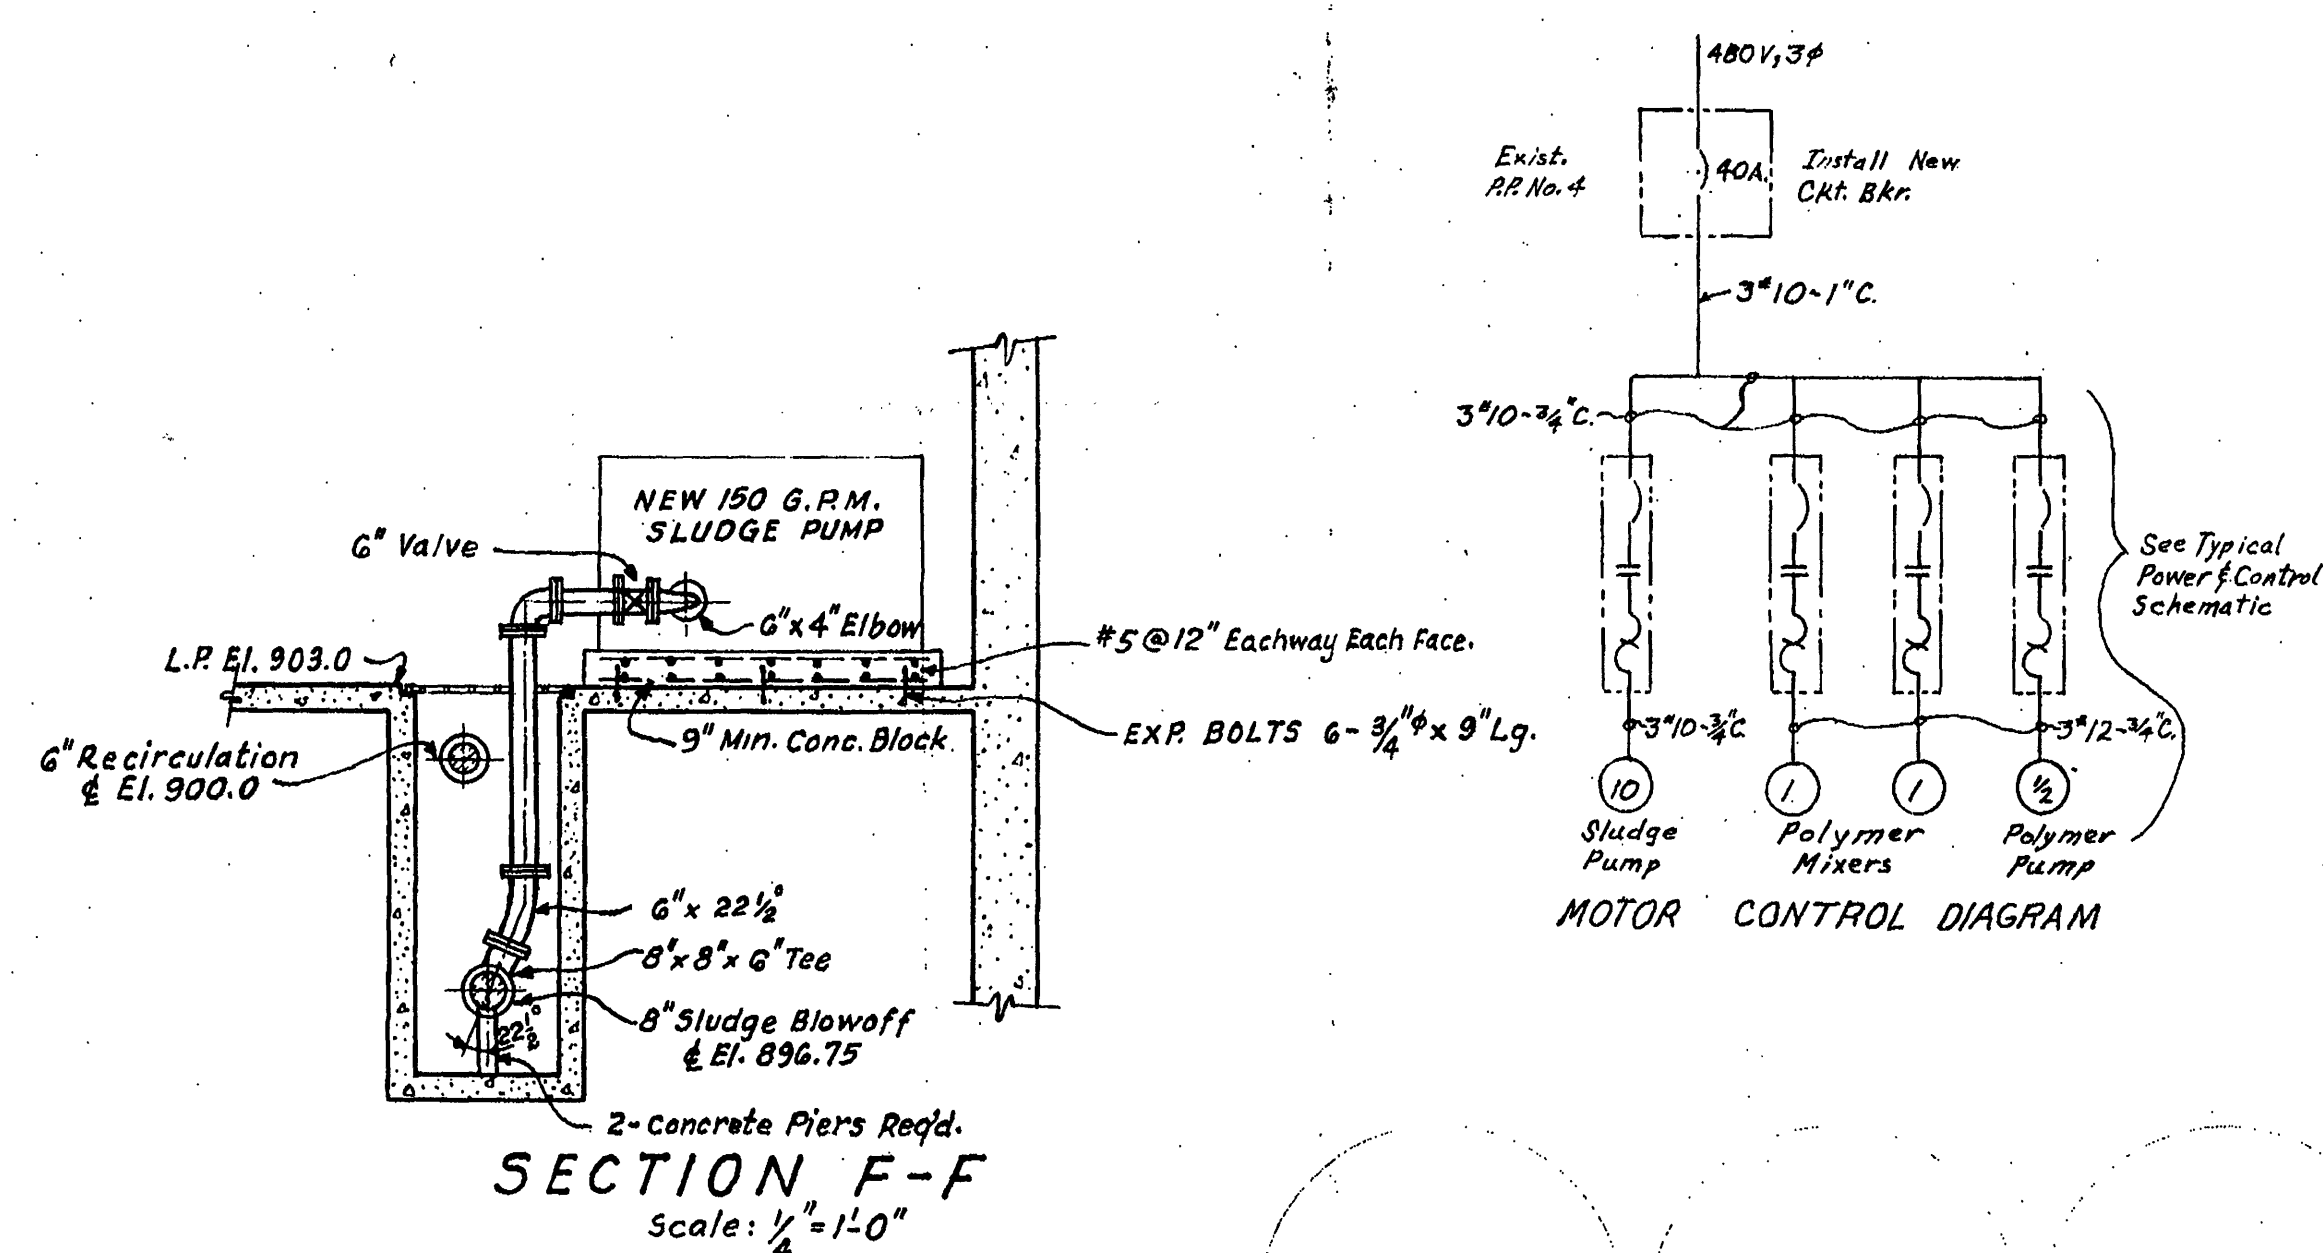
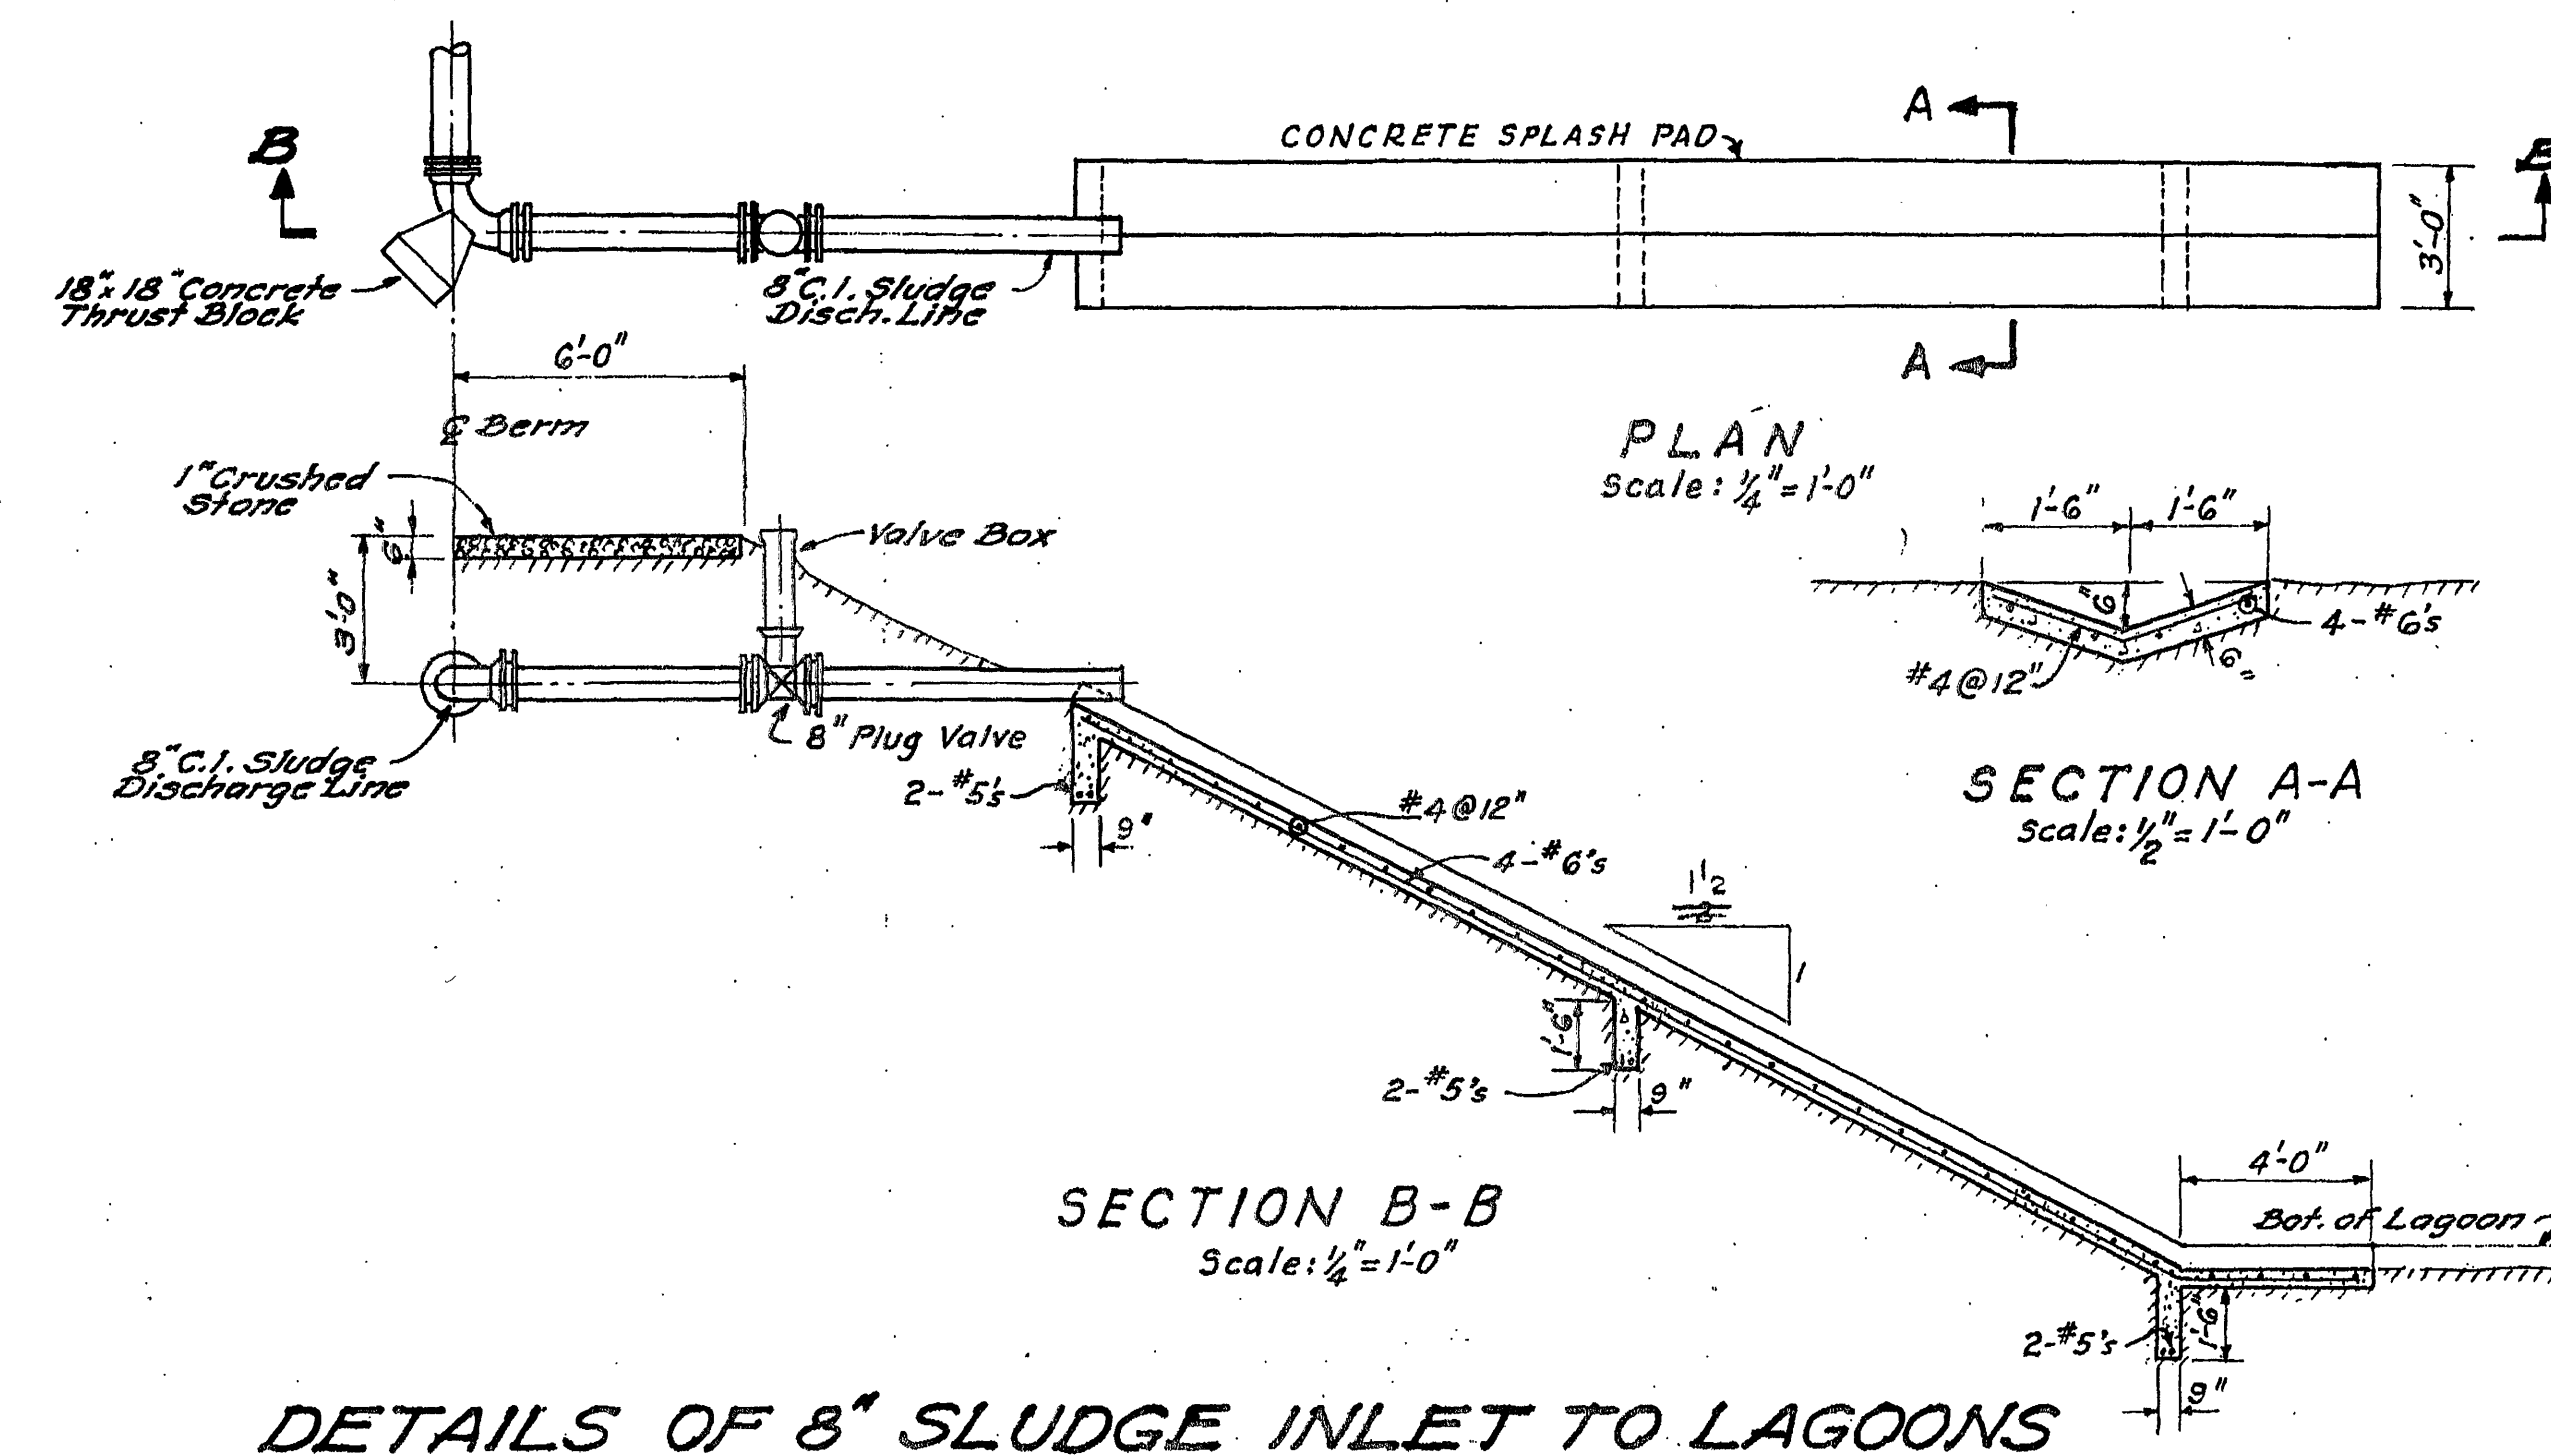


PLAN OF DIGESTER CONTROL HOUSE
Scale: $\frac{1}{8}" = 1'-0"$

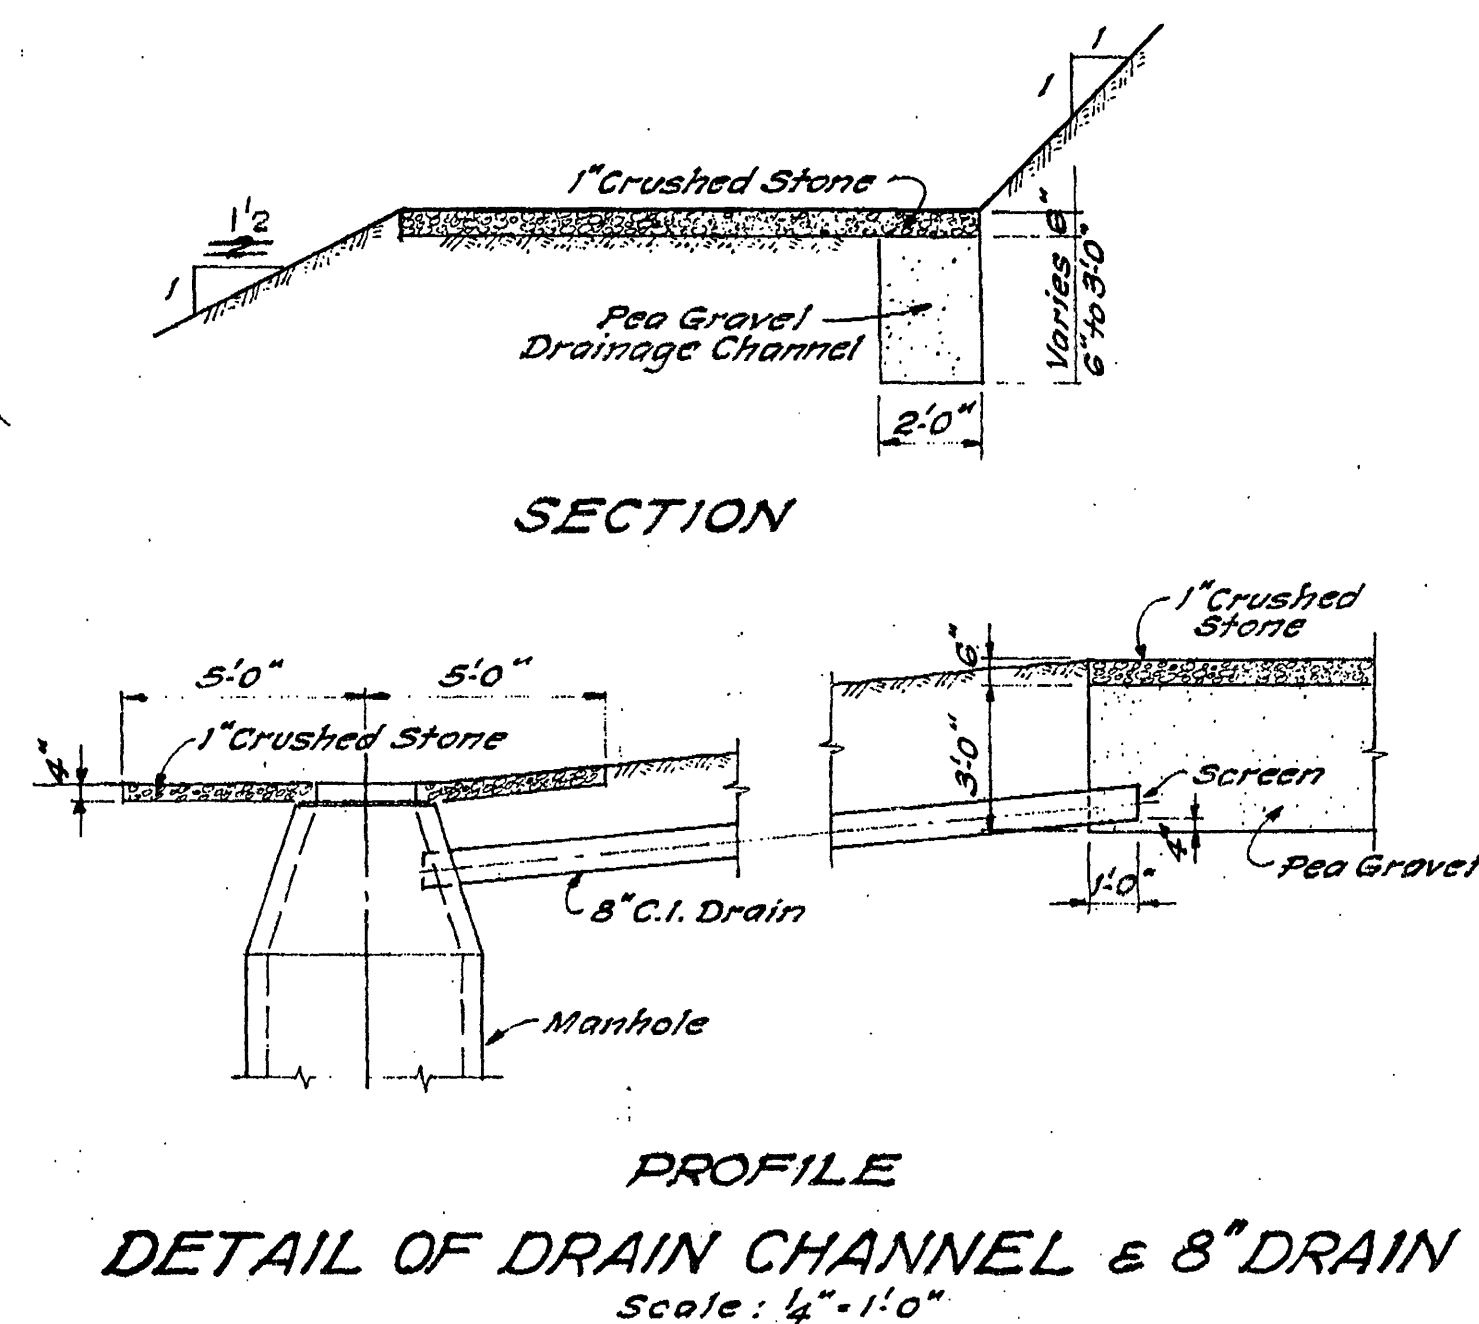


NOTE: ALL ELECTRICAL EQUIPMENT MATERIAL & INSTALLATION SHALL MEET ALL THE CODE REQUIREMENTS FOR CLASS I, GROUP D CLASSIFICATION OF HAZARDOUS LOCATIONS.

ELECTRICAL PLAN
SCALE: 1"=50'

TYPICAL LADDER DETAIL
Scale: $\frac{1}{2}" = 1'-0"$

DETAILS OF DECANT BOX AND ACCESS BRIDGE

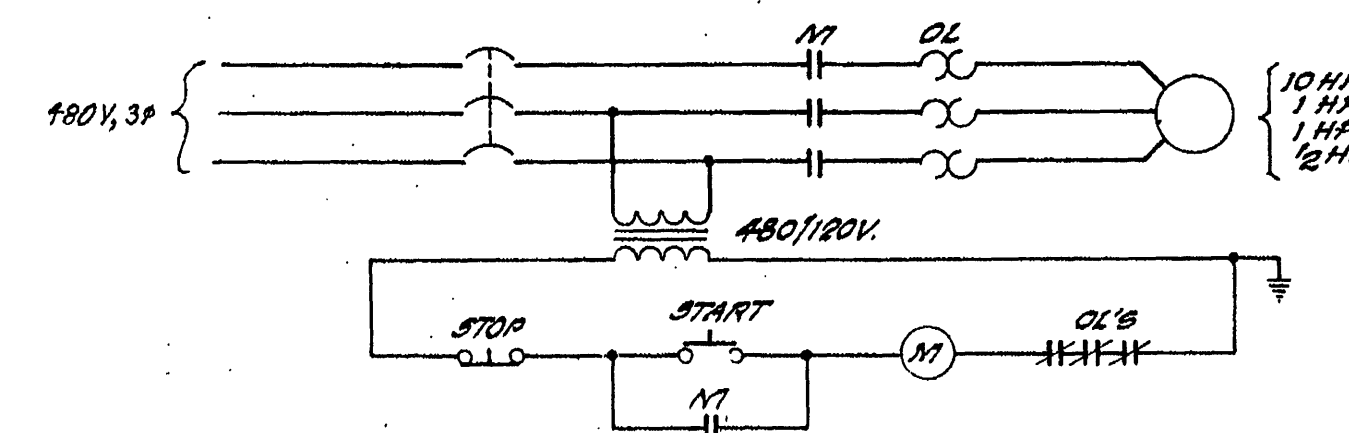

POWER & CONTROL SCHEMATIC
FOR NEW PUMPS & MIXERS
(TYPICAL)

AS BUILT

(4)

Revised: Mar. 3, 1972

ADDITIONS TO SEWAGE TREATMENT PLANT
ROANOKE, VIRGINIA

SLUDGE LAGOONS

ALVORD, BURDICK & HOWSON
ENGINEERS CHICAGO

1972