


Note:
Contractor to check
all existing conditions
& adjust for same.

SCALE:
1"=50'


ROANOKE RIVER

FLOW

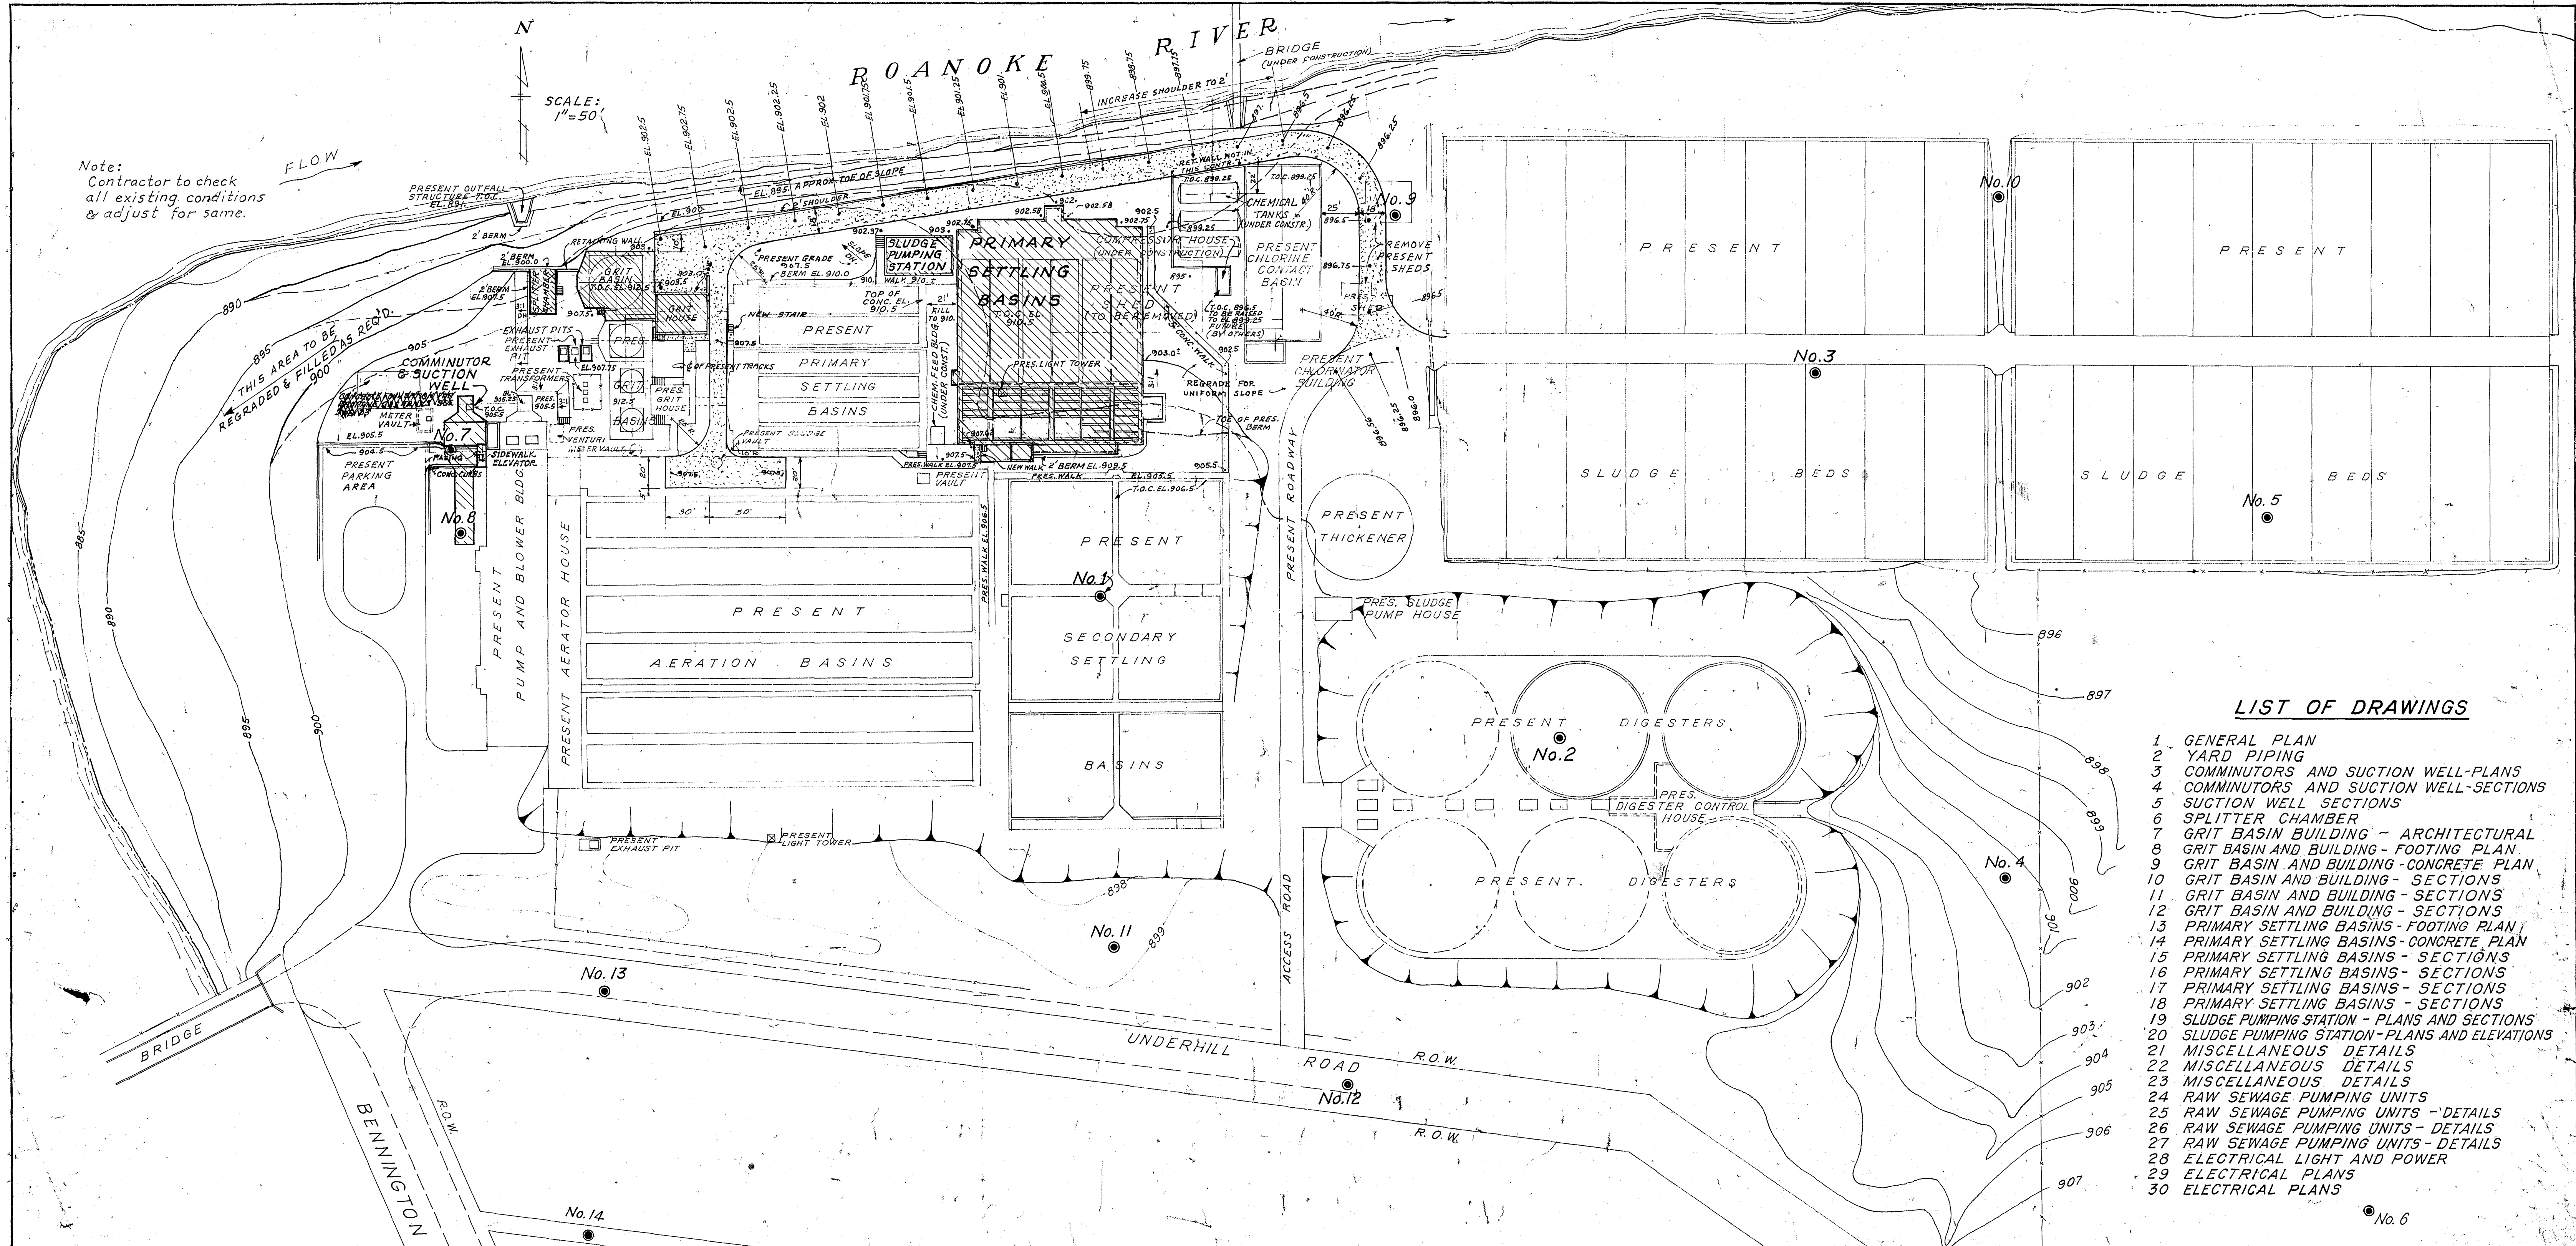

LIST OF DRAWINGS


- 1 GENERAL PLAN
- 2 YARD PIPING
- 3 COMMUNOTORS AND SUCTION WELL-PLANS
- 4 COMMUNOTORS AND SUCTION WELL-SECTIONS
- 5 SUCTION WELL SECTIONS
- 6 SPLITTER CHAMBER
- 7 GRIT BASIN BUILDING - ARCHITECTURAL
- 8 GRIT BASIN AND BUILDING - FOOTING PLAN
- 9 GRIT BASIN AND BUILDING - CONCRETE PLAN
- 10 GRIT BASIN AND BUILDING - SECTIONS
- 11 GRIT BASIN AND BUILDING - SECTIONS
- 12 GRIT BASIN AND BUILDING - SECTIONS
- 13 PRIMARY SETTLING BASINS - FOOTING PLAN
- 14 PRIMARY SETTLING BASINS - CONCRETE PLAN
- 15 PRIMARY SETTLING BASINS - SECTIONS
- 16 PRIMARY SETTLING BASINS - SECTIONS
- 17 PRIMARY SETTLING BASINS - SECTIONS
- 18 PRIMARY SETTLING BASINS - SECTIONS
- 19 SLUDGE PUMPING STATION - PLANS AND SECTIONS
- 20 SLUDGE PUMPING STATION - PLANS AND ELEVATIONS
- 21 MISCELLANEOUS DETAILS
- 22 MISCELLANEOUS DETAILS
- 23 MISCELLANEOUS DETAILS
- 24 RAW SEWAGE PUMPING UNITS
- 25 RAW SEWAGE PUMPING UNITS - DETAILS
- 26 RAW SEWAGE PUMPING UNITS - DETAILS
- 27 RAW SEWAGE PUMPING UNITS - DETAILS
- 28 ELECTRICAL LIGHT AND POWER
- 29 ELECTRICAL PLANS
- 30 ELECTRICAL PLANS

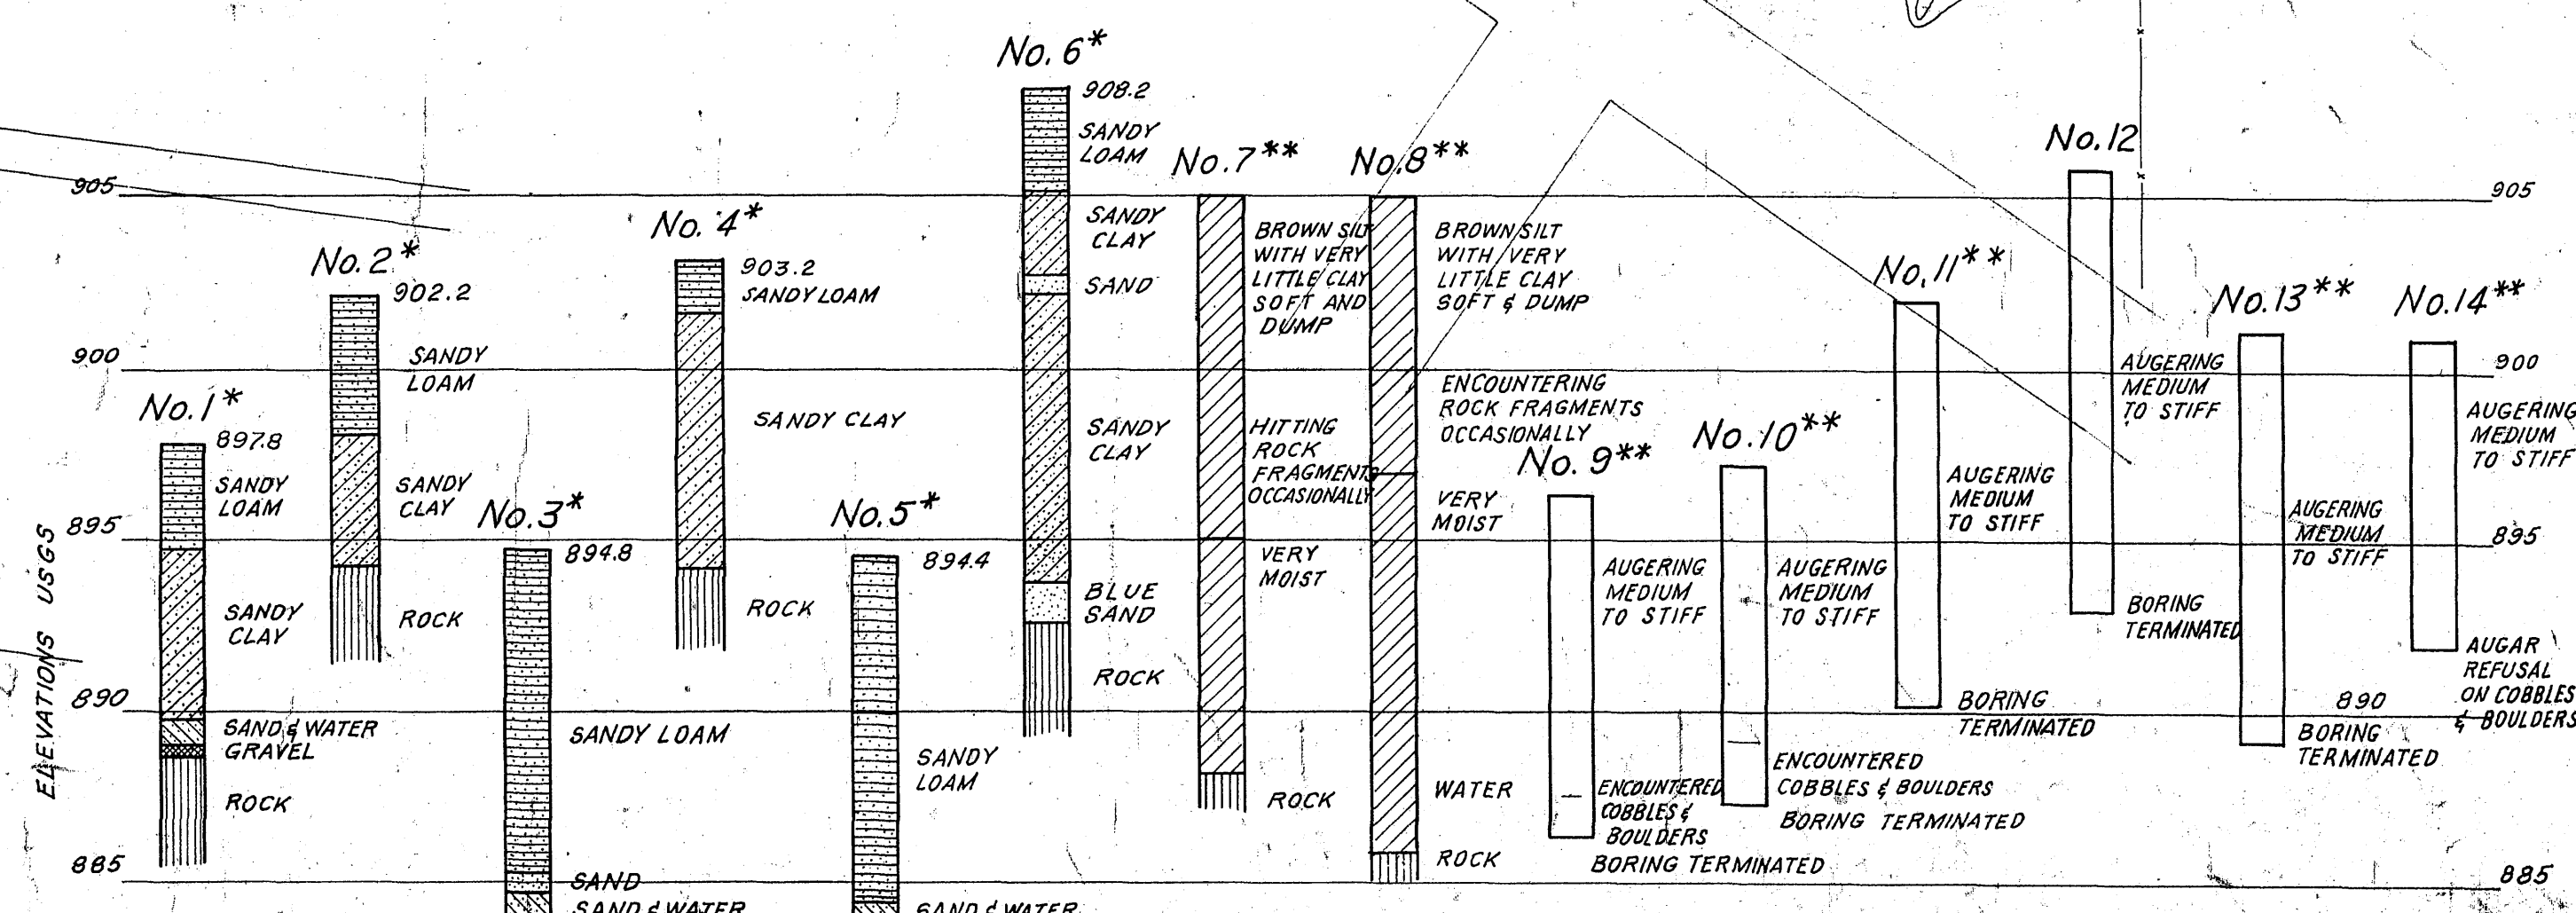

* 1950 BORINGS
** 1972 BORINGS BY PITTSBURG
TESTING LABORATORY

LOG of TEST BORINGS

AS BUILT

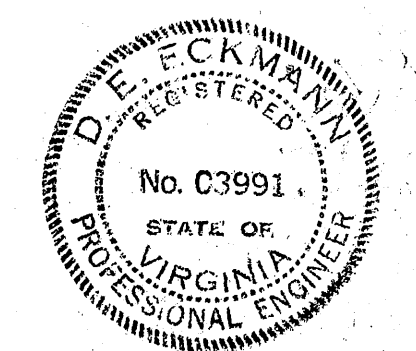

CONTR. C

ADDITIONS TO SEWAGE TREATMENT PLANT
ROANOKE, VIRGINIA

GENERAL PLAN

ALYORD, BURDICK & HOWSON
ENGINEERS CHICAGO

1973