



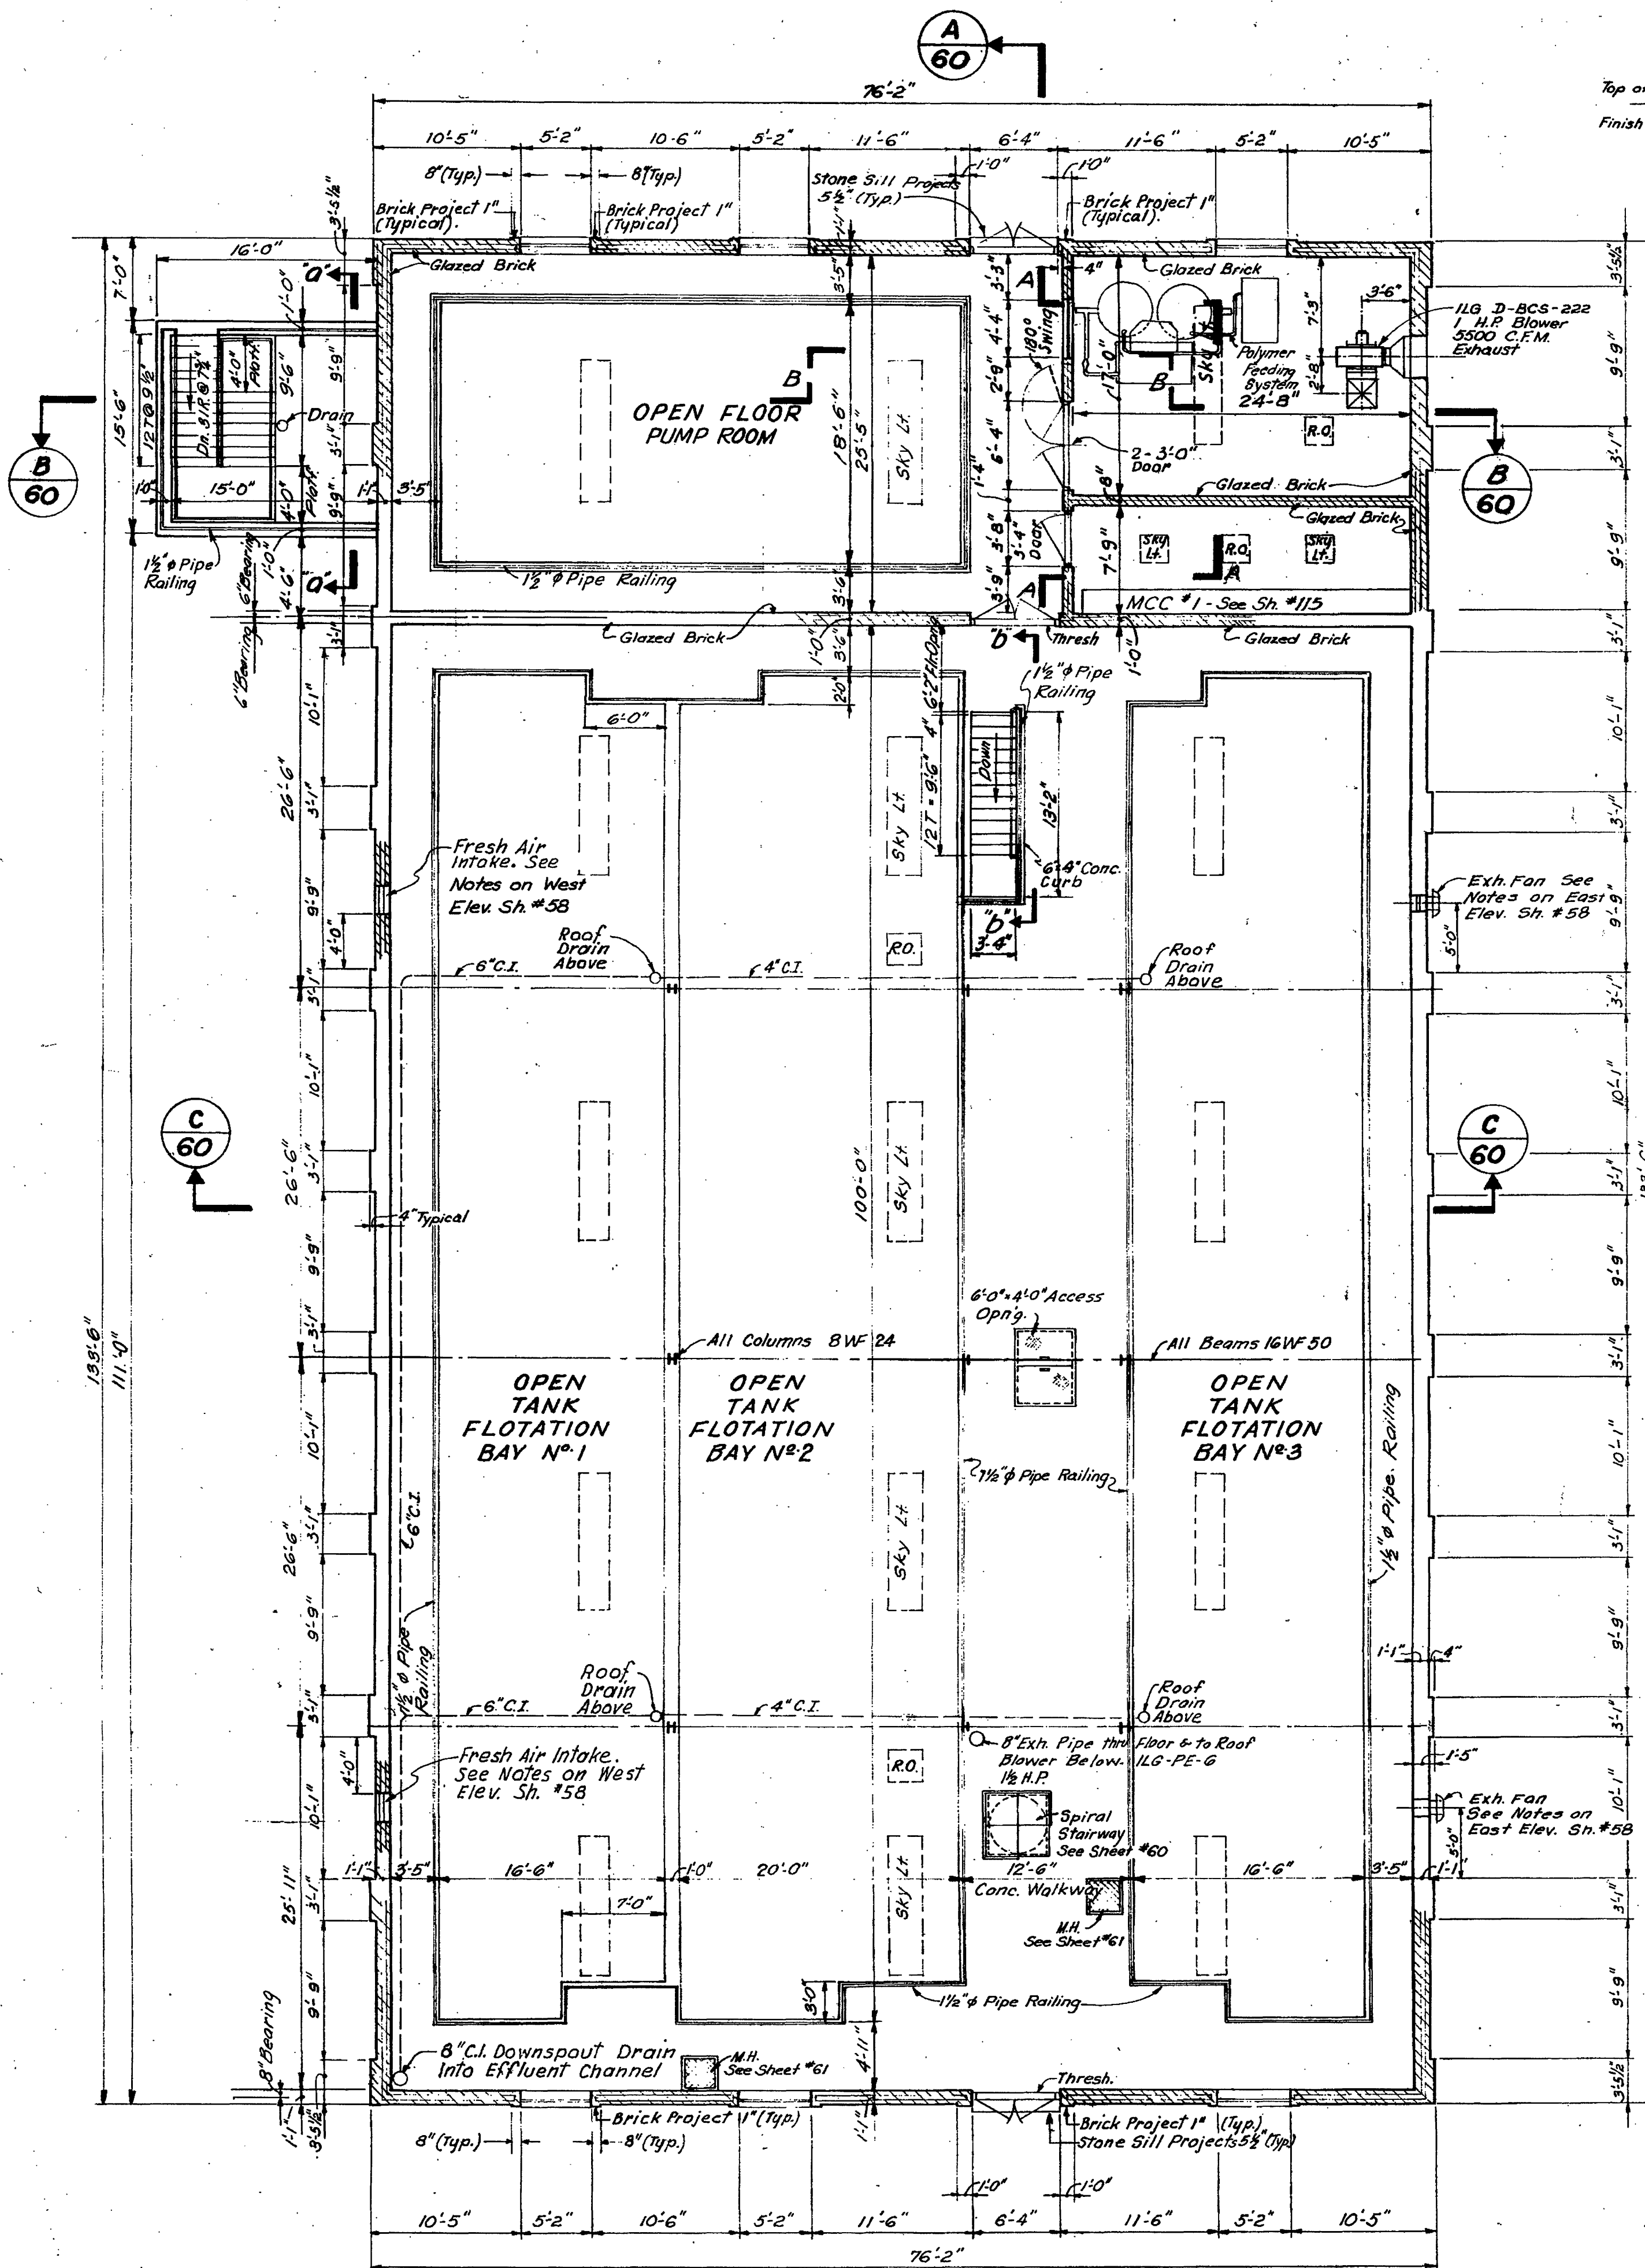


FLOOR PLAN
SCALE: 1/8" = 1'-0"

- NOTES.
1. For Heating Plan see Sheet No. 57
 2. For Electrical Equipment & Lighting Plan See Sheet No. 115.

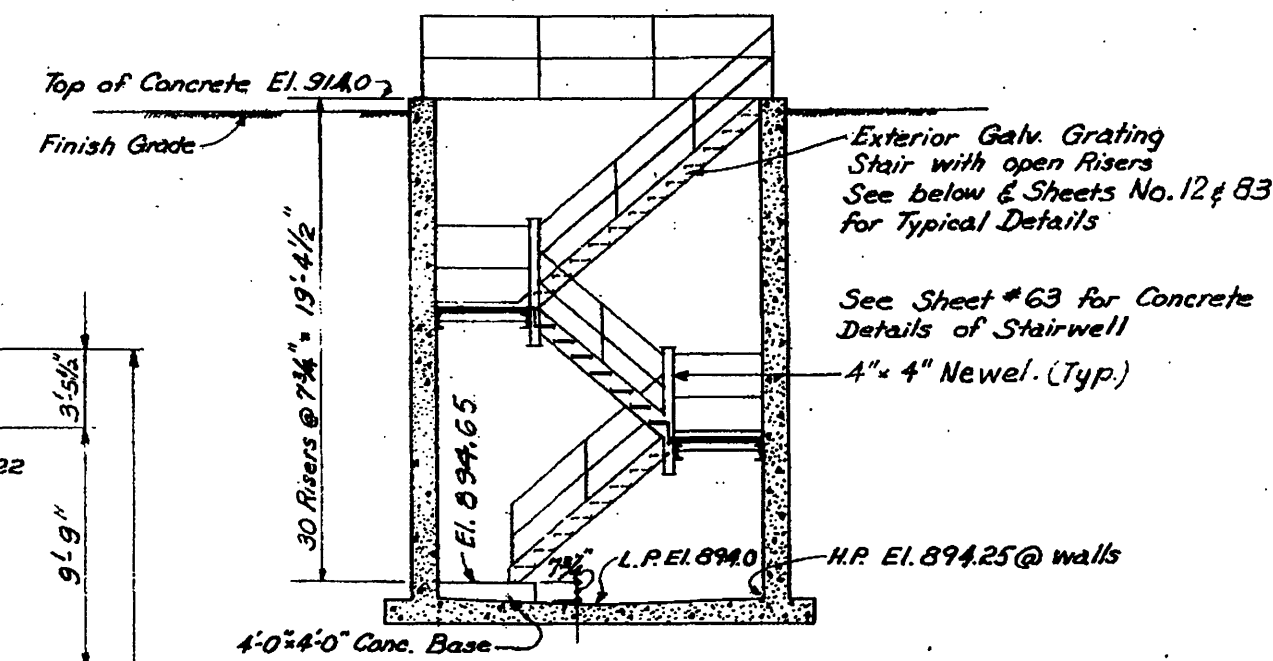


SECTION A-A

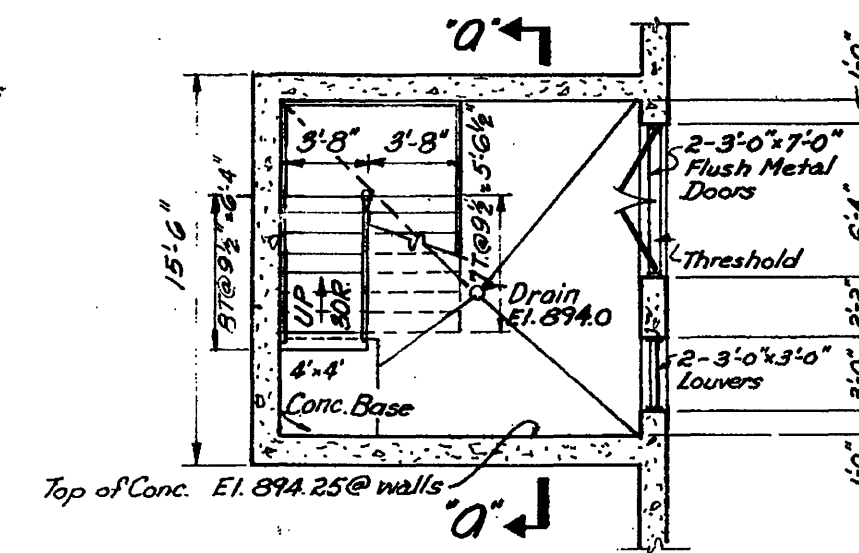


PLAN
(Lower Level)

**EXTERIOR STAIRWAY
@ AREA WELL**
SCALE: 1/8" = 1'-0"

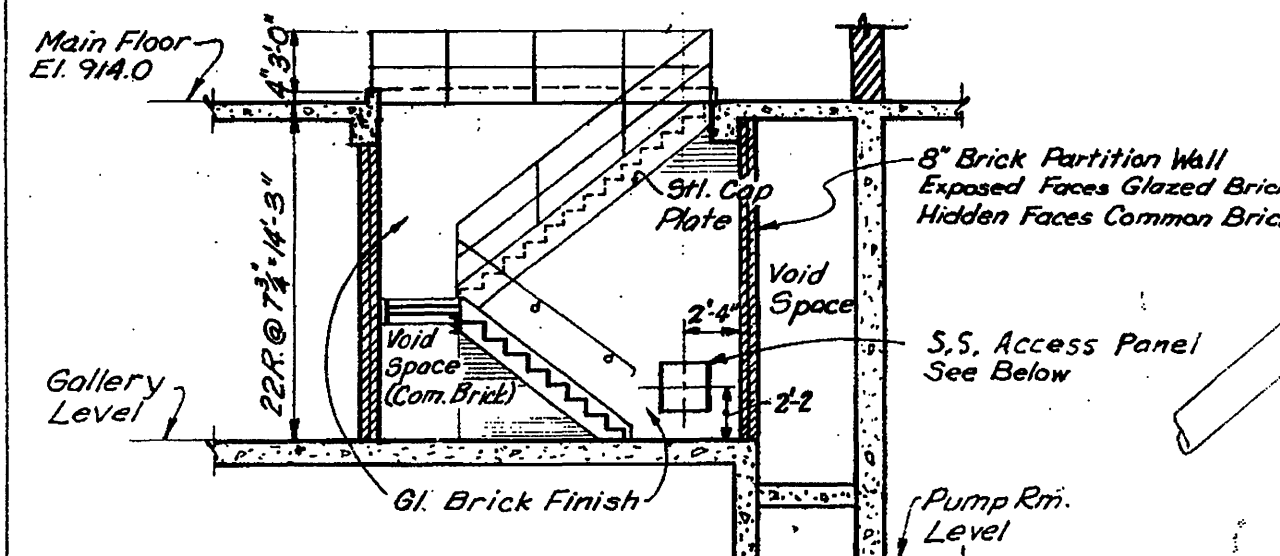


SECTION B-B

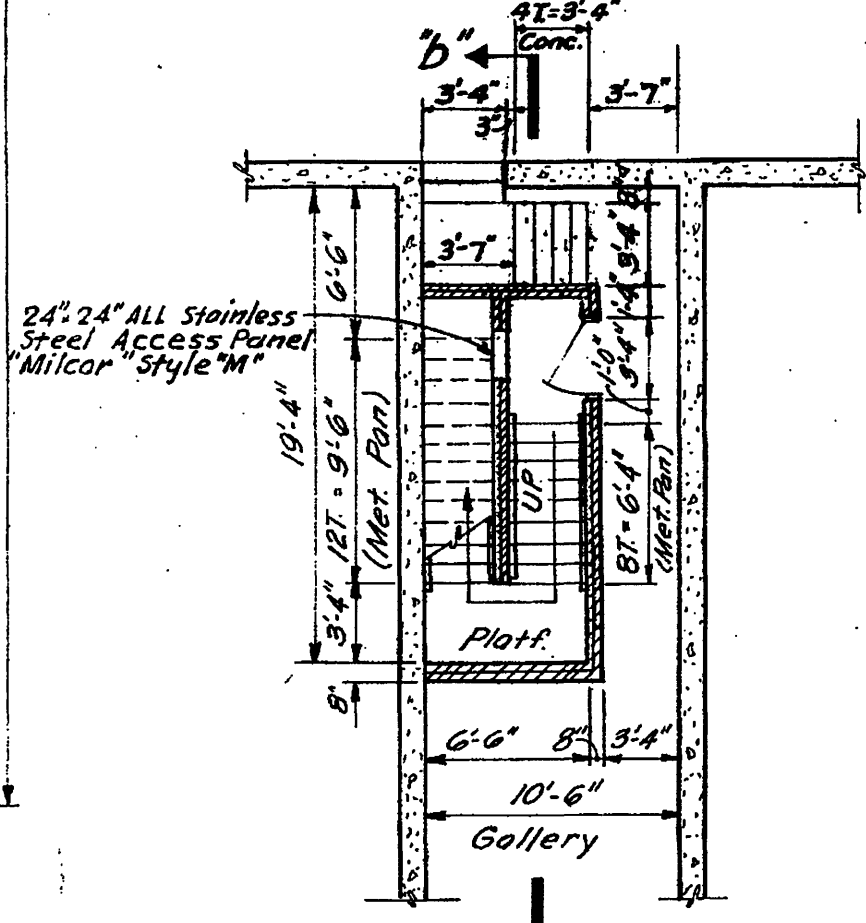


PLAN
(Lower Level)


INTERIOR STAIRWELL
SCALE: 1/8" = 1'-0"

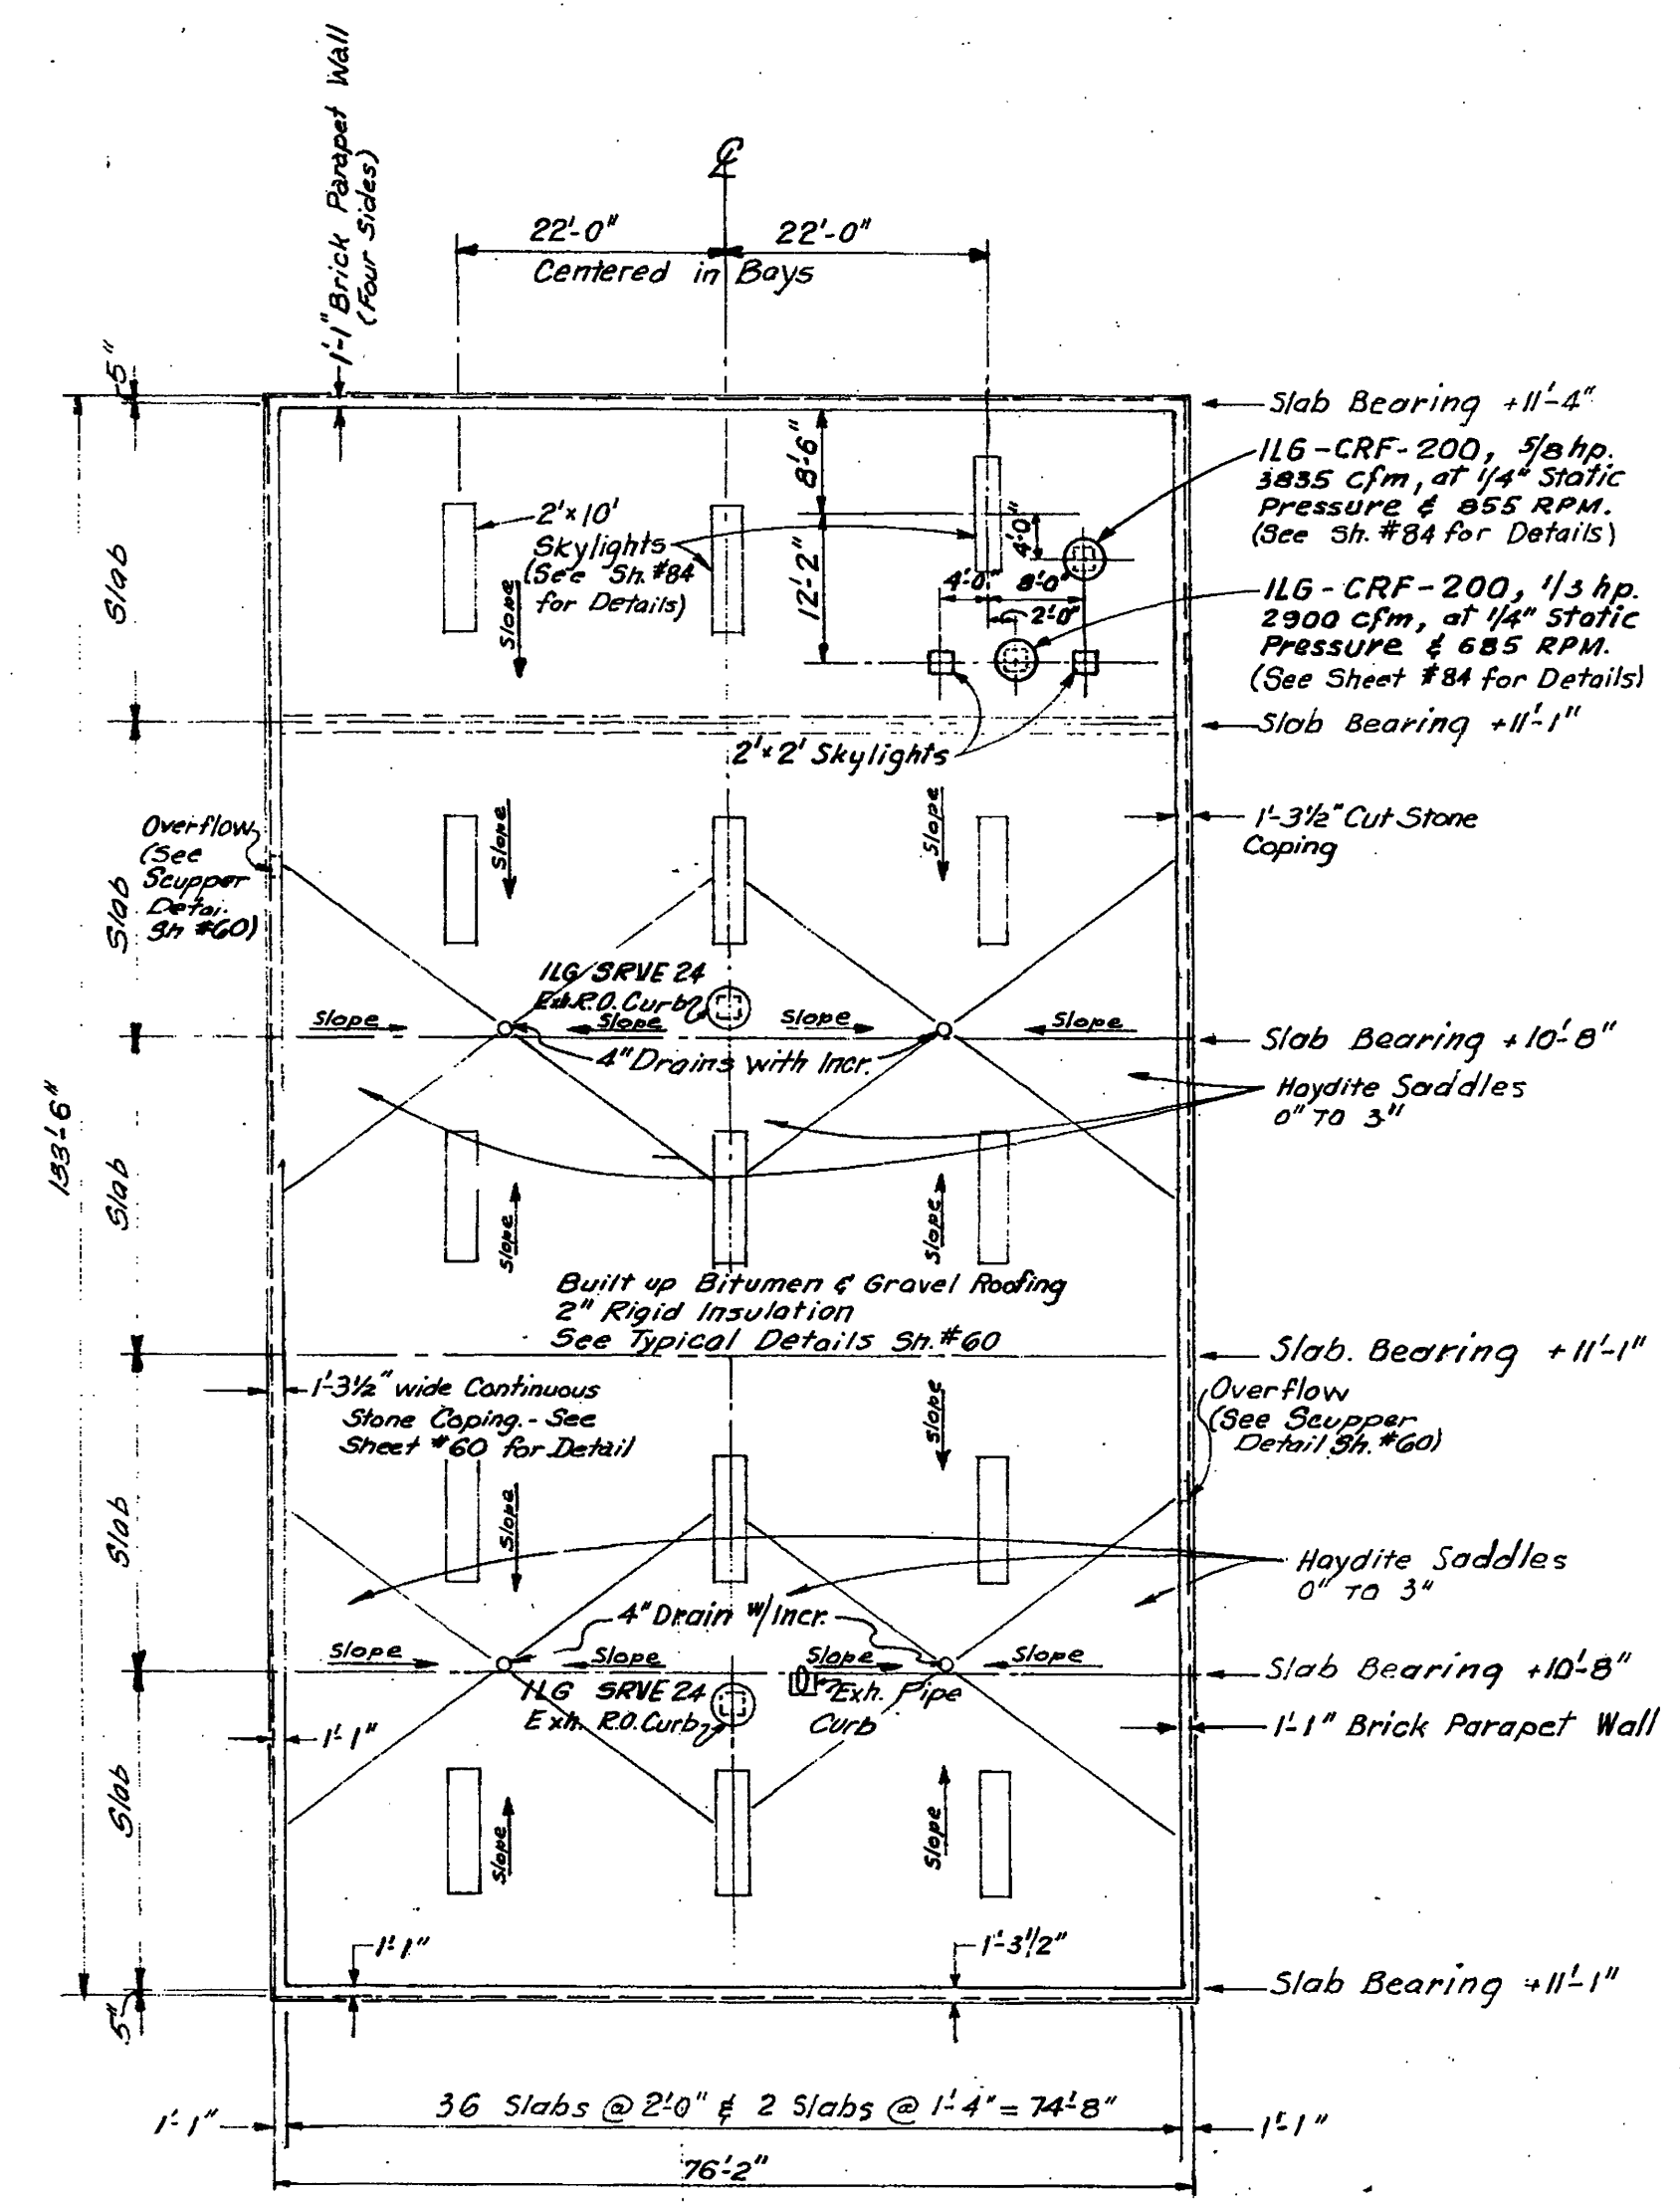

ROOF PLAN
(See Coping & Curb Details Sheet #60)
SCALE: 1/4" = 1'-0"

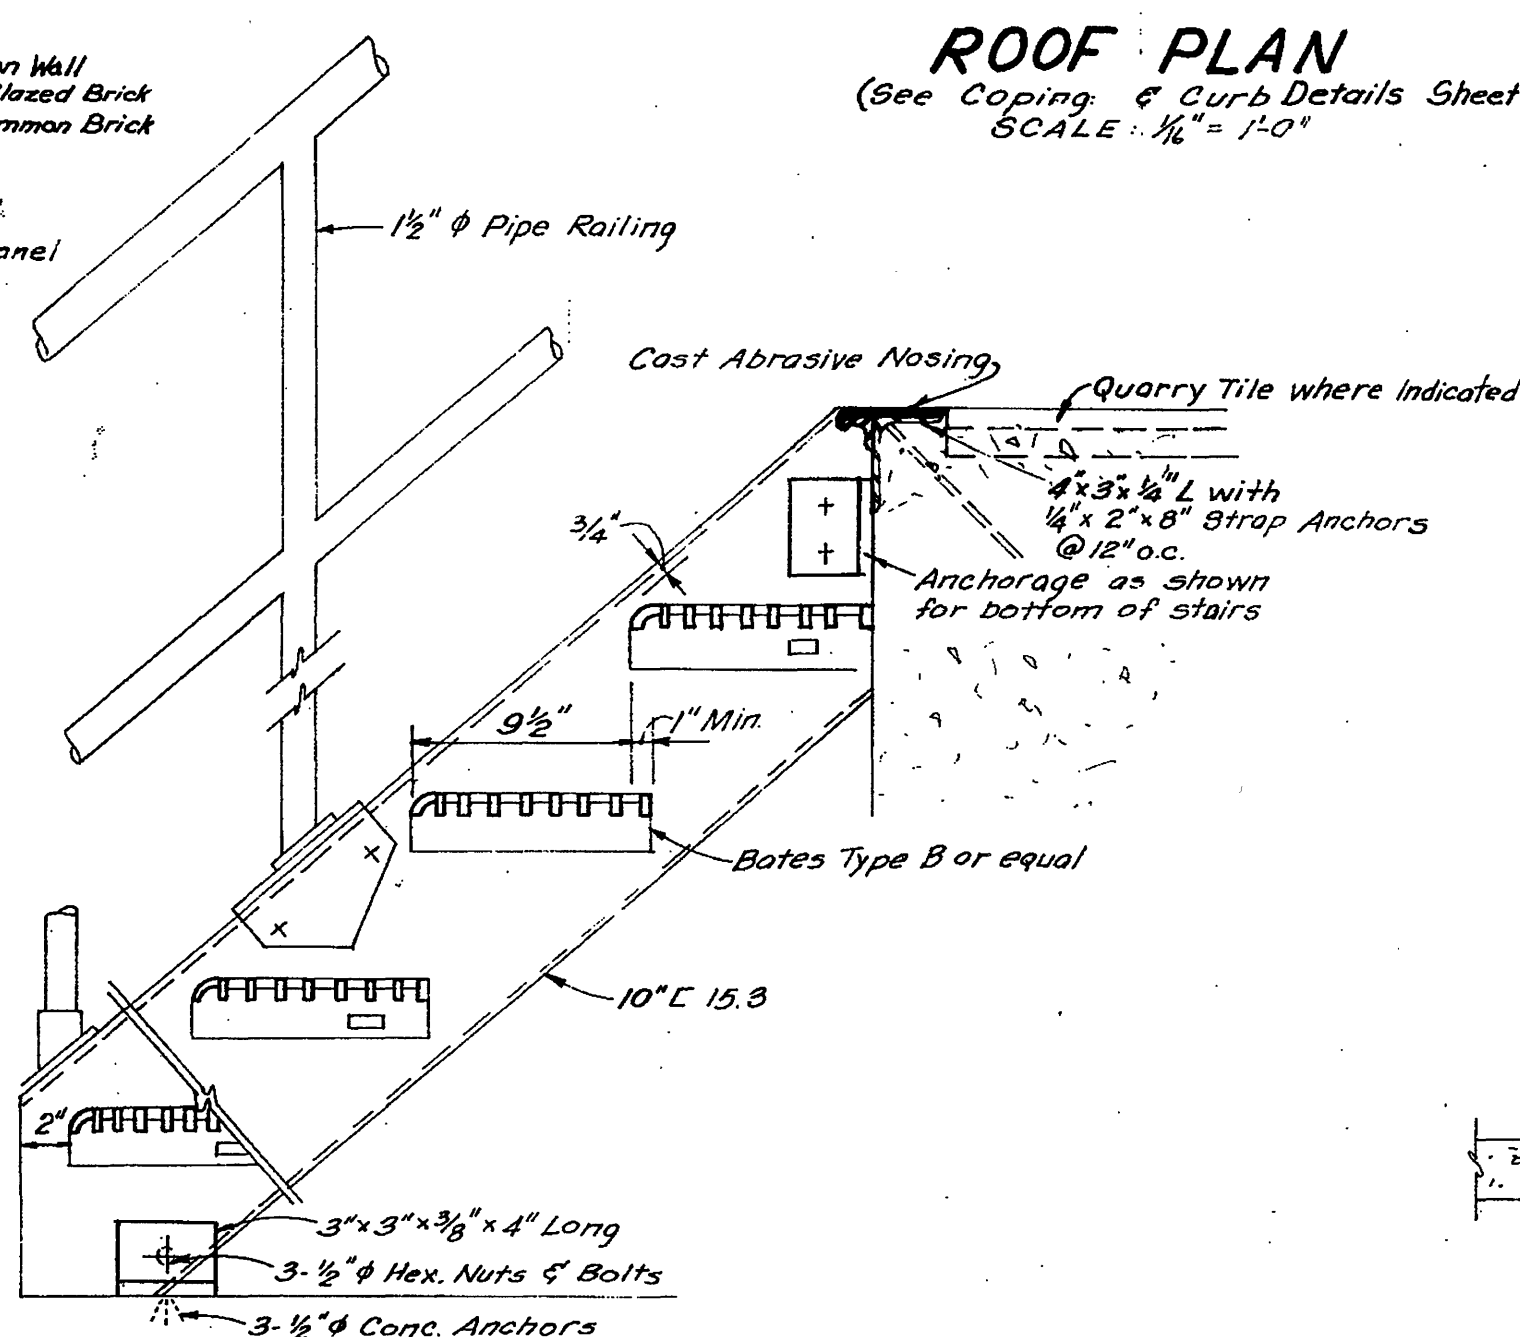

GRATING STAIR DETAIL
SCALE: 1 1/2" = 1'-0"

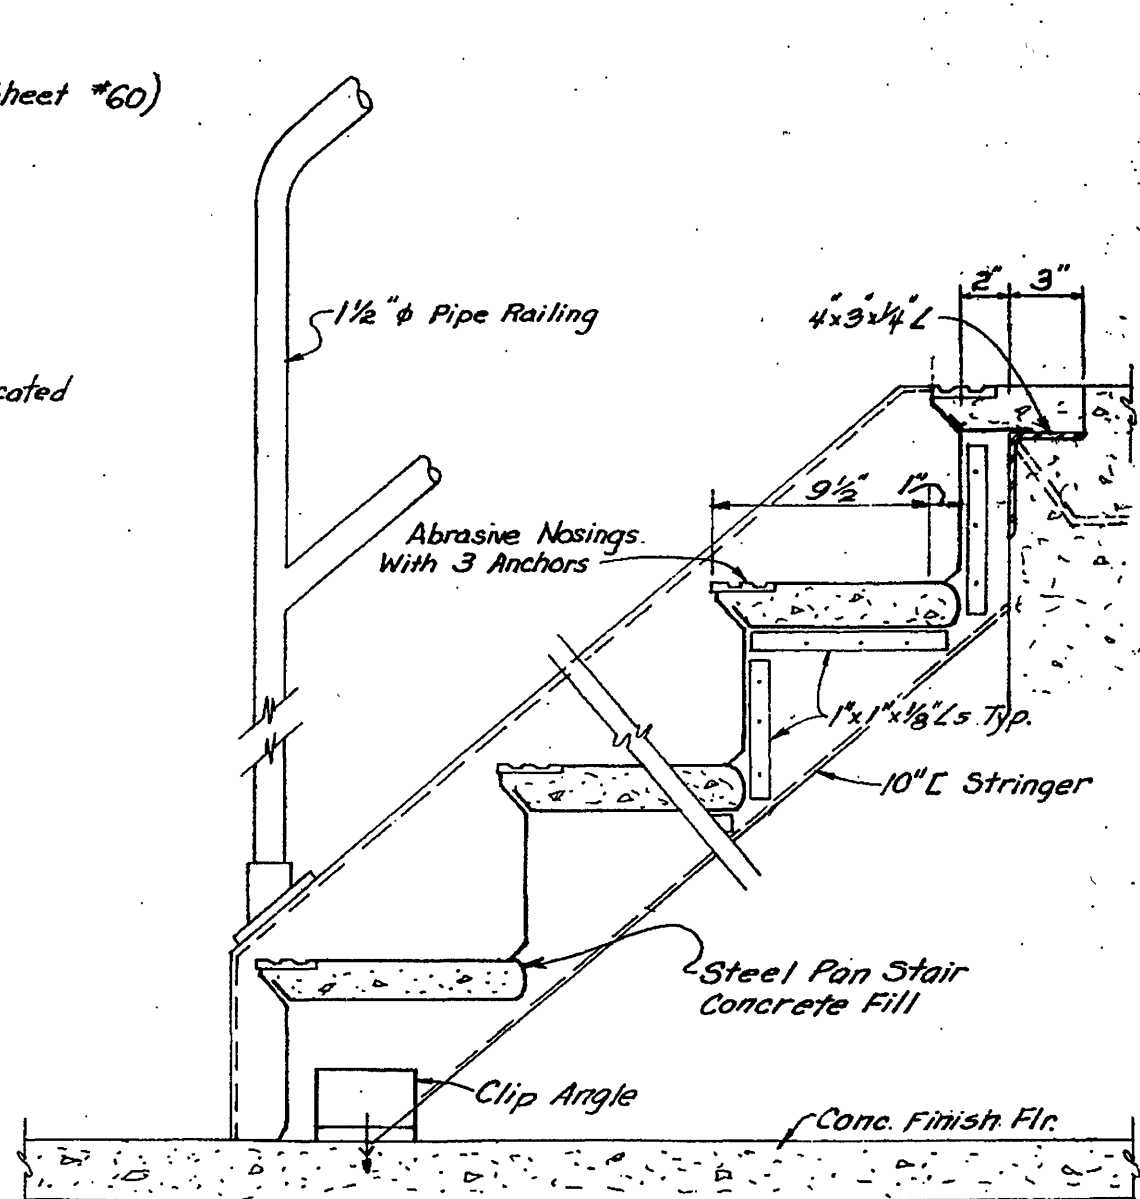

**MET. PAN
STAIR DETAIL**
SCALE: 1 1/2" = 1'-0"
CONTR. "E"

TYPICAL STAIR DETAILS

- NOTES.
1. See also Stair Details, Sheets No. 12 & 83
 2. All Exterior Stairs and Interior Stairs, except where noted, shall be hot-dip galvanized.

ADDITIONS TO SEWAGE TREATMENT PLANT
ROANOKE, VIRGINIA
SLUDGE THICKENER BLDG
ARCH. PLANS & SECTIONS

ALVORD, BURDICK & HOWSON
ENGINEERS CHICAGO

1973