


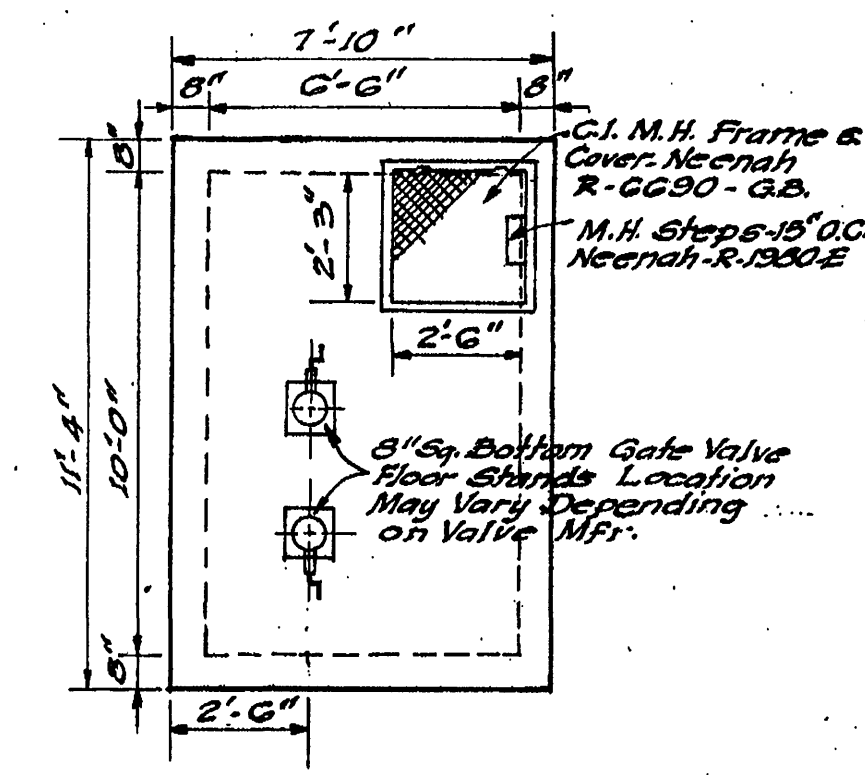
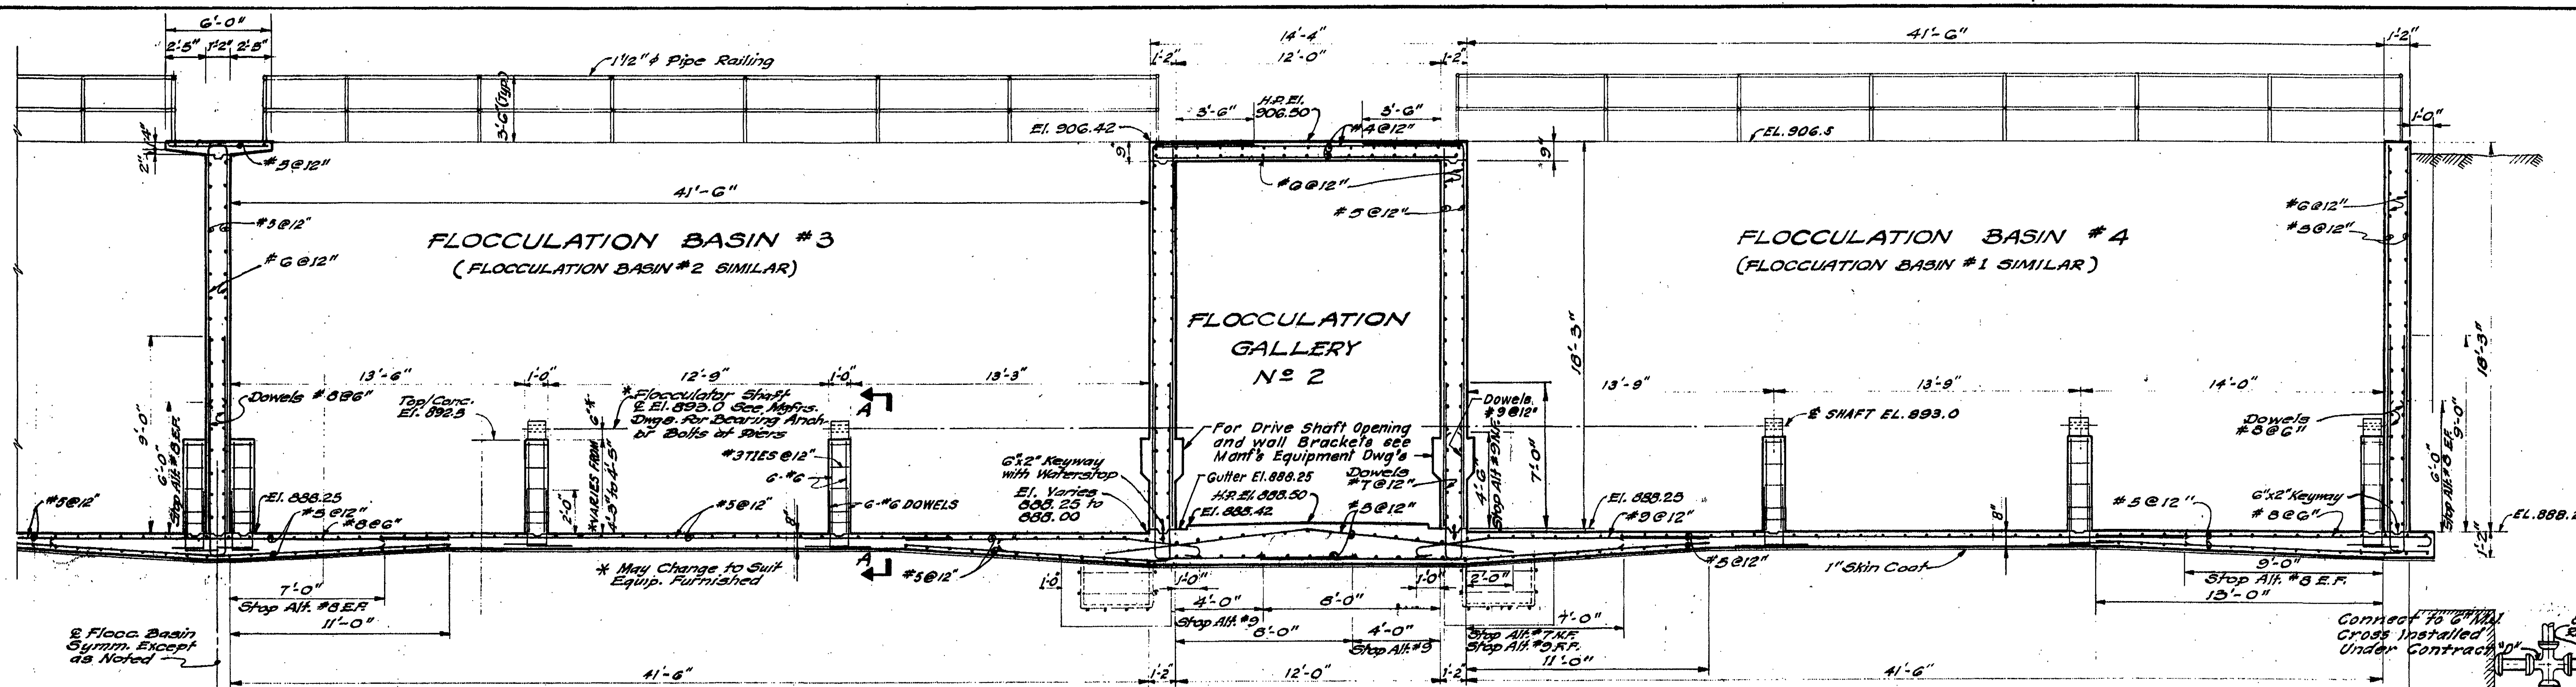


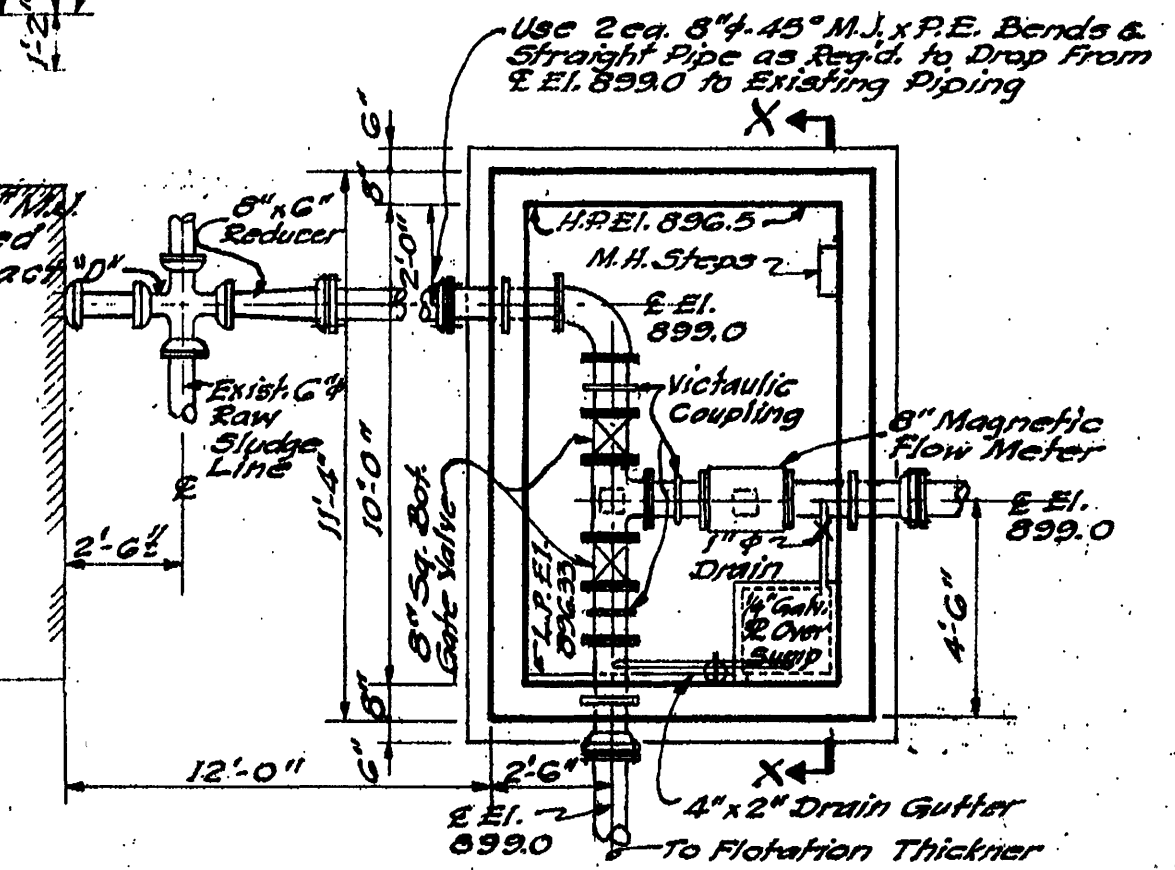




TOP OF CONC. PLAN
Scale: 1/4" = 1'-0"

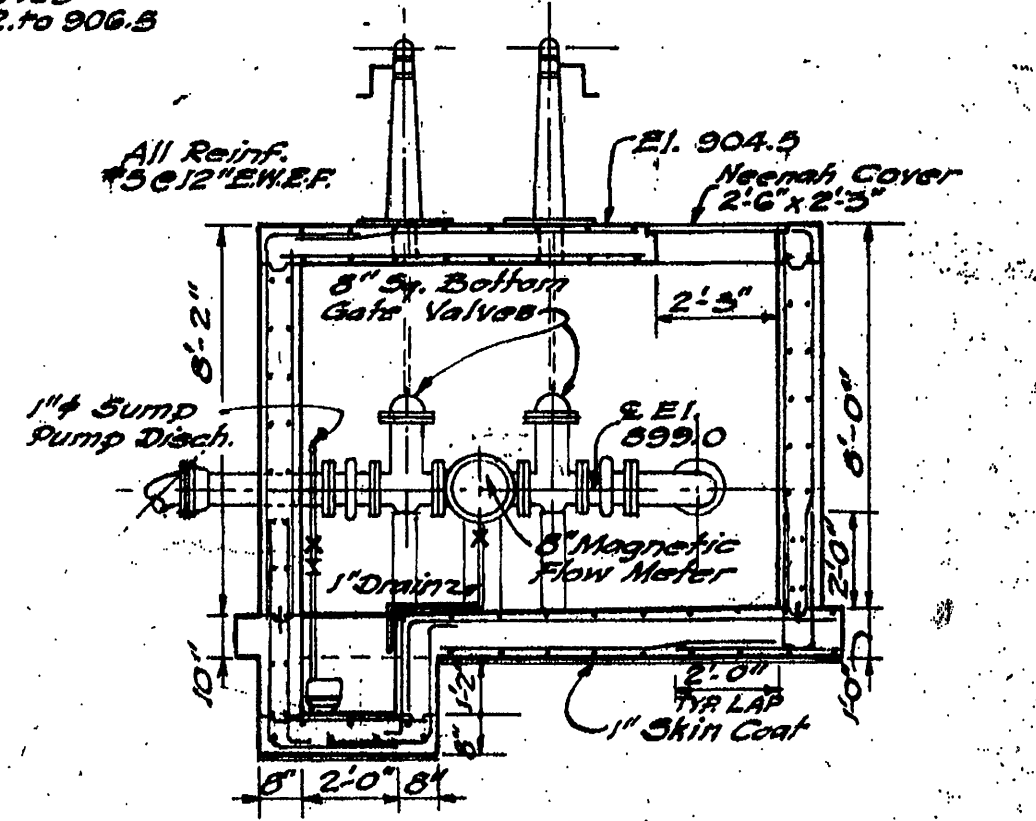


SECTIONAL PLAN
Scale: 1/4" = 1'-0"

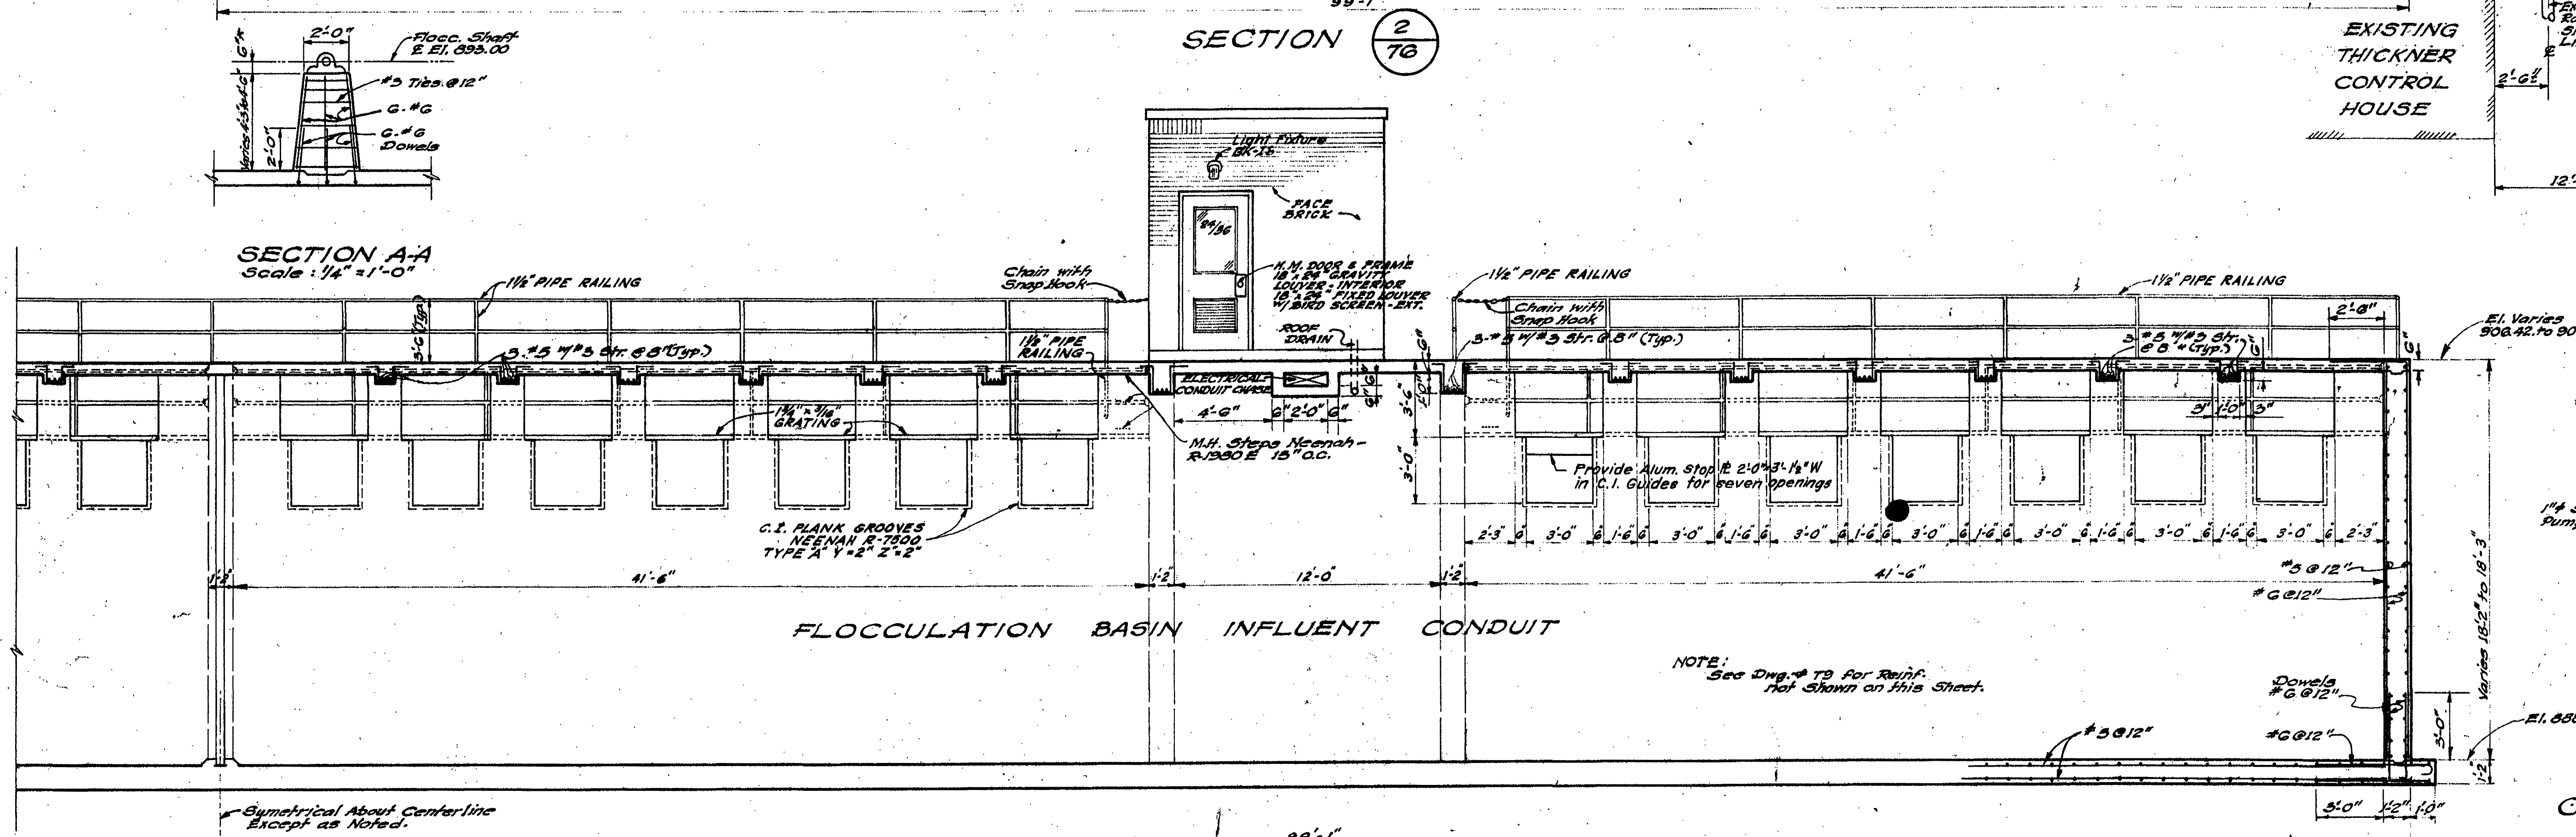

SECTION X-X
DETAILS OF COAG. SLUDGE METER VAULT

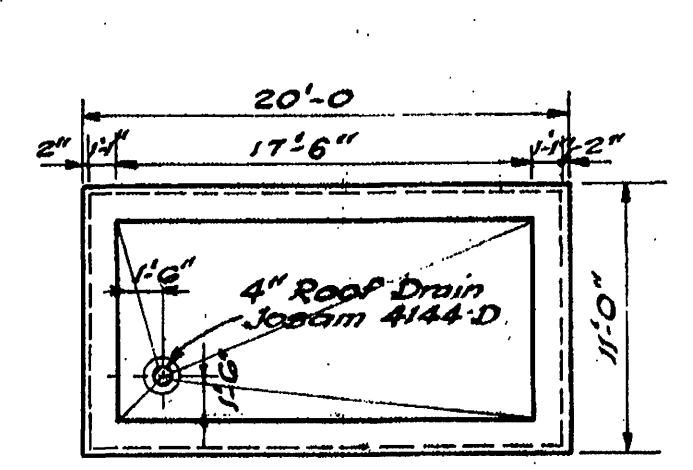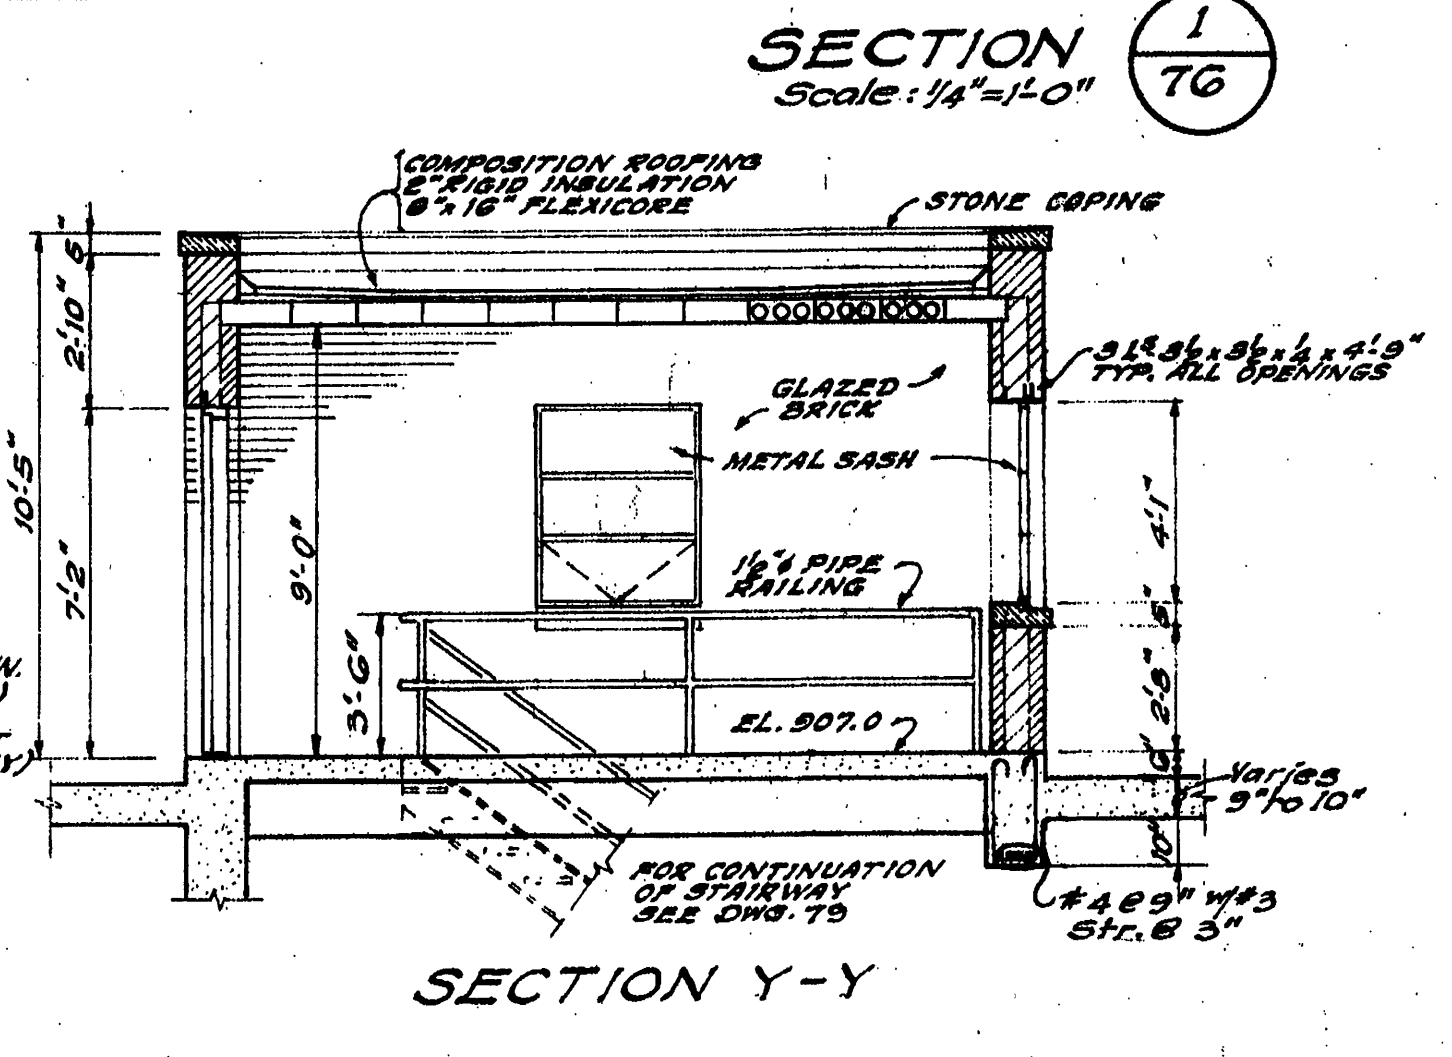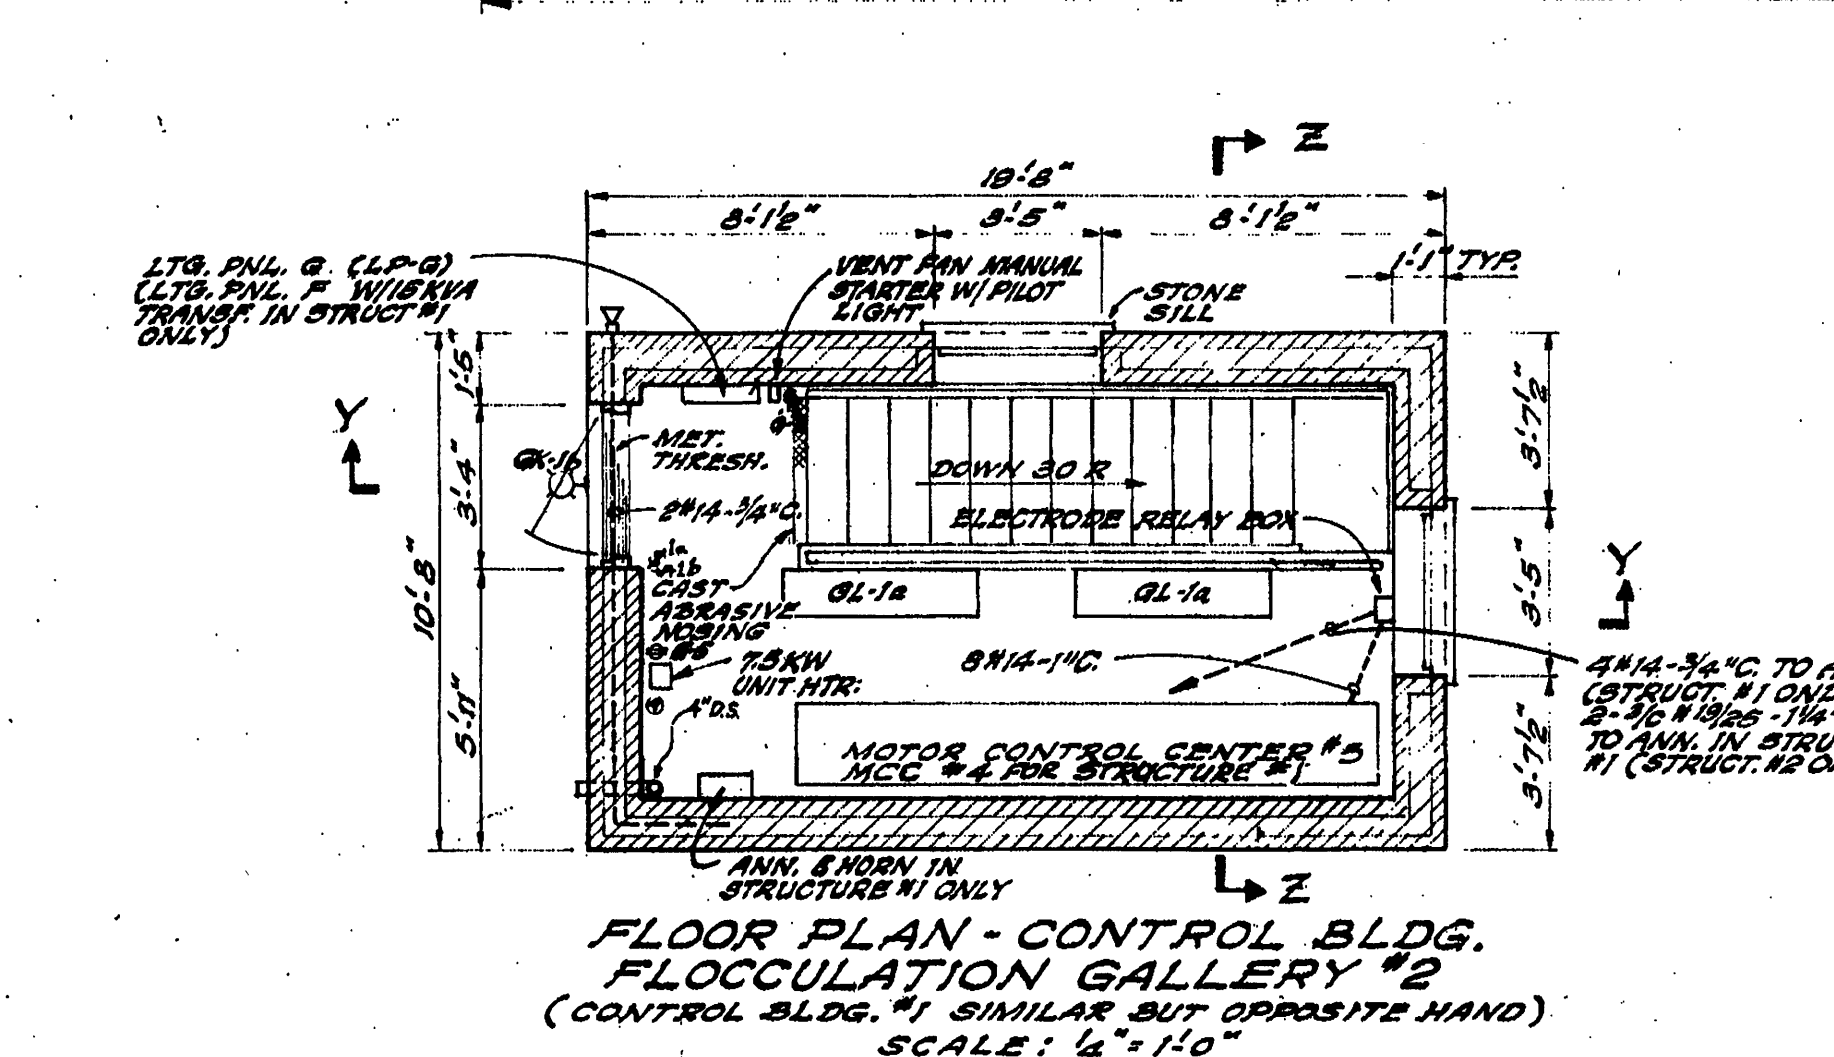

ROOF PLAN
Scale: 1/8" = 1'-0"

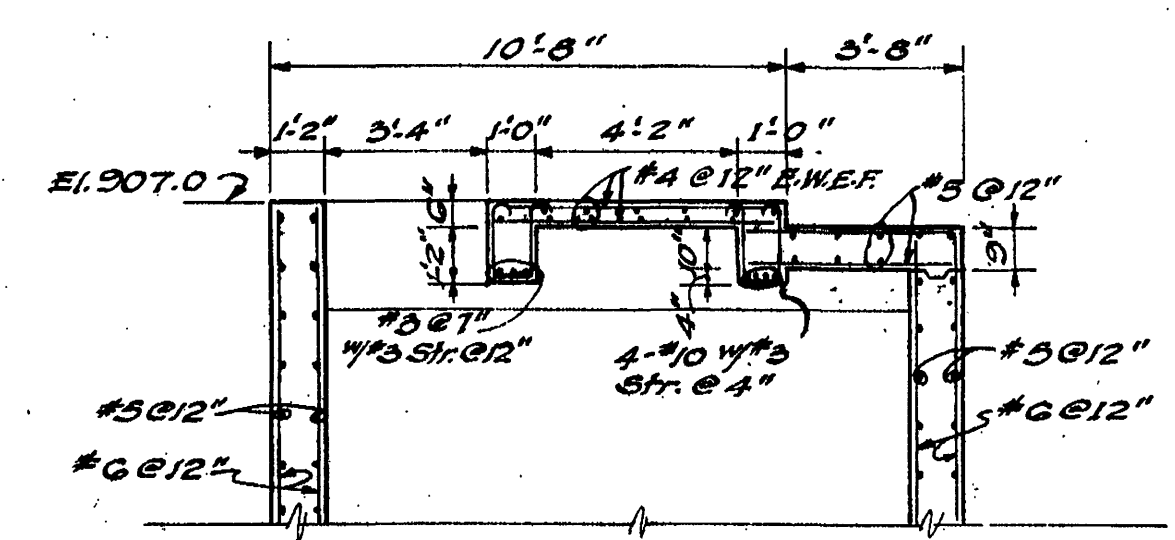

SECTION Z-Z

CONTR. "E"

ADDITIONS TO SEWAGE TREATMENT PLANT
ROANOKE, VIRGINIA

FLOC. BASINS
SECTIONS

ALVORD, BURDICK & HOWSON
ENGINEERS CHICAGO

1973