



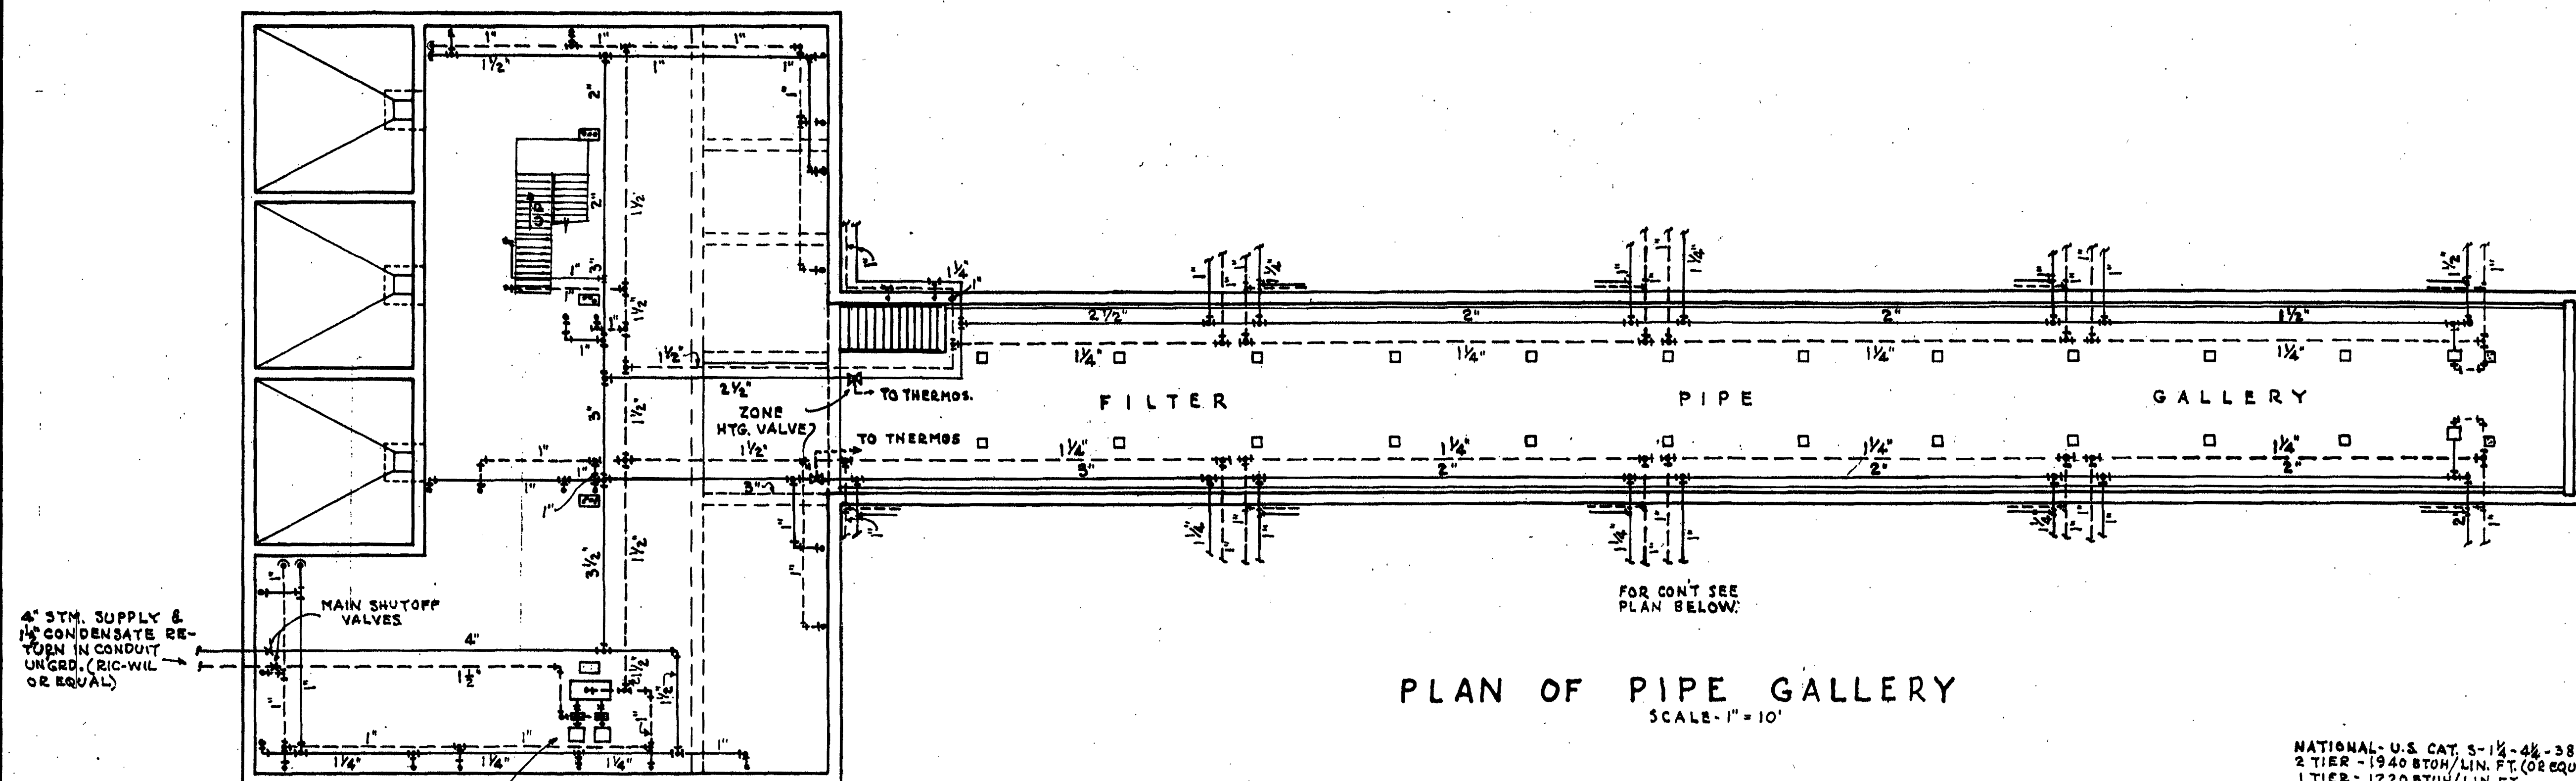


PLAN OF PIPE GALLERY
SCALE: 1" = 10'

NATIONAL U.S. CAT. 5-1 1/2-4 1/2-38
2 TIER - 1940 BTUH/LIN. FT. (OR EQUAL)
1 TIER - 1220 BTUH/LIN. FT.

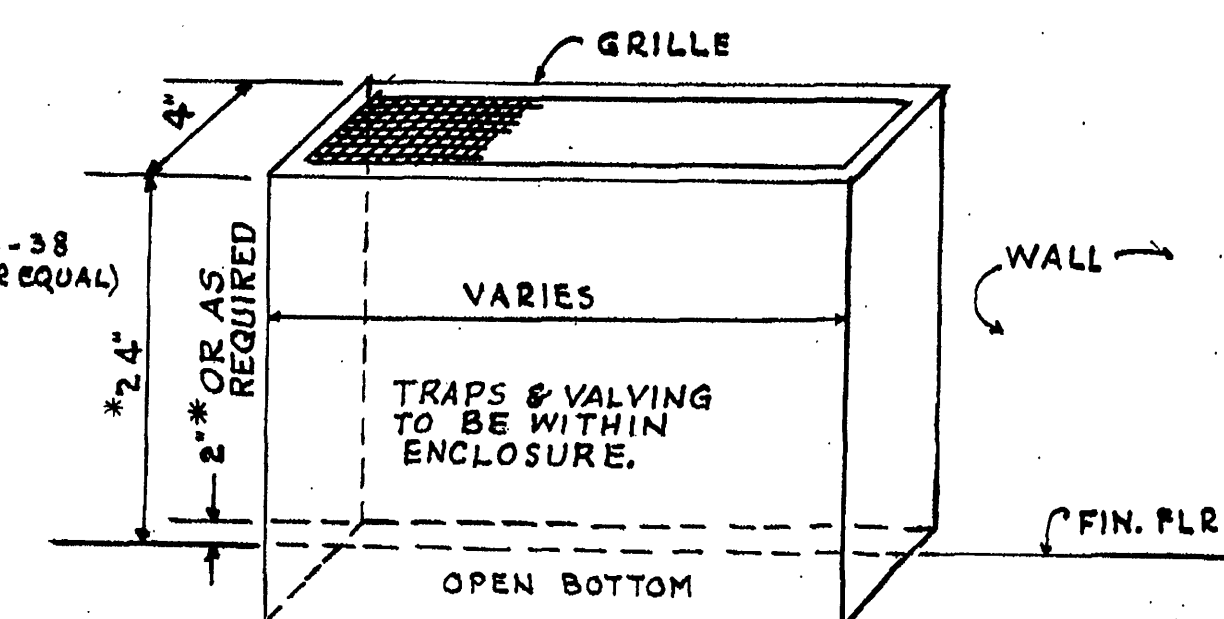


CONVECTOR
TYPICAL FIN TUBE WALL
MOUNT INSTALLATION
NO SCALE

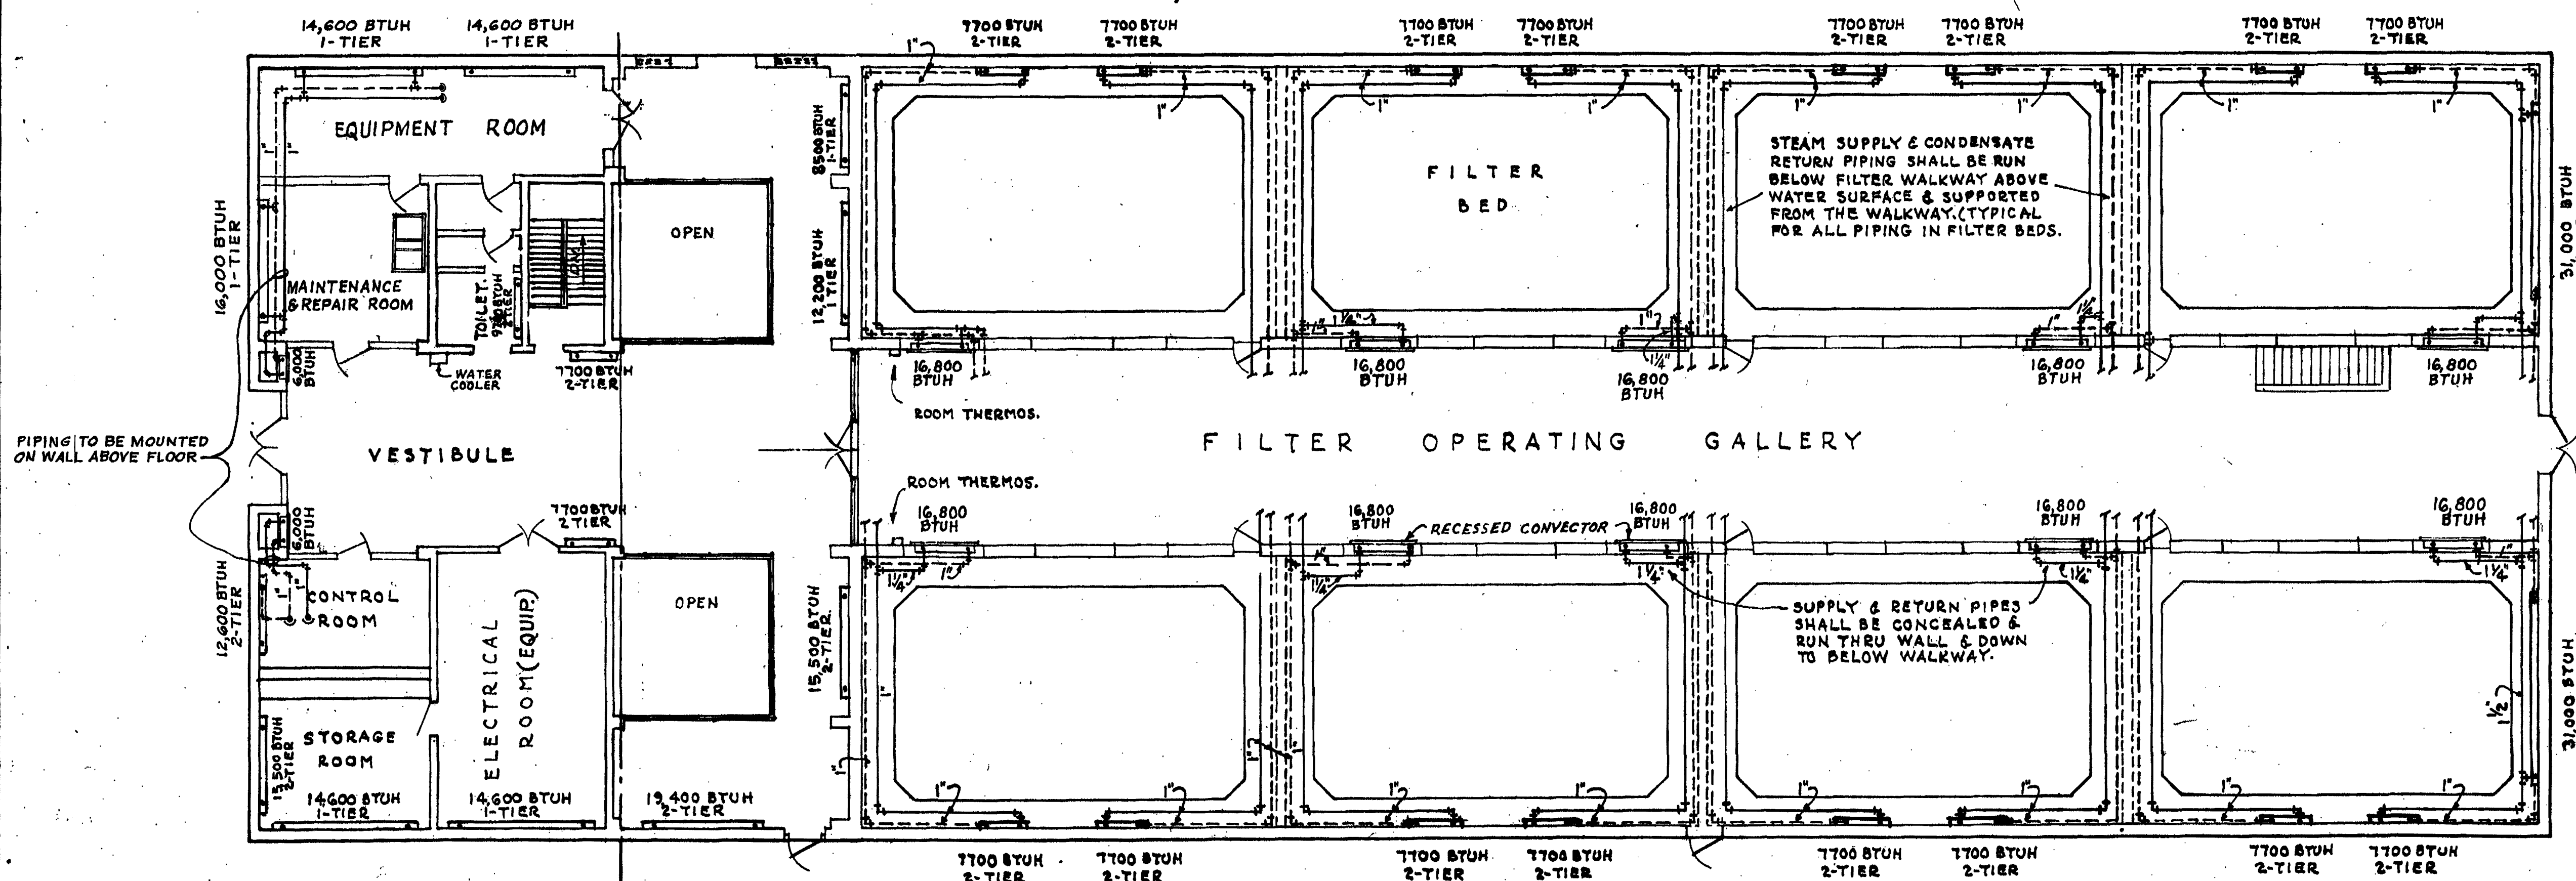

PLAN OF OPERATING GALLERY
SCALE: 1" = 10'

Note: 10-Recessed Convectors in operating gallery, Each @ 16,800 BTUH.

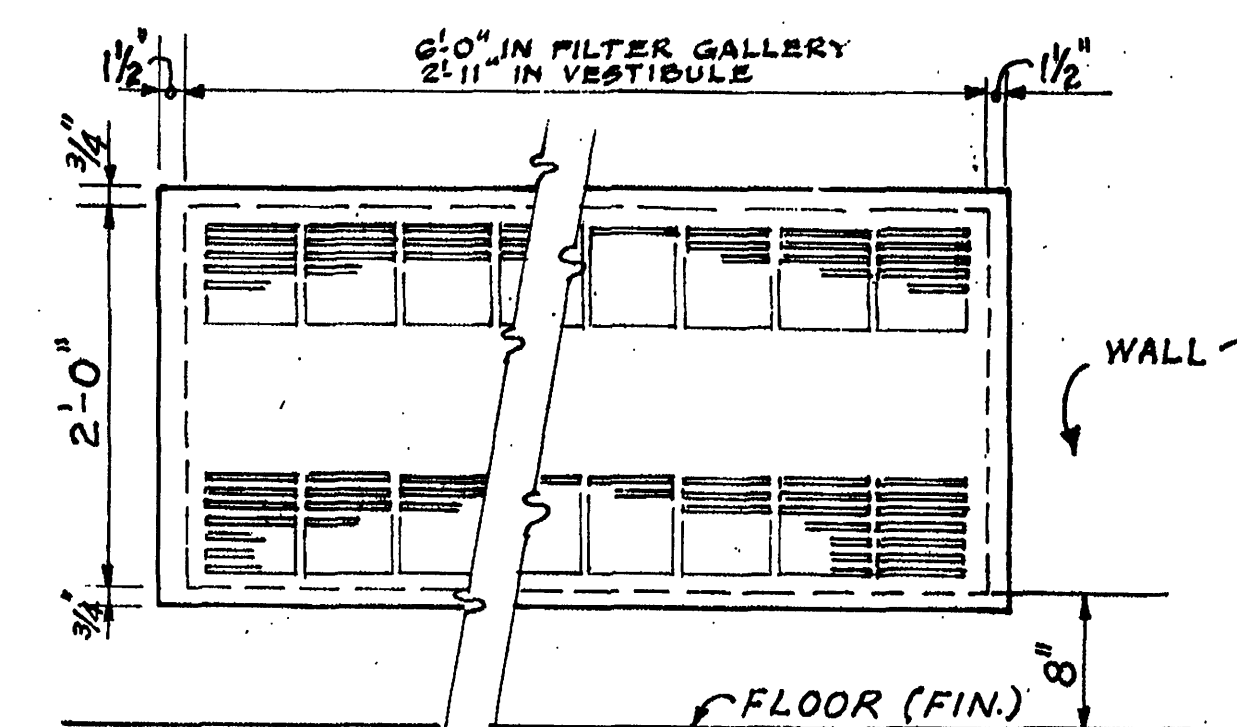

CONVECTOR GRILLE
SCALE: 1" = 1'-0"

CONTR. "E"

ADDITIONS TO SEWAGE TREATMENT PLANT
ROANOKE, VIRGINIA

FILTERS
HEATING PLAN

ALVORD, BURDICK & HOWSON
ENGINEERS CHICAGO

1973

93