



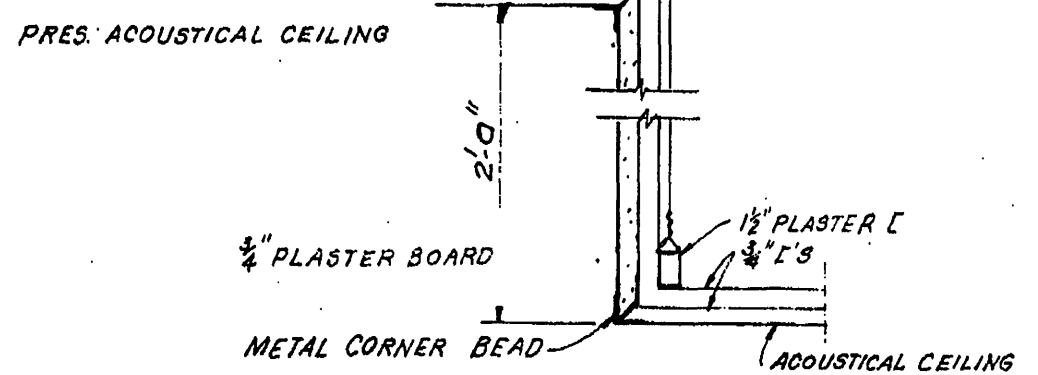

- PLANTING SCHEDULE**
1. FLOWERING CRAB (MALUS SARGENTII)
 2. BUSHY JAPANESE YEW (TAXUS BACCATA ADPRESSA)
 3. SPREADING ENGLISH YEW (TAXUS BACCATA REPANDENS)
 4. HATFIELD YEW (TAXUS MEDIA HATFIELDI)

- KEY TO RECEPTACLES**
- G GAS
 - A AIR
 - F FAN SWITCH
 - L LIGHT SWITCH
 - D DISTILLED WATER
 - E100 100 VOLT-DUPLEX RECEPT.
 - E200 200 VOLT-RECEPT.
 - ALL CUP SINKS COLD WATER
 - ALL OTHER SINKS HOT AND COLD WATER

- SAMPLING SINK CONNECTIONS**
1. PLANT INFLUENT
 2. PRIMARY EFFLUENT
 3. M.L.S.S.-AERATION
 4. M.L.S.S.-NITRIFICATION
 5. NIT. SETT. EFFLUENT
 6. COAGULATION EFFLUENT
 7. FILTERED EFFLUENT
 8. CHLORINATED EFFLUENT

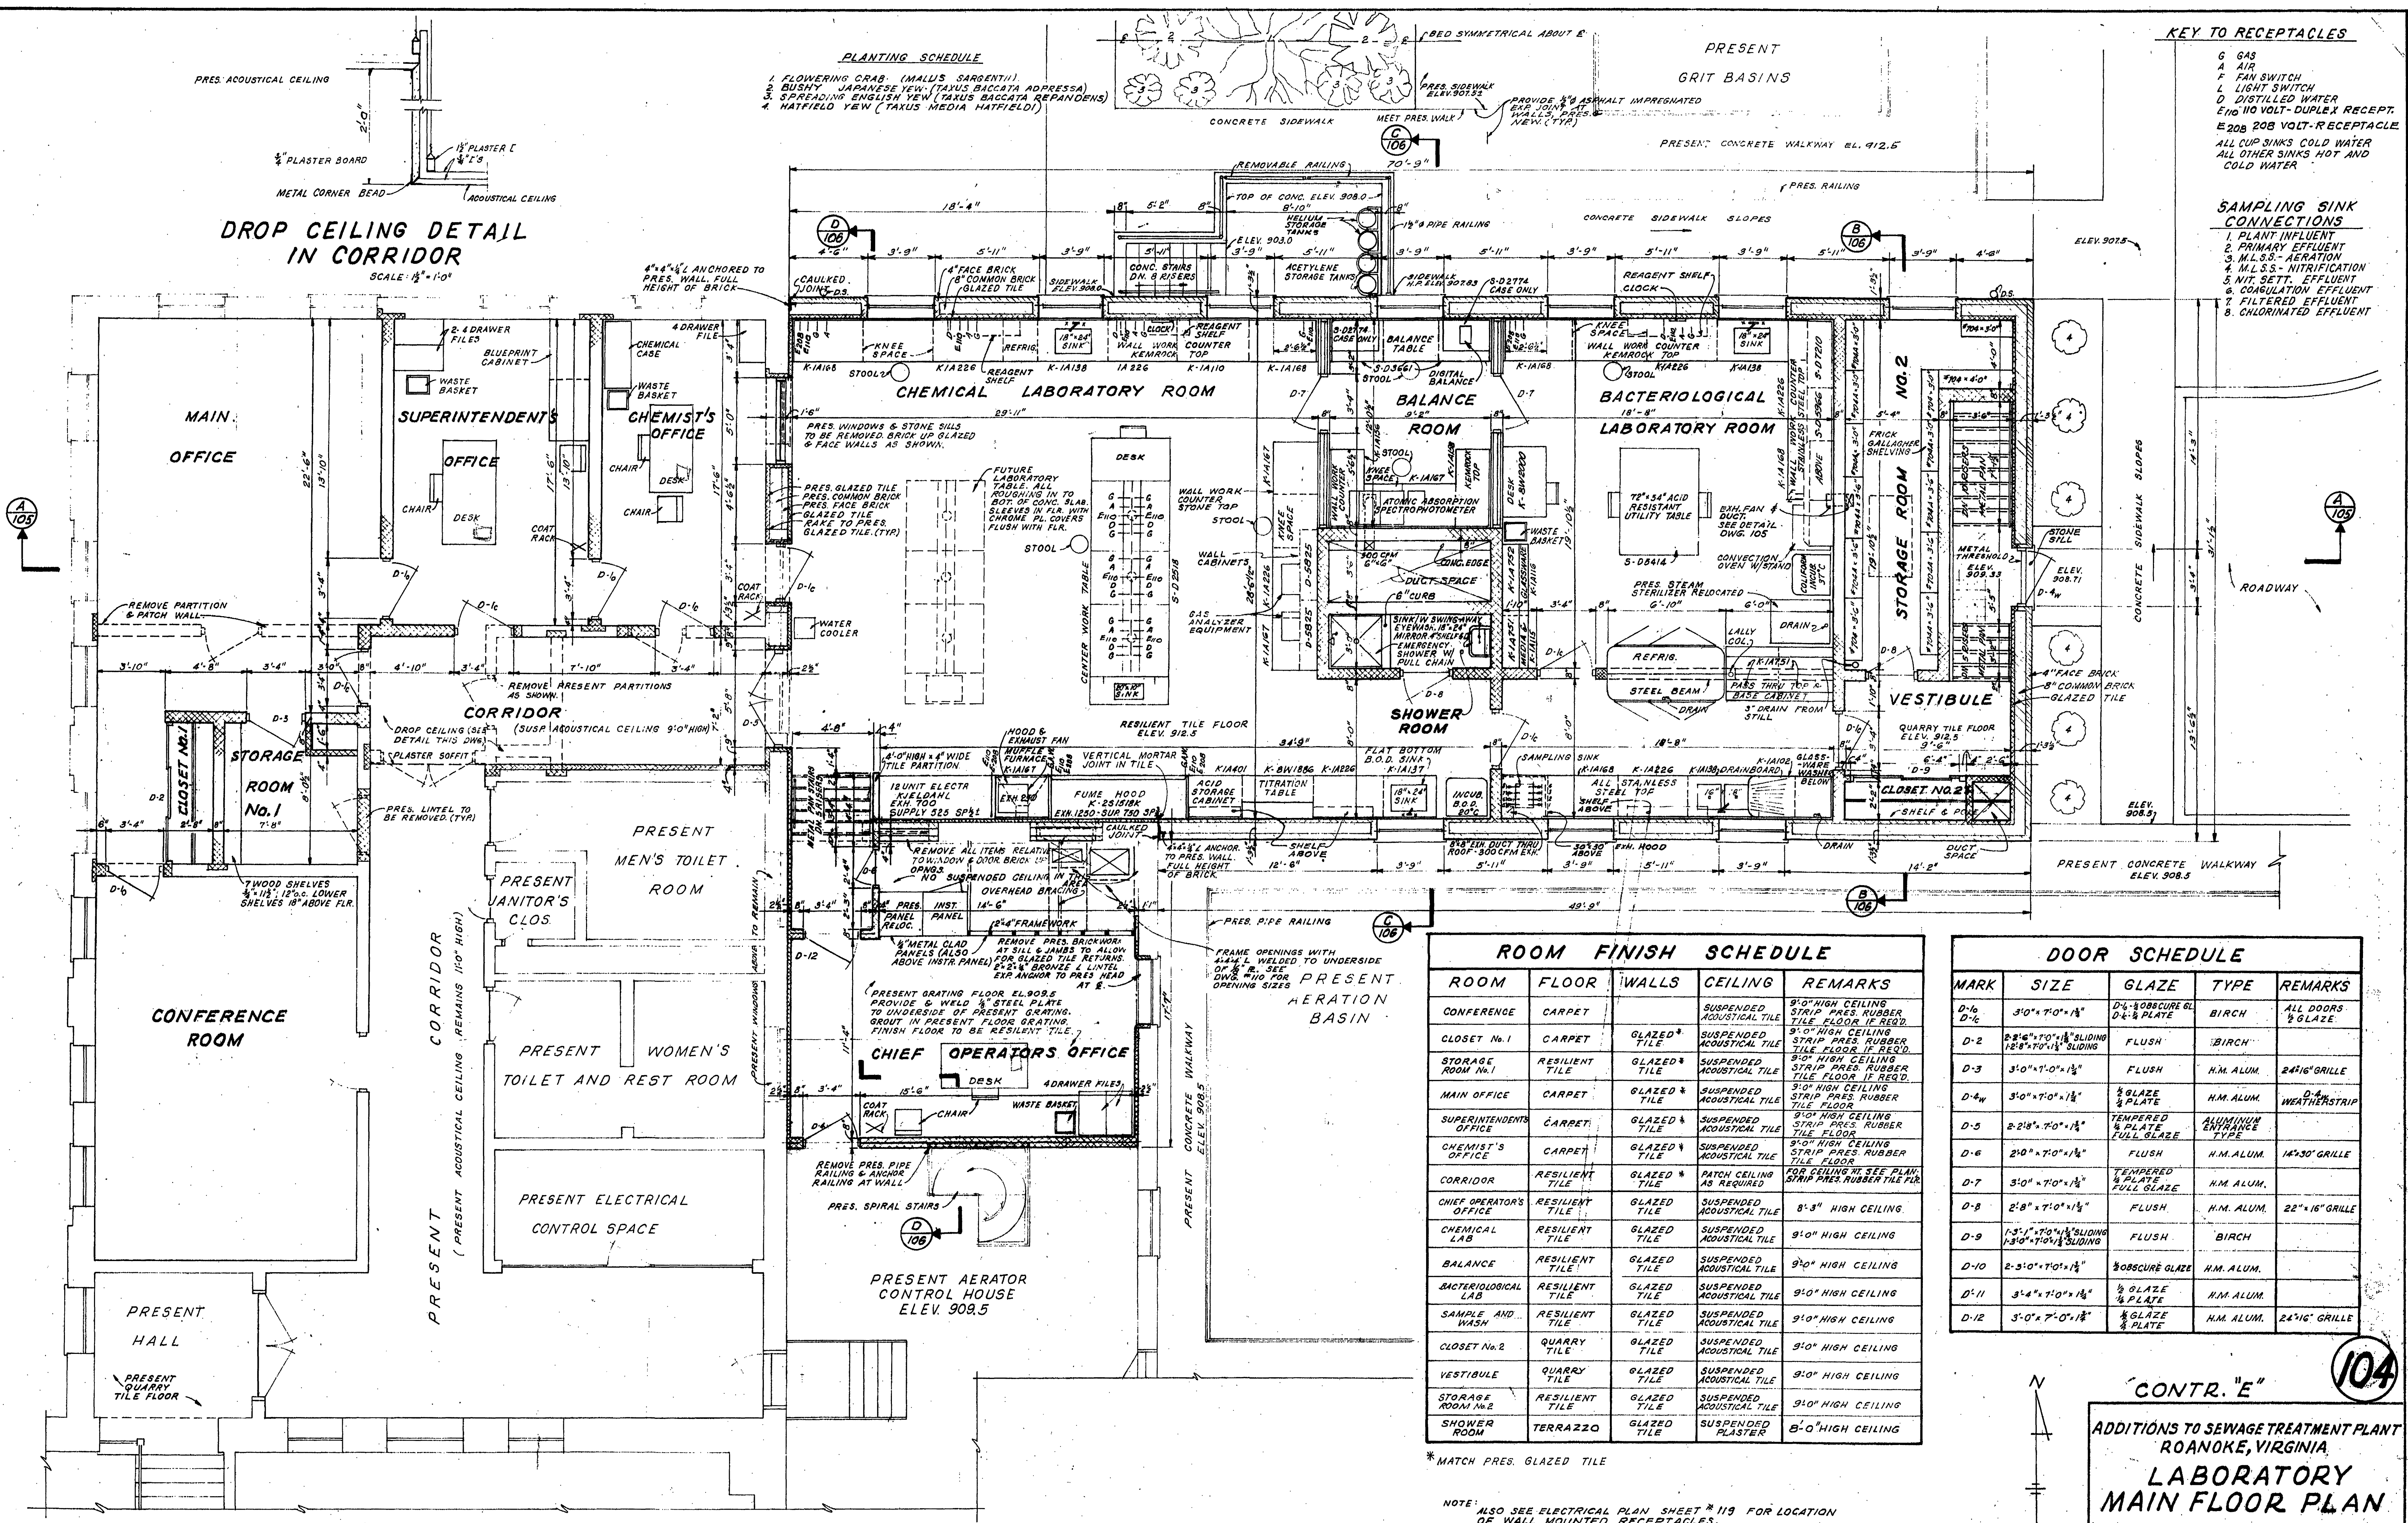

ROOM FINISH SCHEDULE				
ROOM	FLOOR	WALLS	CEILING	REMARKS
CONFERENCE	CARPET		SUSPENDED ACoustical TILE	9'-0" HIGH CEILING STRIP PRES. RUBBER TILE FLOOR IF REQ'D.
CLOSET No. 1	CARPET	GLAZED TILE	SUSPENDED ACoustical TILE	9'-0" HIGH CEILING STRIP PRES. RUBBER TILE FLOOR IF REQ'D.
STORAGE ROOM No. 1	RESILIENT TILE	GLAZED TILE	SUSPENDED ACoustical TILE	9'-0" HIGH CEILING STRIP PRES. RUBBER TILE FLOOR IF REQ'D.
MAIN OFFICE	CARPET	GLAZED TILE	SUSPENDED ACoustical TILE	9'-0" HIGH CEILING STRIP PRES. RUBBER TILE FLOOR
SUPERINTENDENT'S OFFICE	CARPET	GLAZED TILE	SUSPENDED ACoustical TILE	9'-0" HIGH CEILING STRIP PRES. RUBBER TILE FLOOR
CHEMIST'S OFFICE	CARPET	GLAZED TILE	SUSPENDED ACoustical TILE	9'-0" HIGH CEILING STRIP PRES. RUBBER TILE FLOOR
CORRIDOR	RESILIENT TILE	GLAZED TILE	SUSPENDED ACoustical TILE	9'-0" HIGH CEILING STRIP PRES. RUBBER TILE FLOOR
CHIEF OPERATOR'S OFFICE	RESILIENT TILE	GLAZED TILE	SUSPENDED ACoustical TILE	8'-3" HIGH CEILING
CHEMICAL LAB	RESILIENT TILE	GLAZED TILE	SUSPENDED ACoustical TILE	9'-0" HIGH CEILING
BALANCE	RESILIENT TILE	GLAZED TILE	SUSPENDED ACoustical TILE	9'-0" HIGH CEILING
BACTERIOLOGICAL LAB	RESILIENT TILE	GLAZED TILE	SUSPENDED ACoustical TILE	9'-0" HIGH CEILING
SAMPLE AND WASH	RESILIENT TILE	GLAZED TILE	SUSPENDED ACoustical TILE	9'-0" HIGH CEILING
CLOSET No. 2	QUARRY TILE	GLAZED TILE	SUSPENDED ACoustical TILE	9'-0" HIGH CEILING
VESTIBULE	QUARRY TILE	GLAZED TILE	SUSPENDED ACoustical TILE	9'-0" HIGH CEILING
STORAGE ROOM No. 2	RESILIENT TILE	GLAZED TILE	SUSPENDED ACoustical TILE	9'-0" HIGH CEILING
SHOWER ROOM	TERRAZZO	GLAZED TILE	SUSPENDED PLASTER	8'-0" HIGH CEILING

DOOR SCHEDULE				
MARK	SIZE	GLAZE	TYPE	REMARKS
D-10	3'-0" x 7'-0" x 1/8"	D-4-8 OBBSCURE GL. D-4-8 PLATE	BIRCH	ALL DOORS 2 GLAZE
D-2	2'-8 1/2" x 7'-0" x 1/8" SLIDING 12'-8" x 7'-0" x 1/8" SLIDING	FLUSH	BIRCH	
D-3	3'-0" x 7'-0" x 1/8"	FLUSH	H.M. ALUM.	24"x16" GRILLE
D-4	3'-0" x 7'-0" x 1/8"	1/2 GLAZE 1/2 PLATE	H.M. ALUM.	D-4 WEATHERSTRIP
D-5	2'-8 1/2" x 7'-0" x 1/8"	TEMPERED 1/2 PLATE FULL GLAZE	ALUMINUM ENTRANCE TYPE	
D-6	2'-0" x 7'-0" x 1/8"	FLUSH	H.M. ALUM.	14"x30" GRILLE
D-7	3'-0" x 7'-0" x 1/8"	TEMPERED 1/2 PLATE FULL GLAZE	H.M. ALUM.	
D-8	2'-8 1/2" x 7'-0" x 1/8"	FLUSH	H.M. ALUM.	22"x16" GRILLE
D-9	1'-3 1/2" x 7'-0" x 1/8" SLIDING 13'-0" x 7'-0" x 1/8" SLIDING	FLUSH	BIRCH	
D-10	2'-3 1/2" x 7'-0" x 1/8"	1/2 OBBSCURE GLAZE	H.M. ALUM.	
D-11	3'-4" x 7'-0" x 1/8"	1/2 GLAZE 1/2 PLATE	H.M. ALUM.	
D-12	3'-0" x 7'-0" x 1/8"	1/2 GLAZE 1/2 PLATE	H.M. ALUM.	24"x16" GRILLE

* MATCH PRES. GLAZED TILE

NOTE: ALSO SEE ELECTRICAL PLAN SHEET #119 FOR LOCATION OF WALL MOUNTED RECEPTACLES.

MAIN FLOOR PLAN
SCALE: 1/8" = 1'-0"

CONTR. "E"
ADDITIONS TO SEWAGE TREATMENT PLANT
ROANOKE, VIRGINIA
**LABORATORY
MAIN FLOOR PLAN**
ALVORD, BURDICK & HOWSON
ENGINEERS CHICAGO
1973