




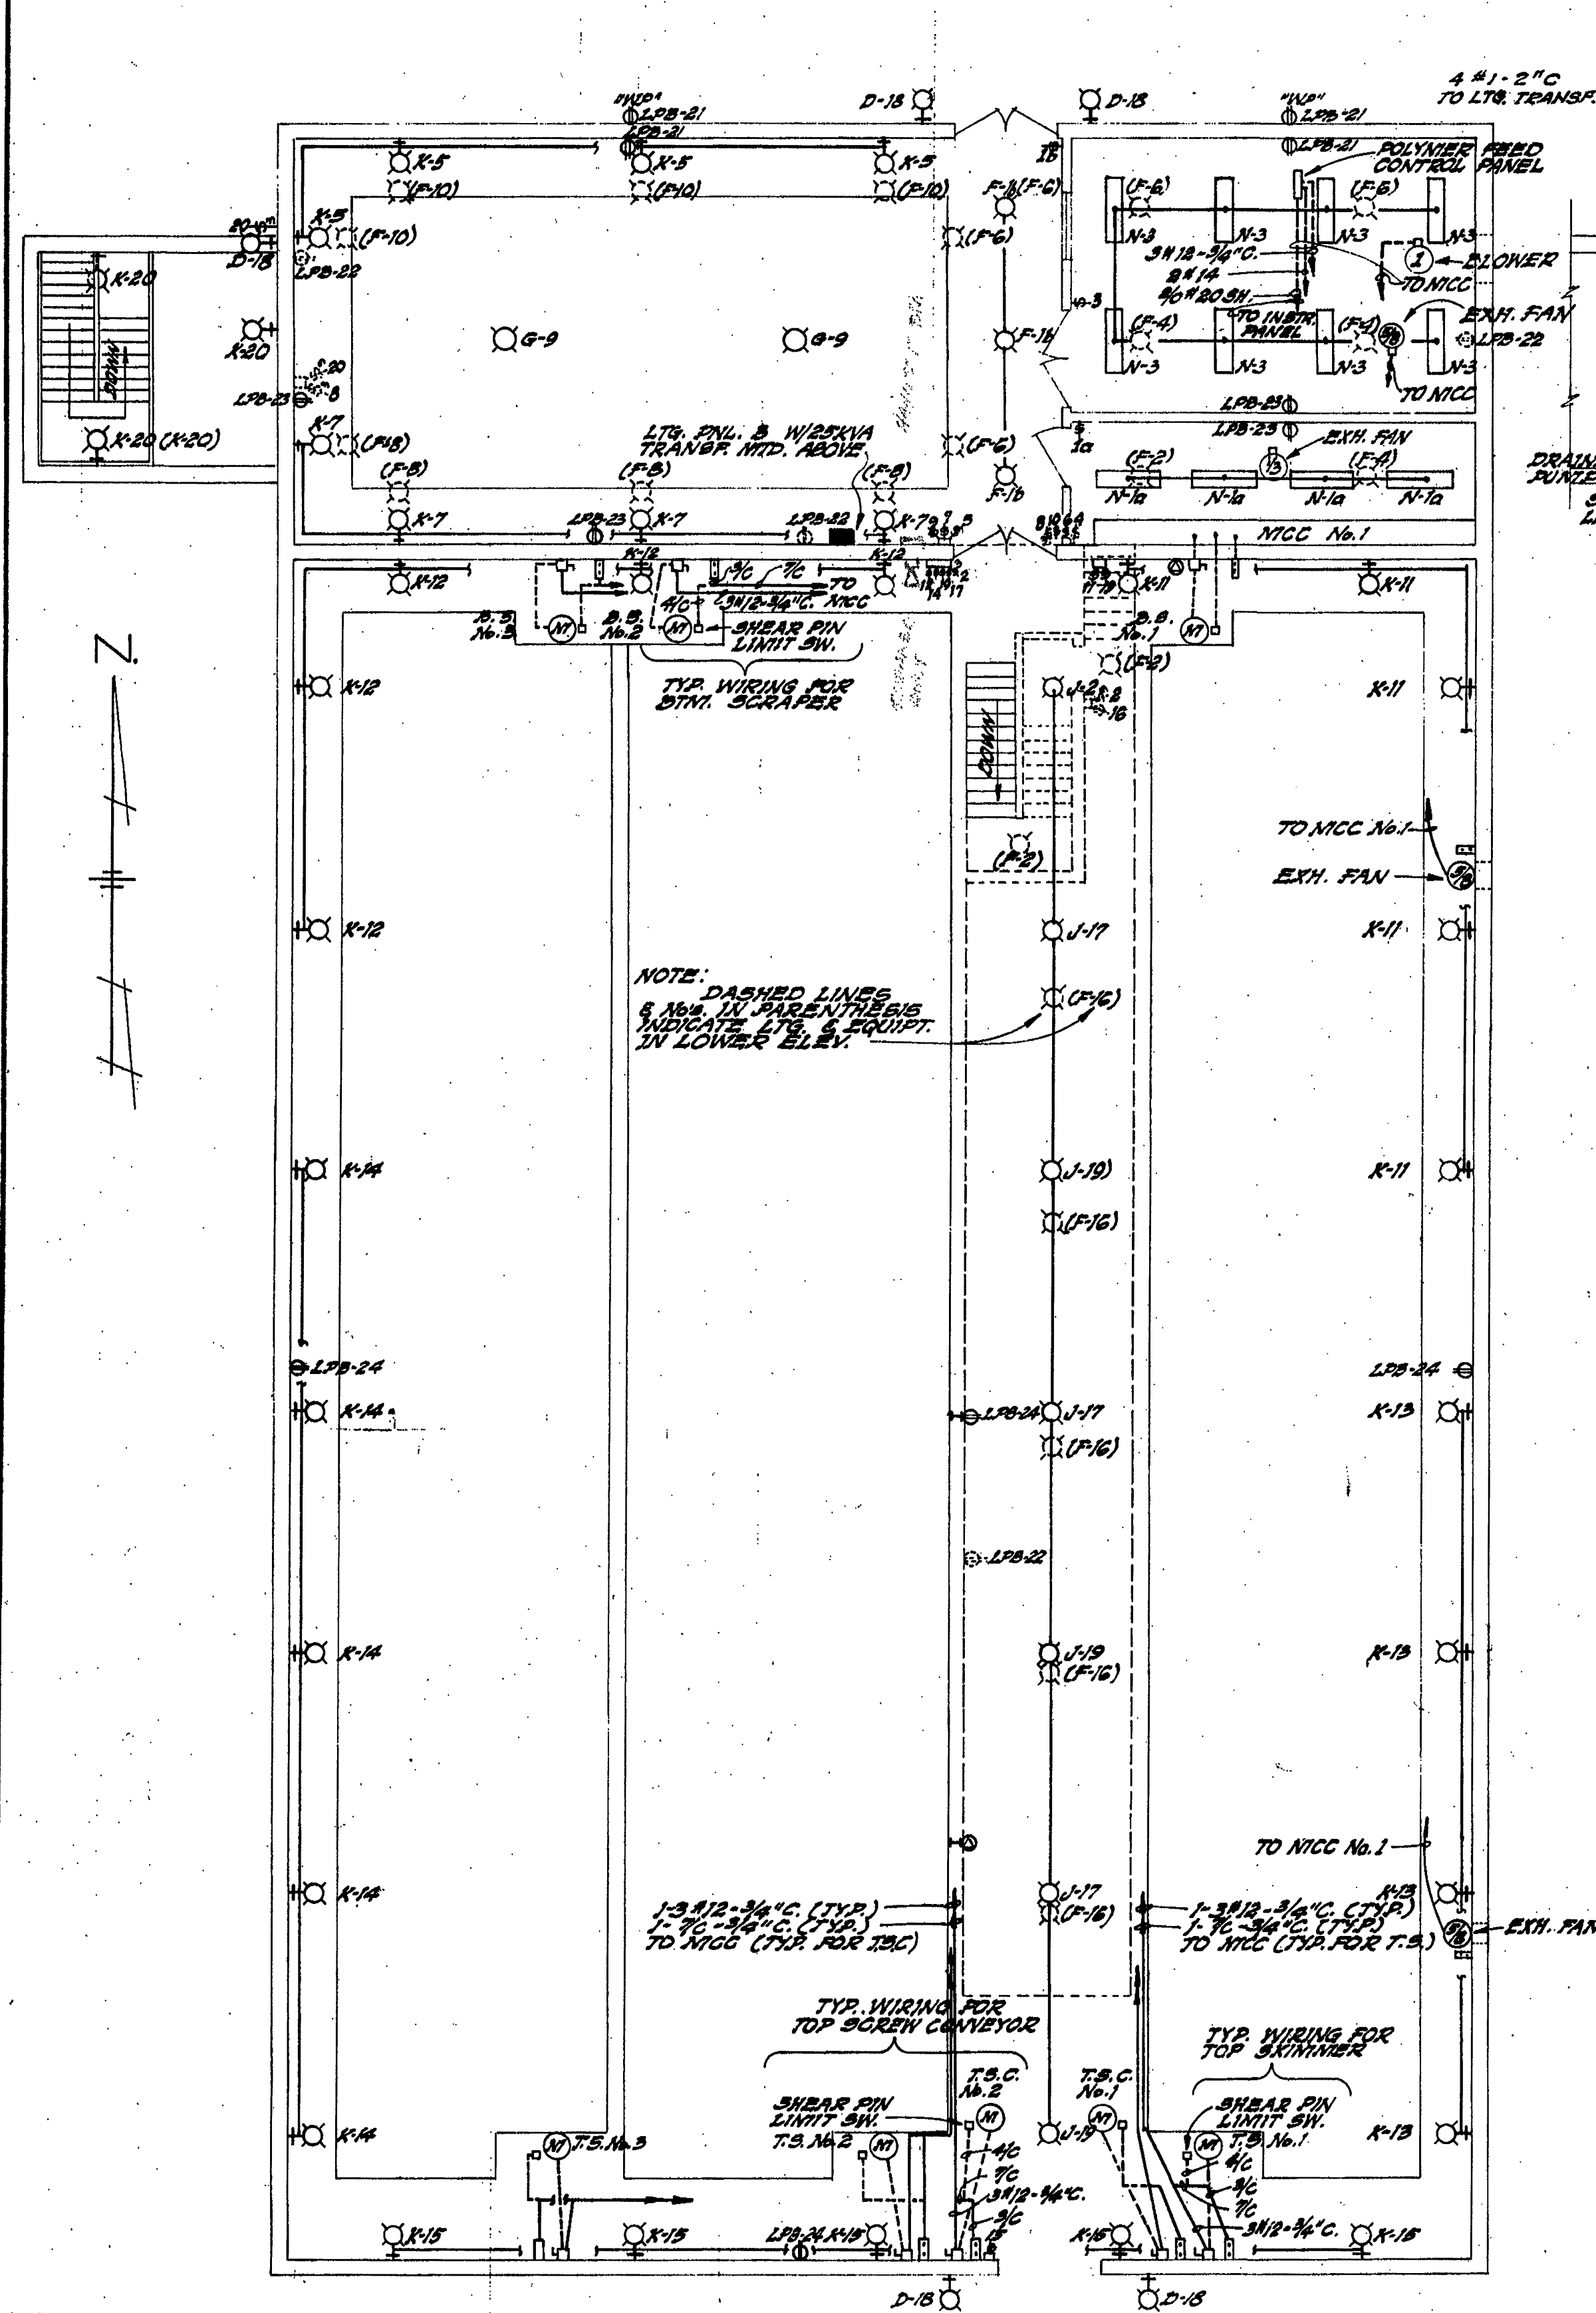


ELEV'S 913.0, 899.0 & 894.0
POWER & LIGHTING PLAN
SCALE: 1/8" = 1'-0"

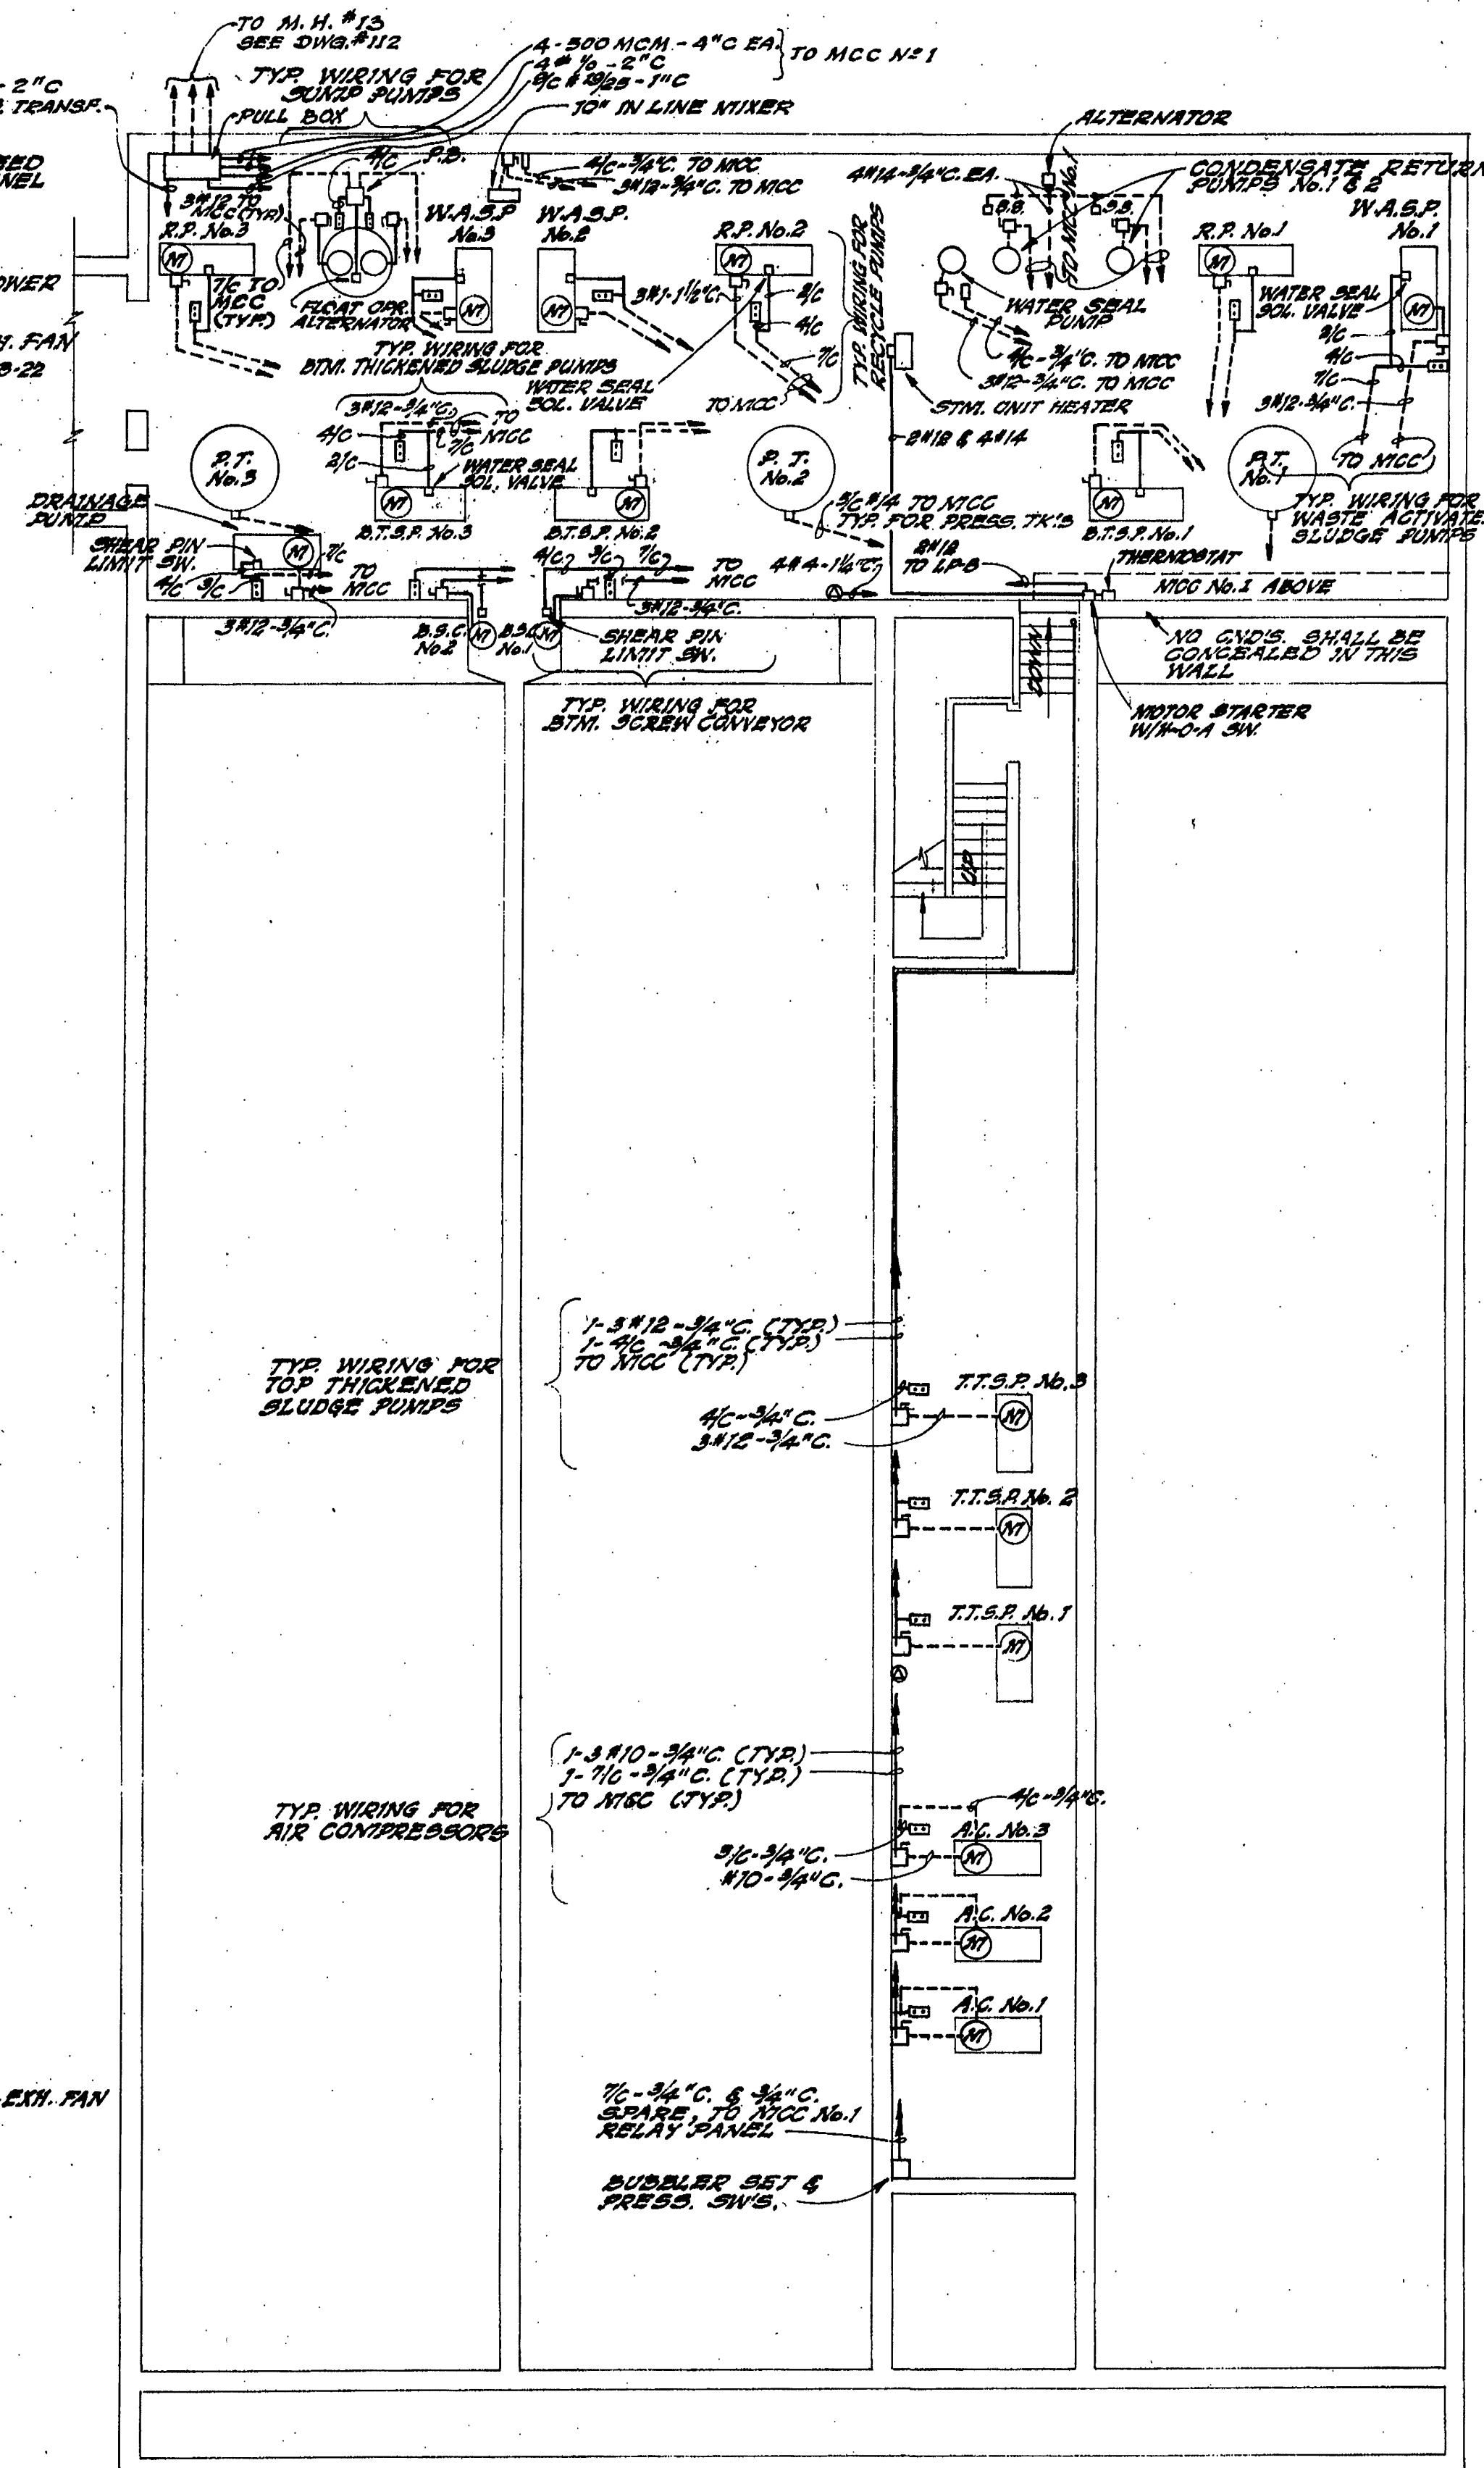


ELEV'S 899.0 & 894.0
POWER PLAN
SCALE: 1/8" = 1'-0"

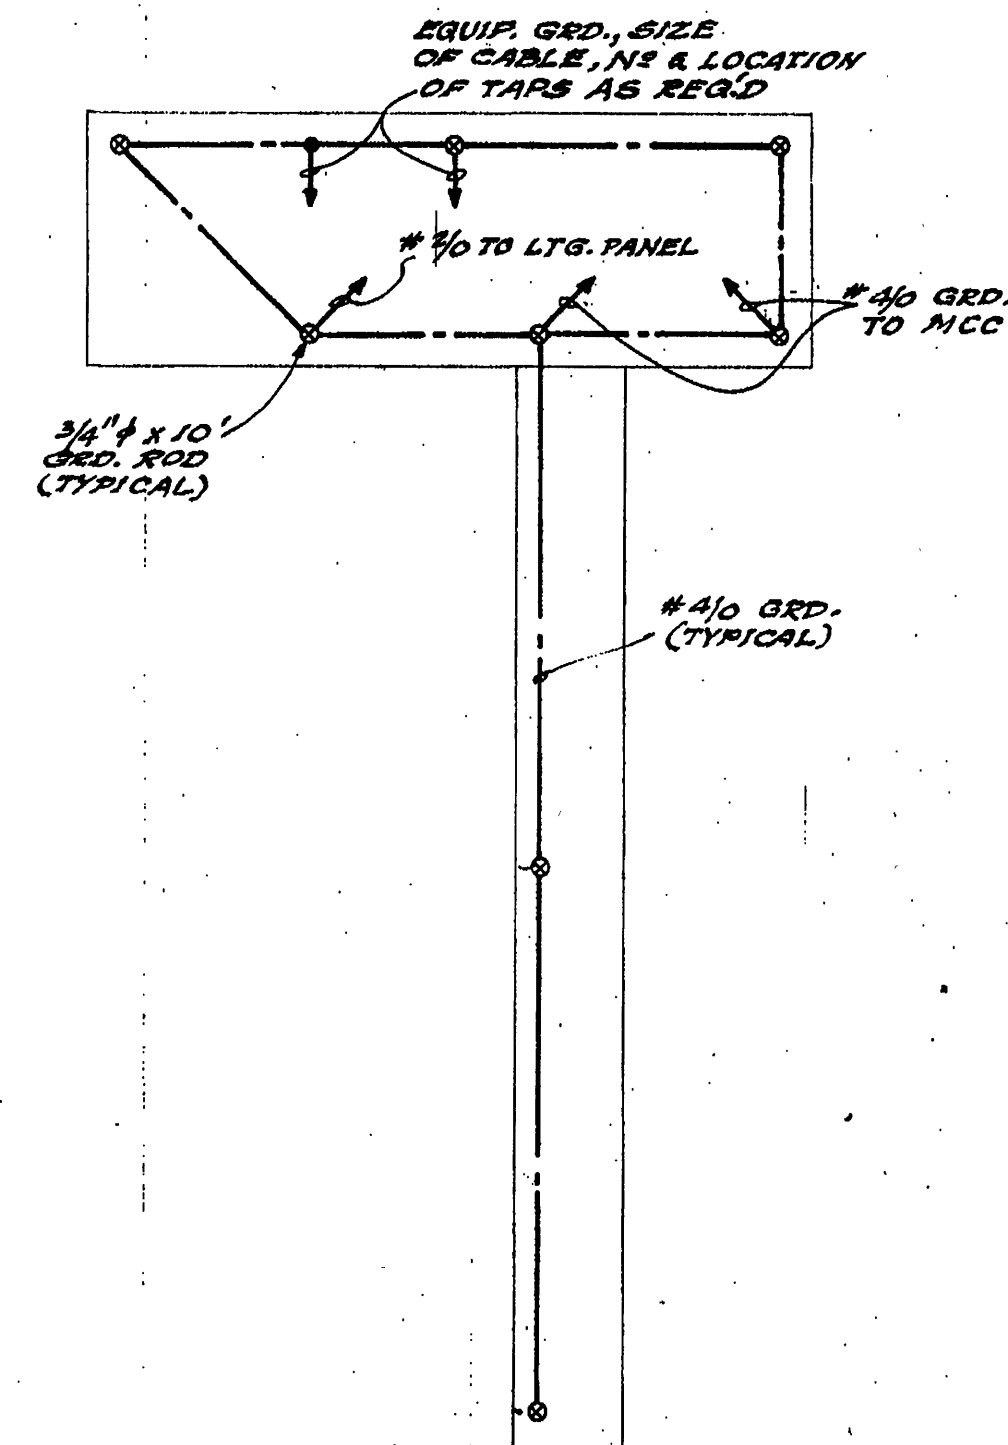

GROUNDING PLAN

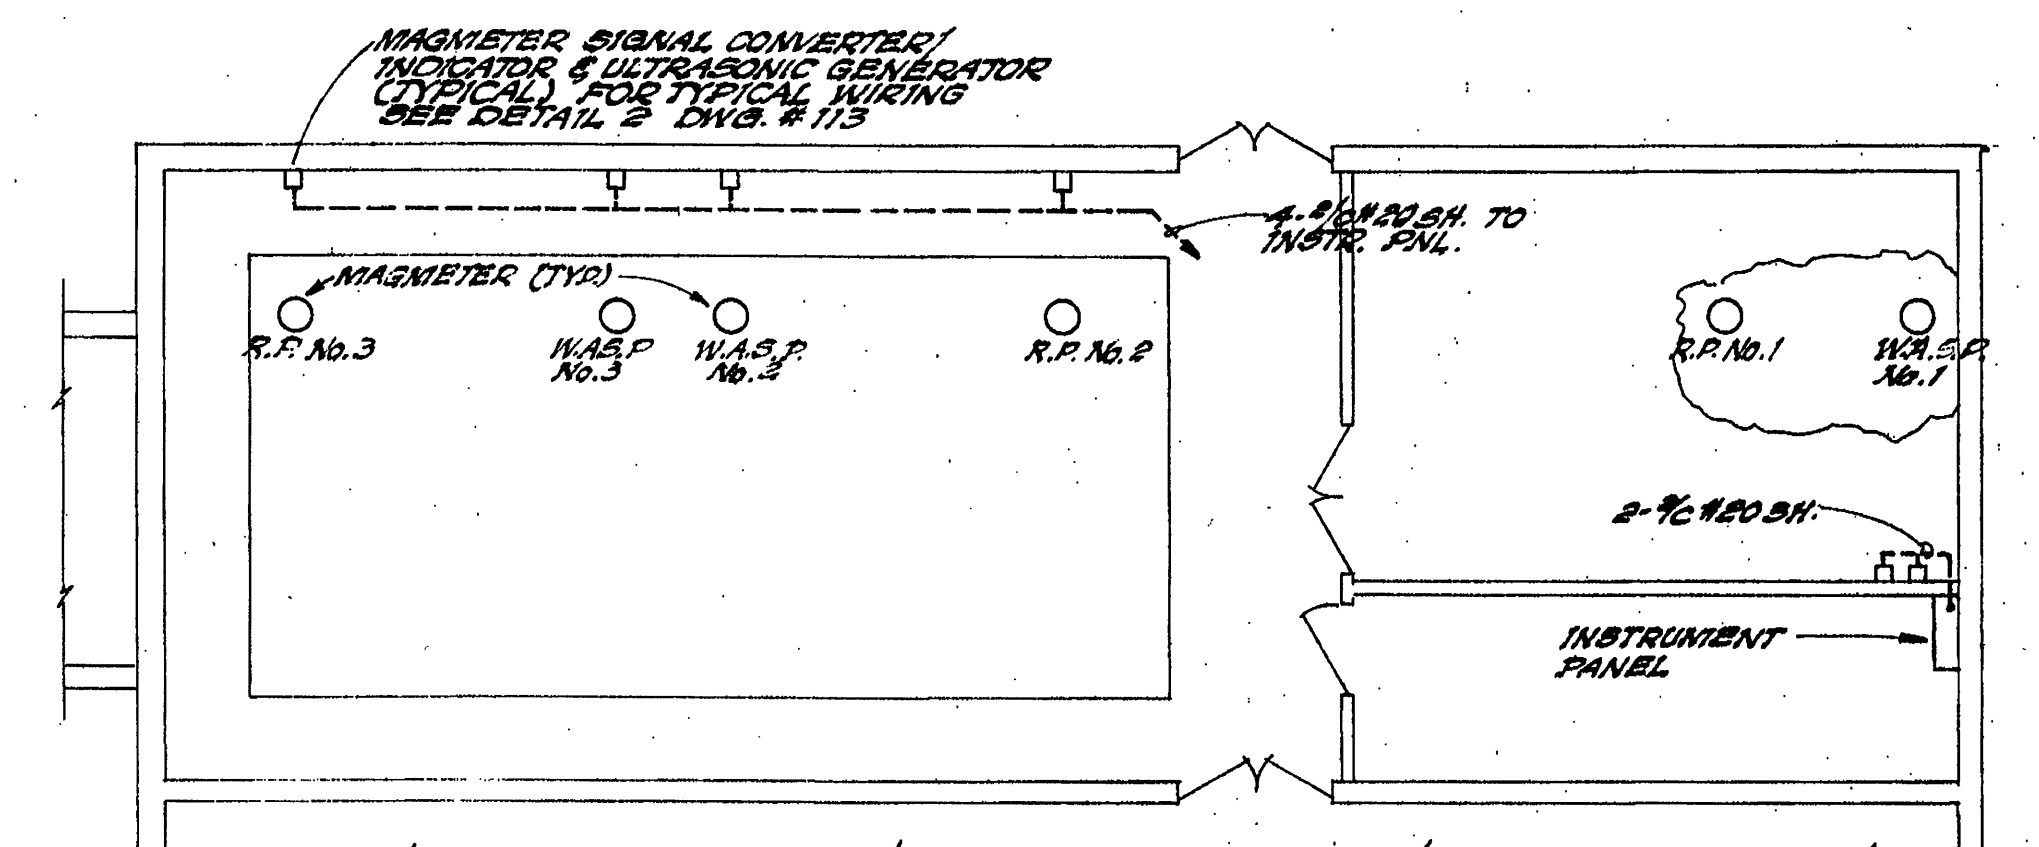

PLAN- MAGNETIC FLOWMETER WIRING
SCALE: 1/8" = 1'-0"

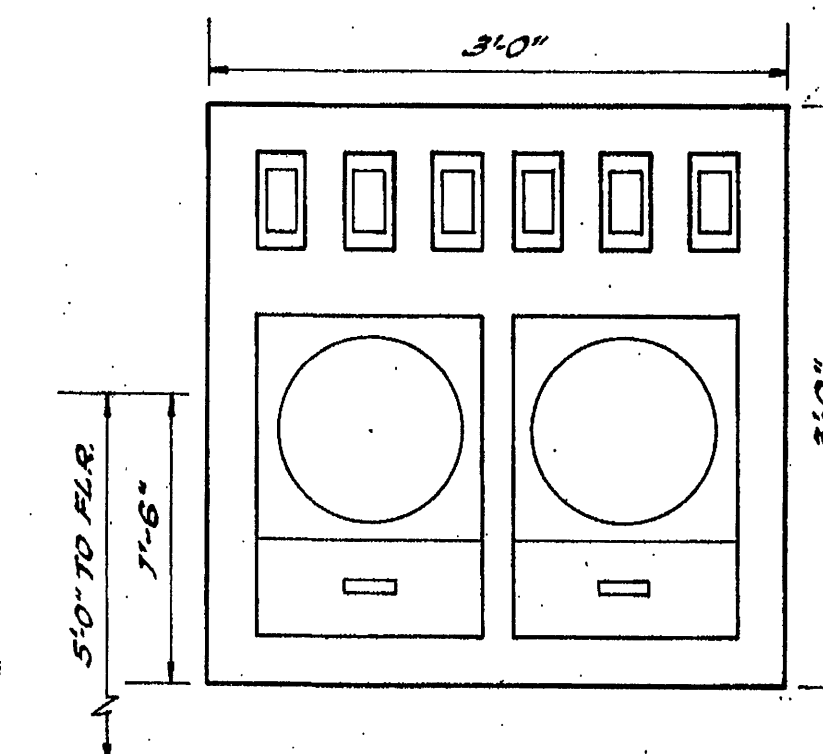

FRONT ELEVATION
INSTRUMENT PANEL
SCALE: 1" = 1'-0"

115

CONTR. "E"

ADDITIONS TO SEWAGE TREATMENT PLANT
ROANOKE, VIRGINIA

SLUDGE THICKENER
ELECTRICAL PLAN

ALVORD, BURDICK & HOWSON
ENGINEERS CHICAGO

1973