




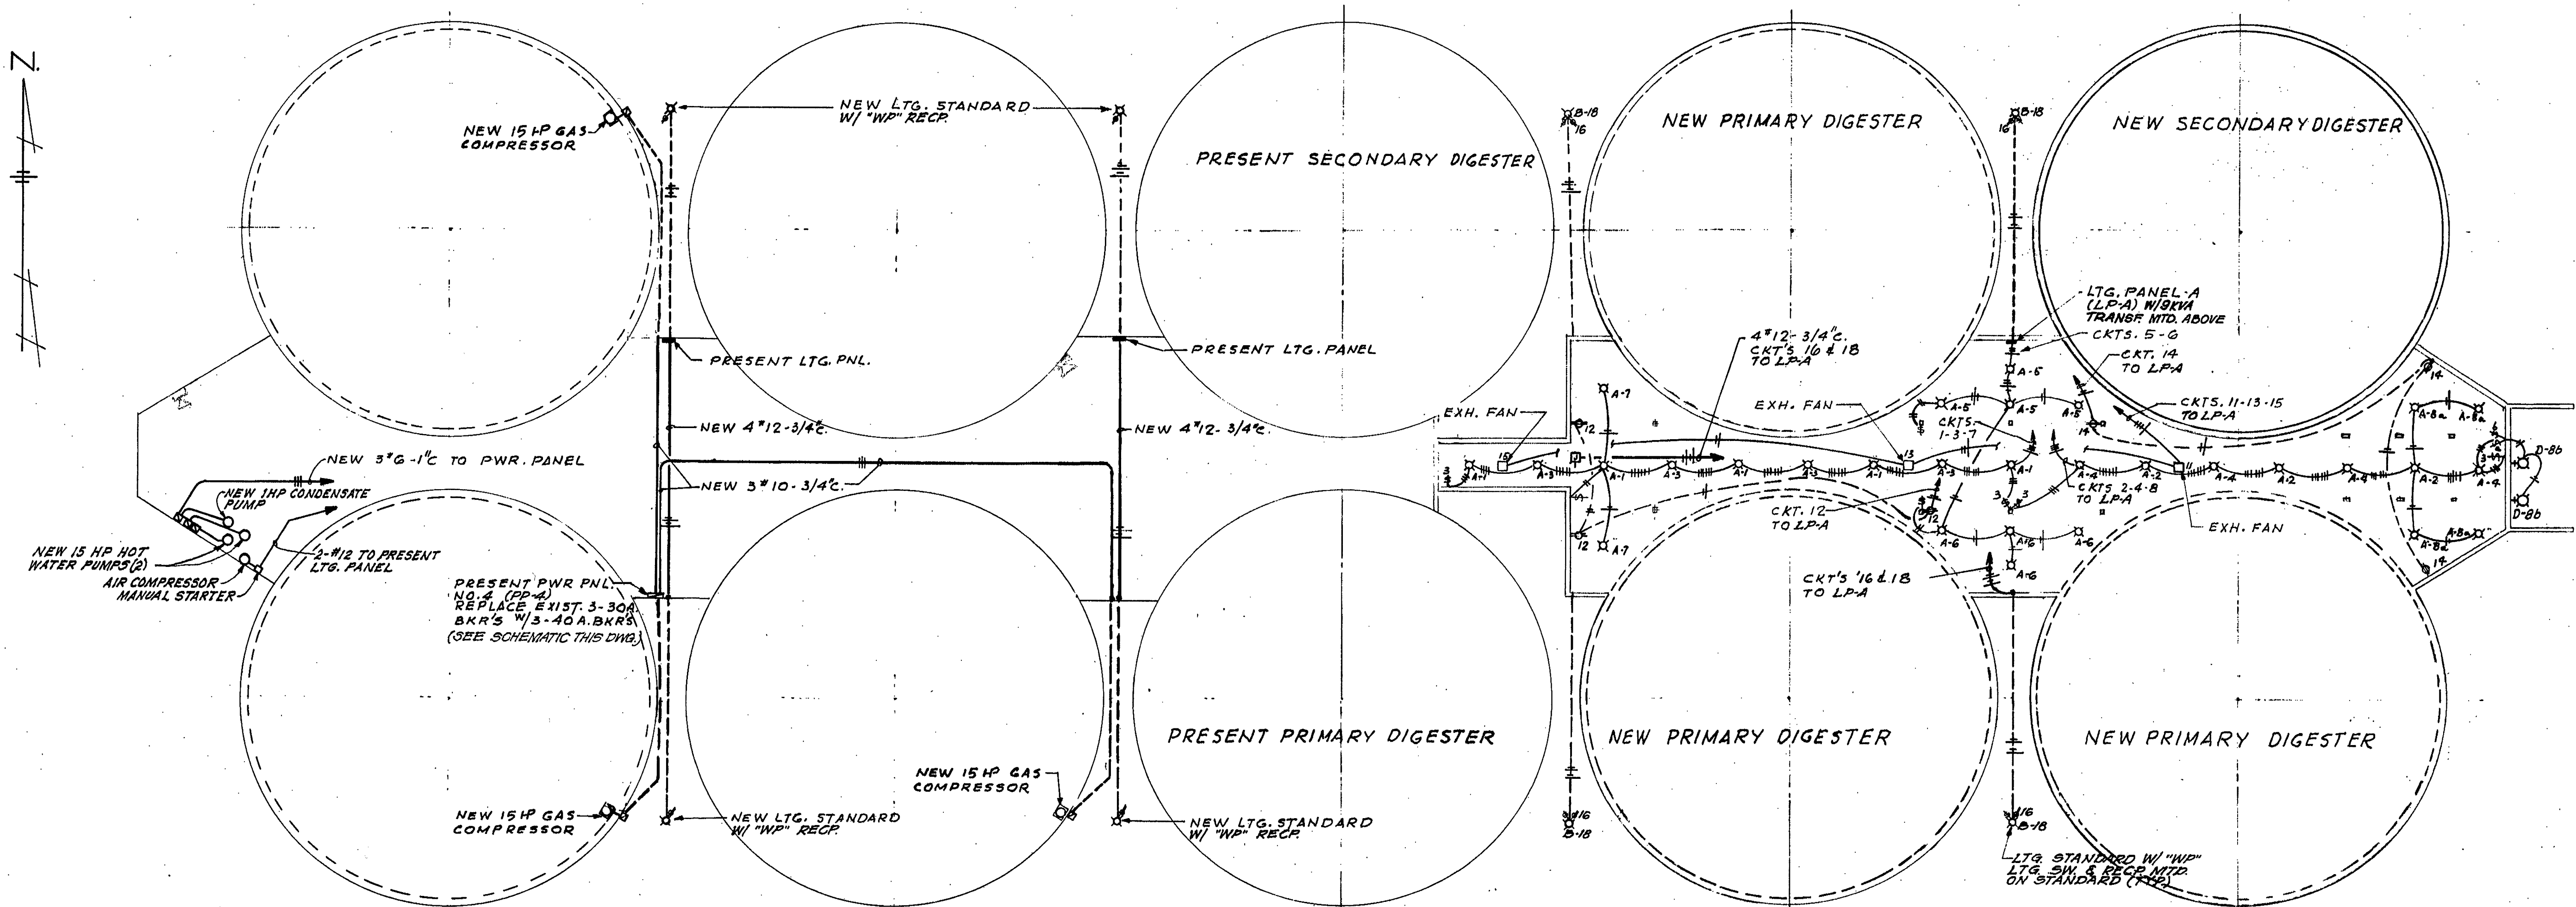


DIGESTER PLAN - FLOOR EL. 903.1 - LIGHTING
SCALE: 1" = 20'-0"

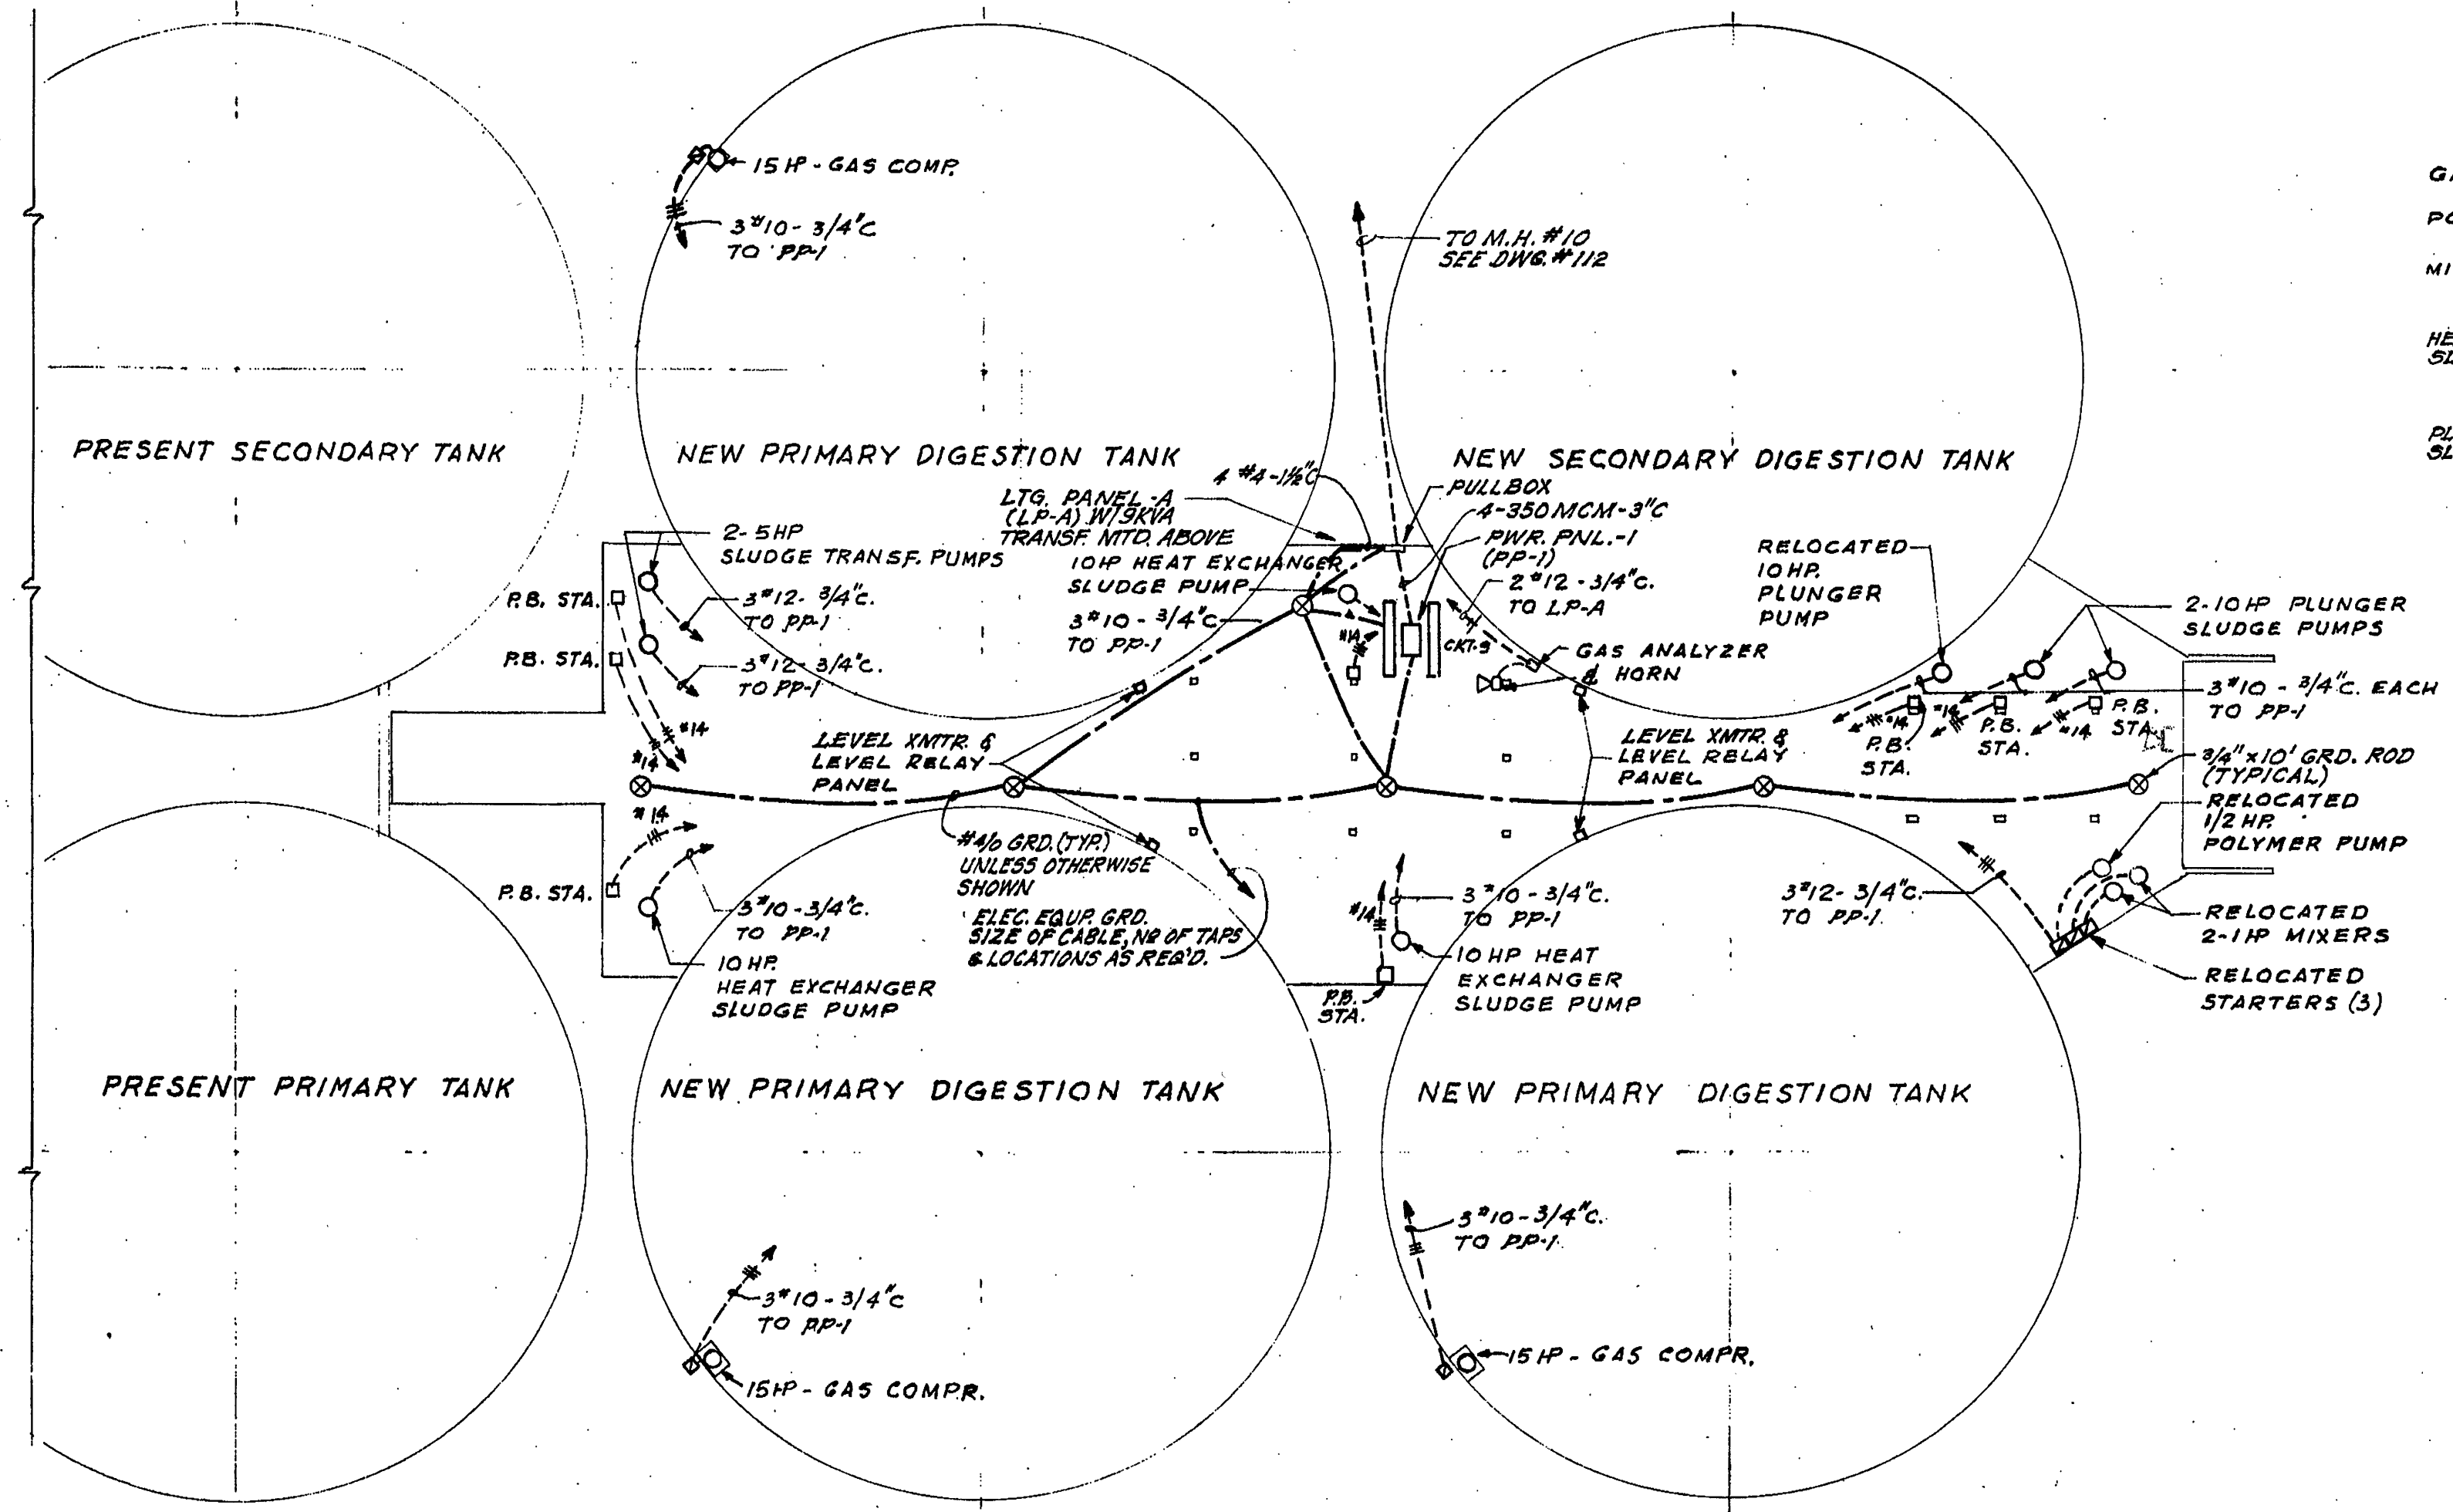


DIGESTER PLAN - FLOOR EL. 903.1 - POWER
SCALE: 1" = 20'-0"

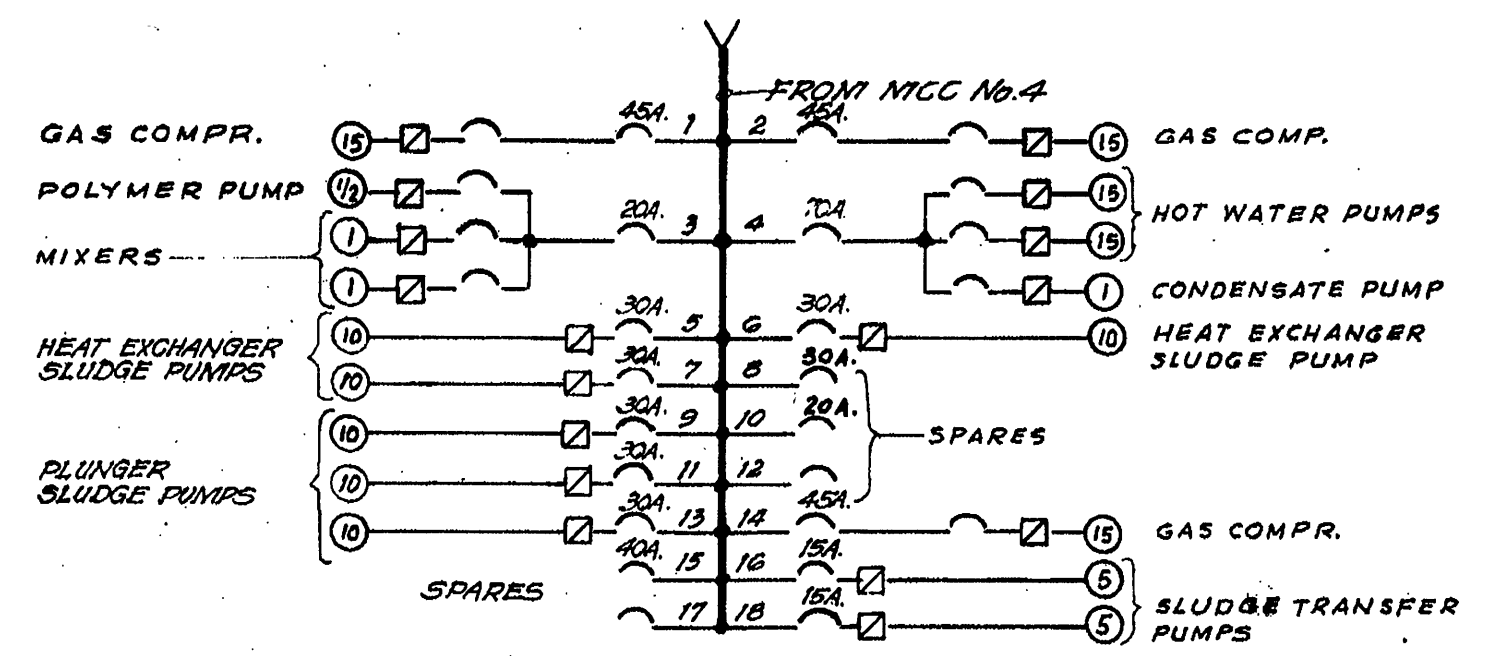

POWER PANEL-1 (PP-1)

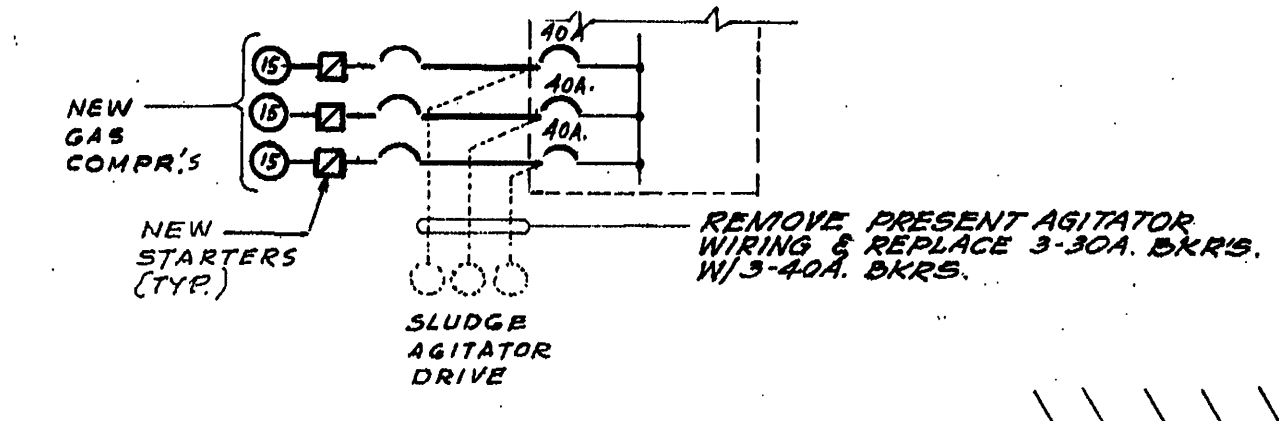


PRESENT POWER PNL No. 4

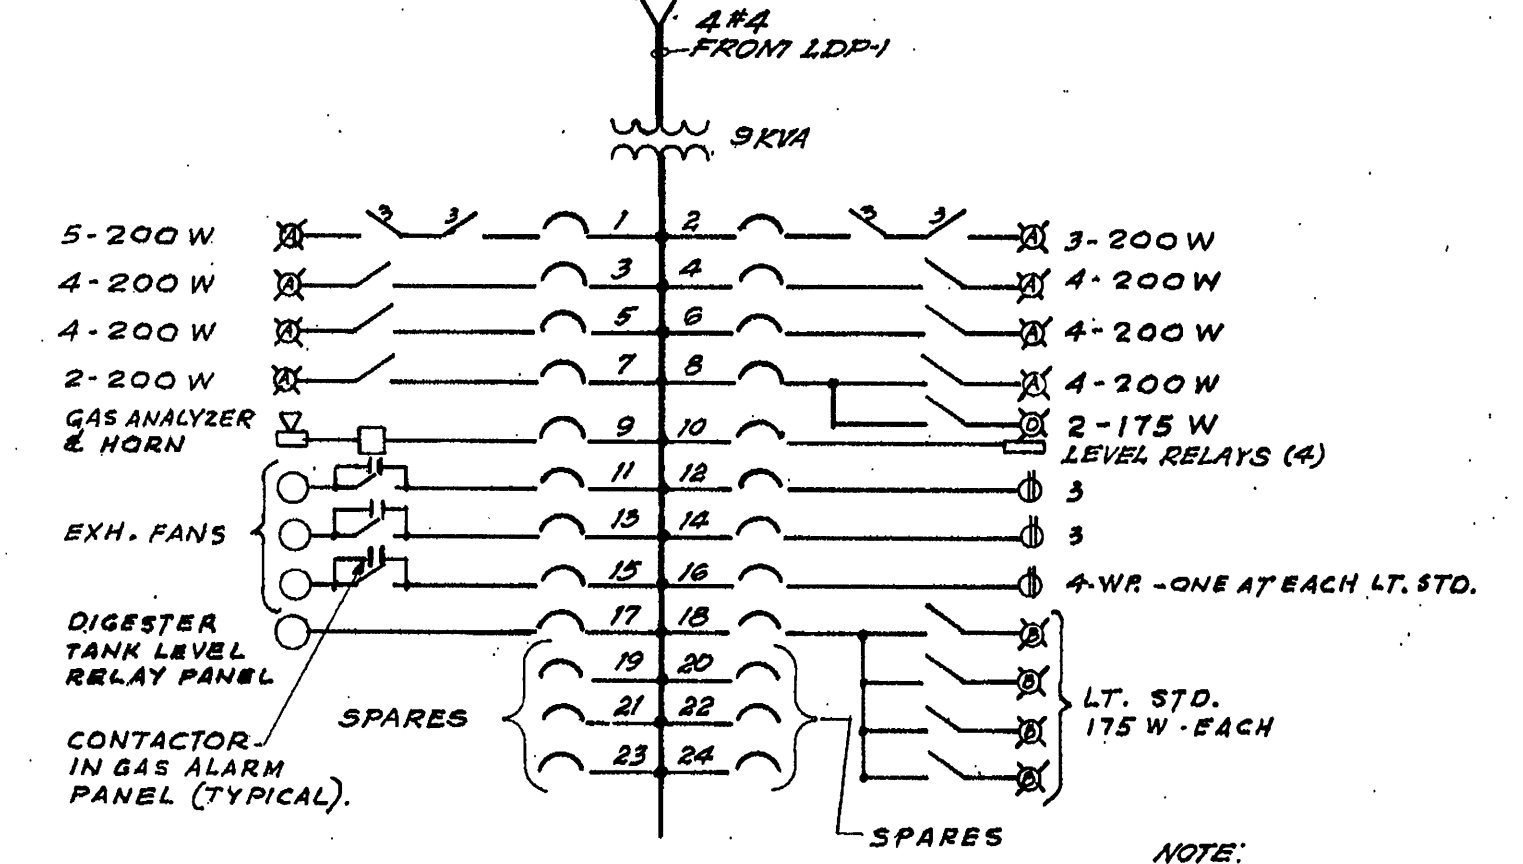

LIGHTING PANEL-A (LP-A)

NOTE: ALL BKRS. 20A. MIN. UNLESS OTHERWISE NOTED.

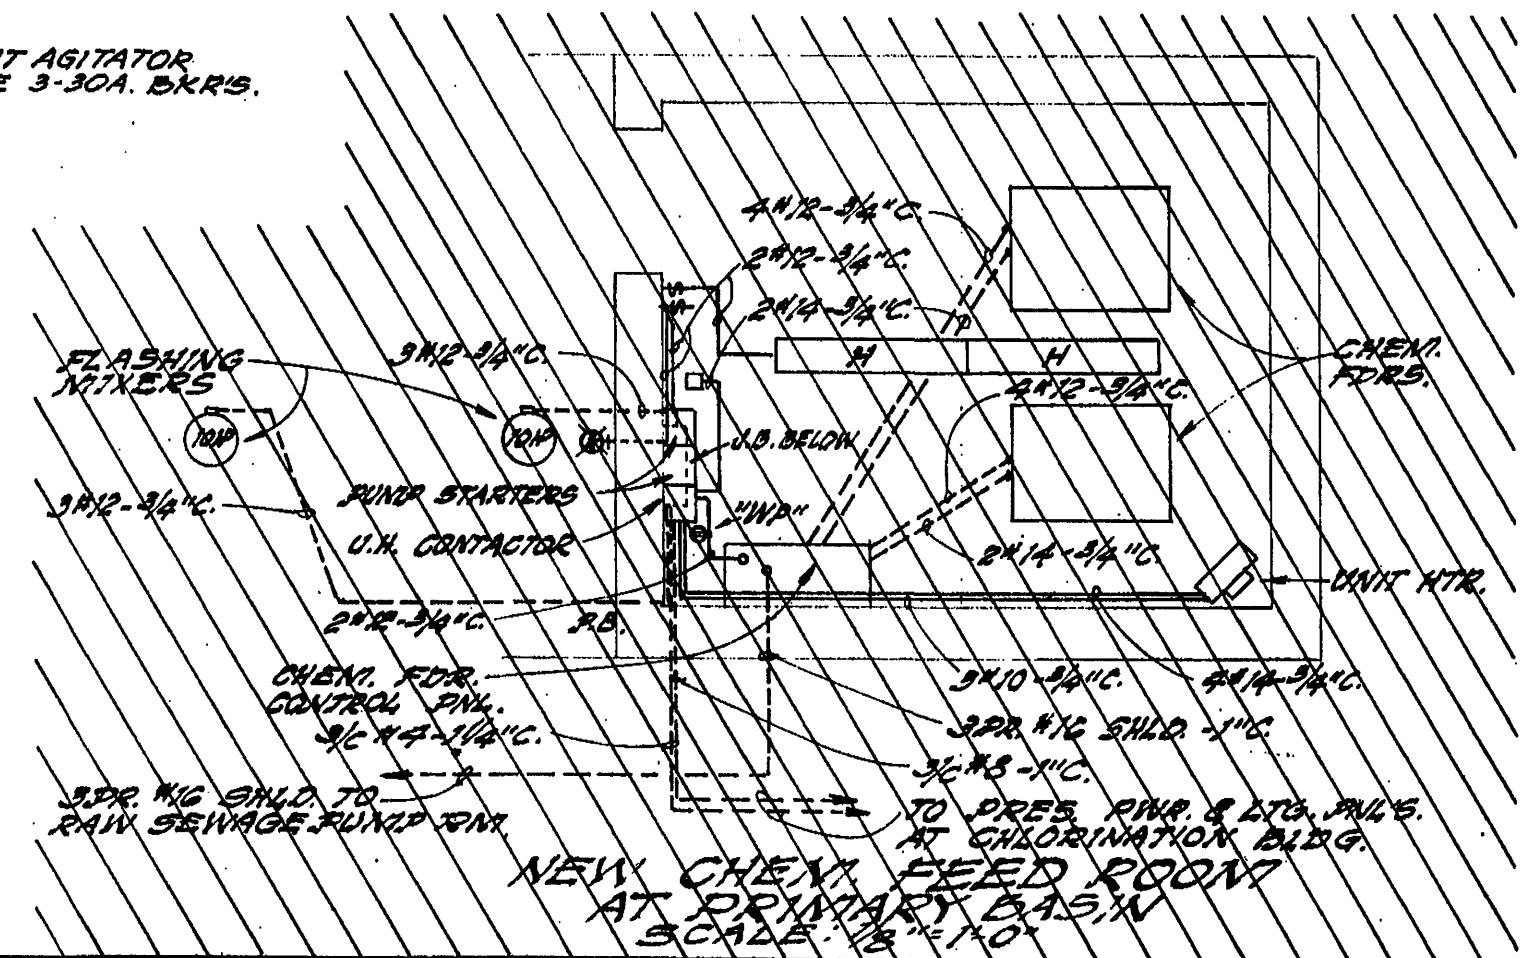

CONTR. "E"

ADDITIONS TO SEWAGE TREATMENT PLANT
ROANOKE, VIRGINIA

**DIGESTERS
ELECTRICAL PLAN**

ALVORD, BURDICK & HOWSON
ENGINEERS CHICAGO

1973