


0001-2
JOB# 00001
2/18/00
PLOT SCALE:
XREF(S): 0001b1

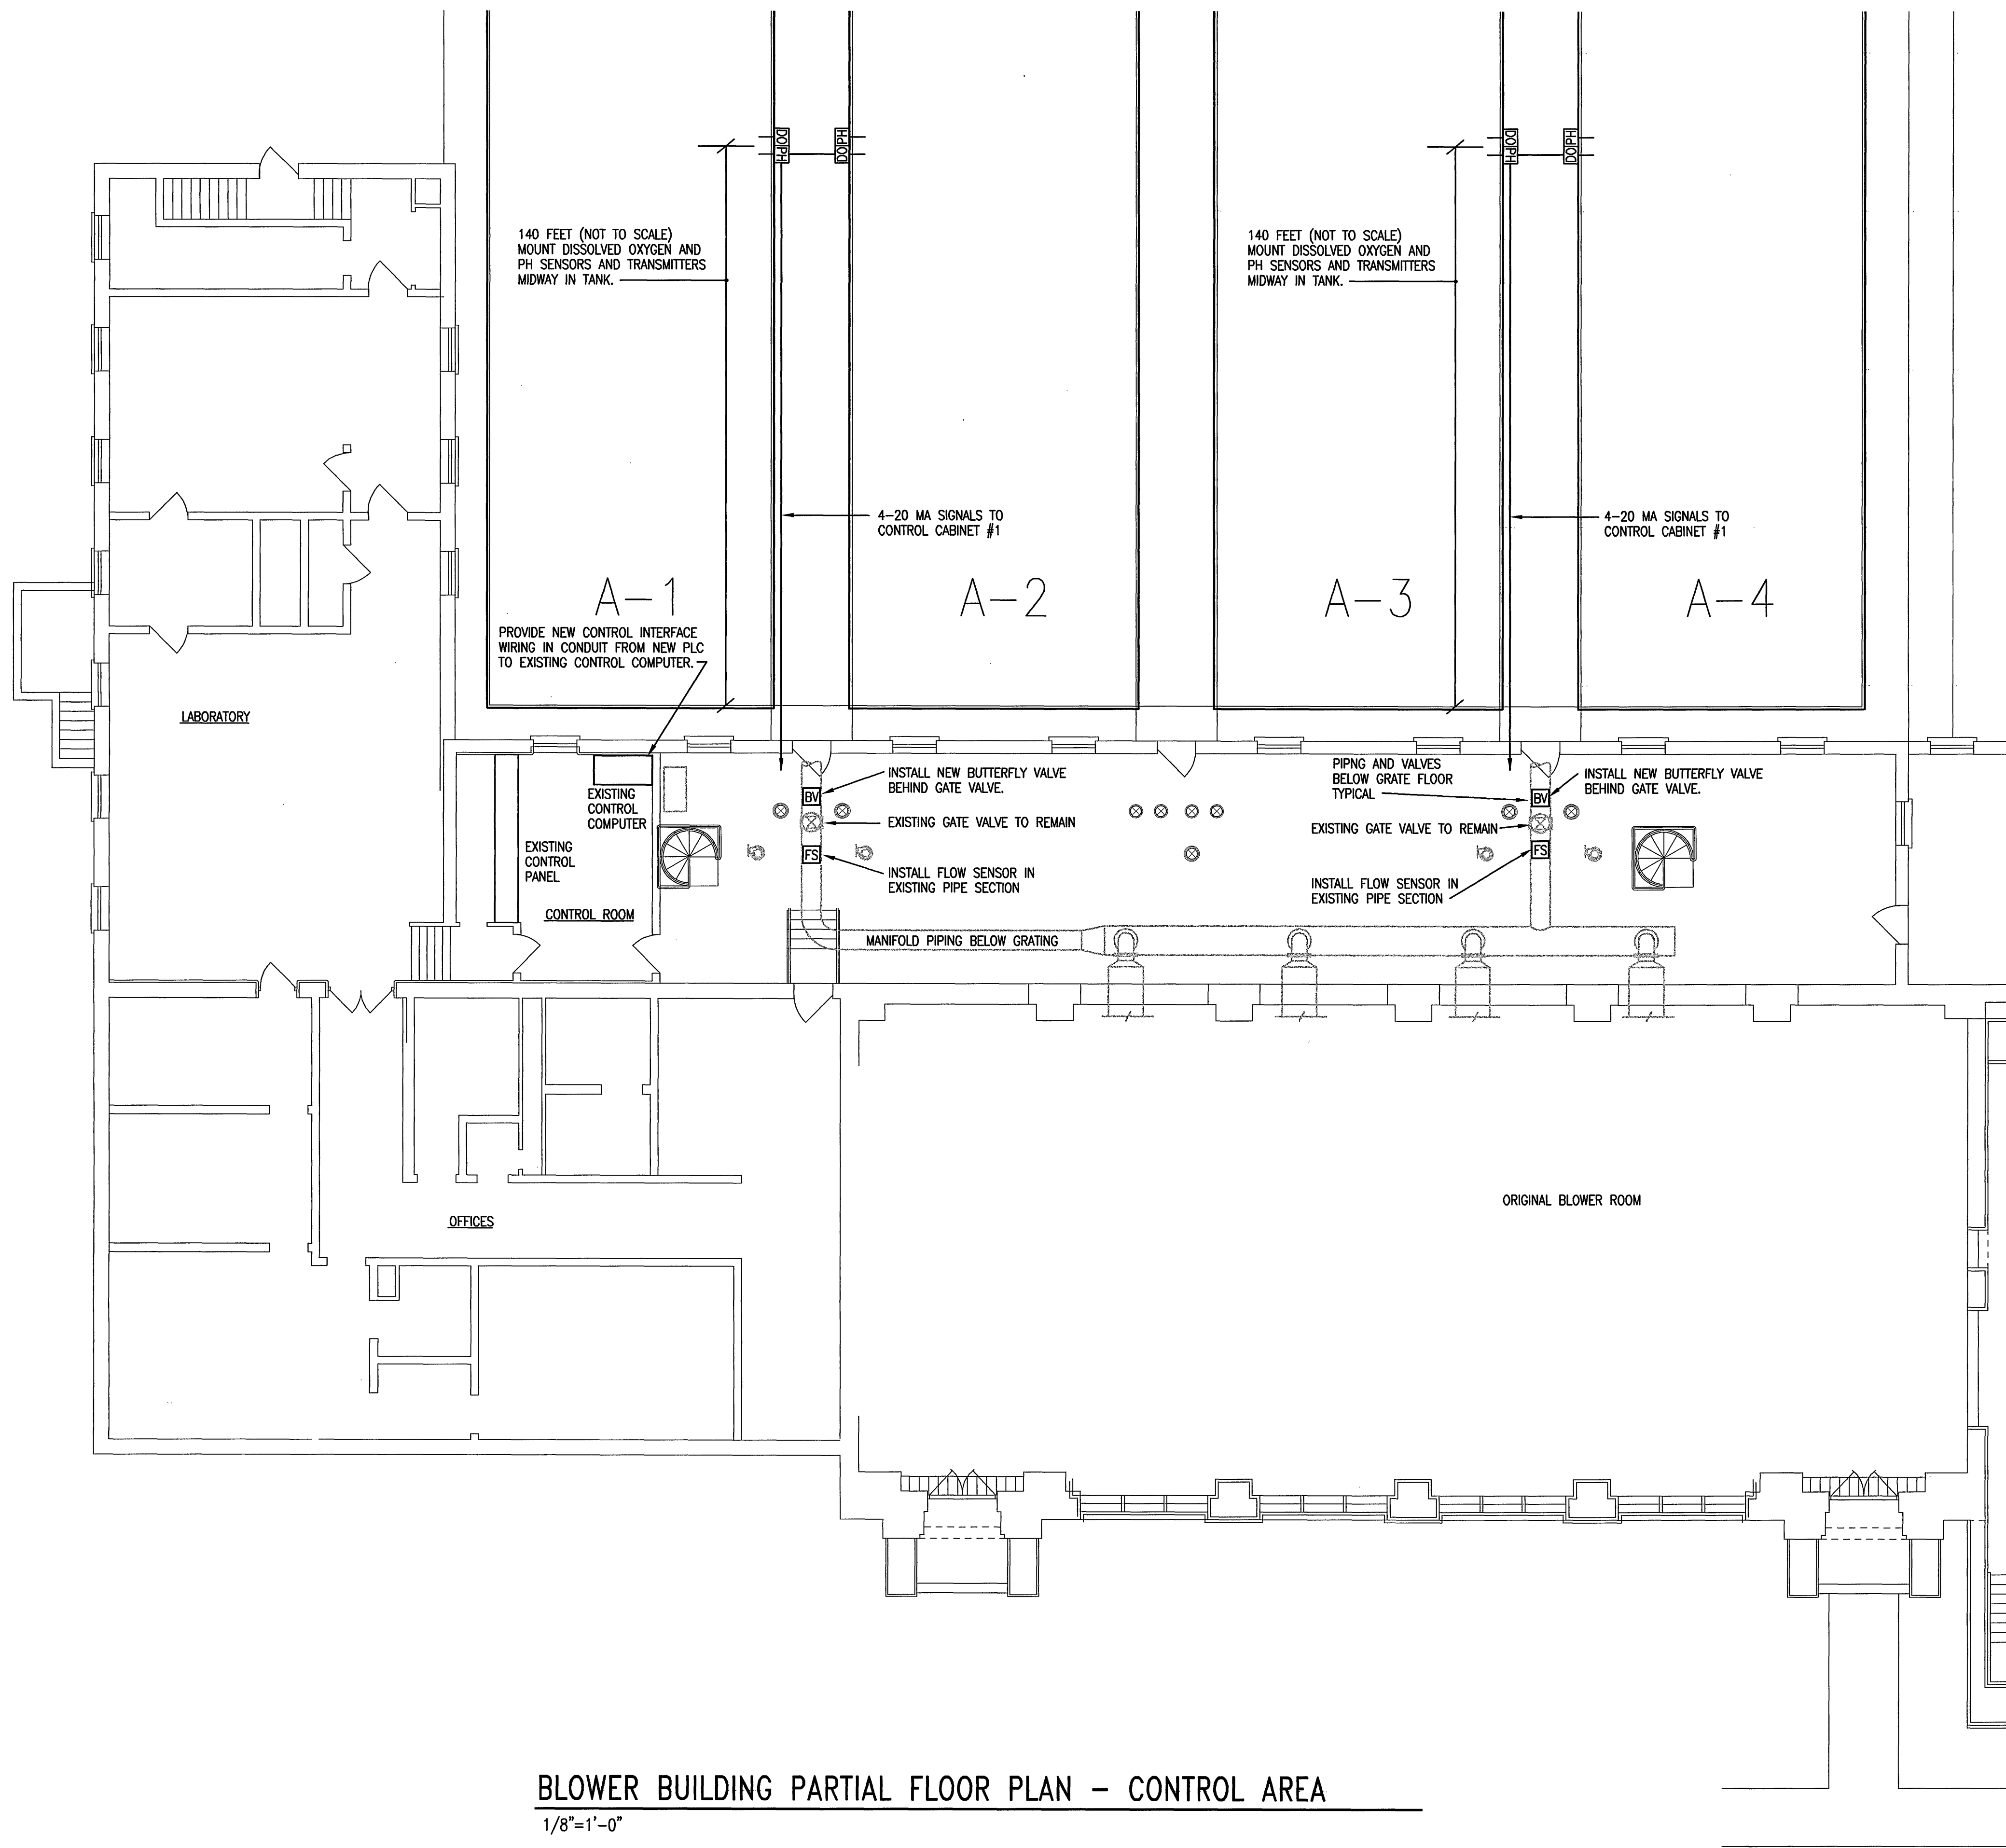


BLOWER BUILDING PARTIAL FLOOR PLAN - CONTROL AREA
1/8"=1'-0"

LEGEND	
	DUPLEX RECEPTACLE
	DUPLEX RECEPTACLE WITH GROUND FAULT INTERRUPTER
	DUPLEX RECEPTACLE - WEATHERPROOF
	VALVE ACTUATOR
	BUTTERFLY VALVE WITH ACTUATOR
	FLOW SENSOR
	DISSOLVED OXYGEN SENSOR/TRANSMITTER
	PH ACIDITY SENSOR/TRANSMITTER
	MANIFOLD AIR PRESSURE SENSOR
	WIRING JUNCTION BOX OR EQUIPMENT JUNCTION
	PULL BOX
	CONTACTOR
	PANELBOARD
	PANELBOARD
	SPECIAL CABINET
	MOTOR
	SAFETY DISCONNECT SWITCH
	FUSED DISCONNECT SWITCH
	NON-FUSED DISCONNECT SWITCH
	HOMERUN TO PANELBOARD
	WIRERUN
	ABANDON
	EXISTING
	RELOCATED
	SHEET NOTE
	EQUIPMENT GROUNDING CONDUCTOR

KEY PLAN

GENERAL NOTES

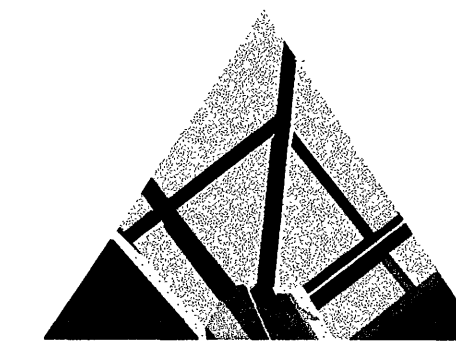


SPECTRUM DESIGN

325 MOUNTAIN AVENUE ROANOKE, VIRGINIA 24016 540.345.8020
ROANOKE • MARION • VIRGINIA BEACH

**ROANOKE SEWAGE
TREATMENT PLANT**

**BLOWER
ROOM
RENOVATION**

SPECTRUM DESIGN PROJECT NO. 00001

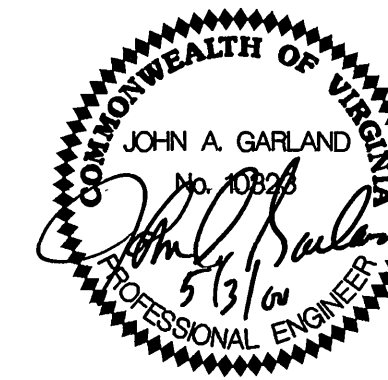

DATE 28 APRIL 2000
DESIGN ARCHITECT
PROJECT ARCHITECT LER
PROJECT ENGINEER LER
CHECKED BY LER
DRAWN BY LER
REVISIONS NUMBER DATE

SHEET TITLE

**BLOWER BUILDING
CONTROL AREA**

E-1.1