




1 WEST ELEVATION
FRONT ENTRANCE
1/8"=1'-0"

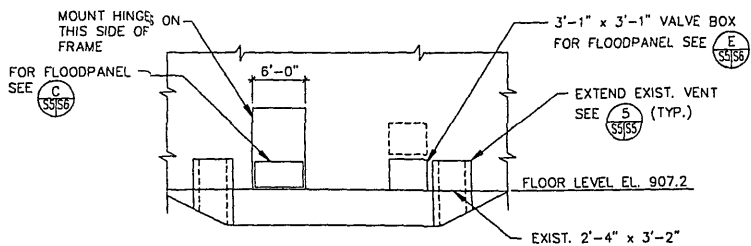


2 NORTH ELEVATION (PARTIAL)
LOADING DOCK AREA
1/8"=1'-0"

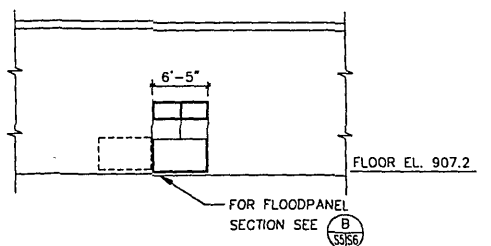


3 EAST ELEVATION (PARTIAL)
1/8"=1'-0"

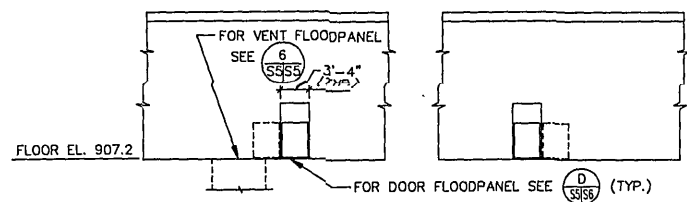


4 SOUTH ELEVATION (PARTIAL)
1/8"=1'-0"

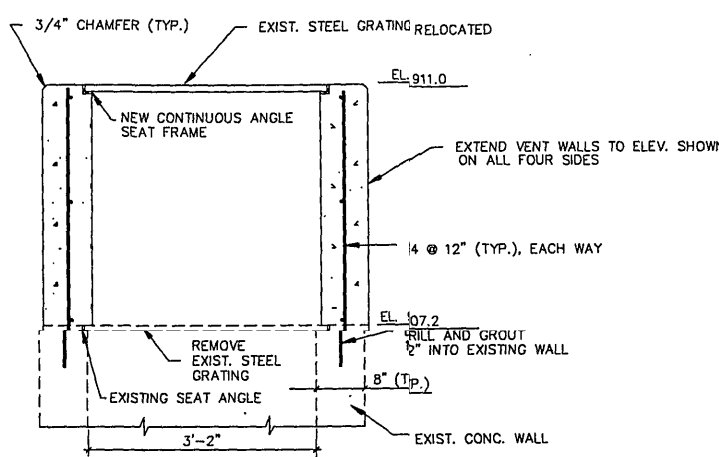

5 SECTION
1"=1'-0"

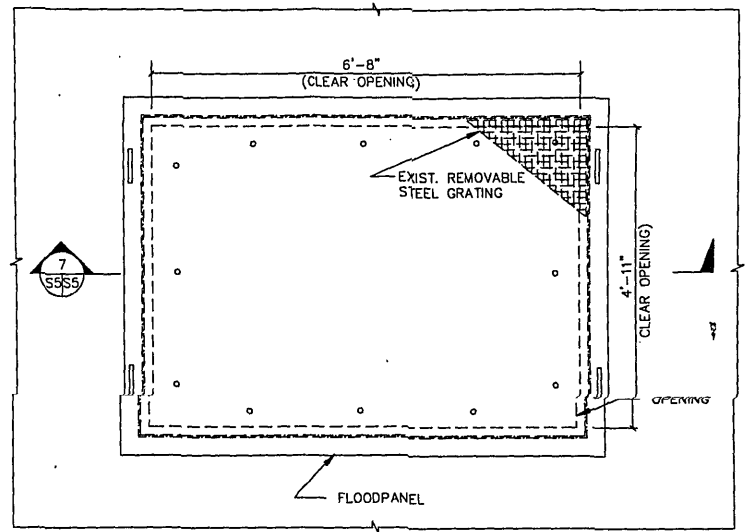


6 PLAN - VENT FLOODPANEL (1 REQ'D)
1"=1'-0"

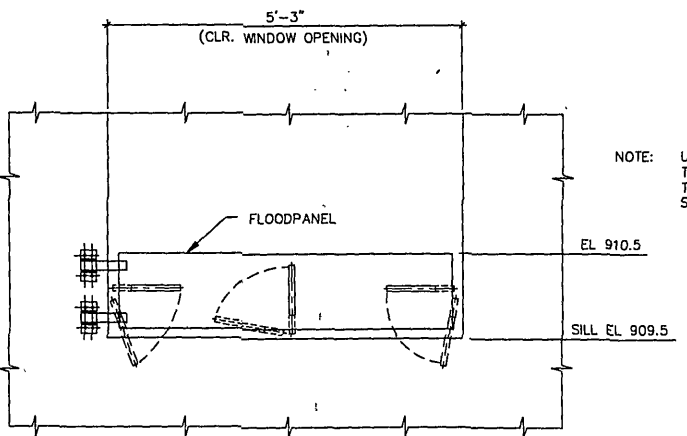

7 WINDOW FLOODPANEL (4 REQ'D)
1"=1'-0"

NOTE: USE TYPE A HEAD, TYPE B JAMB, AND TYPE B SILL. SEE PLATE S-13

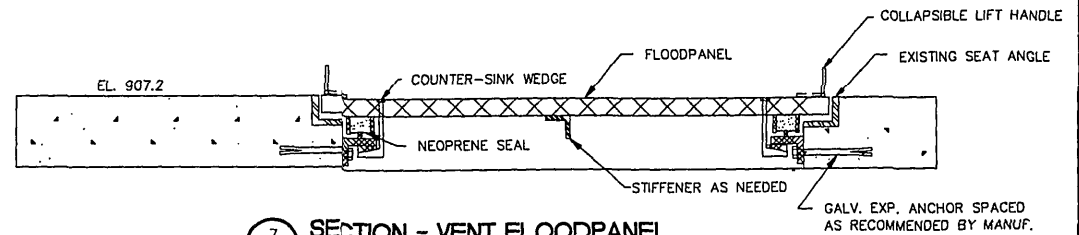

8 SECTION - VENT FLOODPANEL
N.T.S.

AS BUILT RECORD DWG.		B-91-99	5/8
Symbol	Descriptions	Date	Approved
U.S. ARMY ENGINEER DISTRICT CORPS OF ENGINEERS WILMINGTON, NORTH CAROLINA ROANOKE, VIRGINIA FLOOD REDUCTION PROJECT SEWAGE TREATMENT PLANT FLOODPROOFING FILTER BUILDING			
Designed by:	JKJ	Scale:	AS SHOWN
Drawn by:	JKJ	Date:	APRIL 1991
Checked by:	JBW	Drawing Code:	RR102-02-32
Reviewed by:	EDP, P.E. CHIEF, DESIGN BRANCH	File Number:	RRSTP6
Approved by:	EDP, P.E. CHIEF, DESIGN BRANCH	Plot Scale:	1"=1'-0"
		Sheet	14 of 25