


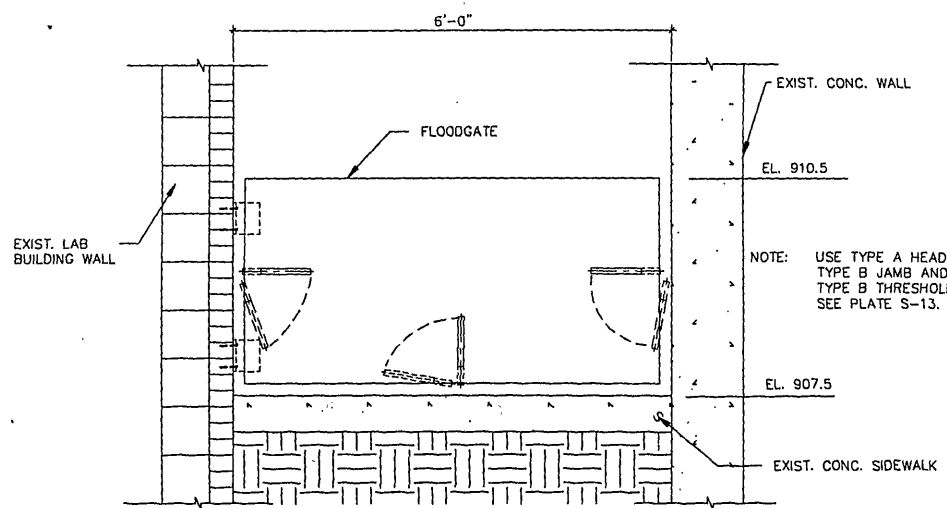


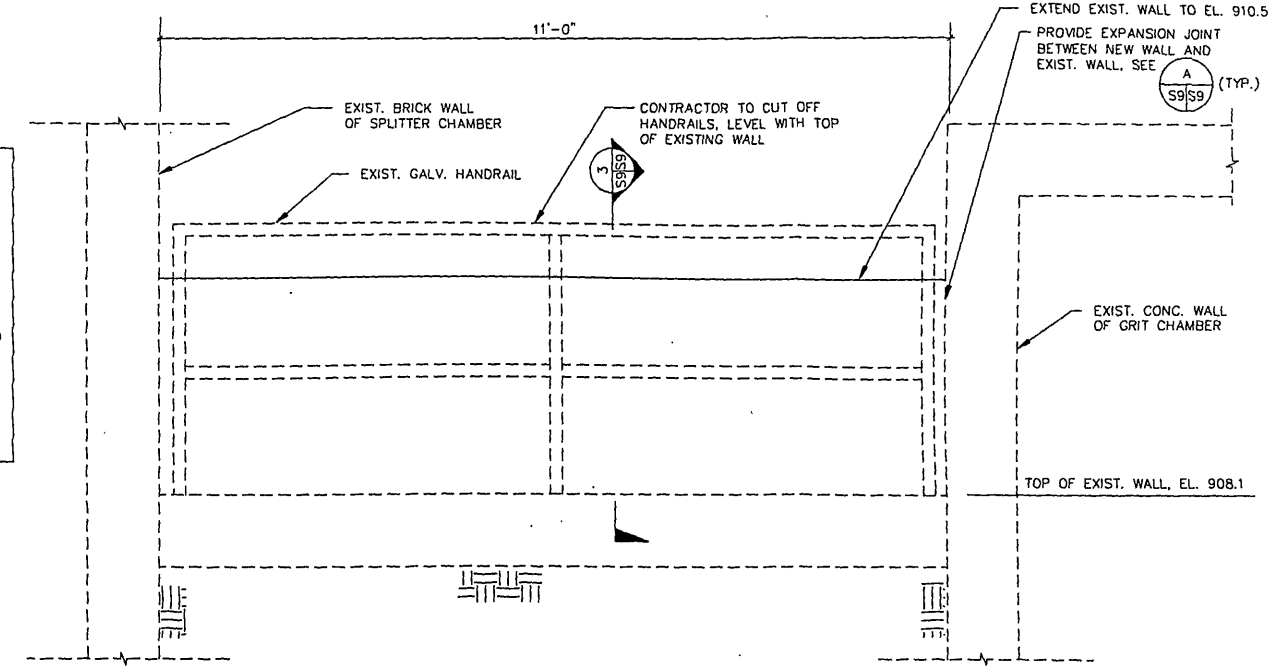


1 ELEVATION - SIDEWALK FLOODGATE (1 REQ'D)
1"=1'-0"
(SEE PLATE S-1 FOR LOCATION)

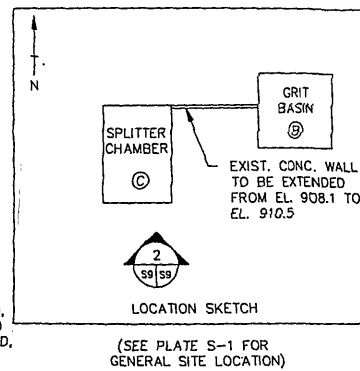


2 ELEVATION - EXISTING WALL BETWEEN SPLITTER CHAMBER AND GRIT BASIN
1"=1'-0"

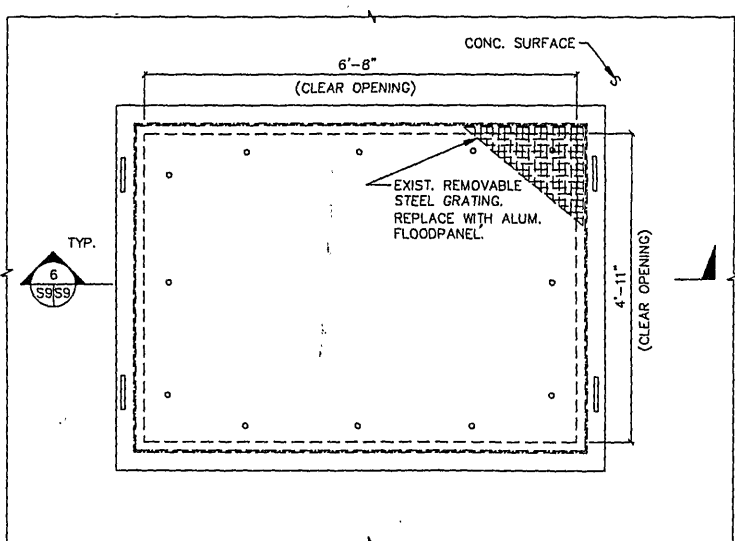


5 PLAN - VENT FLOODPANEL (1 REQ'D)
1"=1'-0"
(SEE PLATE S-1 FOR LOCATION)

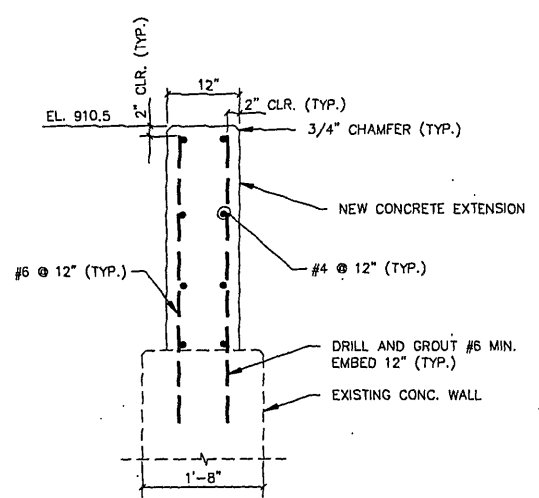

3 WALL SECTION
1"=1'-0"

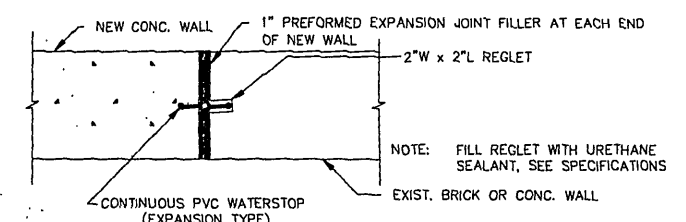

A EXPANSION JOINT DETAIL
NTS

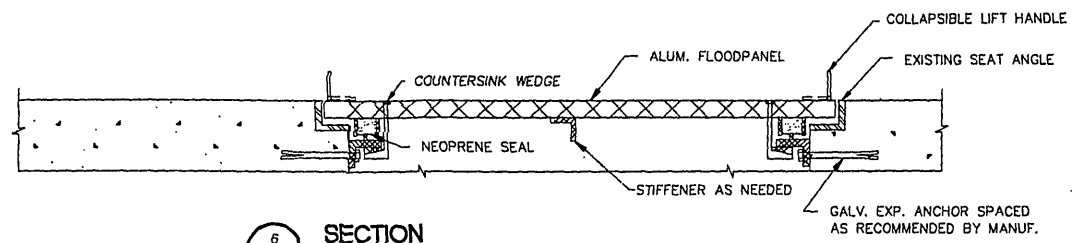

6 SECTION
N.T.S.

AS BUILT RECORD DWG.		B-91-93		5FH
Symbol	Descriptions	Date	Approved	
Revisions				
U.S. ARMY ENGINEER DISTRICT CORPS OF ENGINEERS WILMINGTON, NORTH CAROLINA				
ROANOKE, VIRGINIA				
FLOOD REDUCTION PROJECT				
SEWAGE TREATMENT PLANT FLOODPROOFING MISCELLANEOUS AREAS				
Designed by:	JKJ	Scale:	AS SHOWN	File Number:
Drawn by:	JKJ	Date:	APRIL, 1991	RRSTP10
Checked by:	JBW	Drawing Code:	RR102-02-32	S-9
Reviewed by:	John B. Williams, P.E. CHIEF, STRUCTURES SECTION			
Approved by:	Ed R. Miller, P.E. CHIEF, DESIGN BRANCH			
PLOT SCALE: 1"=1'-0"				Sheet 18 of 25