


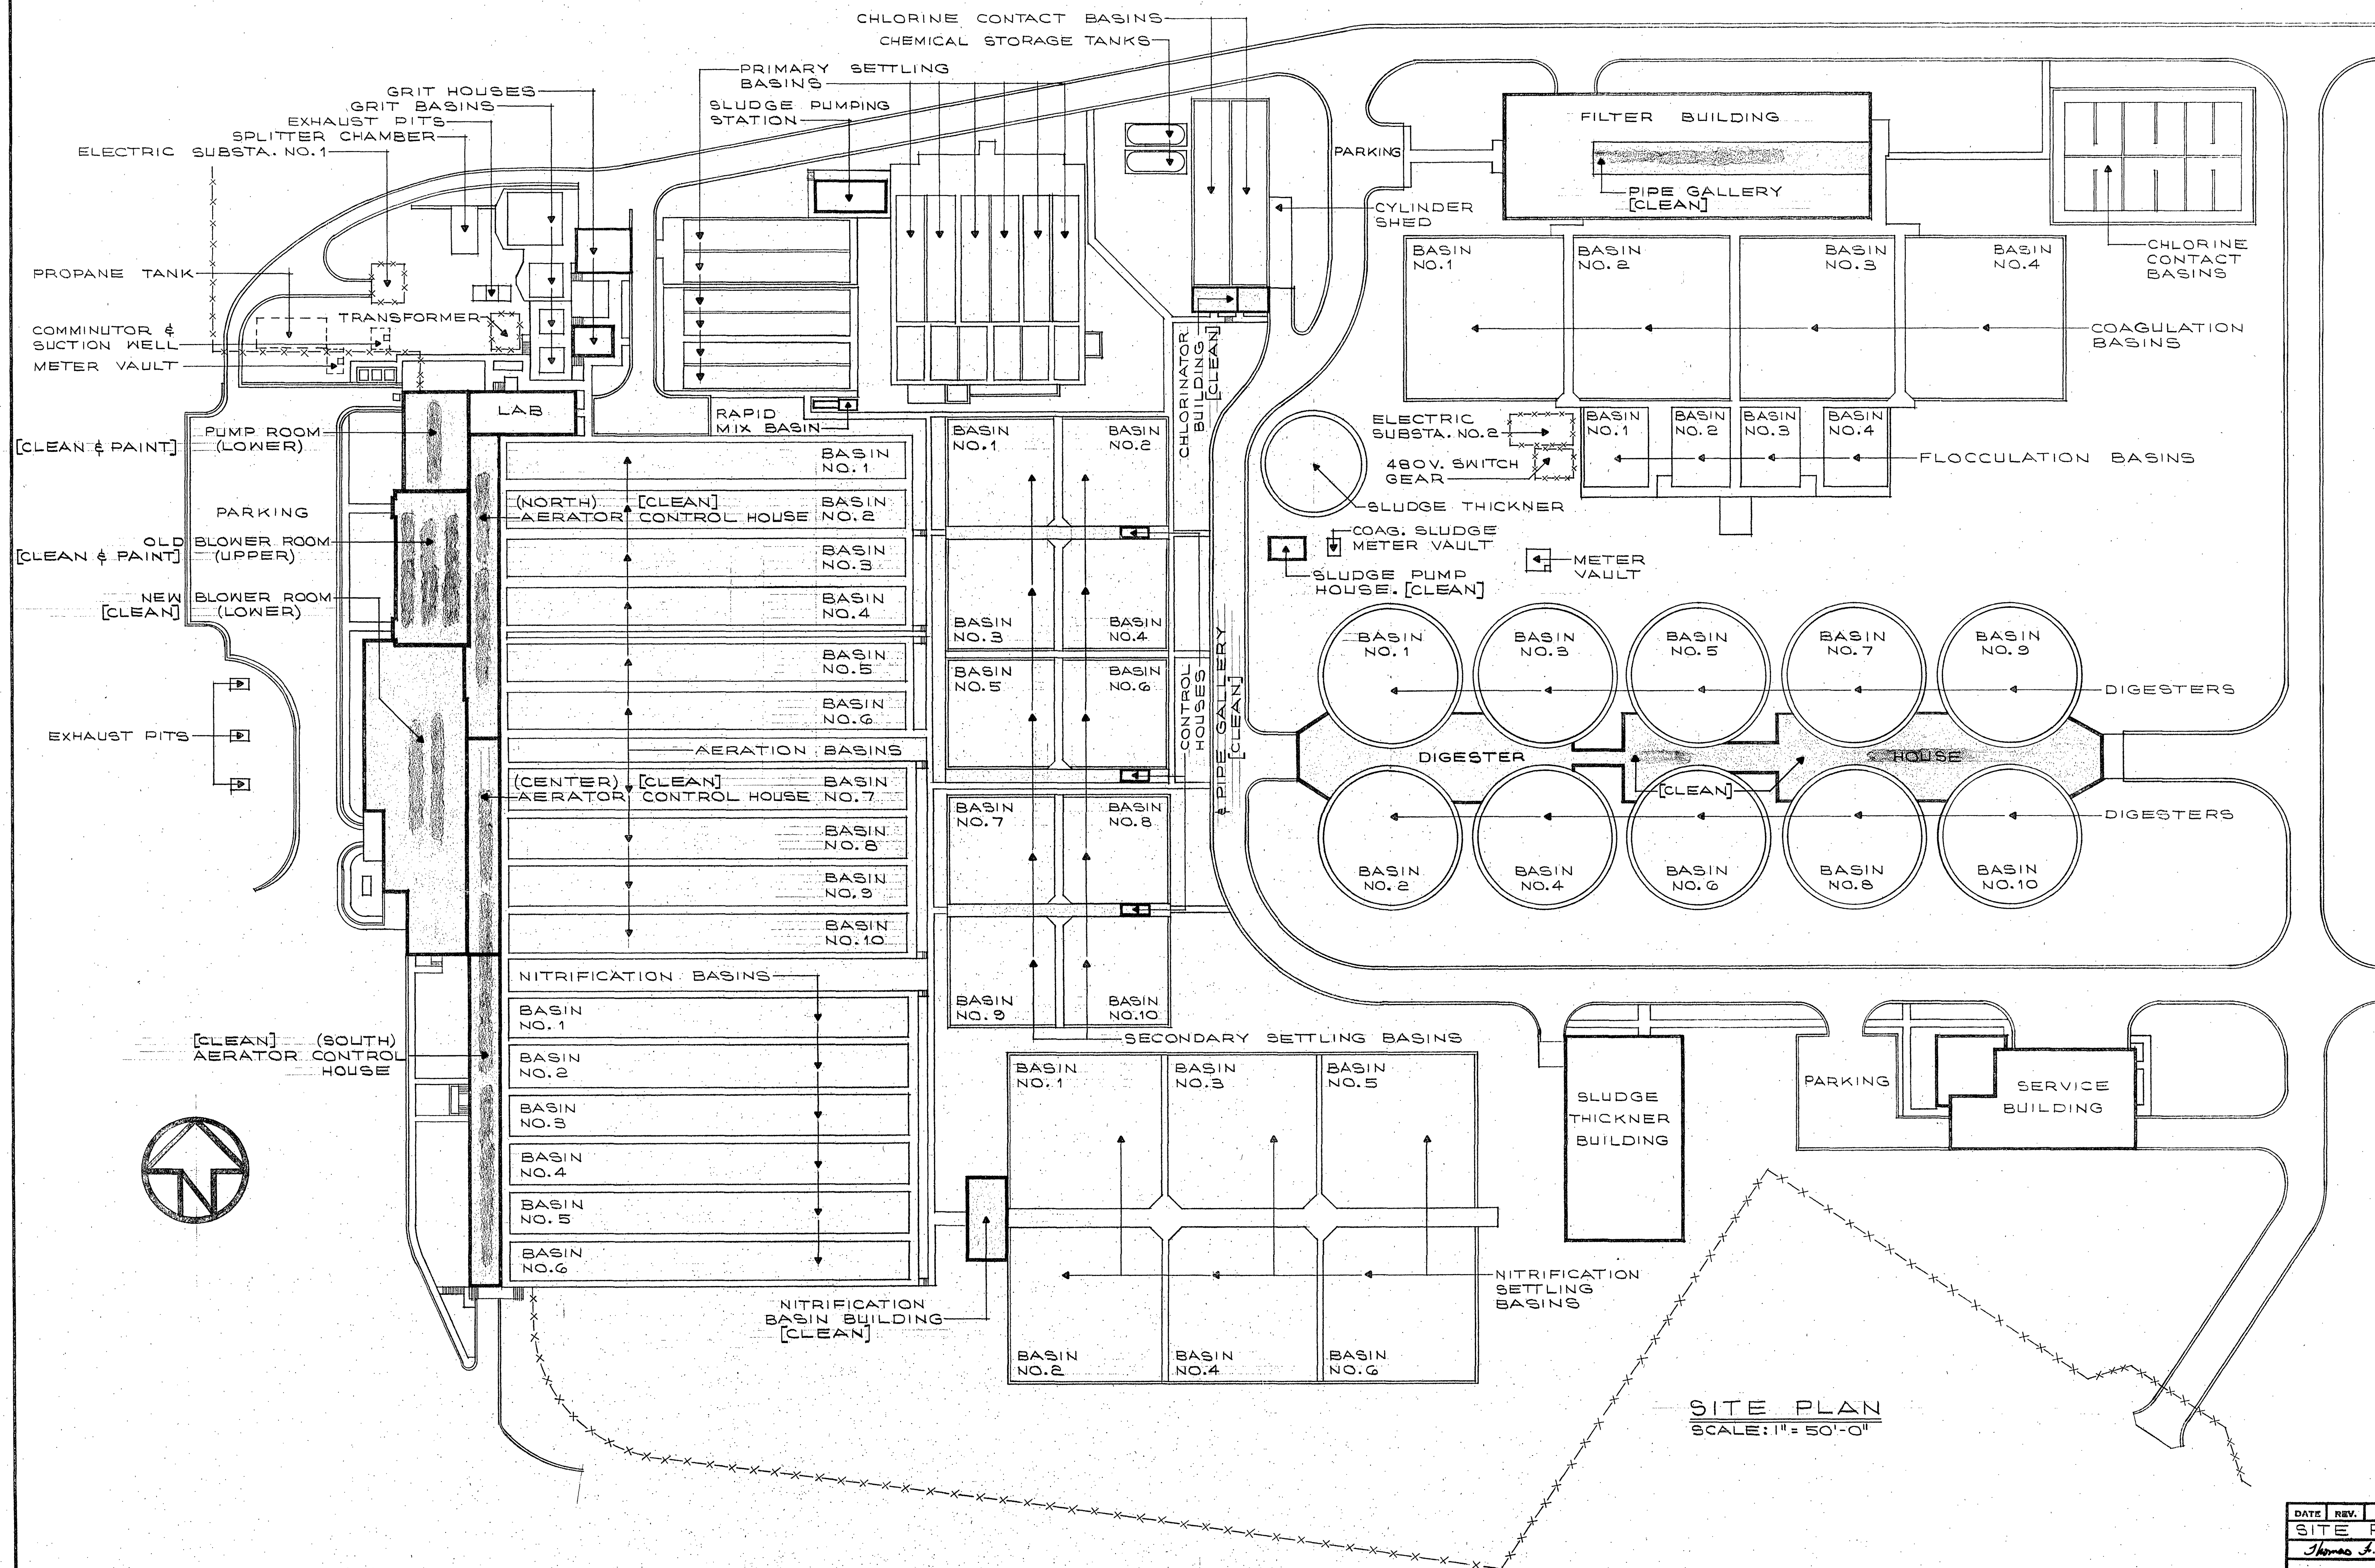

SITE PLAN
SCALE: 1" = 50'-0"

DATE	REV.	DESCRIPTION	BY
		SITE PLAN	
		<i>Thomas J. Brady</i>	<i>City Engineer</i>
		SEWAGE TREATMENT PLANT	LEB
		ROANOKE, VIRGINIA	TFB
		CITY OF ROANOKE	1301-A
		OFFICE OF CITY ENGINEER	1
		ROANOKE, VIRGINIA	1
		CONTRACTOR MUST VERIFY ALL DIMENSIONS AT PROJECT BEFORE PROCEEDING WITH WORK	

MANAGER WATER POLLUTION CONTROL PLANT. DATE