



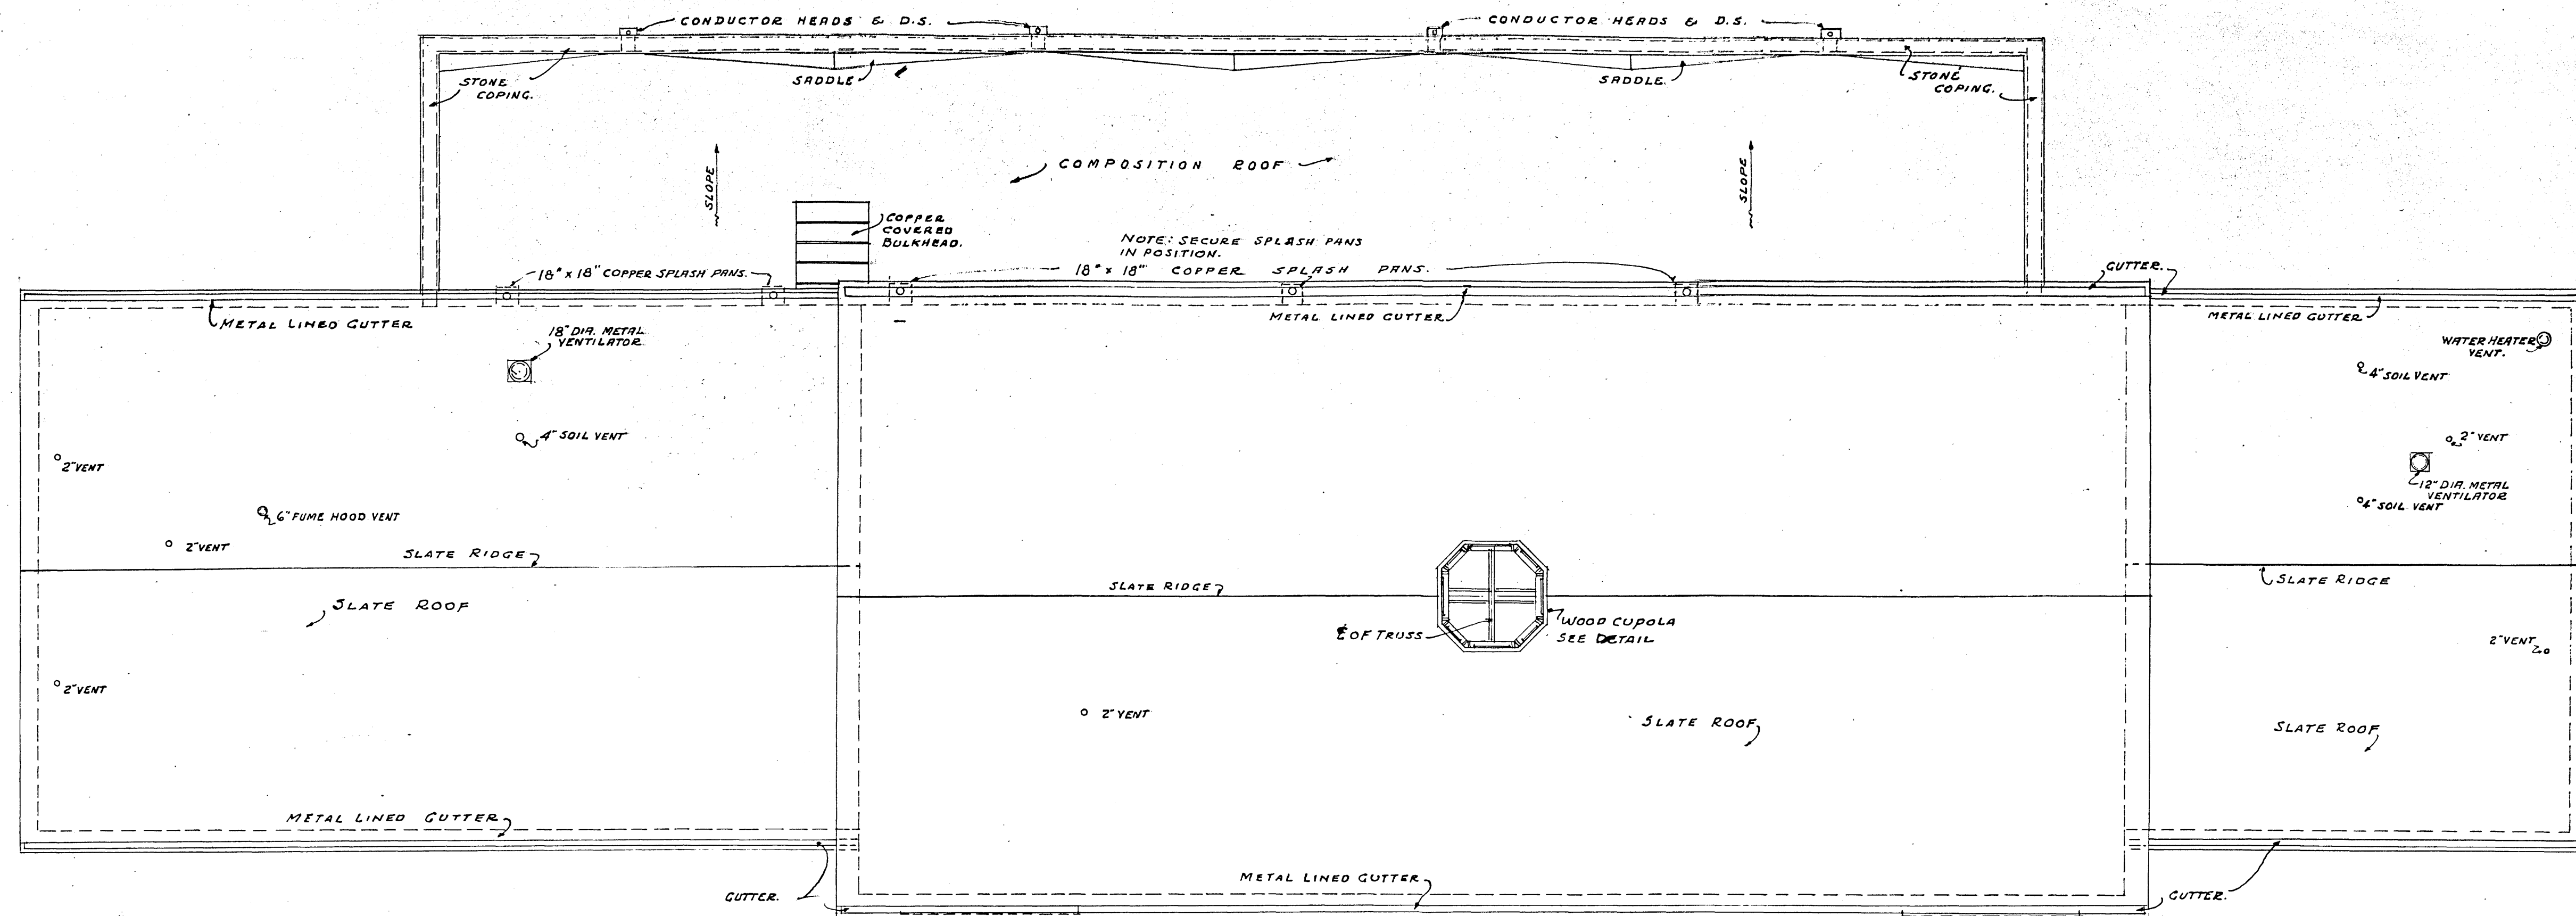


ROOF PLAN

SCALE 1/8" = 1'-0"

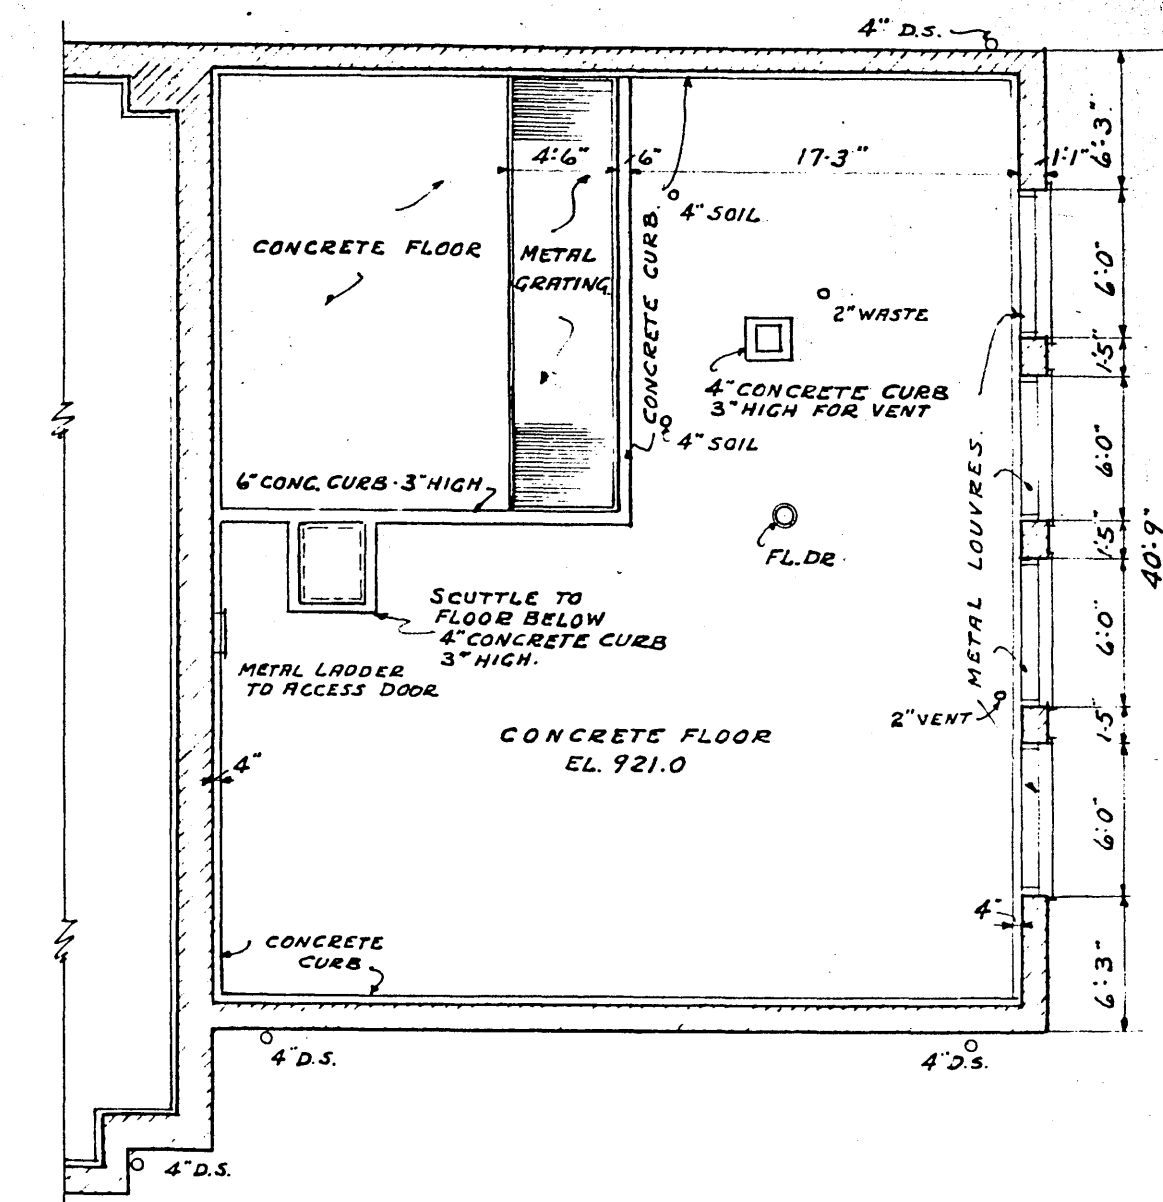

PLAN OF AIR INTAKE SPACE

SCALE 1/8" = 1'-0"

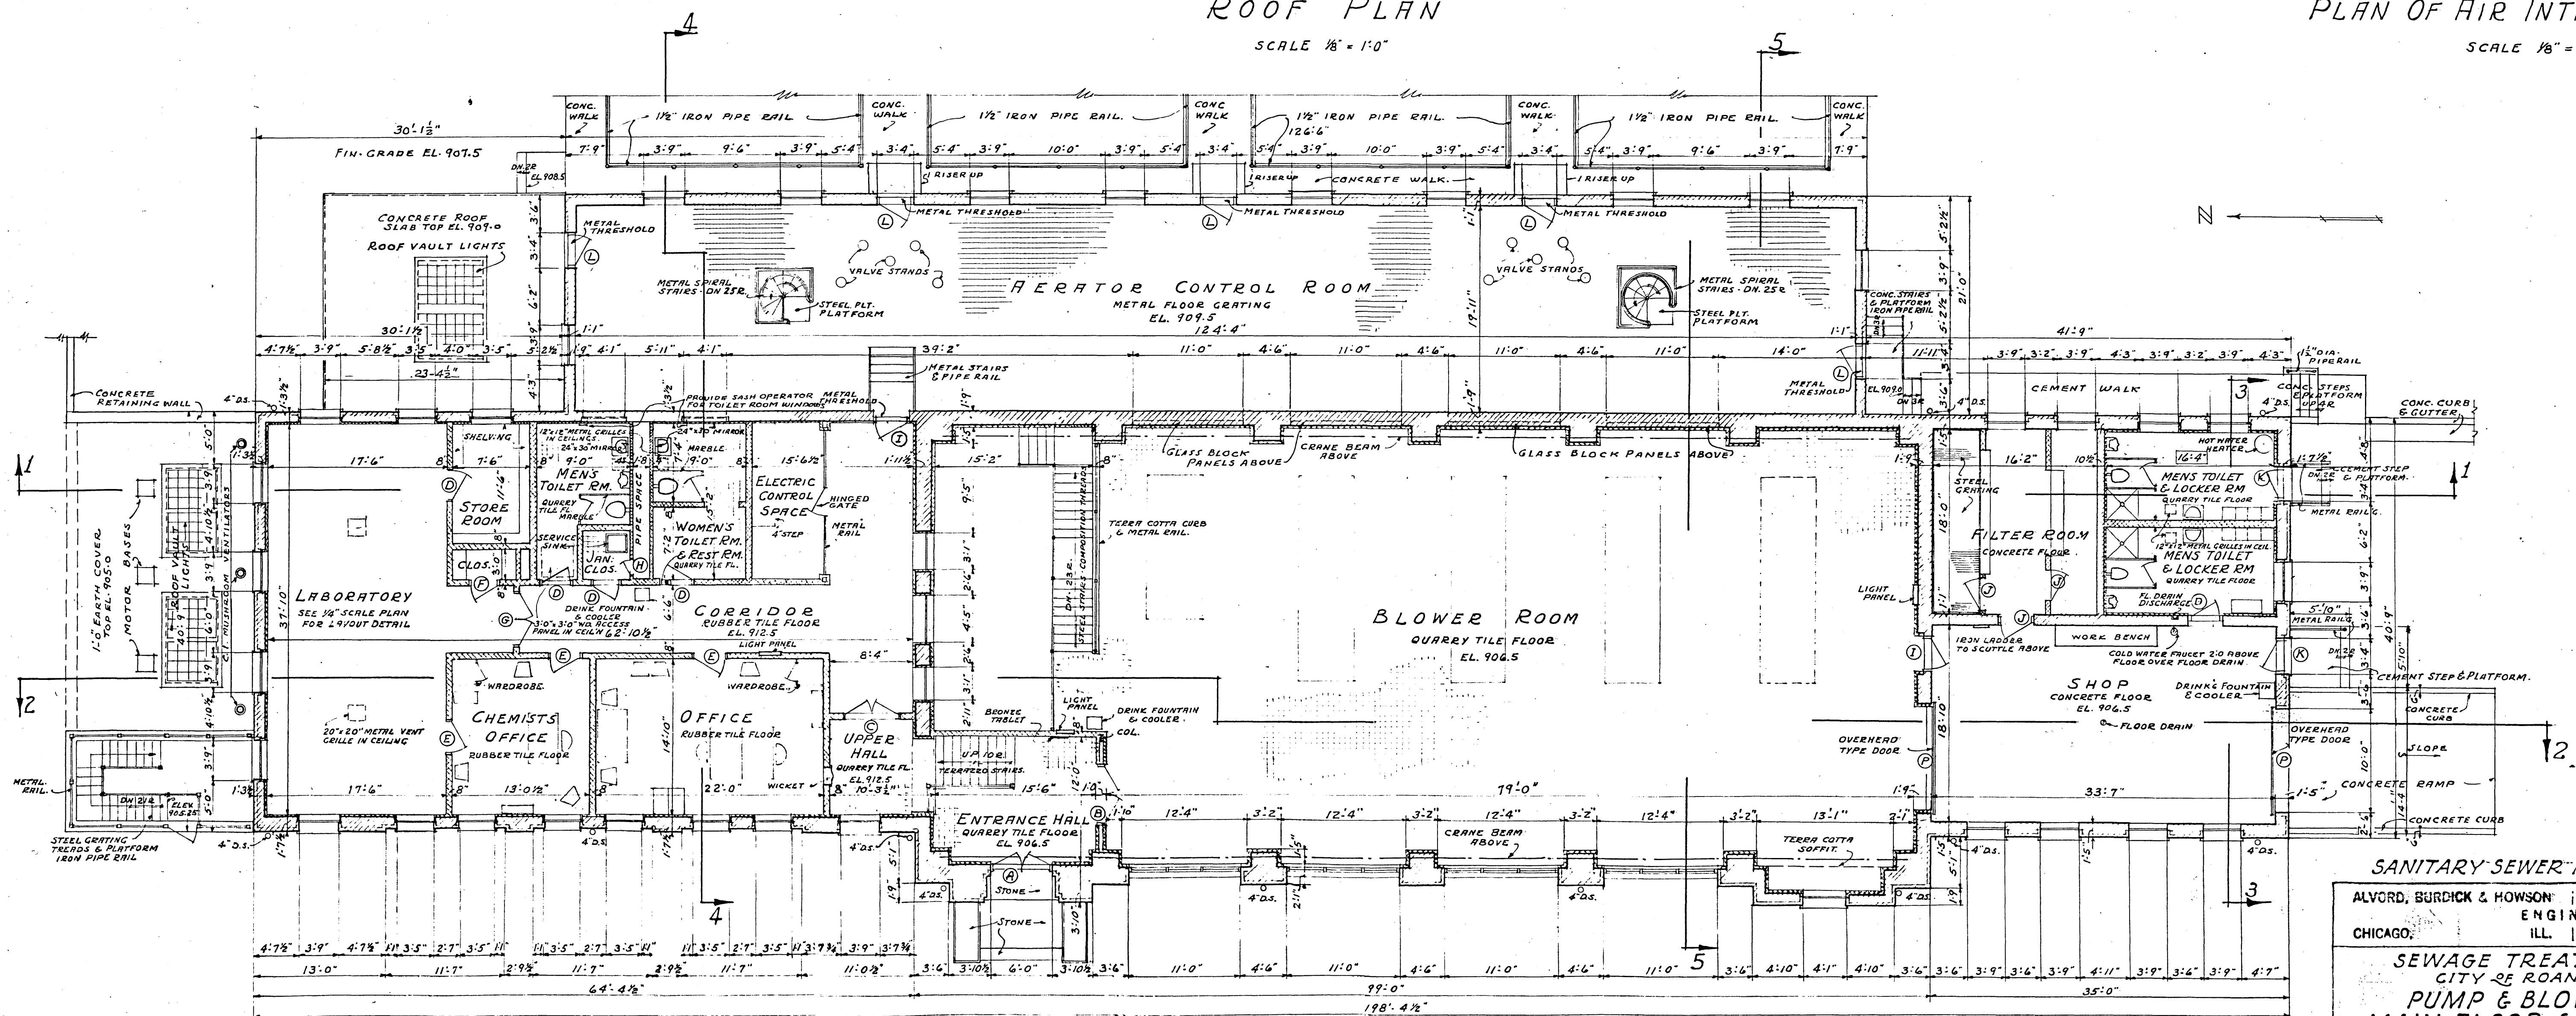

MAIN FLOOR PLAN

SCALE 1/8" = 1'-0"

SANITARY SEWER PROJECT No. 3 - 1950

ALVORD, BURCHICK & HOWSON | MATERN & MATERN
ENGINEERS
CHICAGO, ILL. | ROANOKE, VA.

**SEWAGE TREATMENT PLANT
CITY OF ROANOKE, VIRGINIA
PUMP & BLOWER BLDG.
MAIN FLOOR & ROOF PLANS**

DESIGNED	SCALE AS SHOWN	CON. NO.
DRAWN B.G.C.		
CHECKED P.G.O.	DATE AUGUST, 1950	SHEET NO. 6