




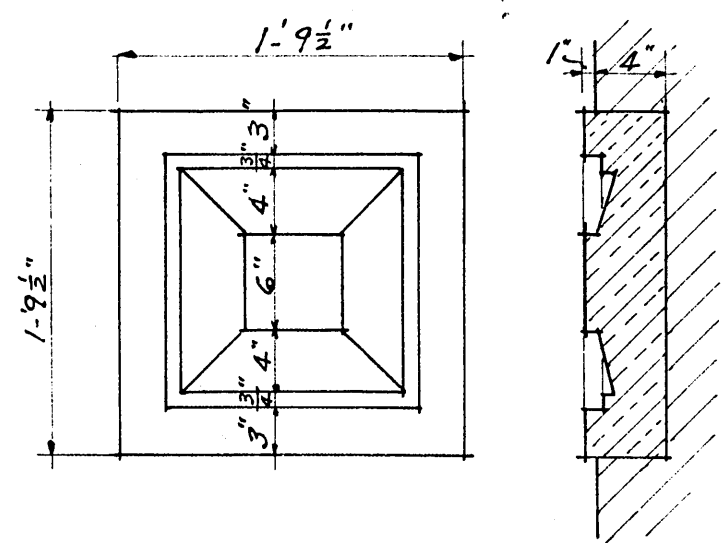


DETAIL OF STONE PANELS
IN FRONT ELEVATION
MAIN BUILDING
SCALE 1"=1'-0"

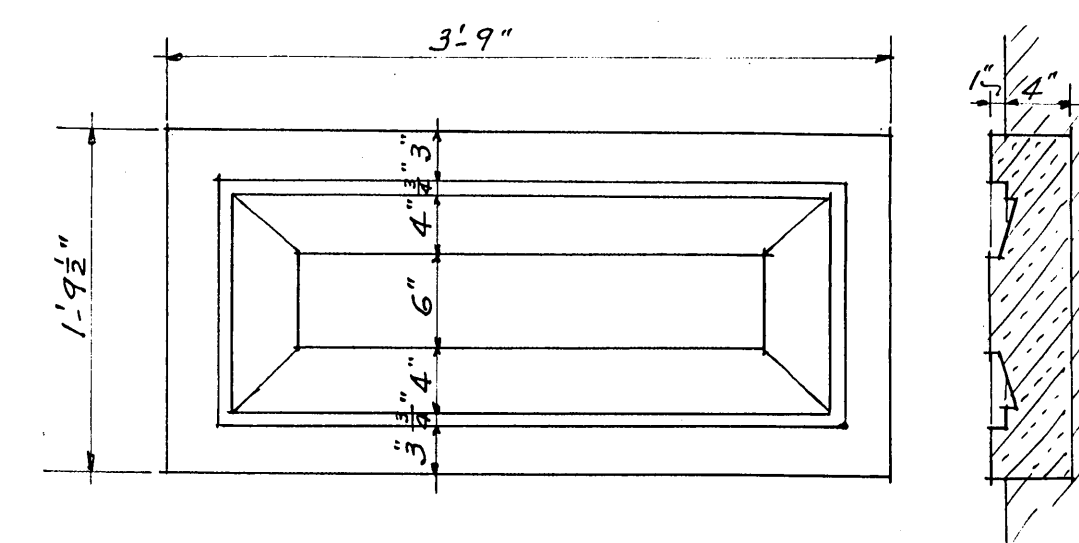

DETAIL OF STONE PANELS
FRONT ELEVATION SHOP WING
SCALE 1"=1'-0"

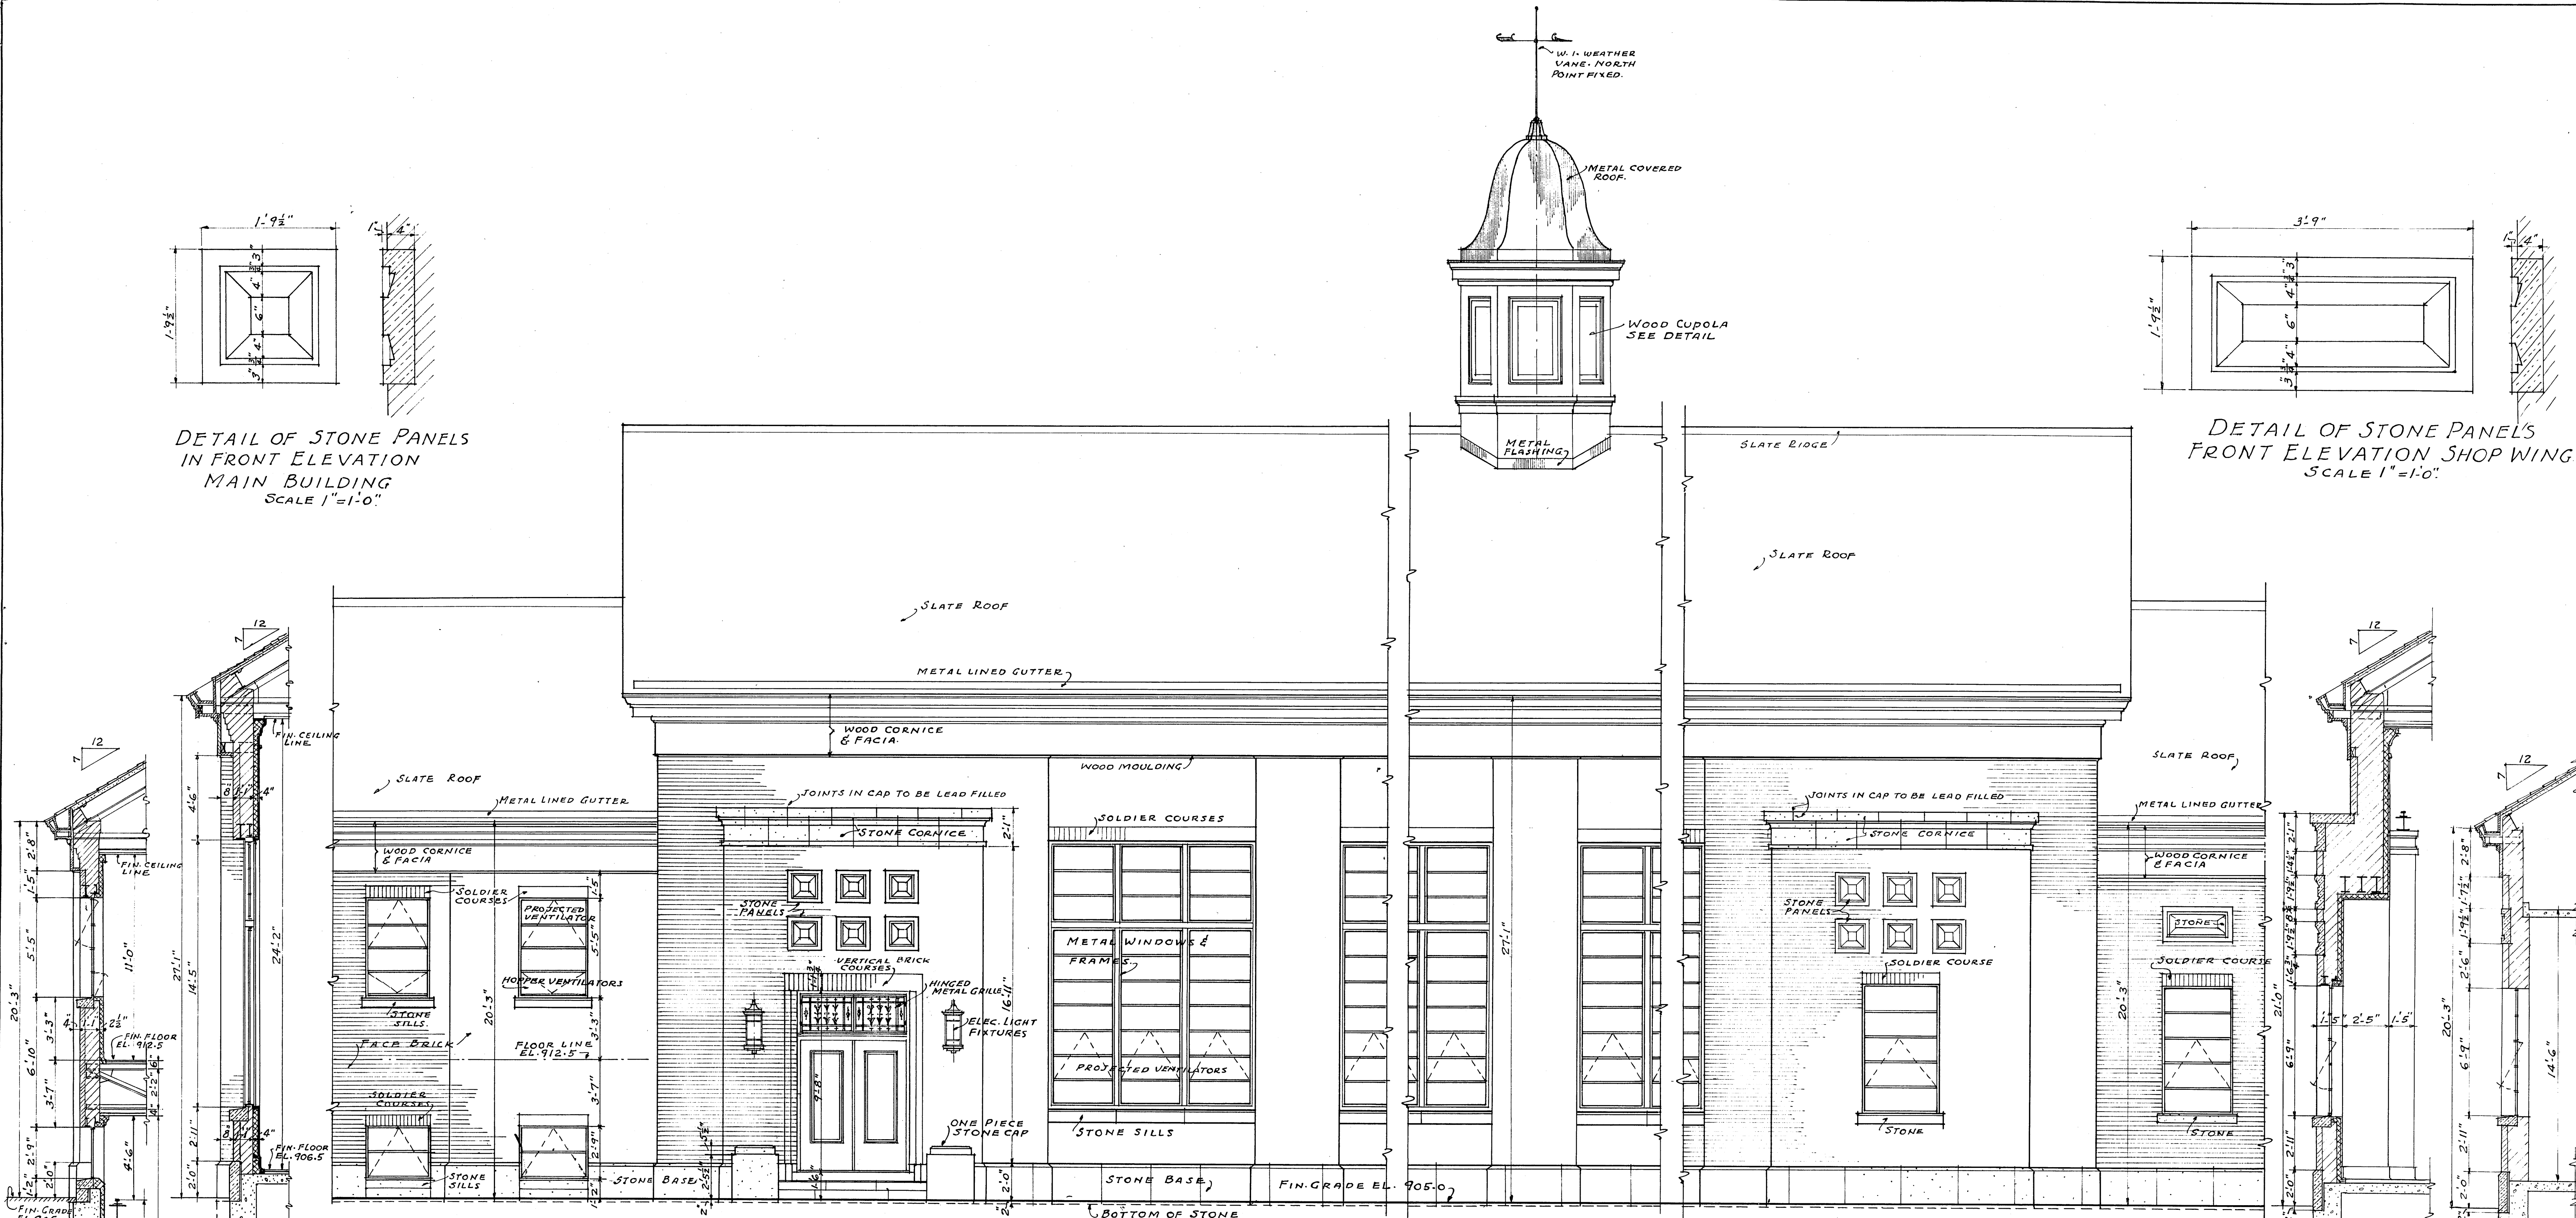


DETAIL OF FRONT ELEVATION BLOWER BUILDING.
SCALE 1/4"=1'-0"

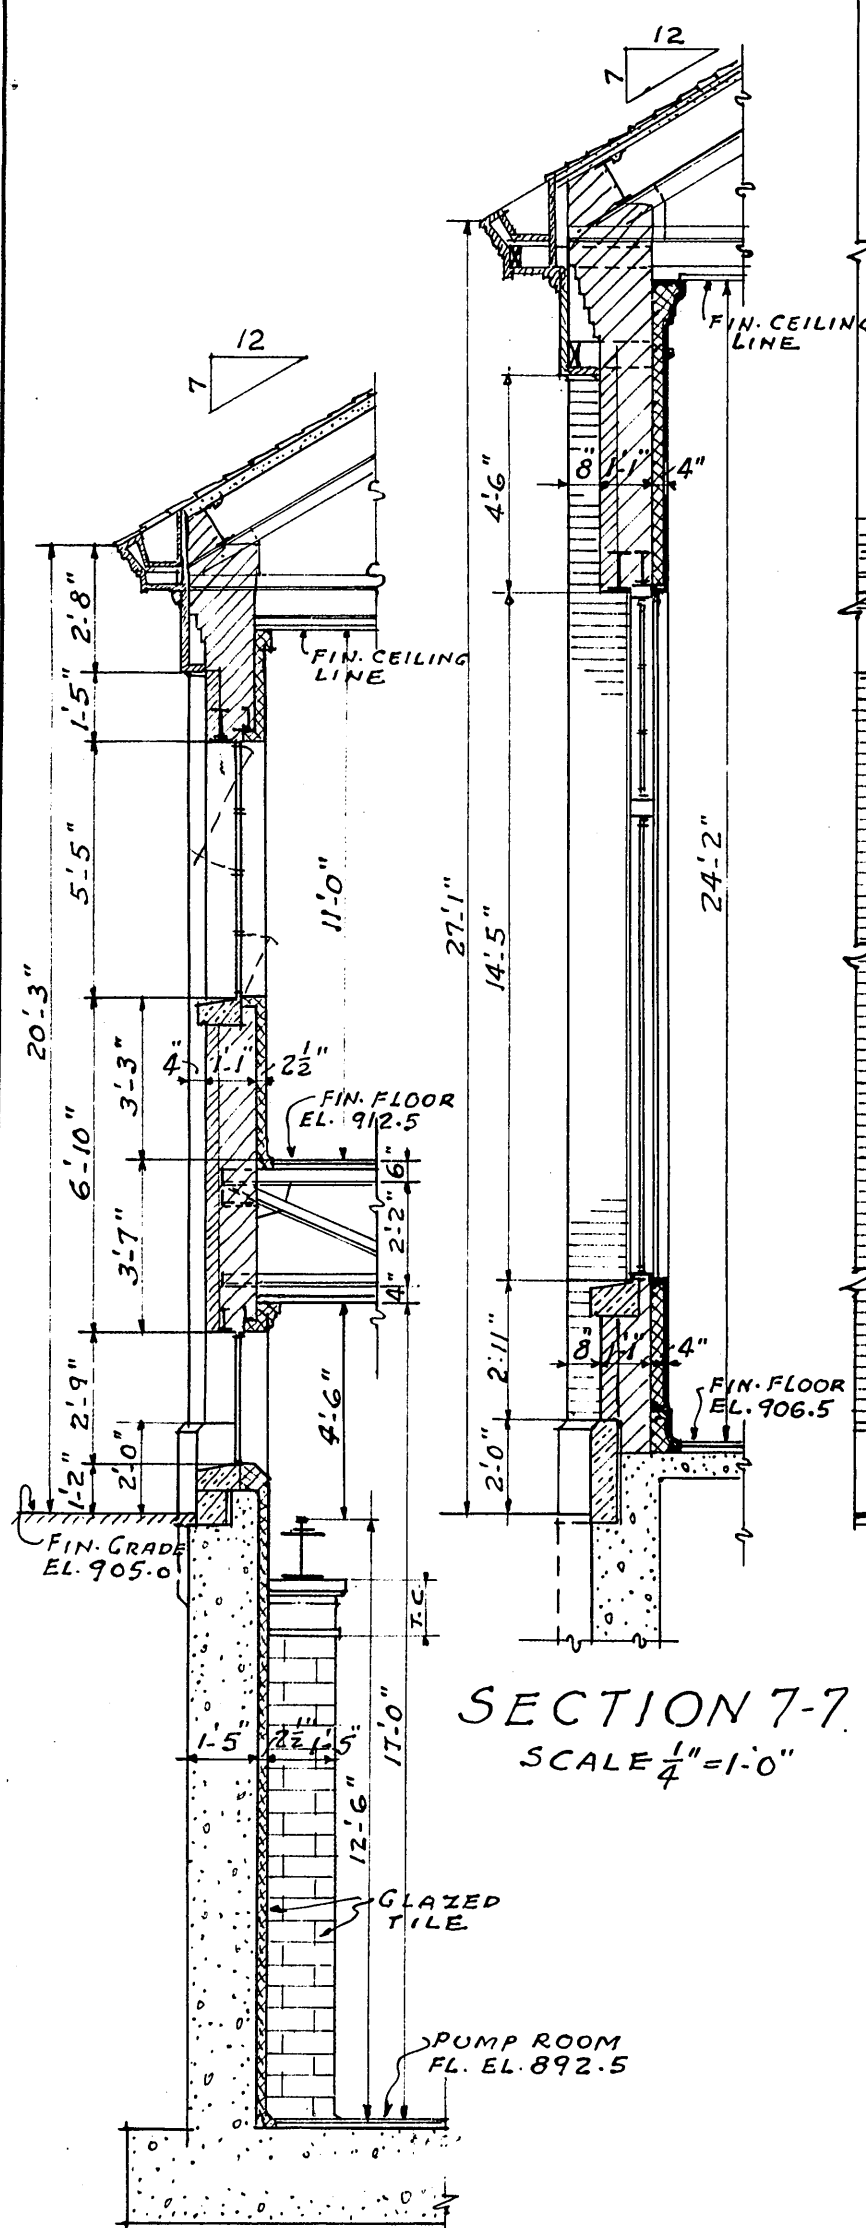

SECTION 7-7
SCALE 1/4"=1'-0"

NOTE: FOR LOCATION OF
SECTIONS SEE SHEET #8.

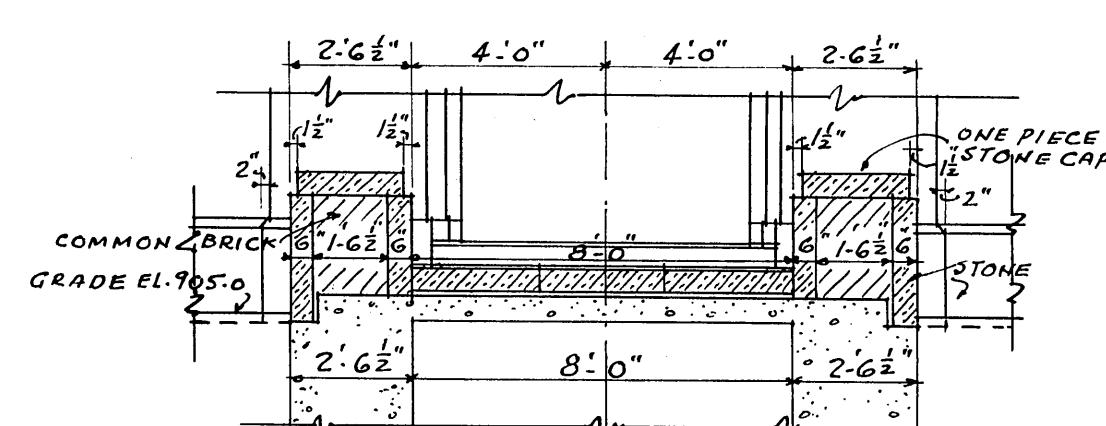

CROSS SECTION THRU
BUTTRESSES AT MAIN ENTR.
SCALE 1/4"=1'-0"

SECTION 8-8 SECTION 9-9
SCALE 1/4"=1'-0" SCALE 1/4"=1'-0"

SANITARY SEWER PROJECT No. 3 - 1950

ALVORD, BURDICK & HOWSON | MATTERN & MATTERN
ENGINEERS
CHICAGO, ILL | ROANOKE, VA.

SEWAGE TREATMENT PLANT
CITY OF ROANOKE, VIRGINIA
PUMP & BLOWER BLDG.
EXTERIOR DETAILS

DESIGNED	P.G.O.	SCALE	AS SHOWN	CON.	NO.
DRAWN	P.G.O.	DATE	AUGUST, 1950	SHEET	9
CHECKED	P.G.O.				