
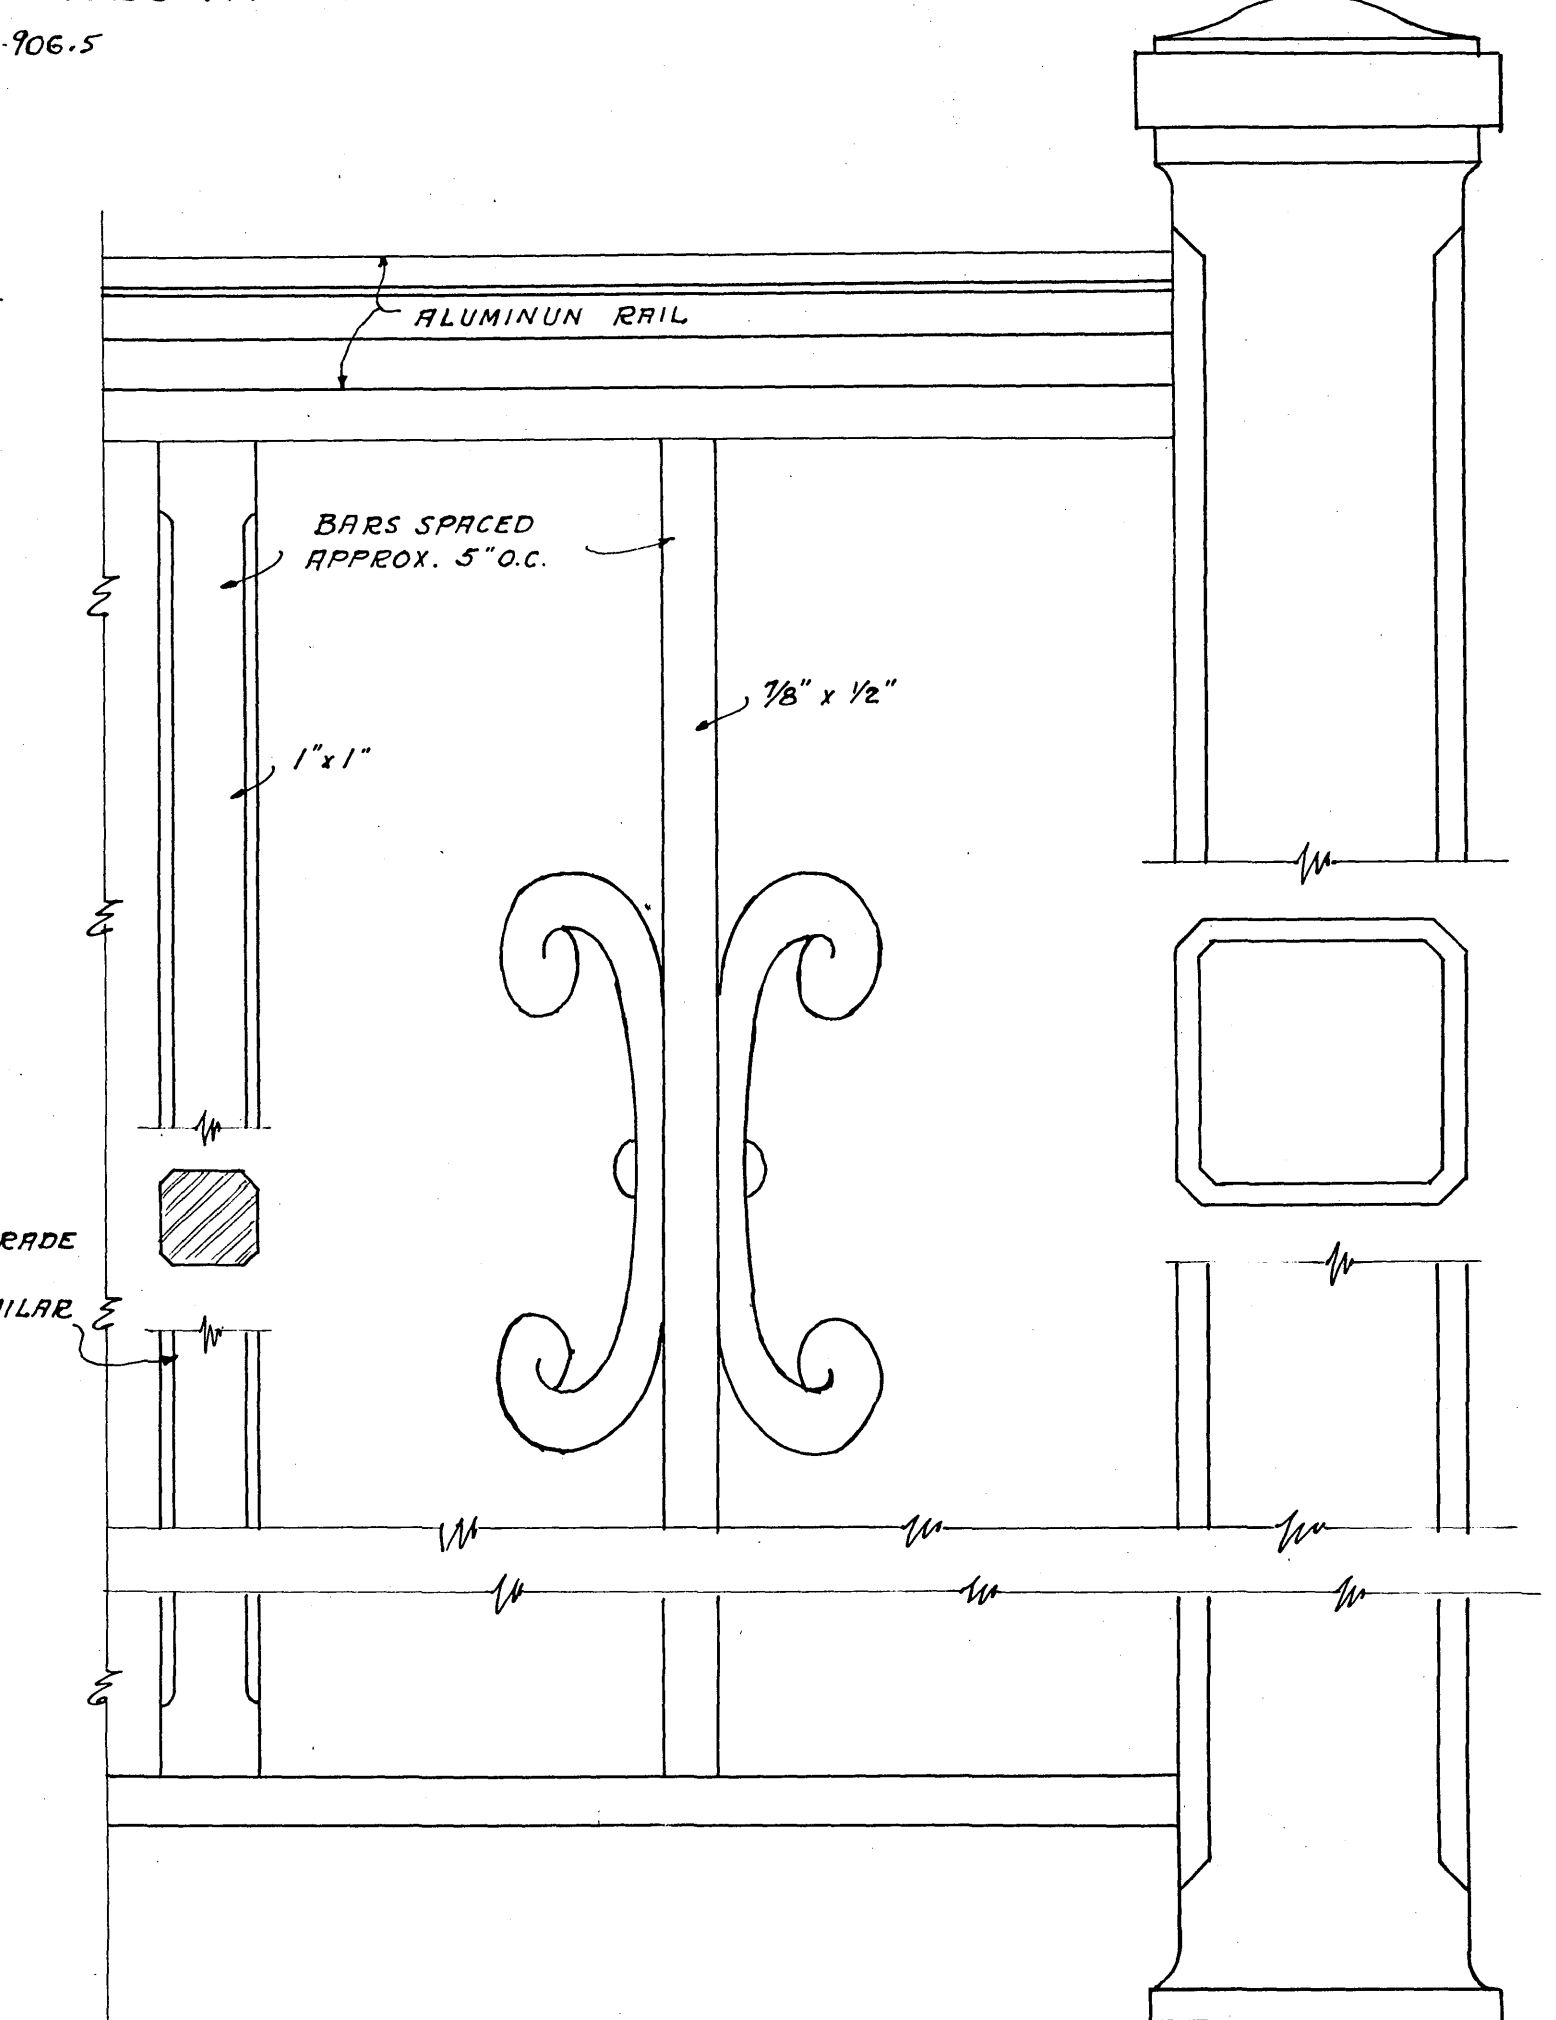
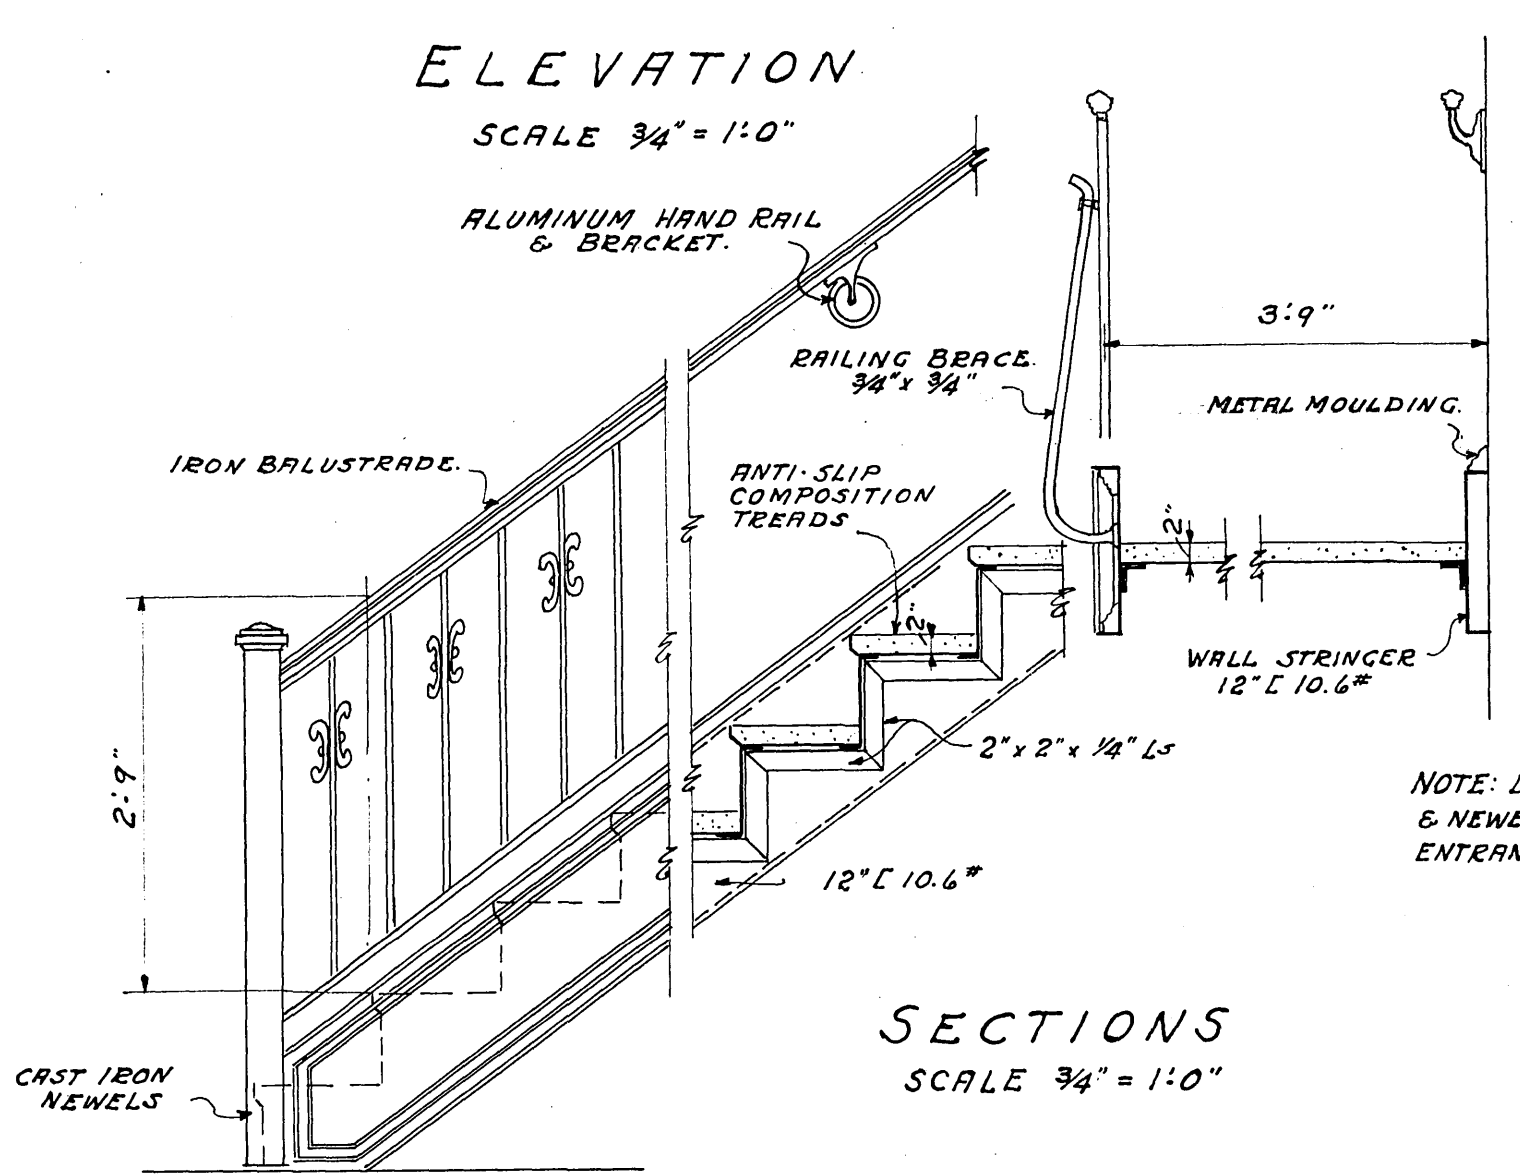
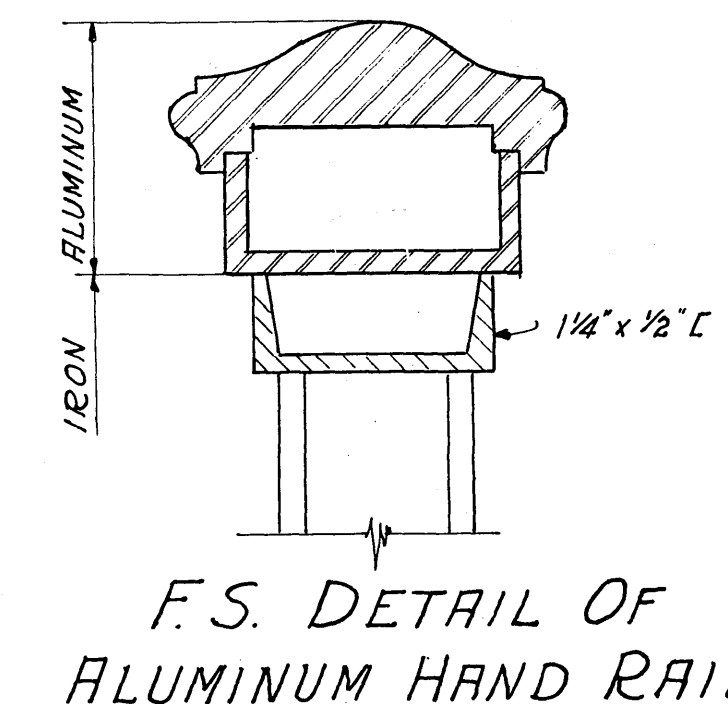
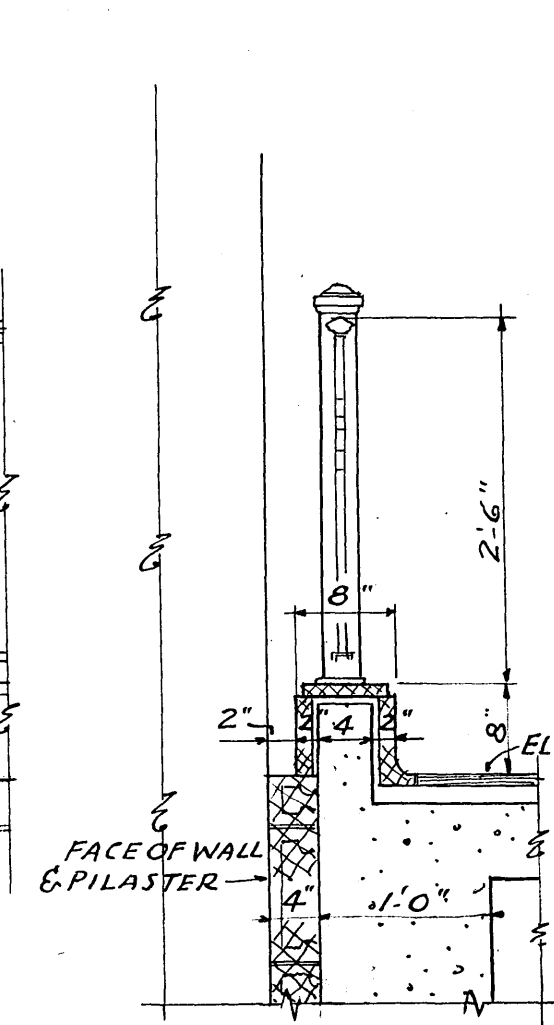


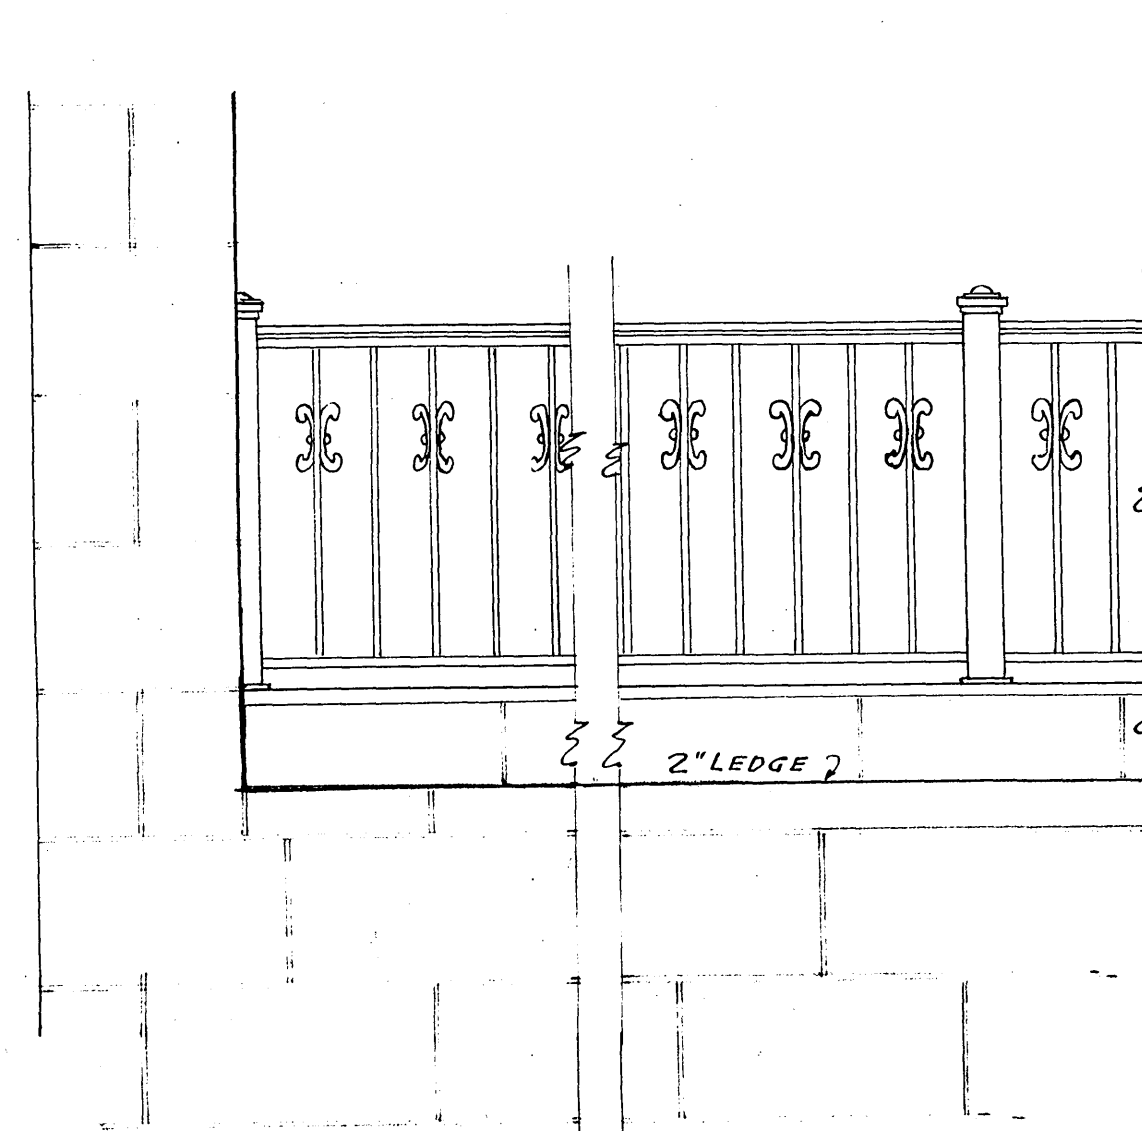


NOTE: THIS DETAIL TYPICAL FOR RAILING IN MAIN ENTRANCE HALL & AT OPERATOR'S OFFICE & ELECTRICAL CONTROL SPACE.

BALUSTRADE & NEWELS

SCALE ONE HALF FULL SIZE



NOTE: WHERE GATES OCCUR IN CONNECTION WITH ORNAMENTAL RAILINGS, THEY SHALL BE PROVIDED WITH CONCEALED CATCHES AND BUMPER SPRING HINGES OR EQUAL.

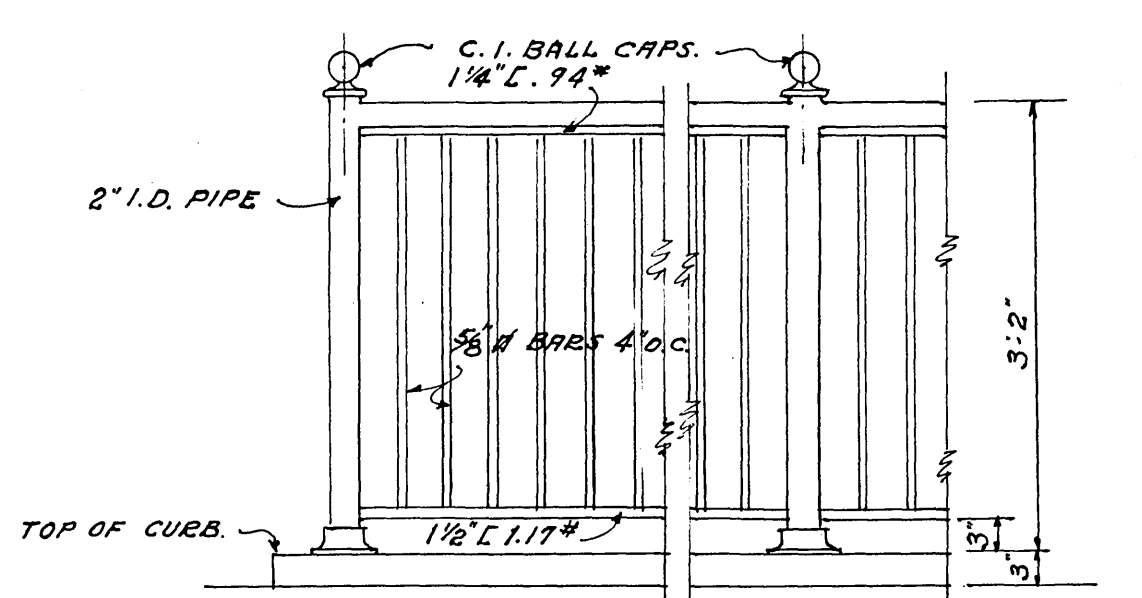

DETAIL OF RAILING AROUND AREA TO SCREEN CHAMBER

SCALE 3/4" = 1'-0"


RAILING AT SHOP ENTR. & TOILET ROOM SOUTH ELEVATION SIMILAR.

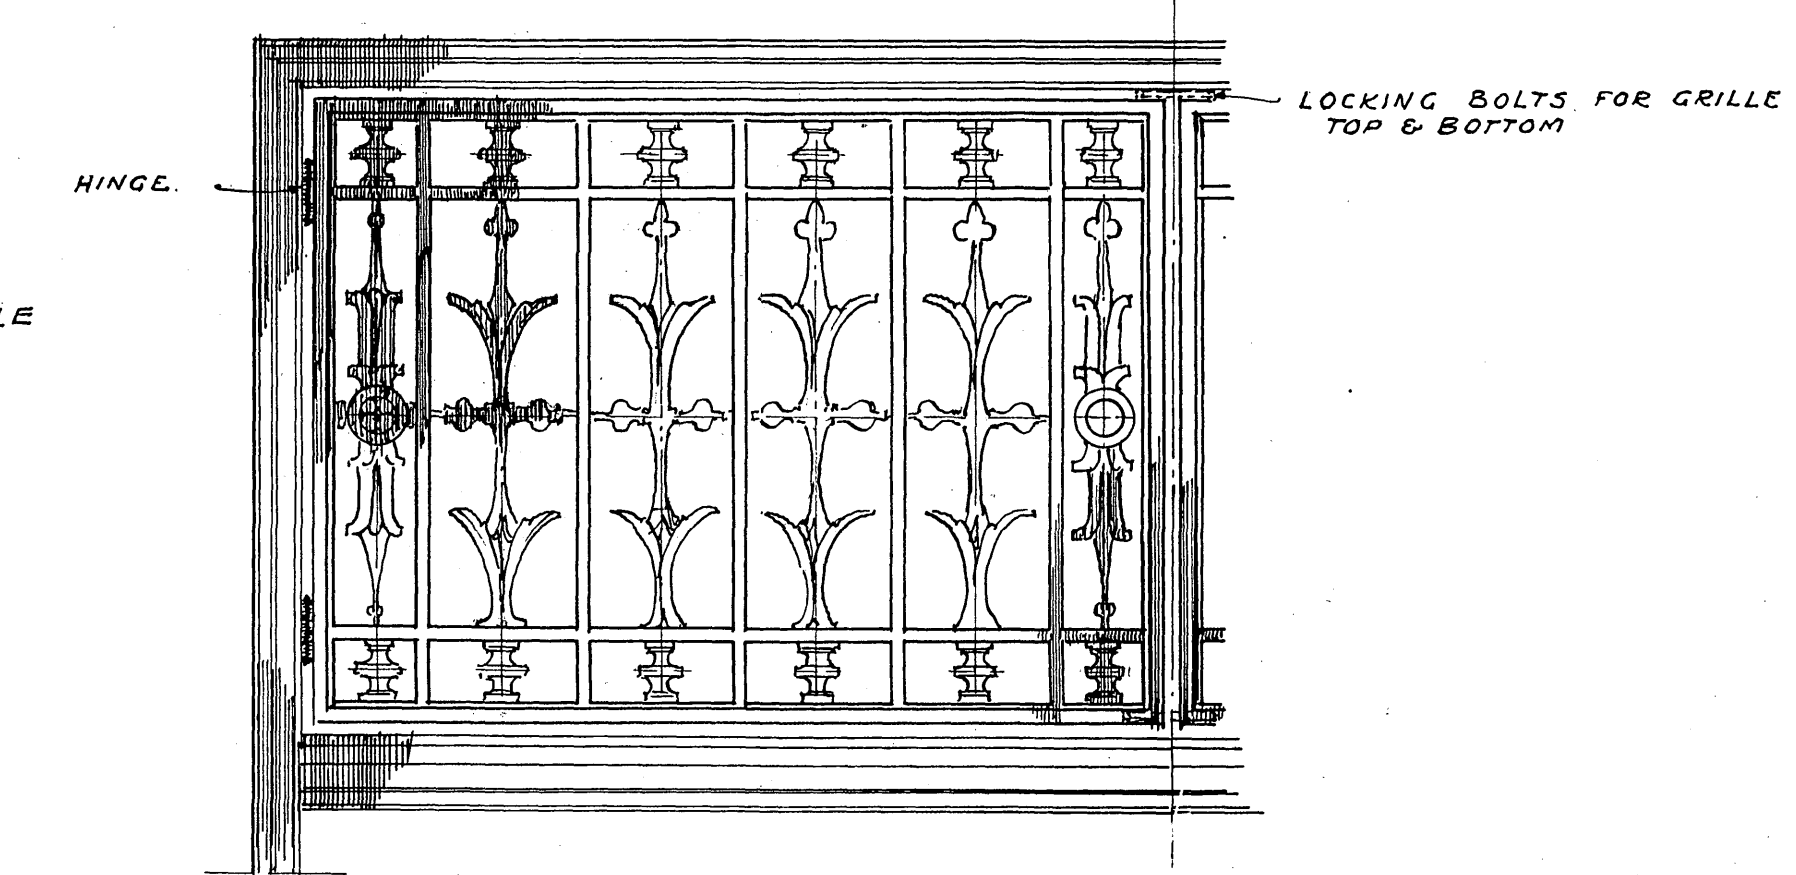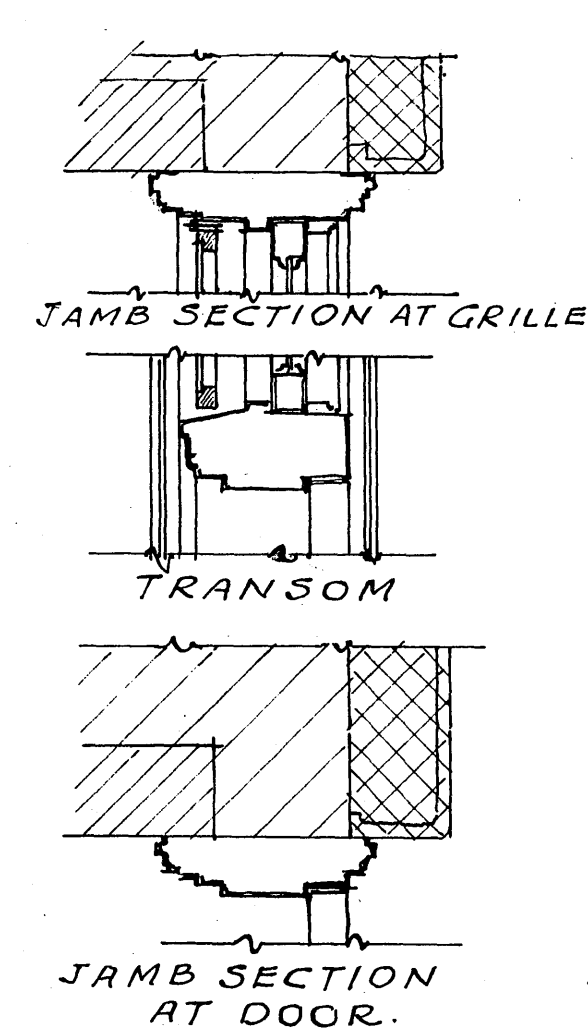

DETAIL MAIN ENTR. DOOR FRAME & GRILLE.


SCALE 1/2" = 1'-0"

DOOR FRAME & GRILLE BET. ENTR. HALL & BLOWER ROOM SIMILAR.

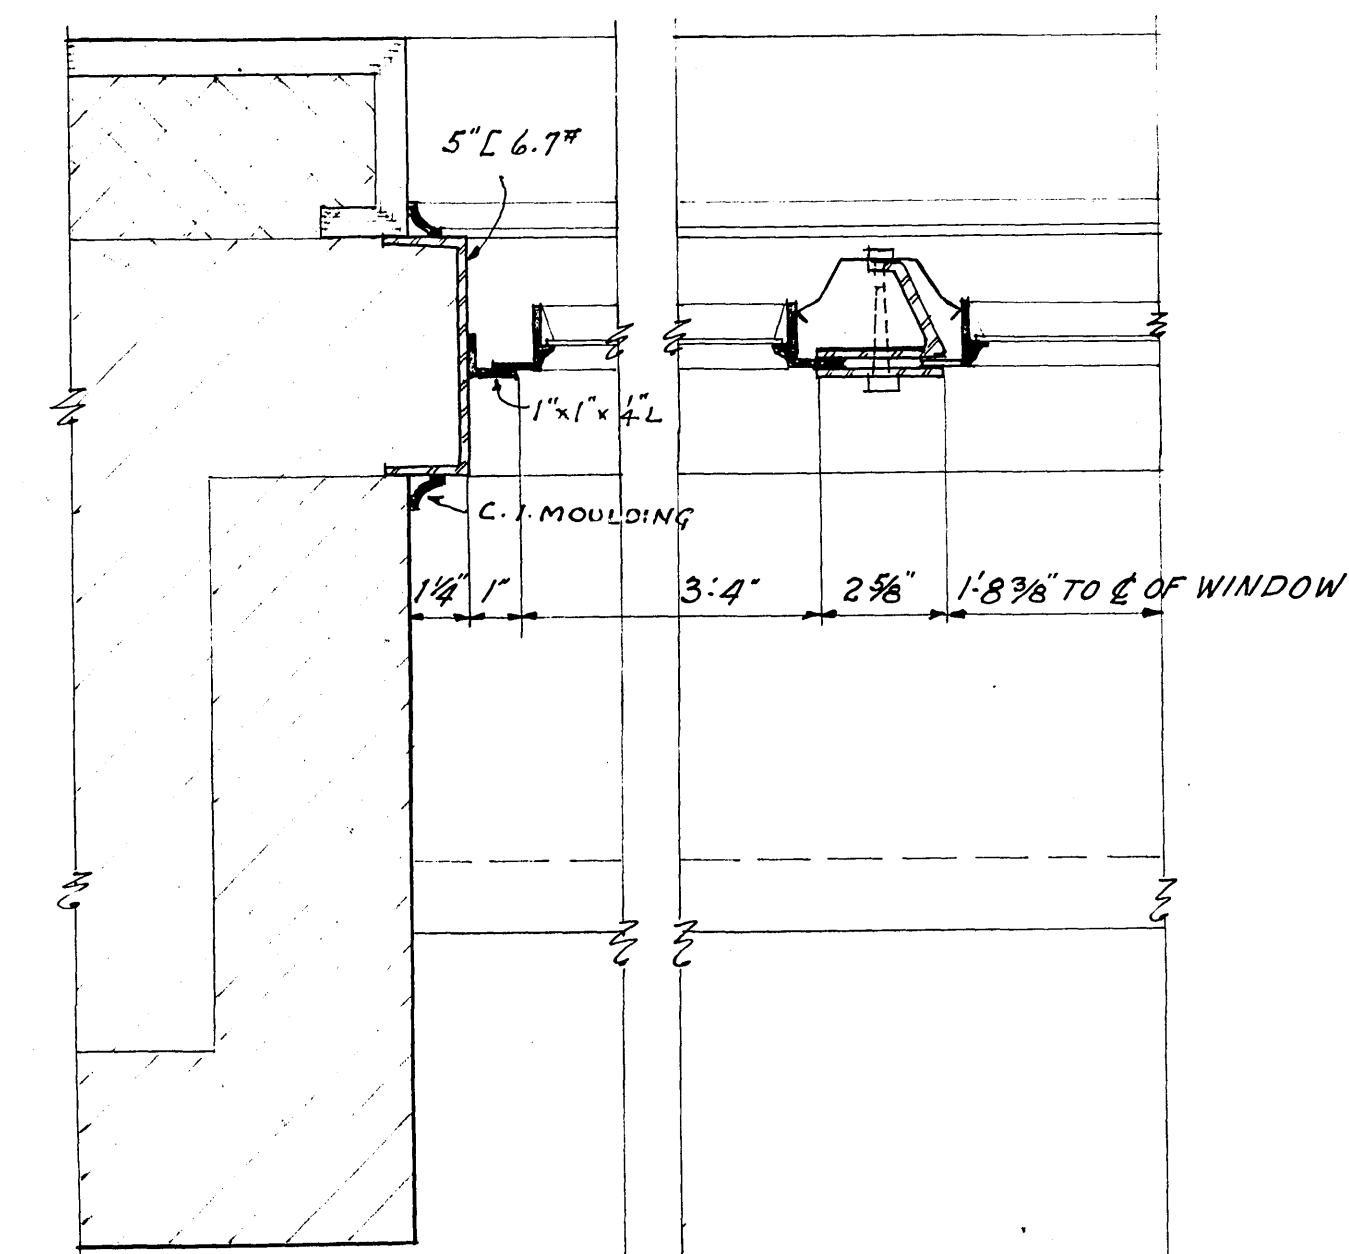


JAMB & MULLION OF BLOWER ROOM WINDOWS

SCALE 3" = 1'-0"

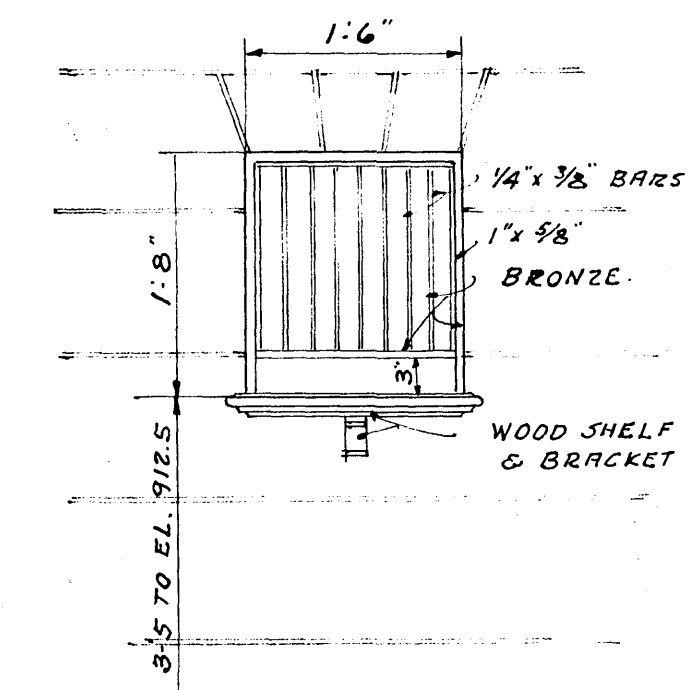

DETAIL OF WICKET

SCALE 3/4" = 1'-0"

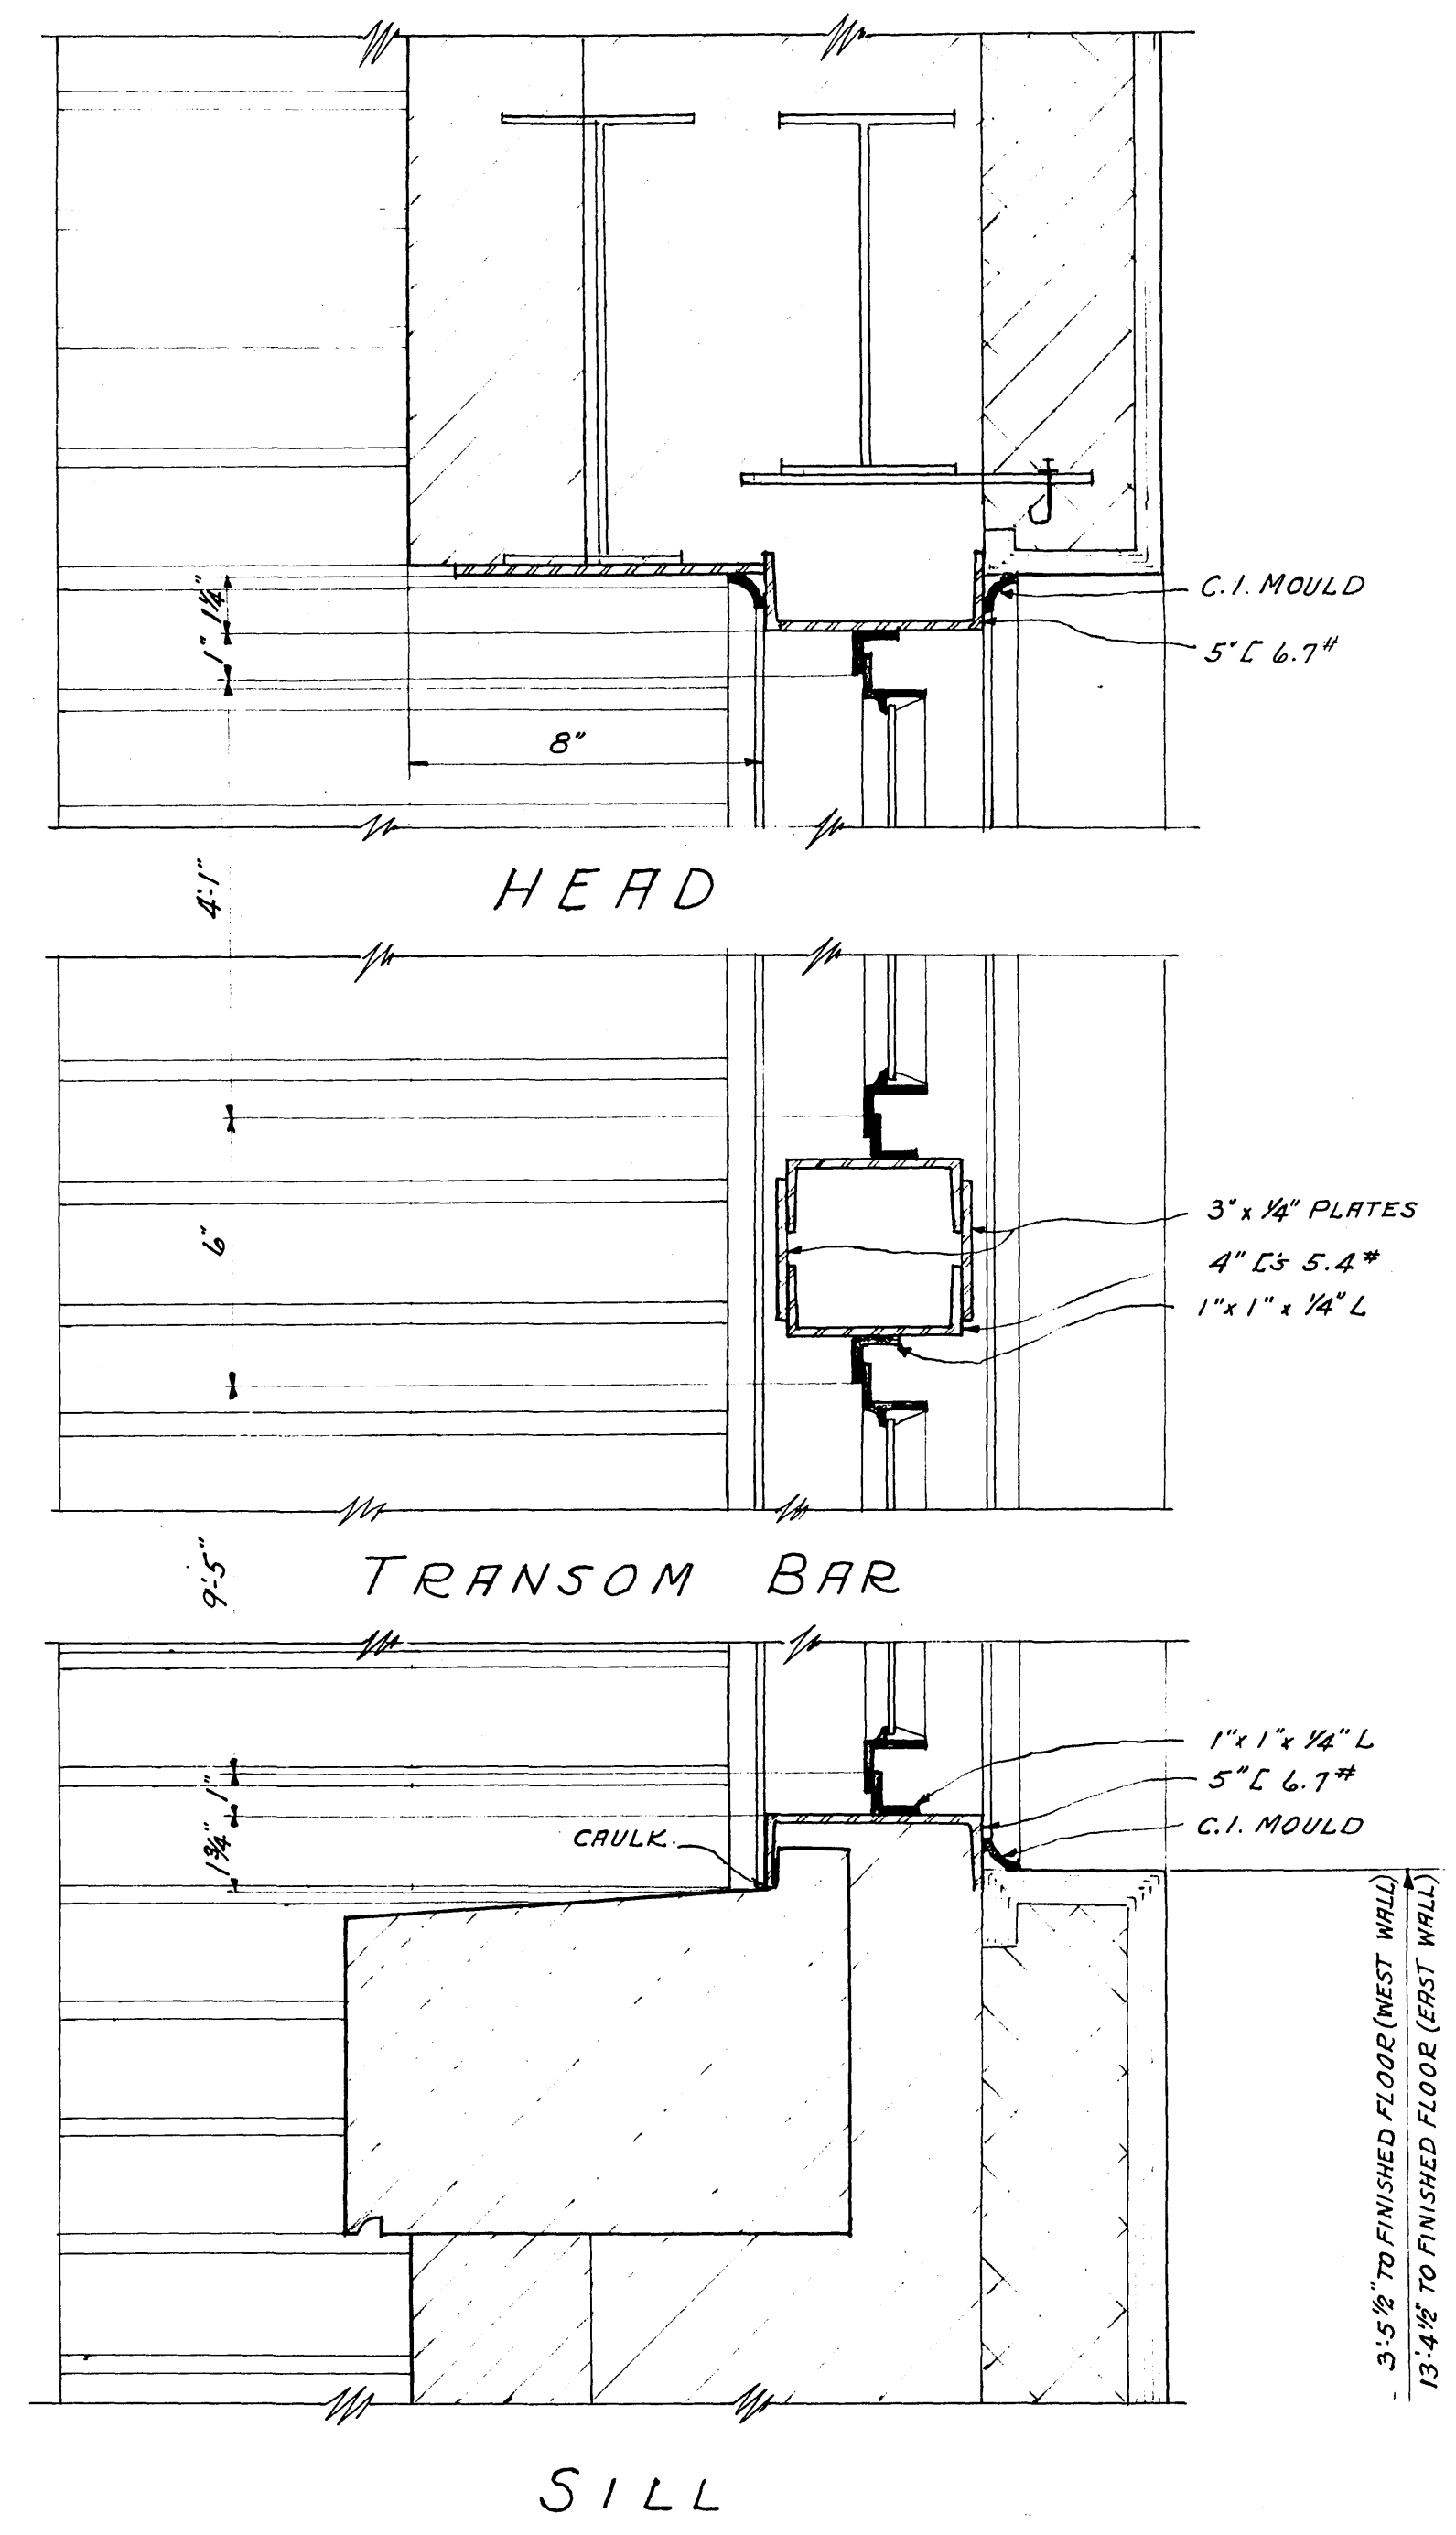

DETAIL OF LARGE WINDOWS IN BLOWER ROOM

SCALE 3" = 1'-0"

SANITARY SEWER PROJECT No. 3 - 1950			
ALYORD, BURDICK & HOWSON		MATTEN & MATTEN	
ENGINEERS		ENGINEERS	
CHICAGO,	ILL.	ROANOKE,	VA.
SEWAGE TREATMENT PLANT			
CITY OF ROANOKE, VIRGINIA			
PUMP & BLOWER BLDG.			
MISCELLANEOUS DETAILS			
DESIGNED	B.C.C.	SCALE	AS SHOWN
DRAWN	B.C.C.	DATE	AUGUST, 1950
CHECKED	P.G.D.	SHEET NO.	12