


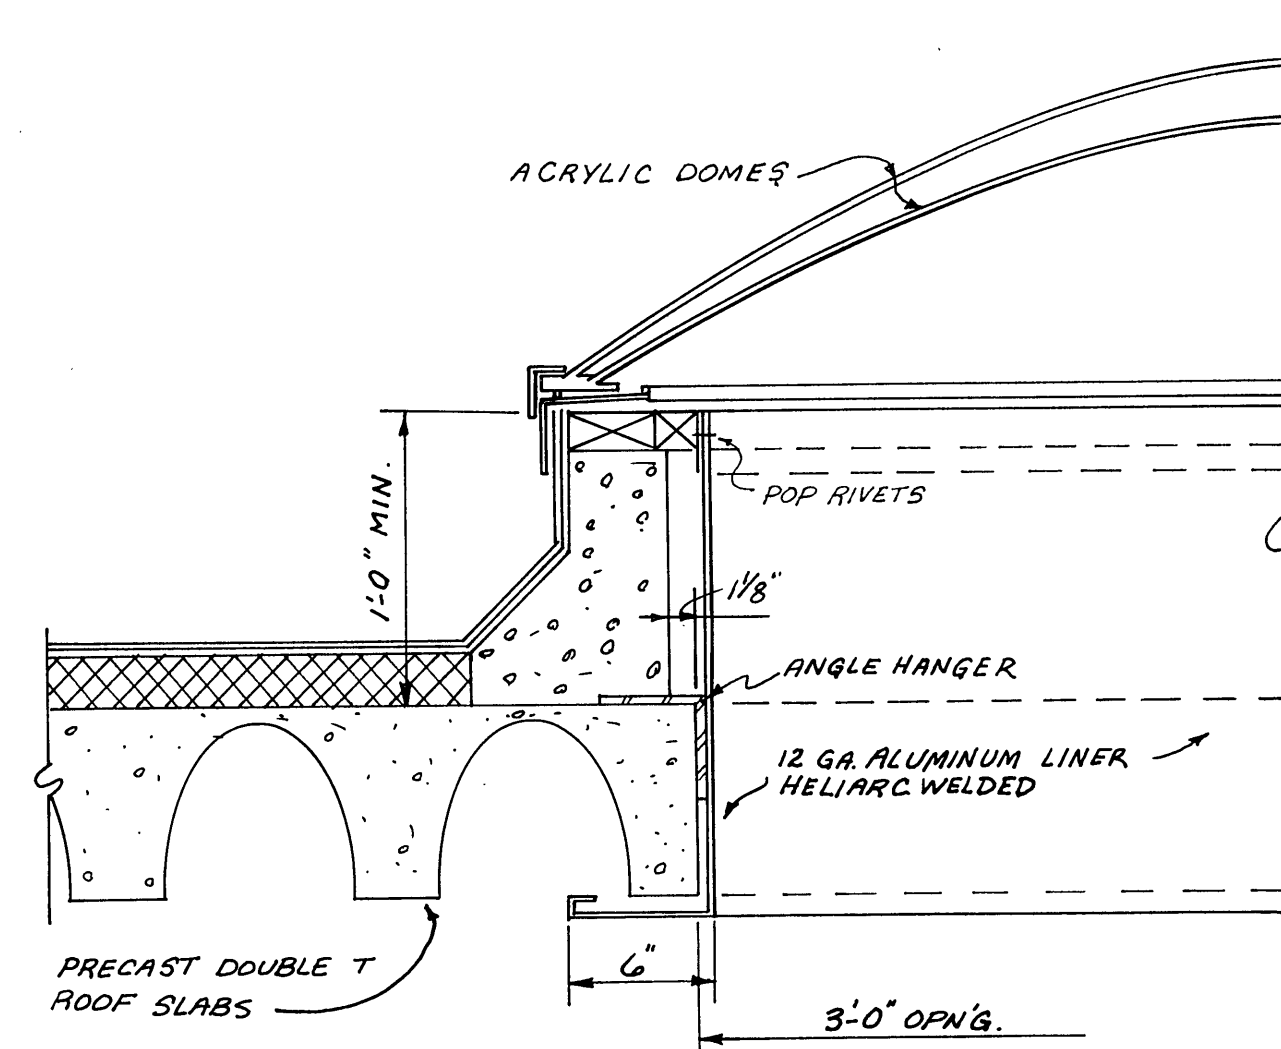
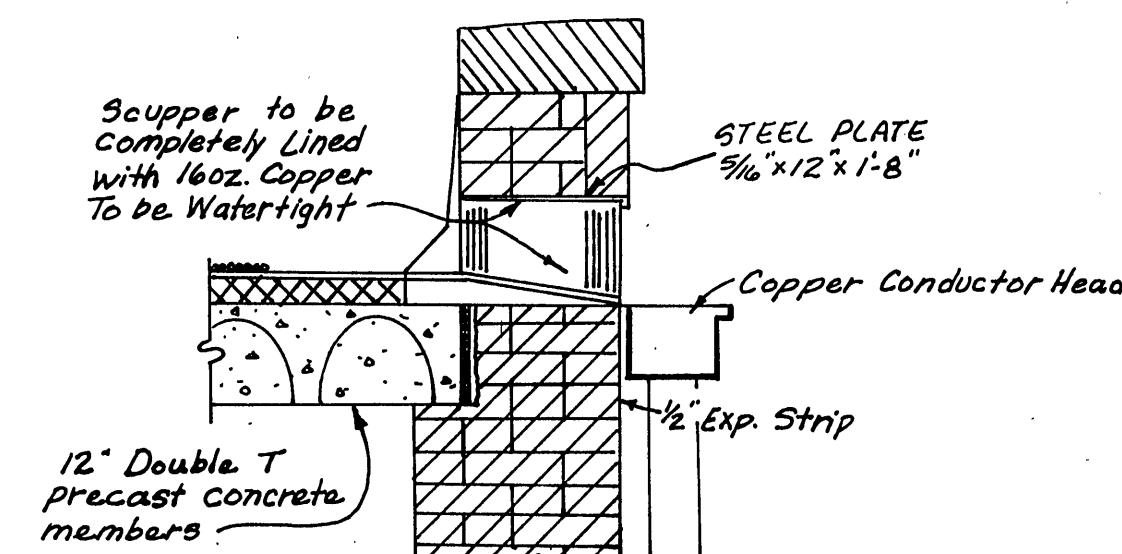


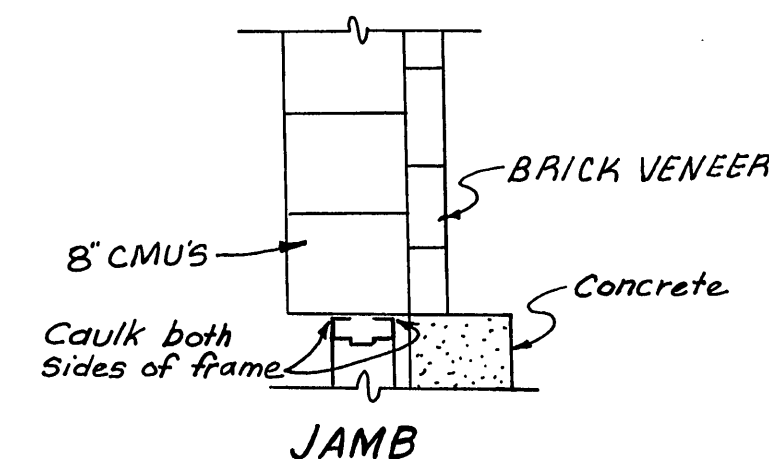

SKYLIGHT 10
7
SCALE: 1 1/2" = 1'-0"

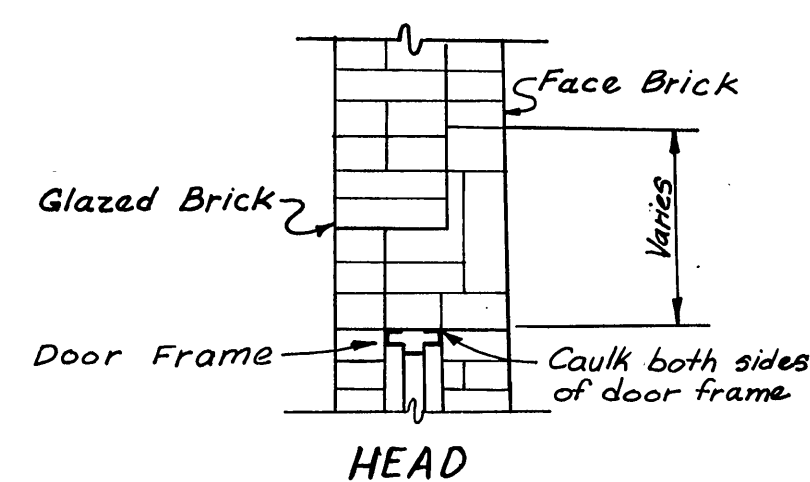


SCUPPER DETAIL 7
7
SCALE: 3/4" = 1'-0"

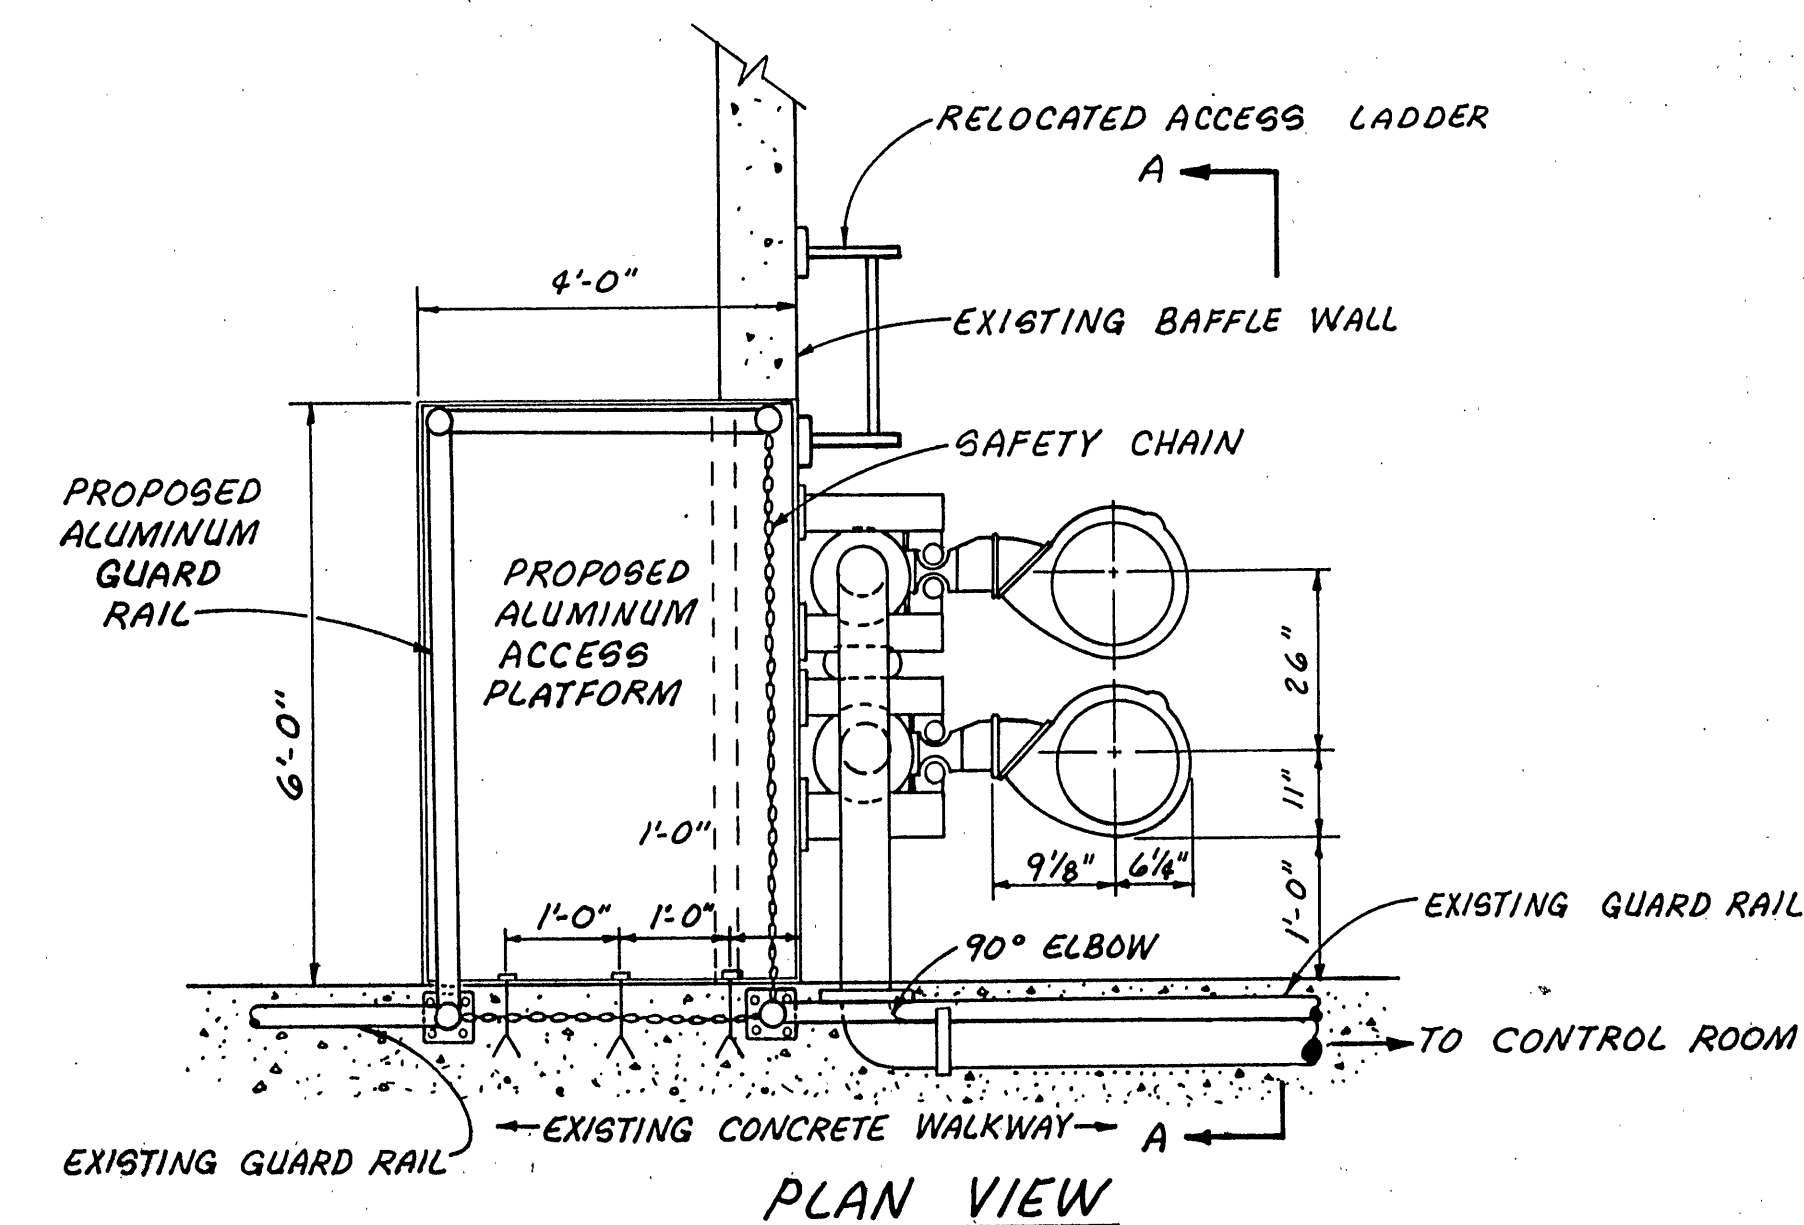


EJECTOR WATER SUPPLY PUMPS
SCALE: 1/2" = 1'-0"


- NOTES
1. SAFETY CHAINS TO BE INSTALLED AT PLATFORM & PUMP ACCESS AREAS
 2. ALL PIPING TO BE CLASS 50 DUCTILE UNLESS NOTED OTHERWISE.
 3. PUMP ELECTRICAL CONTROLS TO BE MOUNTED ON EXISTING HANDRAIL AT A LOCATION DESIGNATED BY THE OWNER.
 4. PUMPS TO BE CONTROLLED MANUALLY
 5. GUIDE RAILS DELETED FOR CLARITY

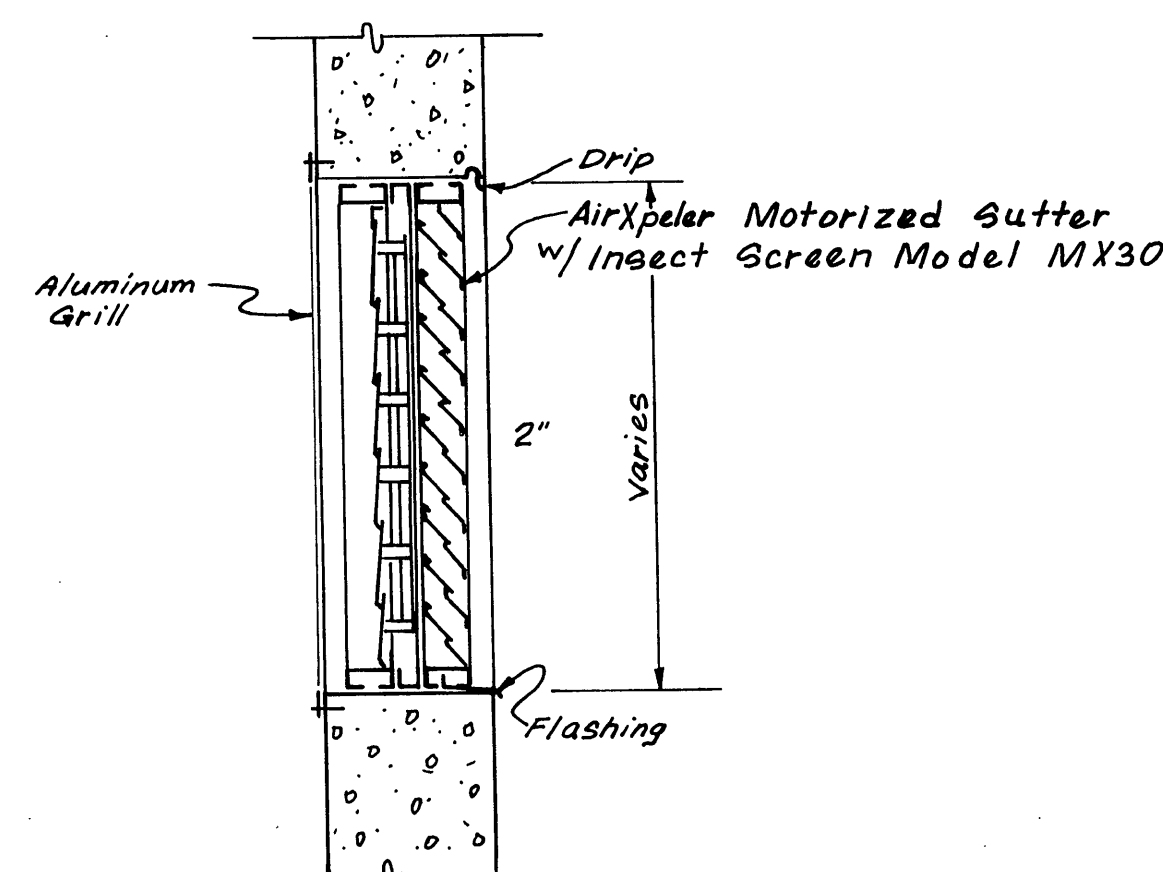


FRESH AIR INTAKE LOUVER
Scale: 3/4" = 1'-0"
(TYP. @ CL₂, 80₂, & CONTROL RM.)
SECTION 9
7

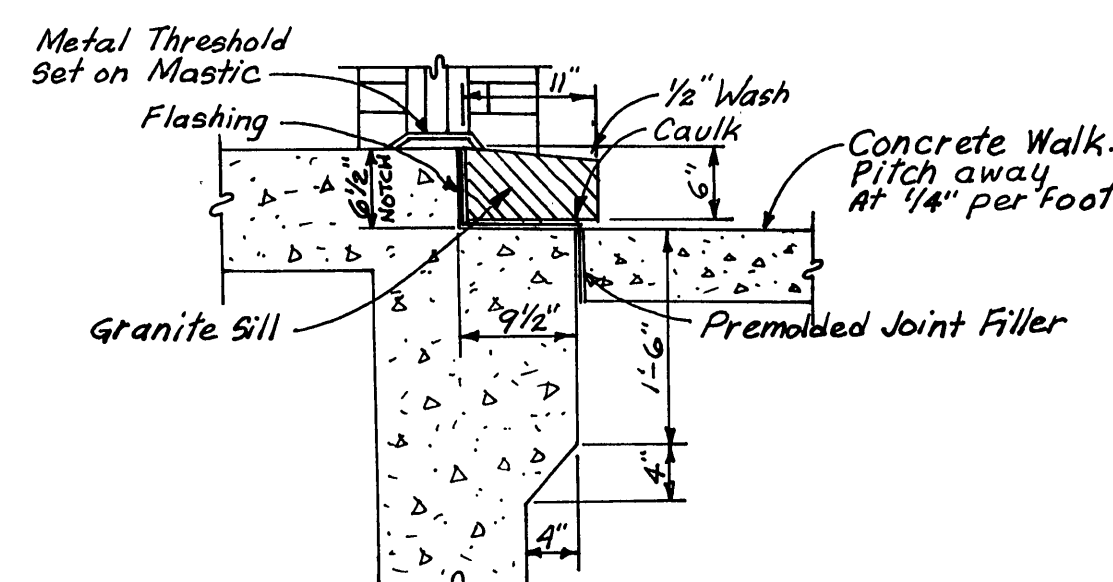


ENTRANCE DOOR DETAILS 8
7
SCALE: 3/4" = 1'-0"

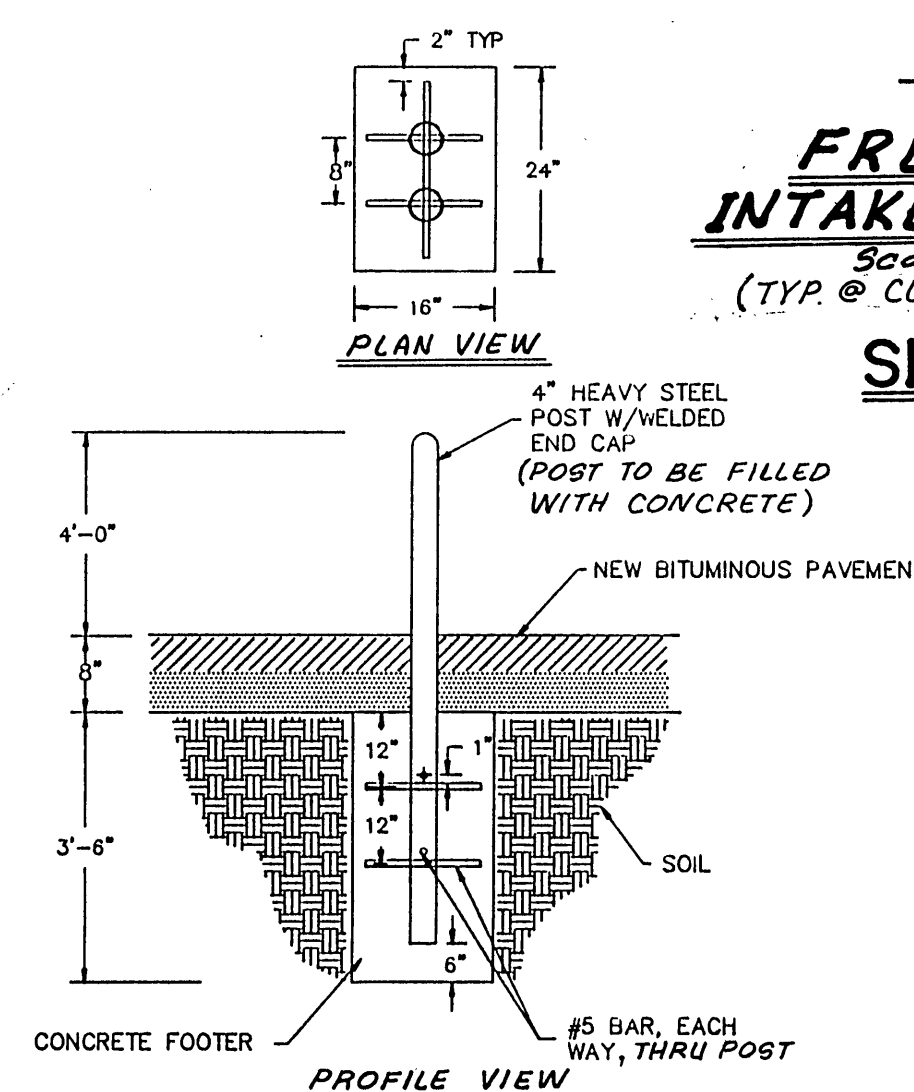


GUARD POST DETAIL
NOT TO SCALE

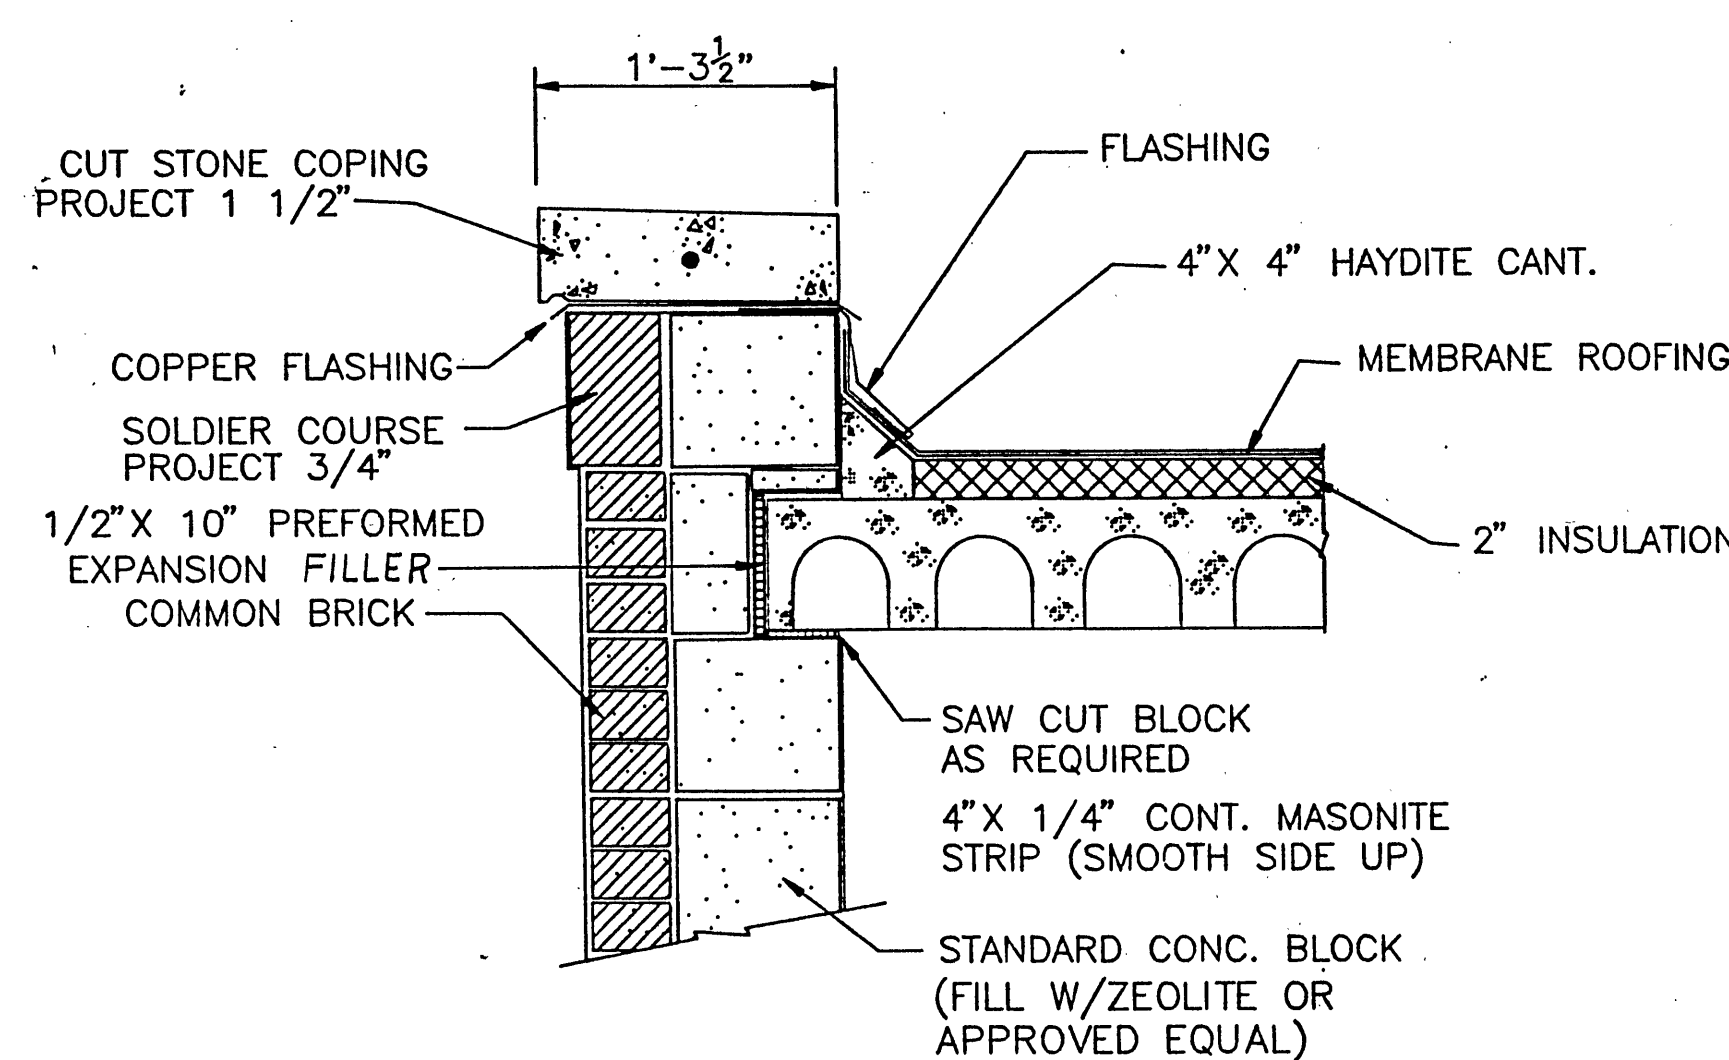

TYPICAL WALL SECTION 6
7
SCALE: 3/4" = 1'

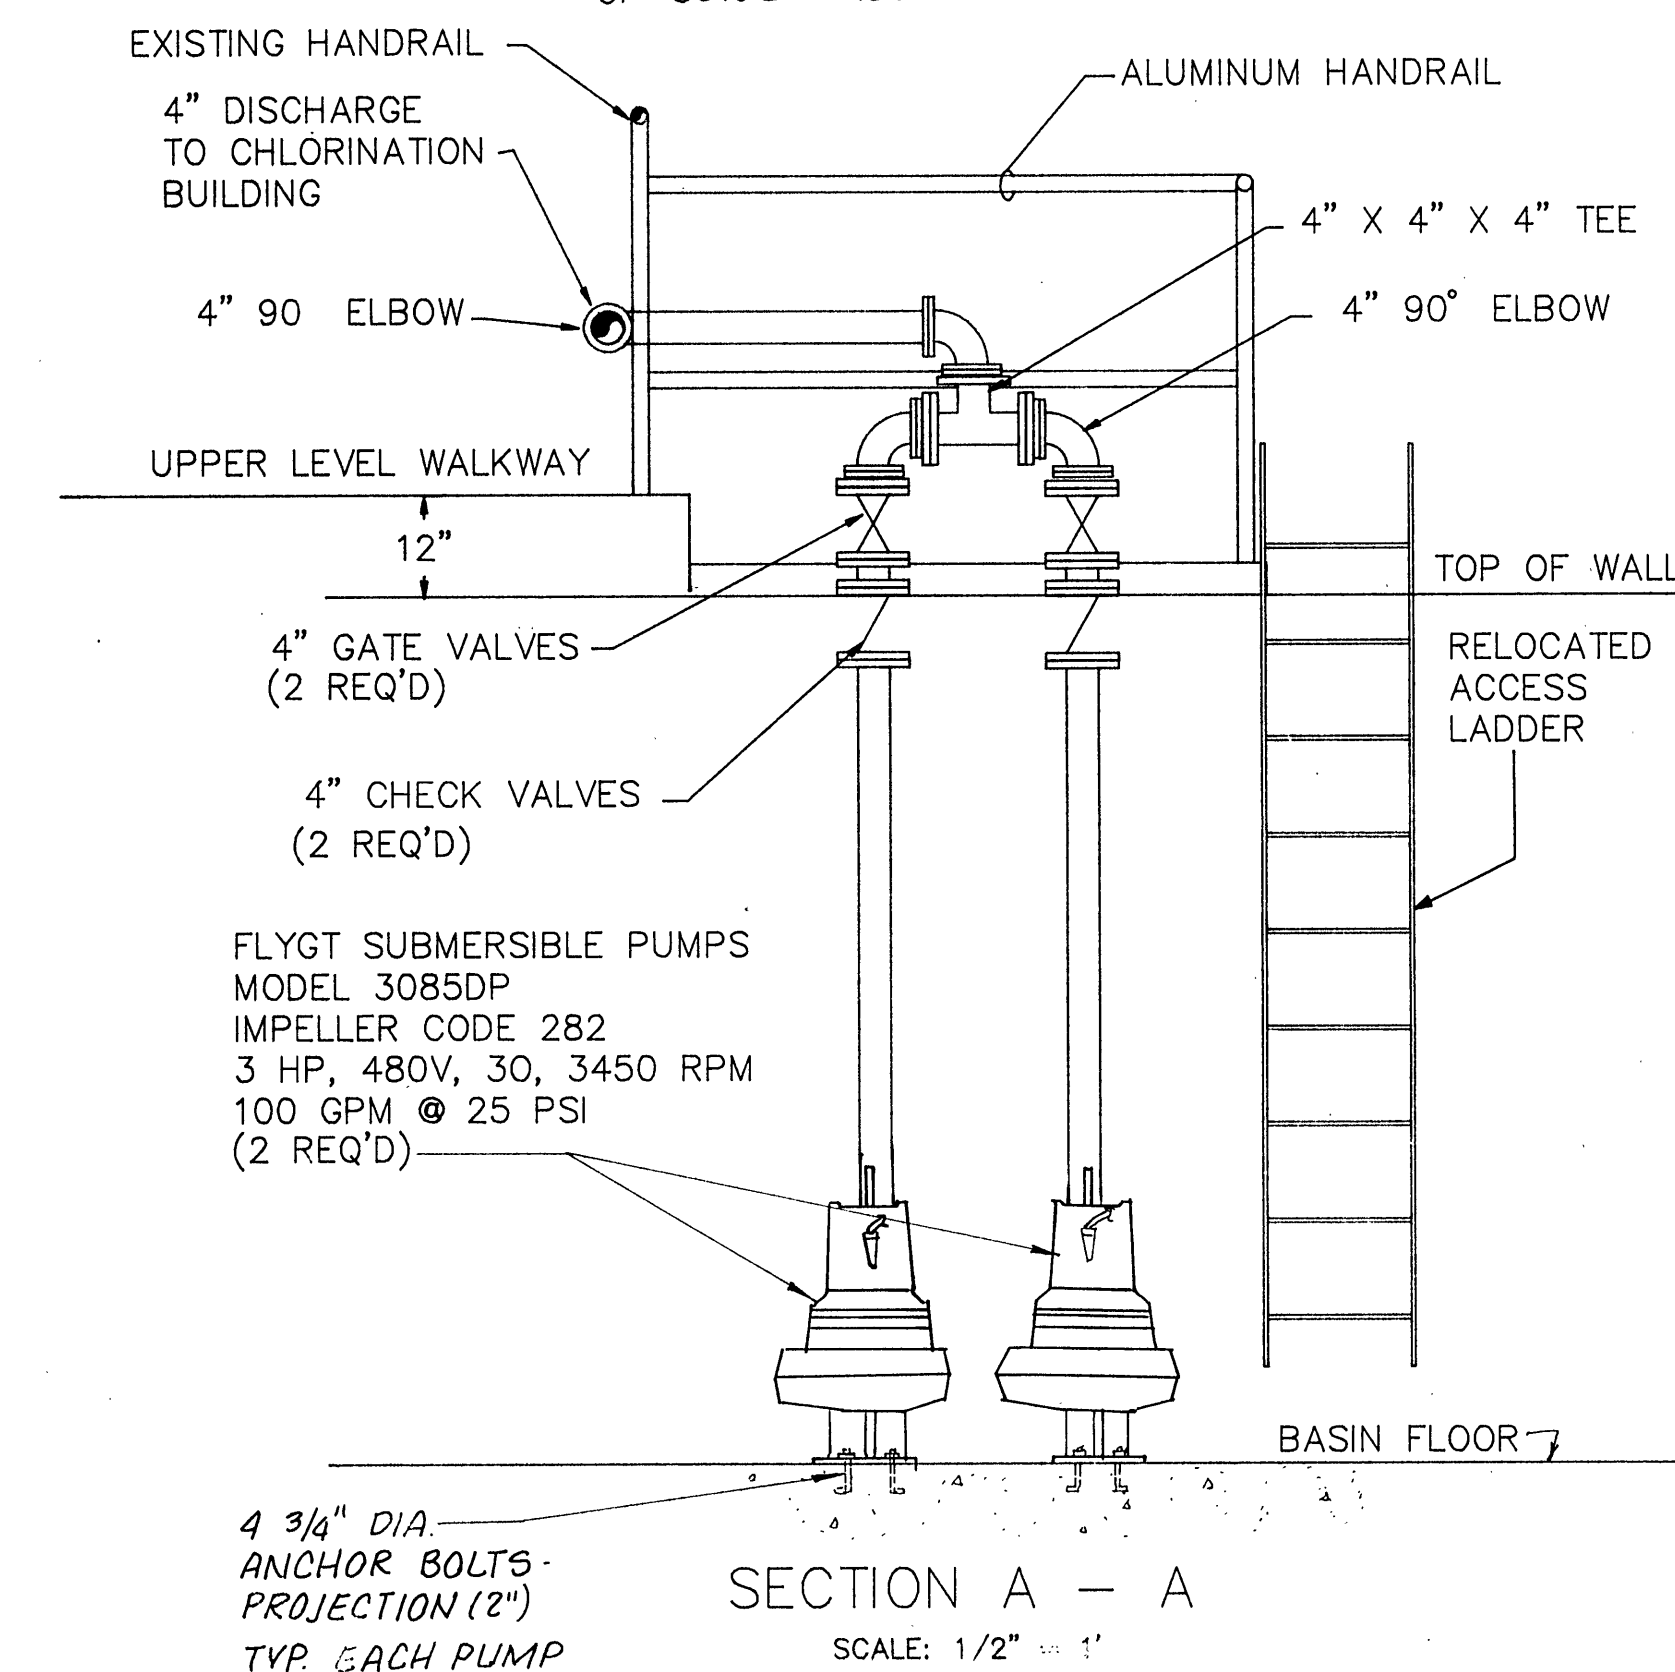

SECTION A - A
SCALE: 1/2" = 1'

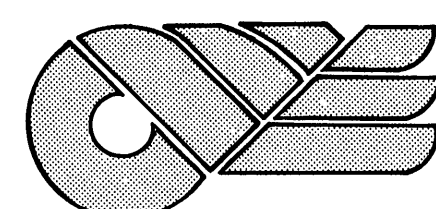


CLEAN WATER ENGINEERS, INC.

P.O. BOX 218
FINCASTLE, VIRGINIA 24090

P.O. BOX 3225
STAUNTON VIRGINIA, 24401

ROANOKE WATER POLLUTION CONTROL FACILITY
CHLORINATION / DECHLORINATION FACILITIES
ARCH. DETAILS

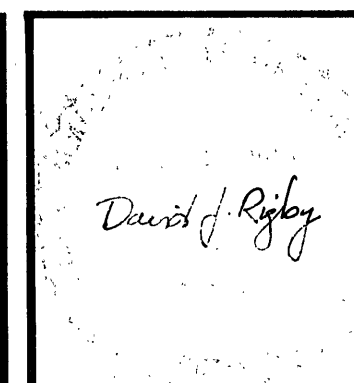

REVISIONS		
NO.	DATE	BY
1	5-5-89	WGP
2	5-9-89	DJR

DESIGNED: WGP	SHEET: 7 OF 10
DRAWN: TAP	SCALE: 3/4" = 1'-0"
CHECKED: WGP	DATE: FEB. 1989
APPROVED: DJR	PROJECT: 87025