


PROJECT LOCATION MAP



LOCATION MAP
NO SCALE

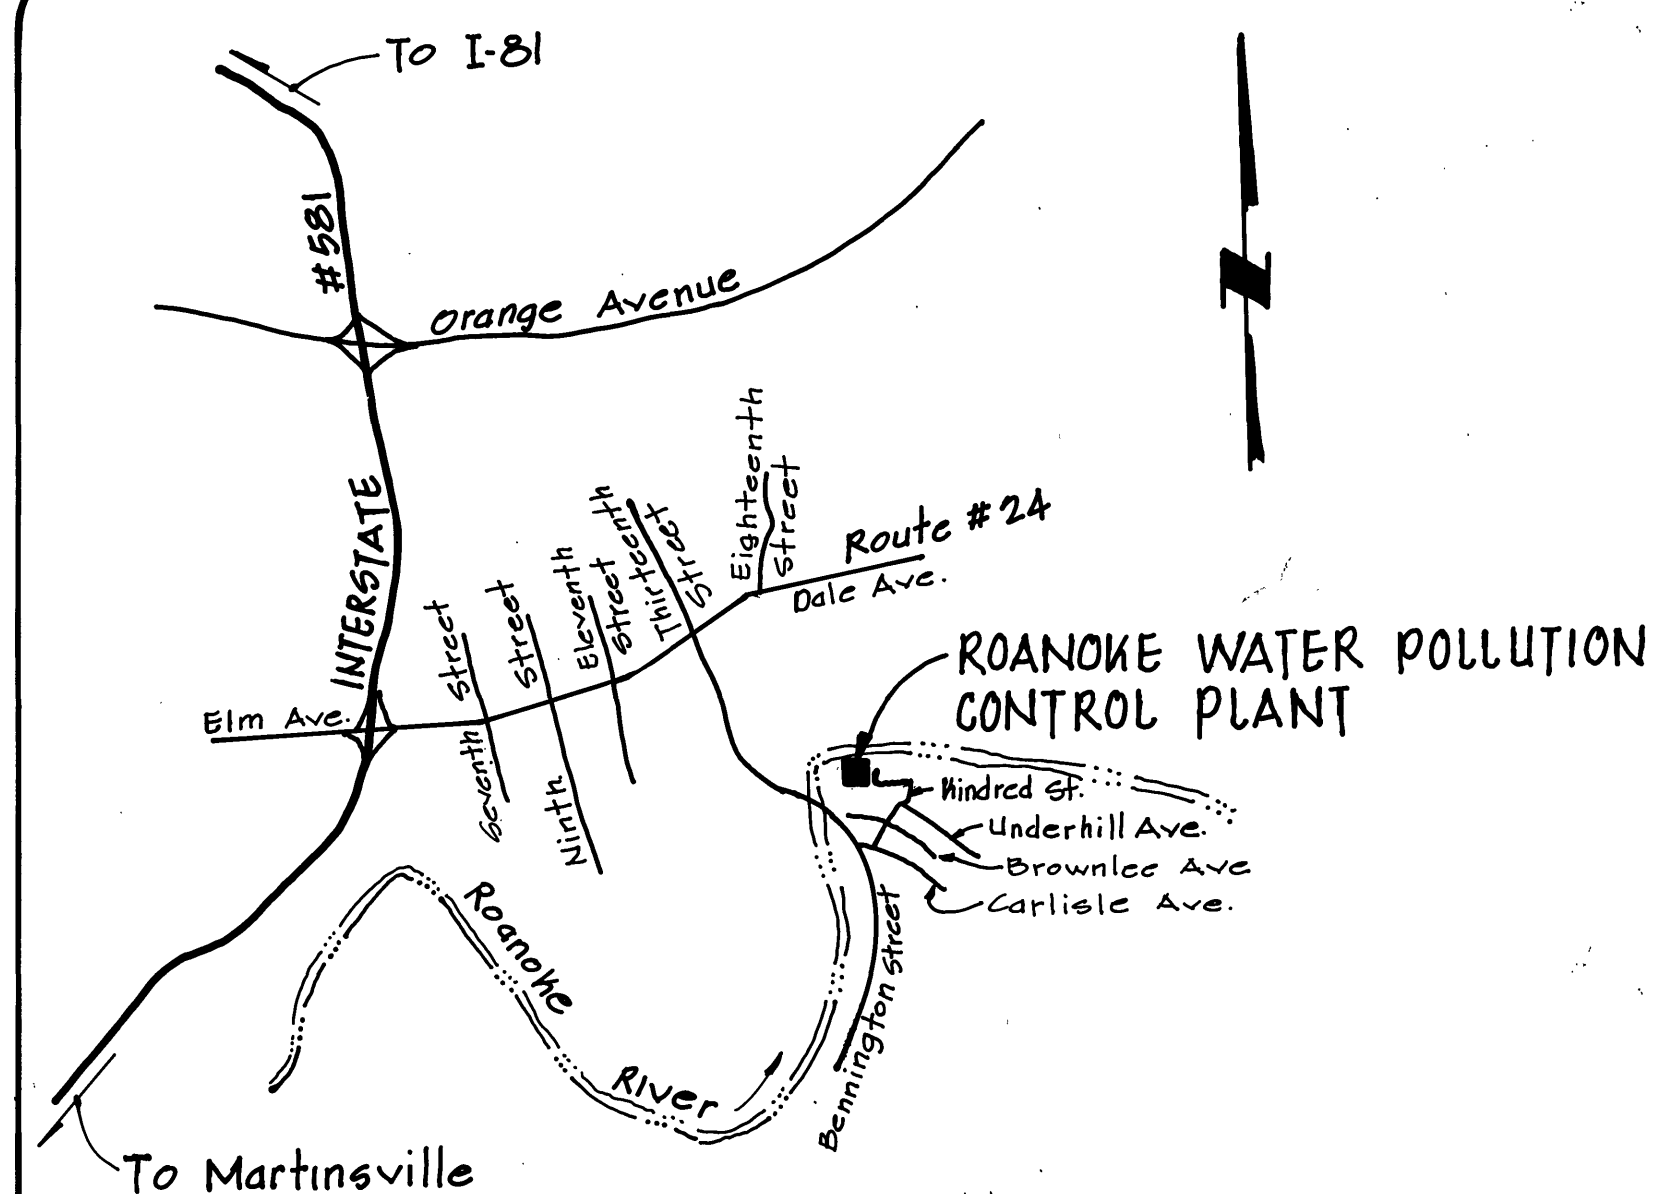

OFFICE OF CITY ENGINEER
ROOM 350
MUNICIPAL BUILDING
215 CHURCH AVENUE, S.W.
ROANOKE, VIRGINIA 24011

INDEX OF SHEETS

SHEET NO.	SHEET TITLE
1.	COVER SHEET
2.	ABBREVIATIONS, LEGEND, AND SUMMARY OF QUANTITIES
3.	PURIFIED GAS LINE REPLACEMENT - EXTERIOR
4.	PURIFIED GAS LINE REPLACEMENT - INTERIOR
5.	EXISTING YARD PIPING PLAN (REFERENCE SHEET)
6.	DETAILS AND SECTIONS

CONSULTING ENGINEERS

**MATTERN AND CRAIG
CONSULTING ENGINEERS
ROANOKE, VIRGINIA**

COMMISSION NUMBER: 658

PROJECT NAME

**PURIFIED GAS LINE REPLACEMENT

ROANOKE
WATER POLLUTION CONTROL PLANT**

PROJECT NUMBER: 18-86

REVISION	BY	DESCRIPTION:	DATE
REVISION	BY	DESCRIPTION:	DATE
REVISION	BY	DESCRIPTION:	DATE
REVISION	BY	DESCRIPTION:	DATE

APPROVED FOR CONSTRUCTION

ROANOKE CITY ENGINEER	DATE
DIRECTOR OF PUBLIC WORKS	DATE
DIRECTOR OF UTILITIES AND OPERATIONS	DATE
	DATE
	DATE

ADVERTISED DATE: _____

SET NUMBER: _____

SHEET NUMBER: 1 OF 6