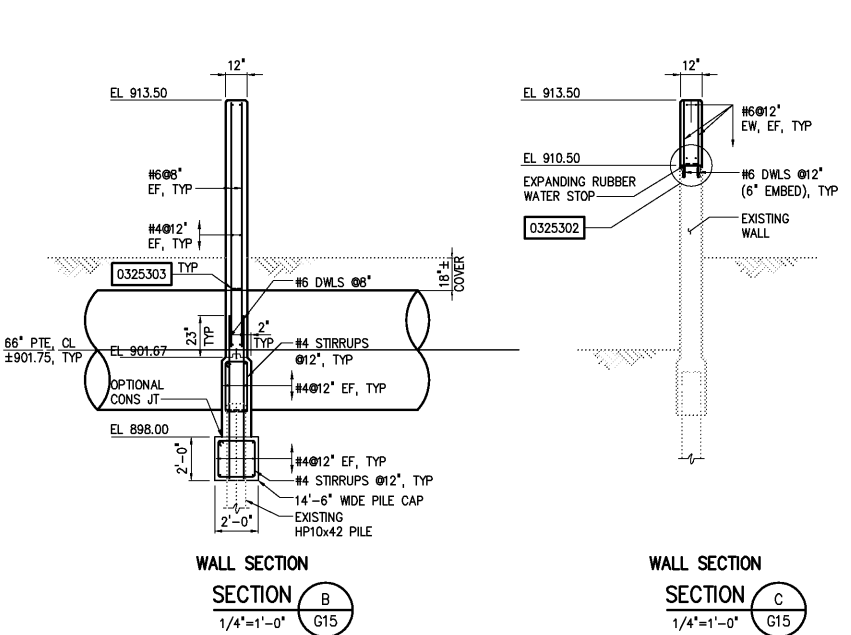
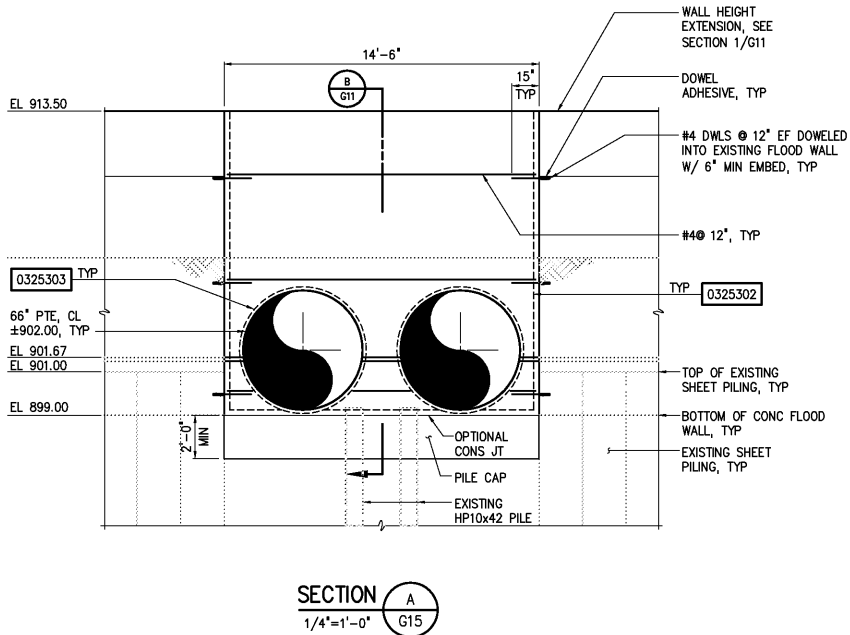

$$1'' = 10'$$


				DESIGNED _____ WGL/DDZ	RECORD DRAWING THIS DRAWING HAS BEEN MODIFIED TO REFLECT FIELD CHANGES REPORTED BY THE CONTRACTOR OR ANOTHER PARTY, BUT NOT VERIFIED BY THE CERTIFYING ENGINEER. THIS DOCUMENT ORIGINALLY ISSUED AND SEALED BY CHRISTOPHER T. PHILLIPS, 033796. THIS MEDIA SHALL NOT BE CONSIDERED A CERTIFIED DOCUMENT.	Hazen and Sawyer Environmental Engineers & Scientists 4011 WestChase Blvd., Raleigh, North Carolina 27607	CITY OF ROANOKE VIRGINIA	REGIONAL WATER POLLUTION CONTROL PLANT WET WEATHER IMPROVEMENTS	SITE PLAN GENERAL FLOOD WALL MODIFICATIONS	THE SCALE BAR SHOWN BELOW MEASURES ONE INCH LONG ON THE ORIGINAL DRAWING. 	DATE JULY 2003	
				DRAWN _____ DDZ							H & S JOB NUMBER 30788A	
				CHECKED _____							CONTRACT NUMBER A	DRAWING NUMBER G15
	RECORD DRAWINGS	MAR 2008	RLT	PROJ. ENGR. DAN								
	CONSTRUCTION	MAR 2004	RLT									
	REGULATORY APPROVAL	NOV 2003	RLT									
	PRELIMINARY DESIGN	NOV 2002	RLT									
NO.	ISSUED FOR	DATE	BY	APPROVED _____								