




NOTES:
1 SEE SITE PLANS FOR LOCATION, ELEVATION, AND SIZE OF PIPING AND SLUICE GATE.

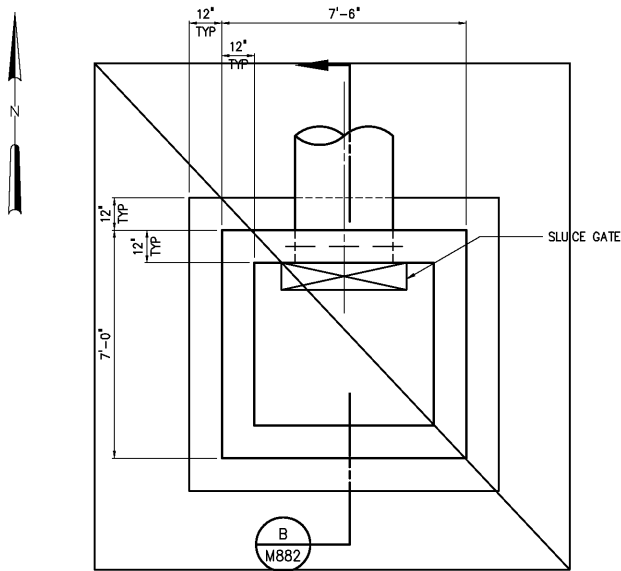


STORMWATER COLLECTION BOX - BOTTOM PLAN
3/8"=1'-0"

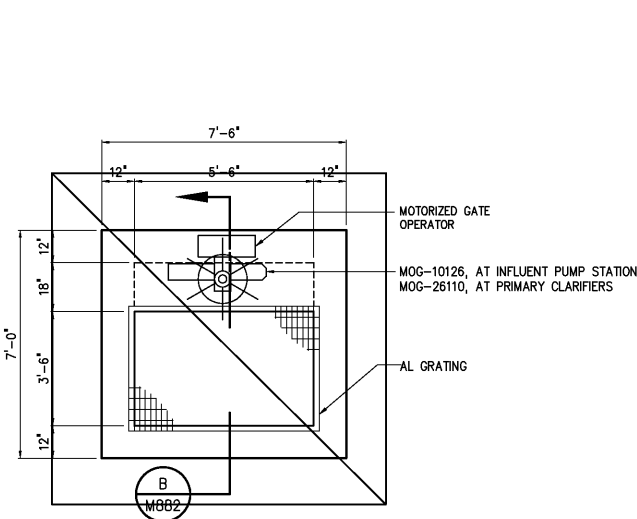


STORMWATER COLLECTION BOX - TOP PLAN
3/8"=1'-0"

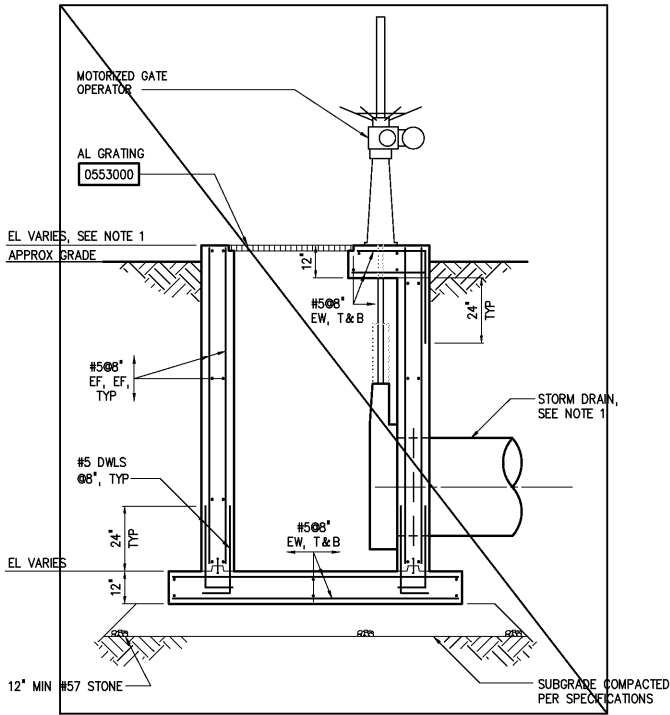


STORMWATER COLLECTION BOX
SECTION B
3/8"=1'-0" M882

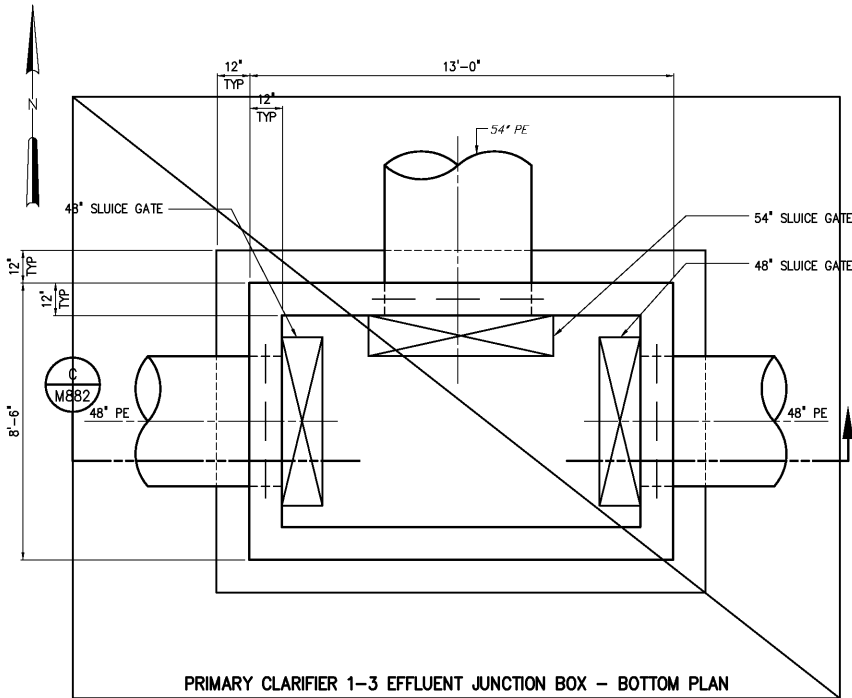

PRIMARY CLARIFIER 1-3 EFFLUENT JUNCTION BOX - BOTTOM PLAN
3/8"=1'-0"

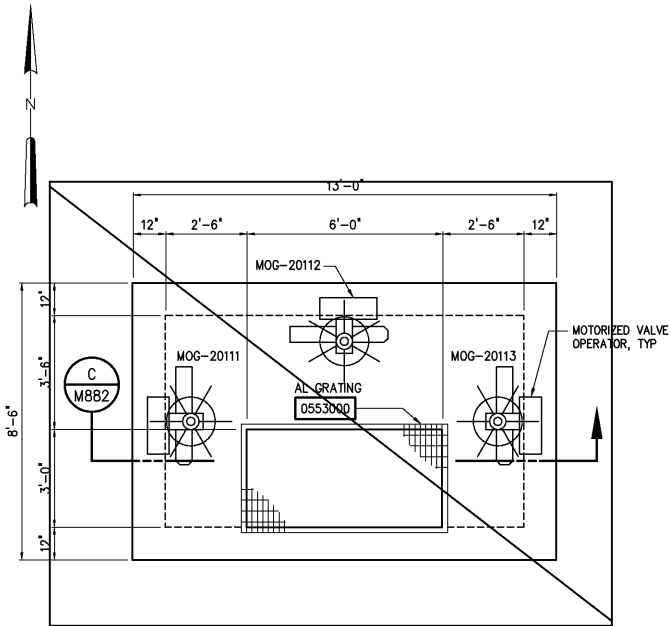

PRIMARY CLARIFIER 1-3 EFFLUENT JUNCTION BOX - TOP PLAN
3/8"=1'-0"

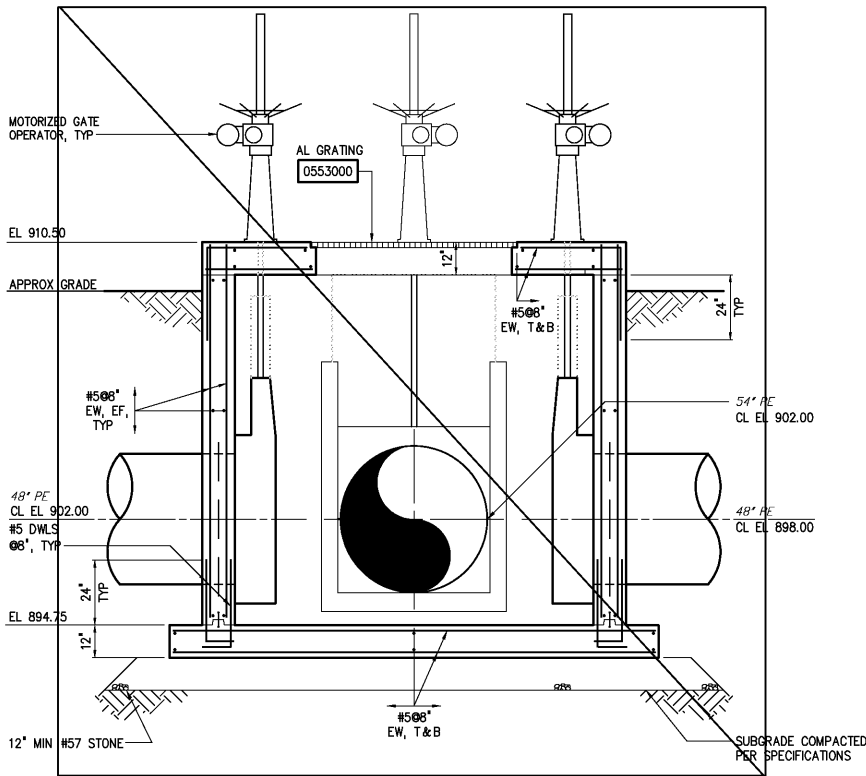

PRIMARY CLARIFIER 1-3 EFFLUENT JUNCTION BOX
SECTION C
3/8"=1'-0" M882

DESIGNED	CMB/WGL
DRAWN	DDZ
CHECKED	
PROJ. ENGR.	DAN
APPROVED	
NO.	

THIS DOCUMENT ORIGINALLY ISSUED FOR CONSTRUCTION AND SEALED BY ROBERT S. DIFIORE, SEAL NO. 22769

RECORD DRAWING

THIS DRAWING HAS BEEN MODIFIED TO REFLECT FIELD CHANGES REPORTED BY THE CONTRACTOR OR ANOTHER PARTY, BUT NOT VERIFIED BY THE CERTIFYING ENGINEER. THIS DOCUMENT ORIGINALLY ISSUED AND SEALED BY DAVID A. NAILOR, 025465. THIS MEDIA SHALL NOT BE CONSIDERED A CERTIFIED DOCUMENT.

THIS DOCUMENT ORIGINALLY ISSUED FOR CONSTRUCTION AND SEALED BY RONALD L. TAYLOR, SEAL NO. 024649

HAZEN AND SAWYER
Environmental Engineers & Scientists
4011 WestChase Blvd, Raleigh, North Carolina 27607

CITY OF ROANOKE
VIRGINIA

REGIONAL WATER POLLUTION CONTROL PLANT
WET WEATHER IMPROVEMENTS

MISCELLANEOUS YARD STRUCTURES
MECHANICAL
PLANS, SECTIONS AND DETAILS

THE SCALE BAR SHOWN BELOW MEASURES ONE INCH LONG ON THE ORIGINAL DRAWING.	DATE	JULY 2003
	H & S JOB NUMBER	30788A
	CONTRACT NUMBER	A
	DRAWING NUMBER	M882