


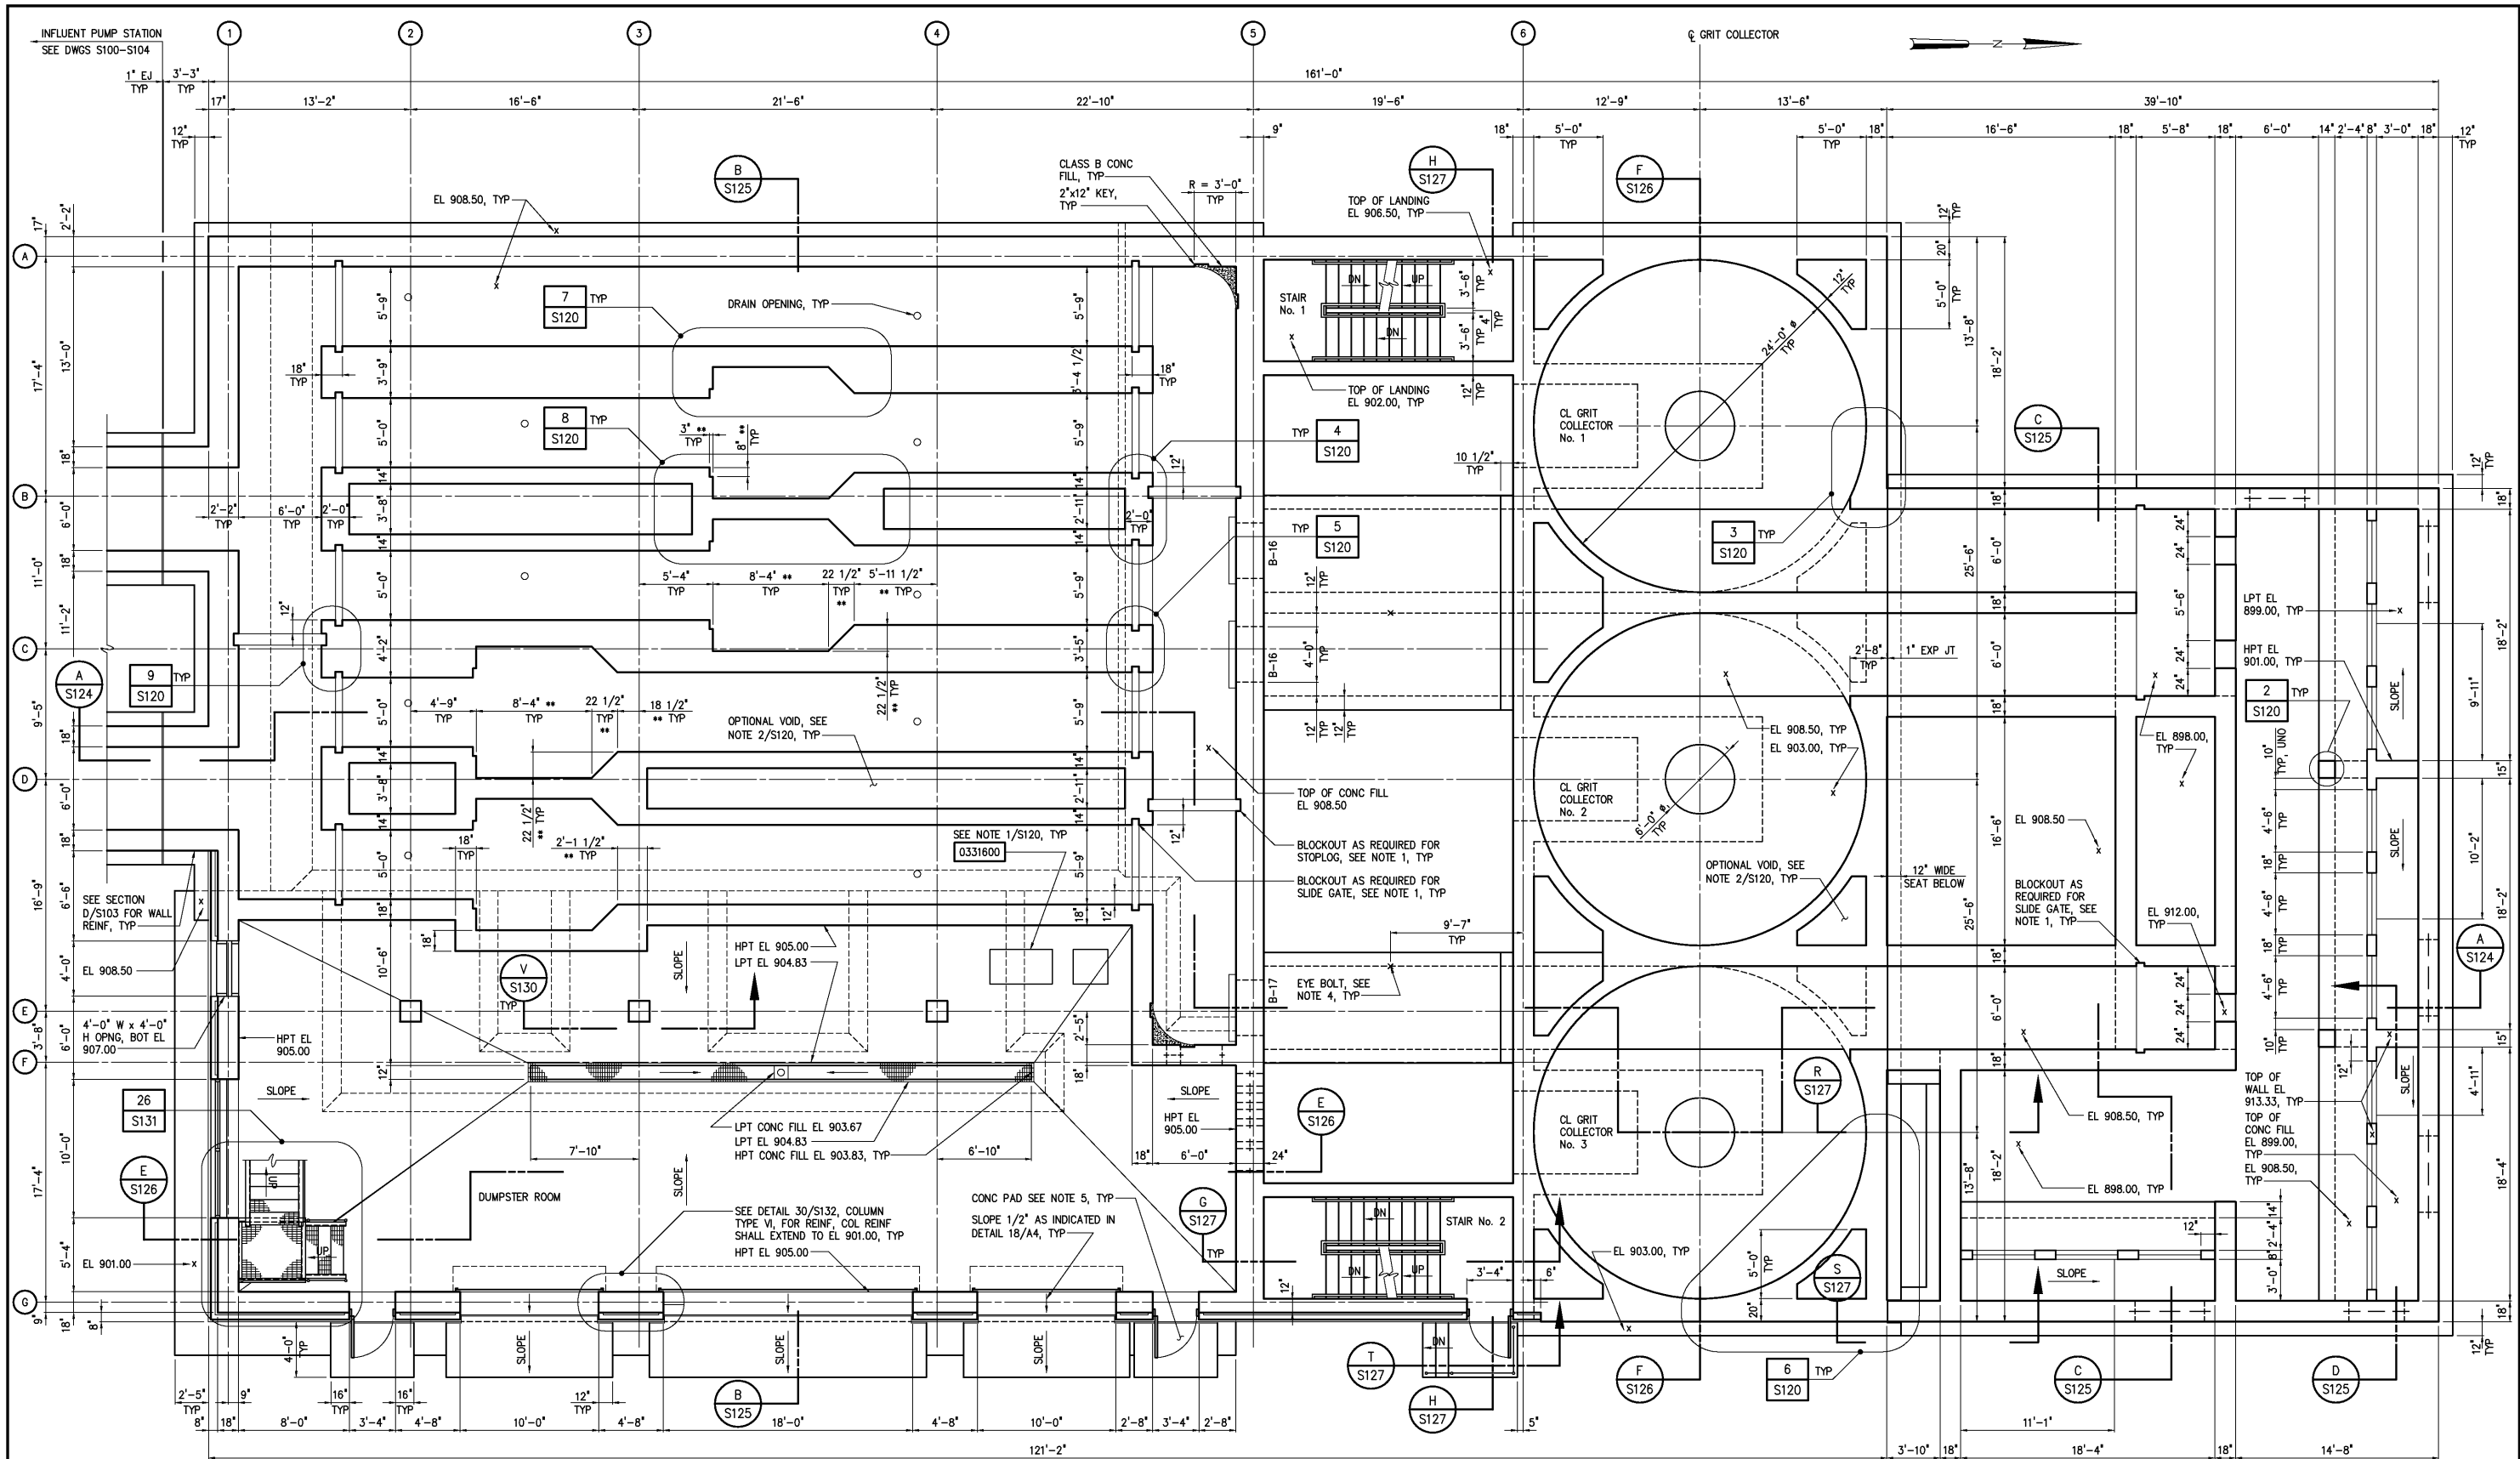

INTERMEDIATE PLAN

3/16"=1'-0"

- NOTES: 1 CONTRACTOR SHALL COORDINATE REQUIRED BLOCKOUT SIZE WITH GATE AND STOP LOG MANUFACTURERS. WALL AND SLAB REINFORCEMENT AROUND BLOCKOUTS SHALL BE AS SHOWN IN STANDARD DETAIL 0331710 OR INDICATED DETAIL.
- 2 ** INDICATES CONTRACTOR SHALL COORDINATE DIMENSION WITH MECHANICAL SCREEN MANUFACTURER PRIOR TO CONSTRUCTION.
- 3 BEAM AND COLUMN SCHEDULES ARE LOCATED ON DRAWING S132.
- 4 X INDICATES LOCATION WHERE EYE BOLT SHALL ATTACH TO UNDERSIDE OF SLAB. SEE STANDARD DETAIL 0550100 AND SECTION H/S127. ALLOWABLE LOAD FOR EYE BOLT SHALL BE 2.0 KIPS.
- 5 PROVIDE 12" THICK CONCRETE PAD WITH #5 BARS EW, T&B. TOP OF PAD EL 905.00.

DESIGNED WGL DRAWN WGL CHECKED PROJ. ENGR. DAN APPROVED				RECORD DRAWING THIS DRAWING HAS BEEN MODIFIED TO REFLECT FIELD CHANGES REPORTED BY THE CONTRACTOR OR ANOTHER PARTY, BUT NOT VERIFIED BY THE CERTIFYING ENGINEER. THIS DOCUMENT ORIGINALLY ISSUED AND SEALED BY CHRISTOPHER T. PHILLIPS, 033796. THIS MEDIA SHALL NOT BE CONSIDERED A CERTIFIED DOCUMENT.		HAZEN AND SAWYER Environmental Engineers & Scientists 4011 WestChase Blvd, Raleigh, North Carolina 27607		CITY OF ROANOKE VIRGINIA REGIONAL WATER POLLUTION CONTROL PLANT WET WEATHER IMPROVEMENTS		PRELIMINARY TREATMENT FACILITIES STRUCTURAL INTERMEDIATE PLAN		THE SCALE BAR SHOWN BELOW MEASURES ONE INCH LONG ON THE ORIGINAL DRAWING. DATE JULY 2003 H & S JOB NUMBER 30788A CONTRACT NUMBER A DRAWING NUMBER S121	
NO.	RECORD DRAWINGS	MAR 2008	RLT	ISSUED FOR	DATE	BY	APPROVED						
	CONSTRUCTION	MAR 2004	RLT										
	REGULATORY APPROVAL	NOV 2003	RLT										
	PRELIMINARY DESIGN	NOV 2002	RLT										