


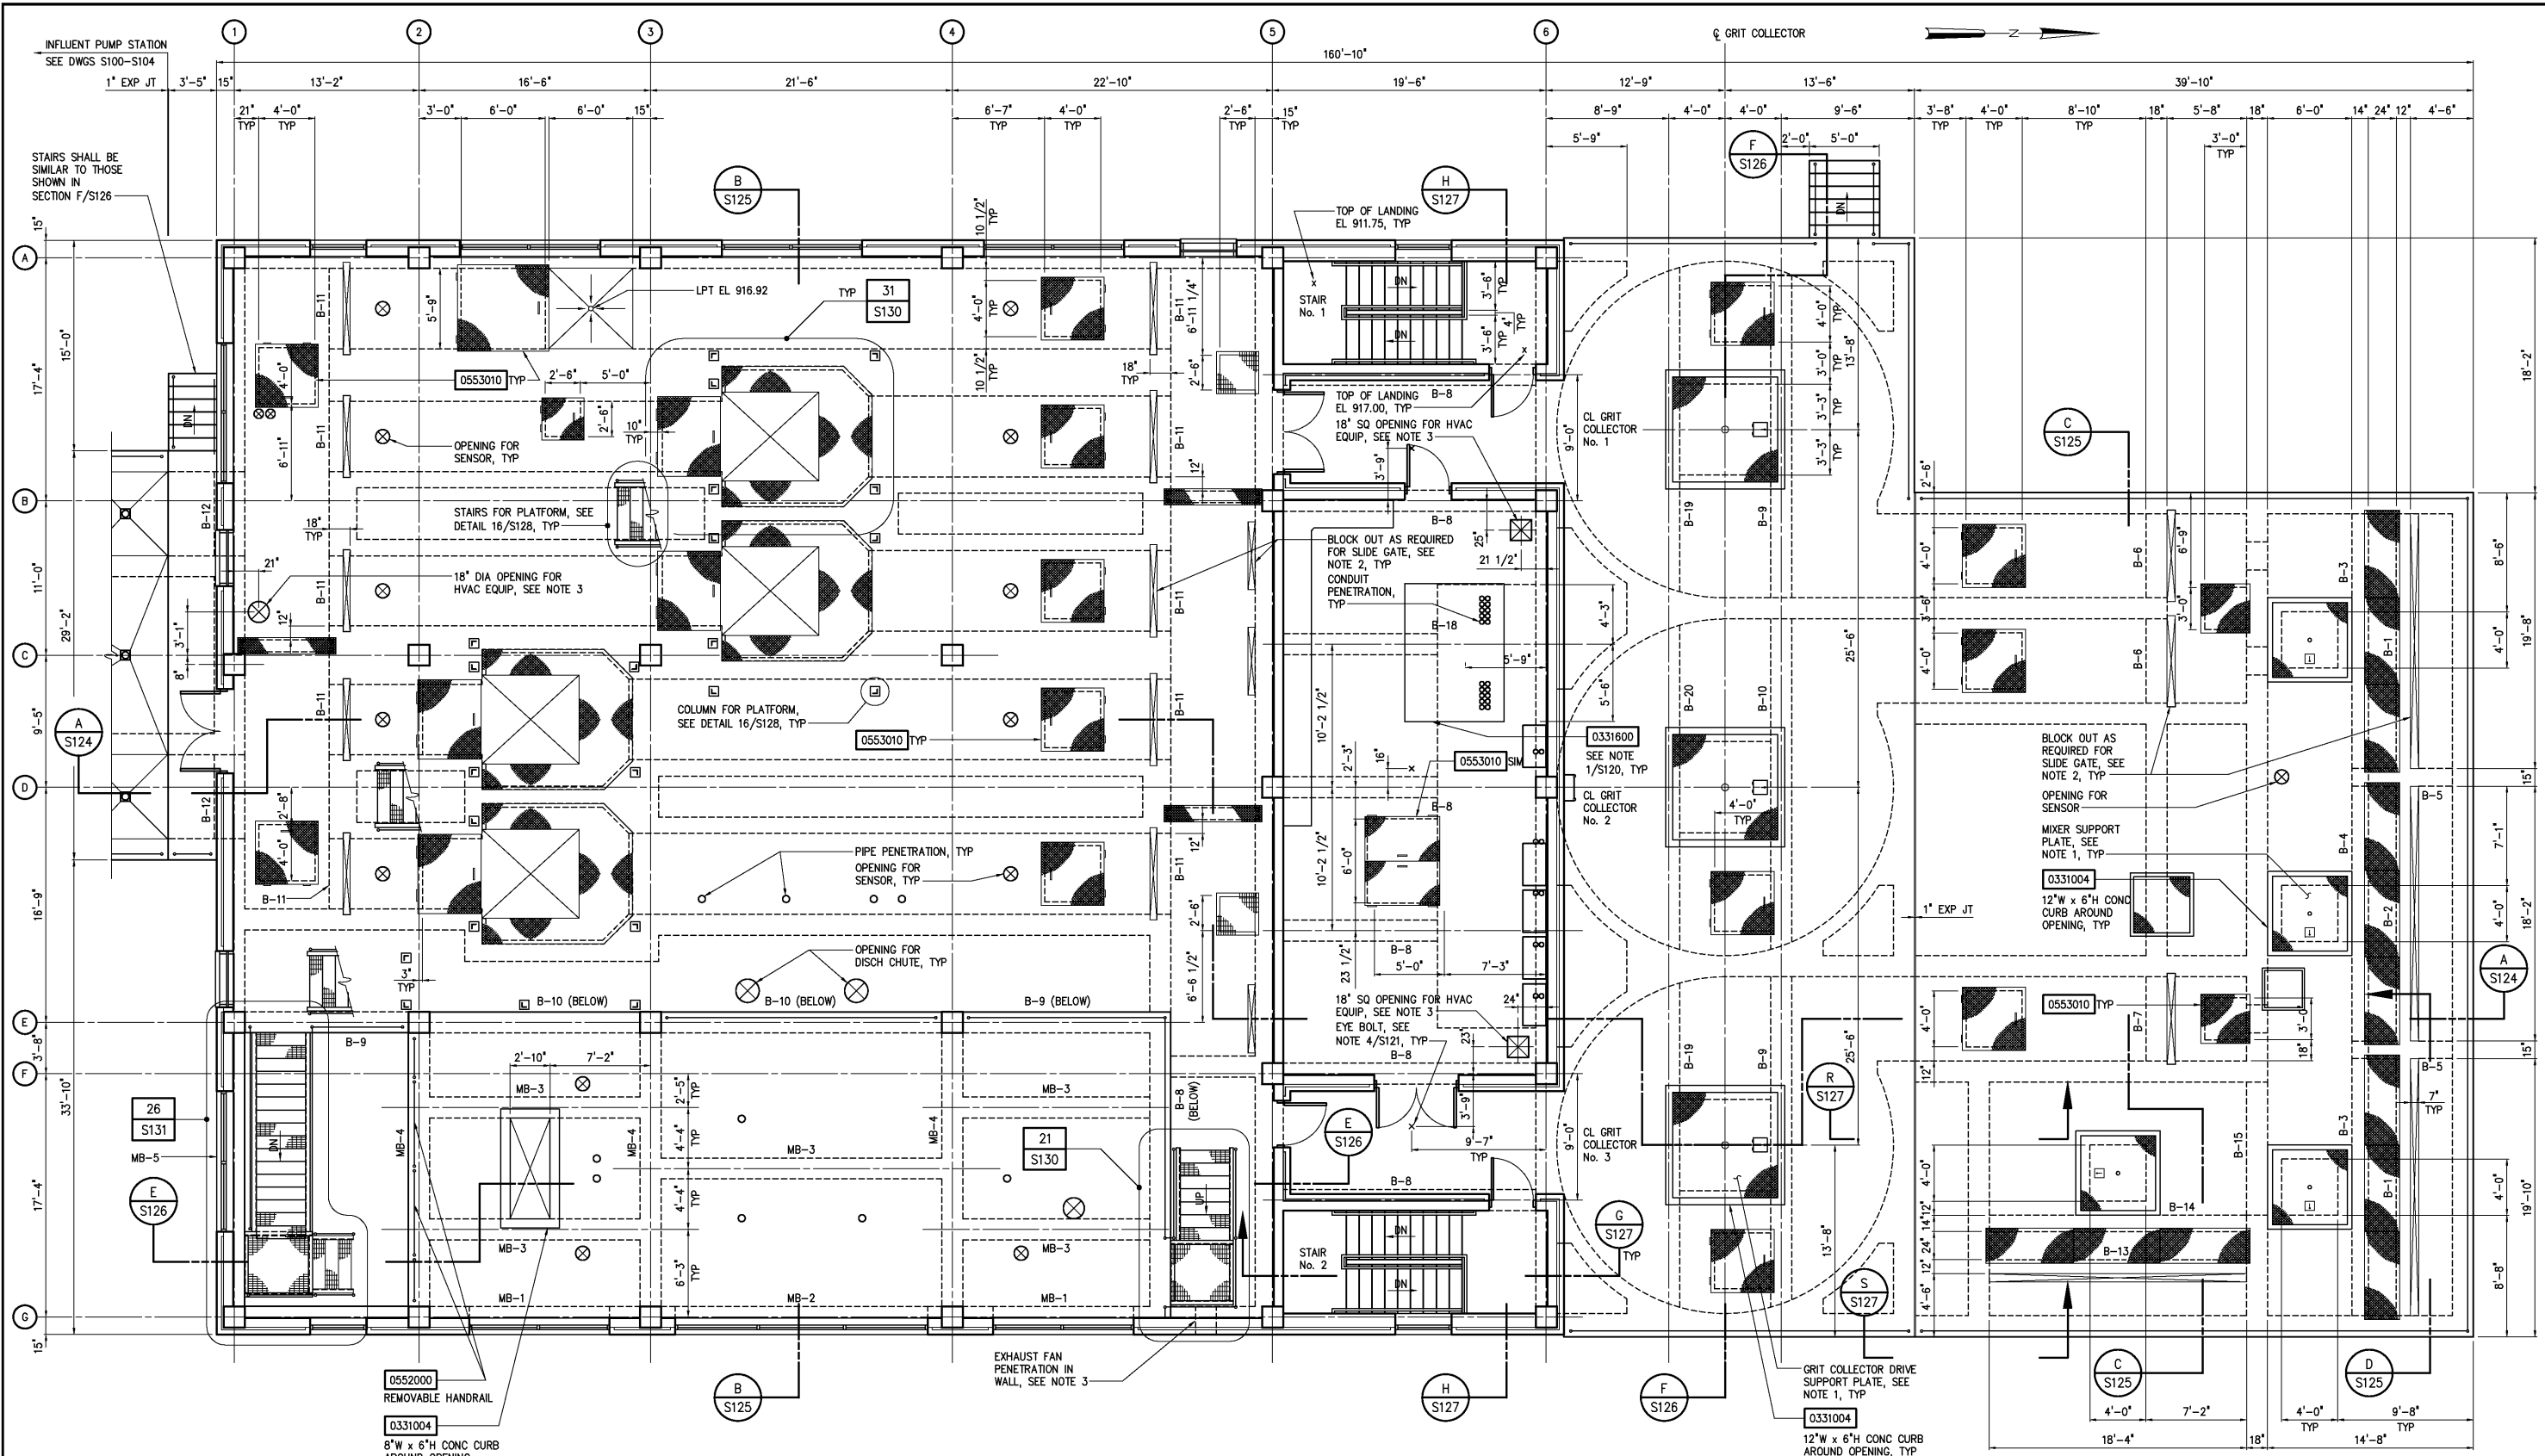

TOP PLAN
3/16"=1'-0"

- NOTES: 1 MIXER AND GRIT COLLECTOR DRIVE SUPPORT PLATES SHALL BE DESIGNED BY MANUFACTURERS OF EQUIPMENT. MANUFACTURER SHALL SUBMIT DESIGN DRAWINGS AND CALCULATIONS, SEALED BY A LICENSED ENGINEER IN THE STATE OF VIRGINIA. DRAWINGS AND CALCULATIONS SHALL BE SUBMITTED WITH SHOP DRAWINGS FOR ASSOCIATED EQUIPMENT. PLATES SHALL BE FABRICATED FROM EITHER ALUMINUM ALLOY 6061-T6 OR TYPE 316 STAINLESS STEEL.
- 2 CONTRACTOR SHALL COORDINATE REQUIRED BLOCKOUT SIZE WITH GATE AND STOP LOG MANUFACTURERS.
- 3 CONTRACTOR SHALL COORDINATE SIZE AND LOCATION OF ALL HVAC OPENINGS WITH EQUIPMENT MANUFACTURER.
- 4 BEAM AND COLUMN SCHEDULES ARE LOCATED ON DRAWING S132.

RECORD DRAWINGS	MAR 2008	RLT
CONSTRUCTION	MAR 2004	RLT
REGULATORY APPROVAL	NOV 2003	RLT
PRELIMINARY DESIGN	NOV 2002	RLT
ISSUED FOR	DATE	BY
NO.		APPROVED

DESIGNED WGL
DRAWN WGL
CHECKED
PROJ. ENGR. DAN
APPROVED

THIS DOCUMENT ORIGINALLY ISSUED FOR CONSTRUCTION AND SEALED BY ROBERT S. DIFIORE, SEAL NO. 22769

THIS DOCUMENT ORIGINALLY ISSUED FOR CONSTRUCTION AND SEALED BY RONALD L. TAYLOR, SEAL NO. 024649

RECORD DRAWING

THIS DRAWING HAS BEEN MODIFIED TO REFLECT FIELD CHANGES REPORTED BY THE CONTRACTOR OR ANOTHER PARTY, BUT NOT VERIFIED BY THE CERTIFYING ENGINEER. THIS DOCUMENT ORIGINALLY ISSUED AND SEALED BY CHRISTOPHER T. PHILLIPS, 033796. THIS MEDIA SHALL NOT BE CONSIDERED A CERTIFIED DOCUMENT.

HAZEN AND SAWYER
Environmental Engineers & Scientists
4011 WestChase Blvd, Raleigh, North Carolina 27607

CITY OF ROANOKE
VIRGINIA

REGIONAL WATER POLLUTION CONTROL PLANT
WET WEATHER IMPROVEMENTS

PRELIMINARY TREATMENT FACILITIES
STRUCTURAL
TOP PLAN

THE SCALE BAR SHOWN BELOW MEASURES ONE INCH LONG ON THE ORIGINAL DRAWING.	DATE JULY 2003
H & S JOB NUMBER 30788A	CONTRACT NUMBER A
DRAWING NUMBER S122	