
 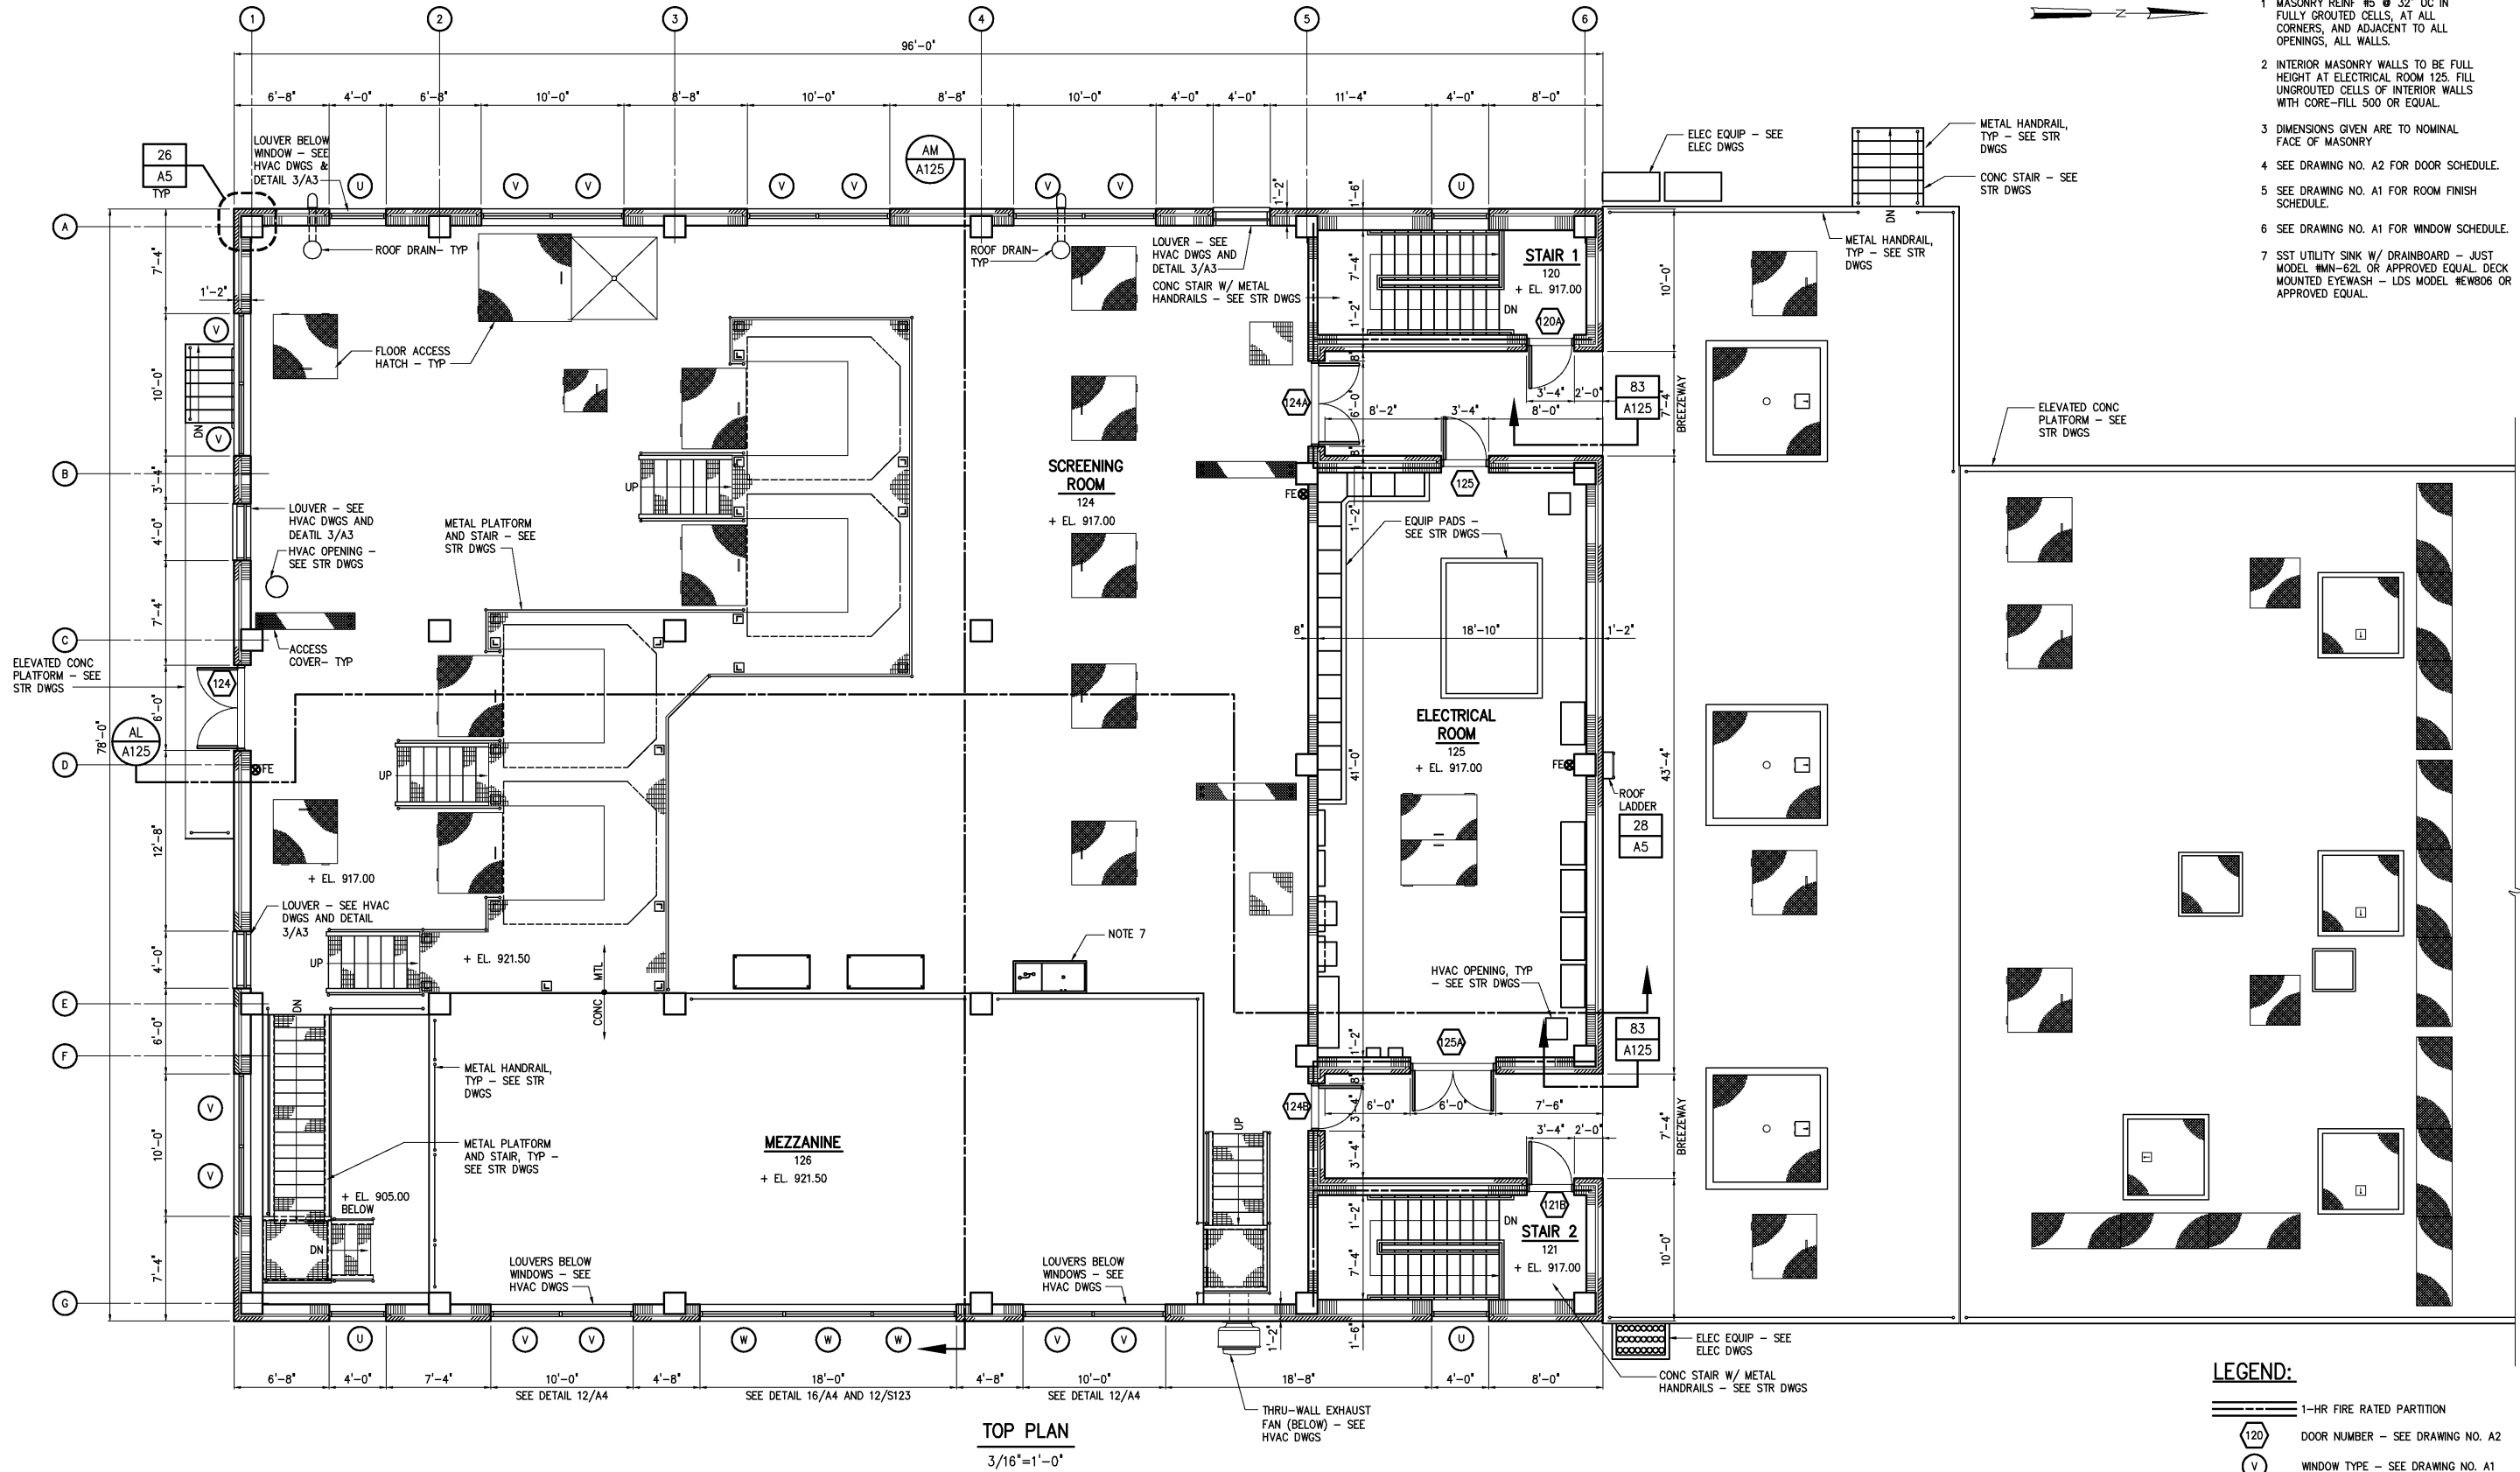


NOTES:

- 1 MASONRY REINF #5 @ 32" OC IN FULLY GROUTED CELLS, AT ALL CORNERS, AND ADJACENT TO ALL OPENINGS, ALL WALLS.
- 2 INTERIOR MASONRY WALLS TO BE FULL HEIGHT AT ELECTRICAL ROOM 125. FILL UNGROUTED CELLS OF INTERIOR WALLS WITH CORE-FILL 500 OR EQUAL.
- 3 DIMENSIONS GIVEN ARE TO NOMINAL FACE OF MASONRY
- 4 SEE DRAWING NO. A2 FOR DOOR SCHEDULE.
- 5 SEE DRAWING NO. A1 FOR ROOM FINISH SCHEDULE.
- 6 SEE DRAWING NO. A1 FOR WINDOW SCHEDULE.
- 7 SST UTILITY SINK W/ DRAINBOARD - JUST MODEL #MN-62L OR APPROVED EQUAL. MOUNTED EYEWASH - LDS MODEL #EW806 OR APPROVED EQUAL.



TOP PLAN

3/16"=1'-0"

LEGEND:

- 1-HR FIRE RATED PARTITION
- DOOR NUMBER - SEE DRAWING NO. A2
- WINDOW TYPE - SEE DRAWING NO. A1
- FE- FIRE EXTINGUISHER

DESIGNED	WHR/DAW
DRAWN	ALB/DAW
CHECKED	
PROJ. ENGR.	DAN
APPROVED	
NO.	
ISSUED FOR	
DATE	
BY	

THIS DOCUMENT ORIGINALLY ISSUED FOR CONSTRUCTION AND SEALED BY ROBERT S. DIFIORE, SEAL NO. 22769

THIS DOCUMENT ORIGINALLY ISSUED FOR CONSTRUCTION AND SEALED BY RONALD L. TAYLOR, SEAL NO. 024649

RECORD DRAWING

**HAZEN AND SAWYER**  
Environmental Engineers & Scientists  
4011 WestChase Blvd, Raleigh, North Carolina 27607

CITY OF ROANOKE  
VIRGINIA

REGIONAL WATER POLLUTION CONTROL PLANT  
WET WEATHER IMPROVEMENTS

PRELIMINARY TREATMENT FACILITIES  
ARCHITECTURAL  
TOP PLAN

THE SCALE BAR SHOWN BELOW MEASURES ONE INCH LONG ON THE ORIGINAL DRAWING.	DATE	JULY 2003
	H & S JOB NUMBER	30788A
	CONTRACT NUMBER	A
	DRAWING NUMBER	A122