



- NOTES:
- 1 BOTTOM OF UNIT HEATER SHALL BE 8'-0" AFF.
 - 2 CONTROL PANEL SHALL BE PROVIDED AND INSTALLED BY ELECTRICAL CONTRACTOR.

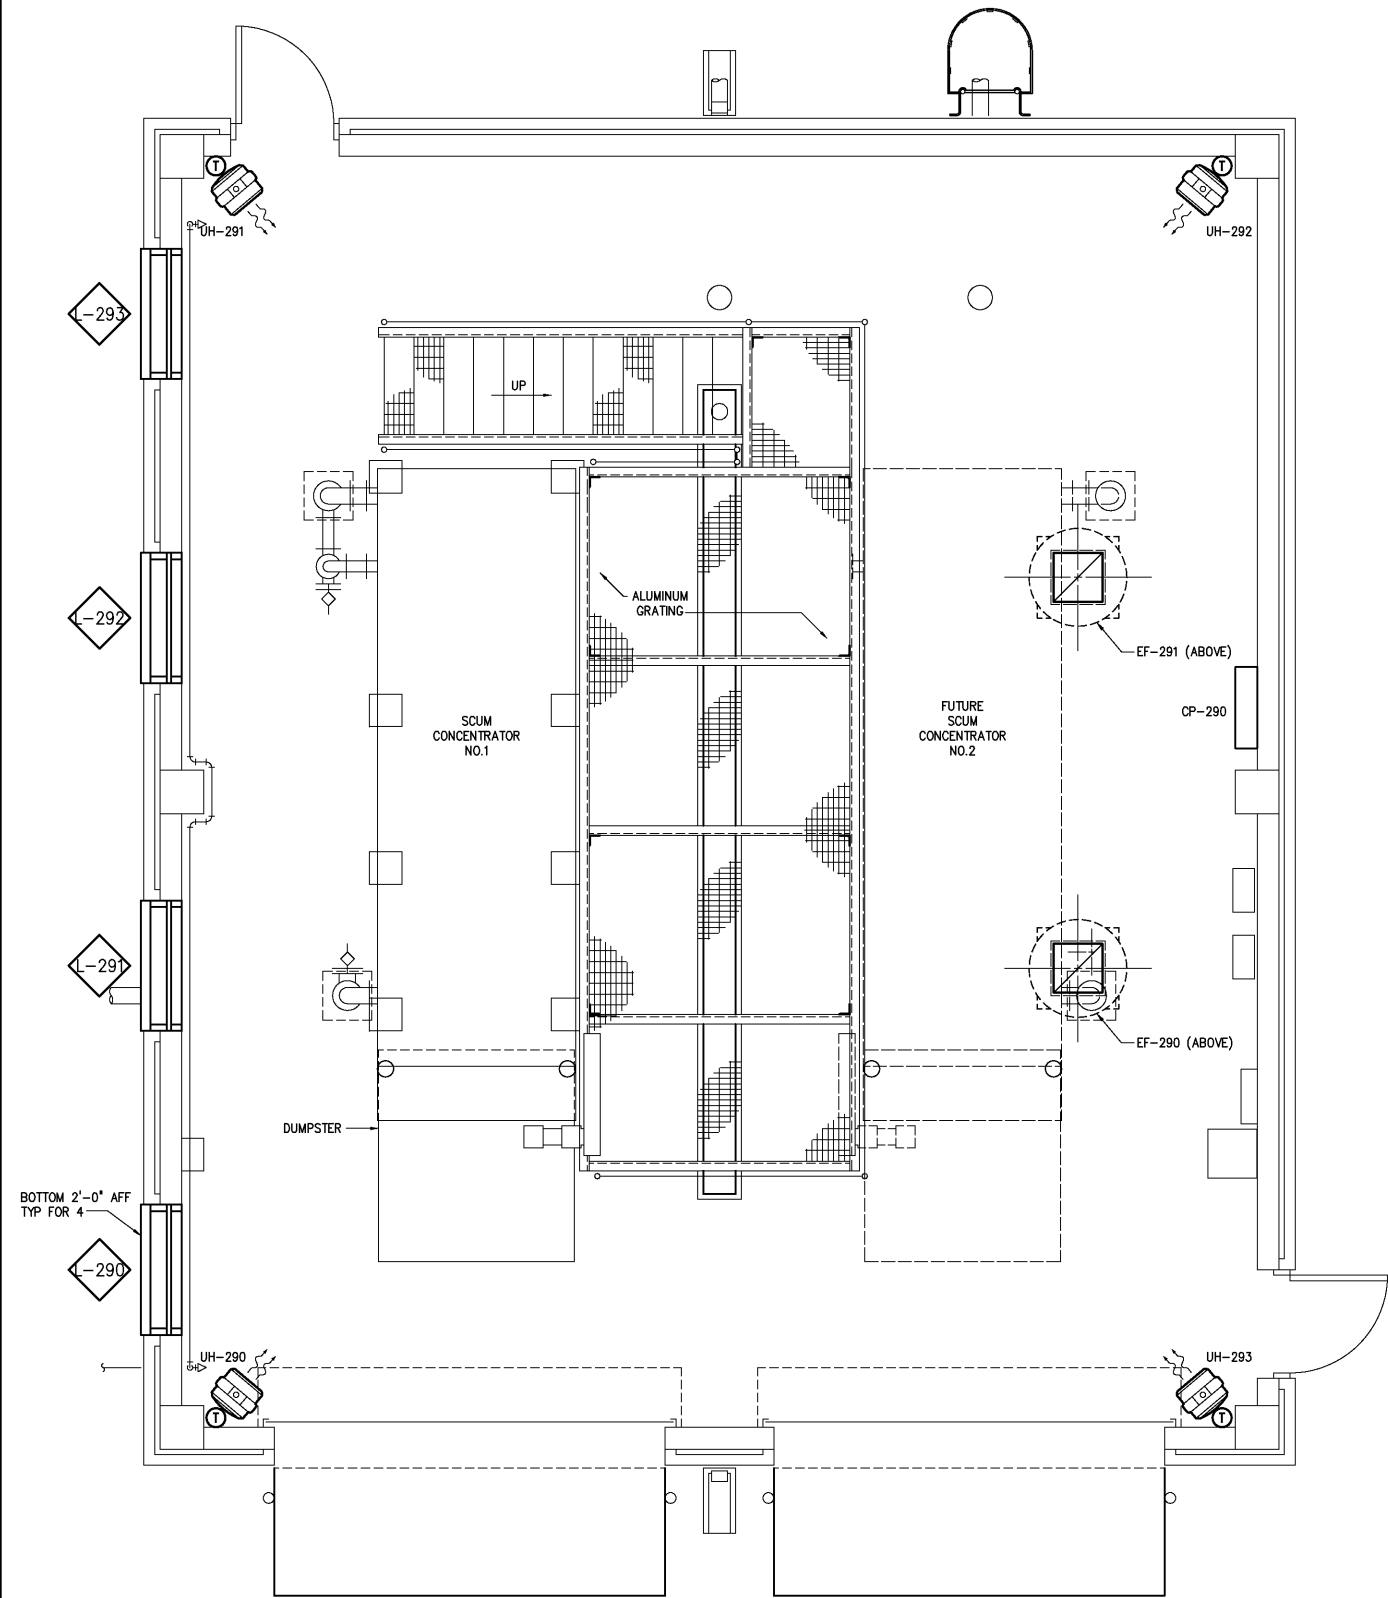

BOTTOM PLAN
3/8"=1'-0"

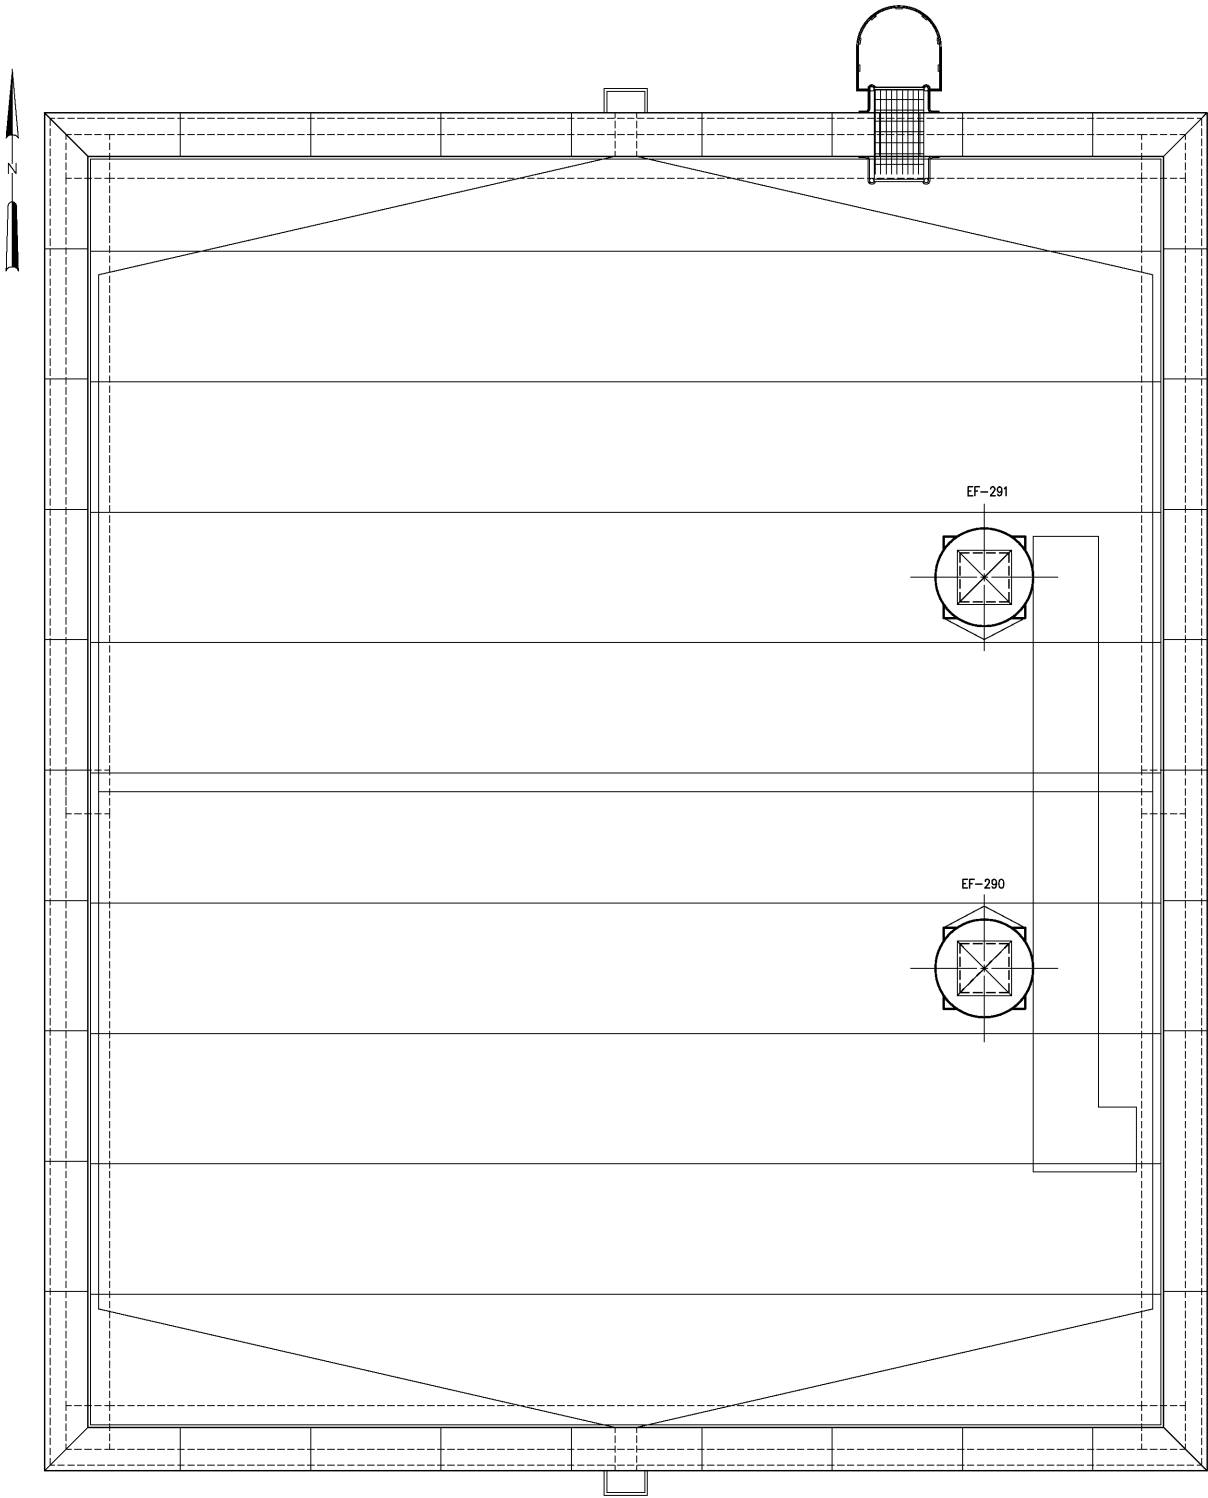

ROOF PLAN
3/8"=1'-0"

				DESIGNED	H & S
				DRAWN	H & S
				CHECKED	
		RECORD DRAWINGS	MAR 2008	RLT	
		CONSTRUCTION	MAR 2004	RLT	PROJ. ENGR. DAN
		REGULATORY APPROVAL	NOV 2003	RLT	
		PRELIMINARY DESIGN	NOV 2002	RLT	
NO.		ISSUED FOR	DATE	BY	APPROVED

THIS DOCUMENT ORIGINALLY ISSUED FOR CONSTRUCTION AND SEALED BY ROBERT S. DIFIORE, SEAL NO. 22769

RECORD DRAWING

THIS DRAWING HAS BEEN MODIFIED TO REFLECT FIELD CHANGES REPORTED BY THE CONTRACTOR OR ANOTHER PARTY, BUT NOT VERIFIED BY THE CERTIFYING ENGINEER. THIS DOCUMENT ORIGINALLY ISSUED AND SEALED BY DAVID A. NAILOR, 025465. THIS MEDIA SHALL NOT BE CONSIDERED A CERTIFIED DOCUMENT.

THIS DOCUMENT ORIGINALLY ISSUED FOR CONSTRUCTION AND SEALED BY RONALD L. TAYLOR, SEAL NO. 024649

HAZEN AND SAWYER
Environmental Engineers & Scientists
4011 WestChase Blvd, Raleigh, North Carolina 27607

CITY OF ROANOKE
VIRGINIA
REGIONAL WATER POLLUTION CONTROL PLANT
WET WEATHER IMPROVEMENTS

SCUM CONCENTRATOR BUILDING
HVAC
BOTTOM PLAN & ROOF PLAN

THE SCALE BAR SHOWN BELOW MEASURES ONE INCH LONG ON THE ORIGINAL DRAWING.	DATE	JULY 2003
	H & S JOB NUMBER	30788A
	CONTRACT NUMBER	A
	DRAWING NUMBER	H290