
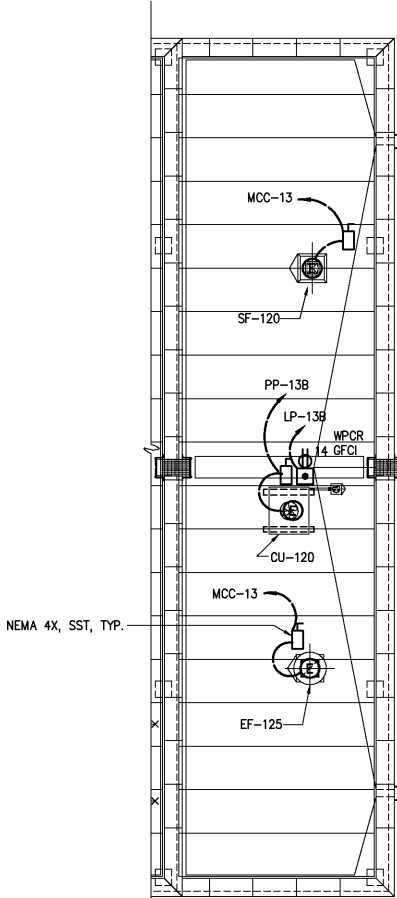


- NOTES:
- 1 THE PTF DUMPSTER EXCHANGE CONTROL STATION SHALL CONTAIN 3 NEMA 4X PUSHBUTTONS AND SHALL CONTAIN THE FOLLOWING NAMEPLATES:
-GRIT SYSTEM HALT
-SCREENS 1 & 2 HALT
-SCREENS 3 & 4 HALT

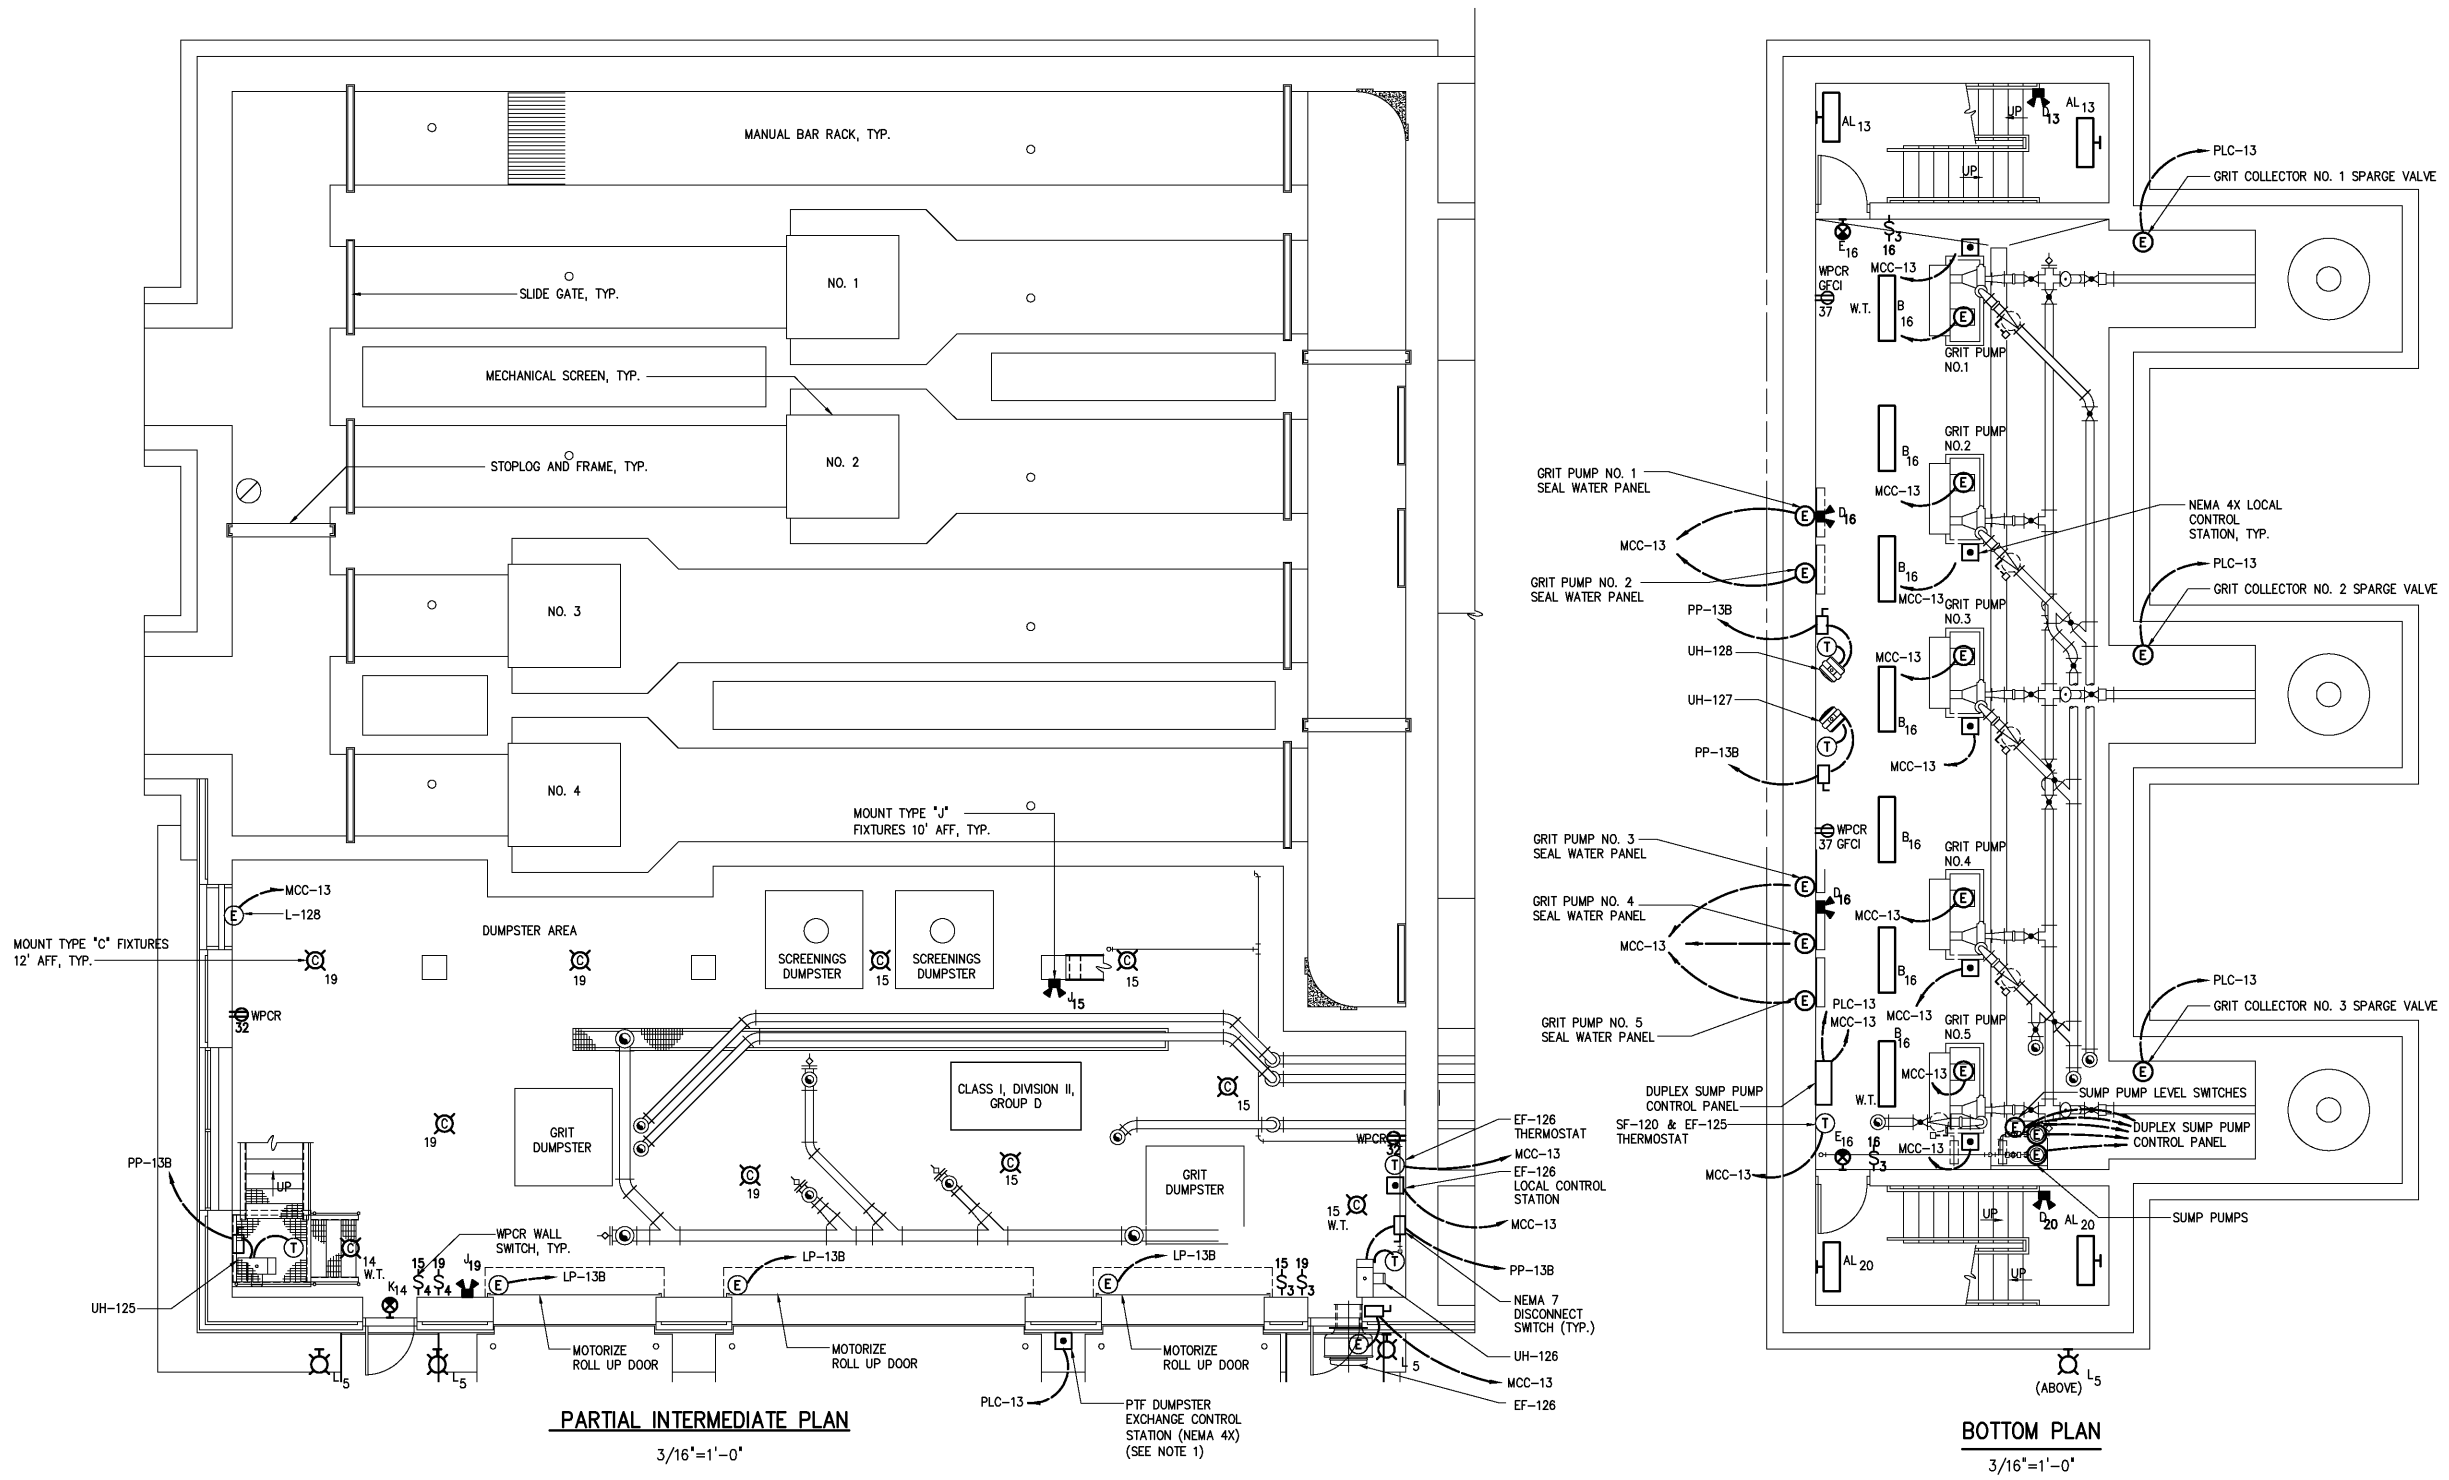

PARTIAL ROOF PLAN
1/8"=1'-0"

DESIGNED BRL DRAWN BRL CHECKED PROJ. ENGR. DAN ISSUED FOR DATE BY APPROVED				RECORD DRAWING THIS DRAWING HAS BEEN MODIFIED TO REFLECT FIELD CHANGES REPORTED BY THE CONTRACTOR OR ANOTHER PARTY, BUT NOT VERIFIED BY THE CERTIFYING ENGINEER. THIS DOCUMENT ORIGINALLY ISSUED AND SEALED BY GERALD J. RATASKY, 026535. THIS MEDIA SHALL NOT BE CONSIDERED A CERTIFIED DOCUMENT.		HAZEN AND SAWYER Environmental Engineers & Scientists 4011 WestChase Blvd, Raleigh, North Carolina 27607		CITY OF ROANOKE VIRGINIA REGIONAL WATER POLLUTION CONTROL PLANT WET WEATHER IMPROVEMENTS		PRELIMINARY TREATMENT FACILITIES ELECTRICAL PARTIAL ROOF PLAN, PARTIAL INTERMEDIATE PLAN AND BOTTOM PLAN		THE SCALE BAR SHOWN BELOW MEASURES ONE INCH LONG ON THE ORIGINAL DRAWING. DATE JULY 2003 H & S JOB NUMBER 30788A CONTRACT NUMBER A DRAWING NUMBER E121	
--	--	--	--	---	--	--	--	---	--	---	--	--	--