



NOTES:

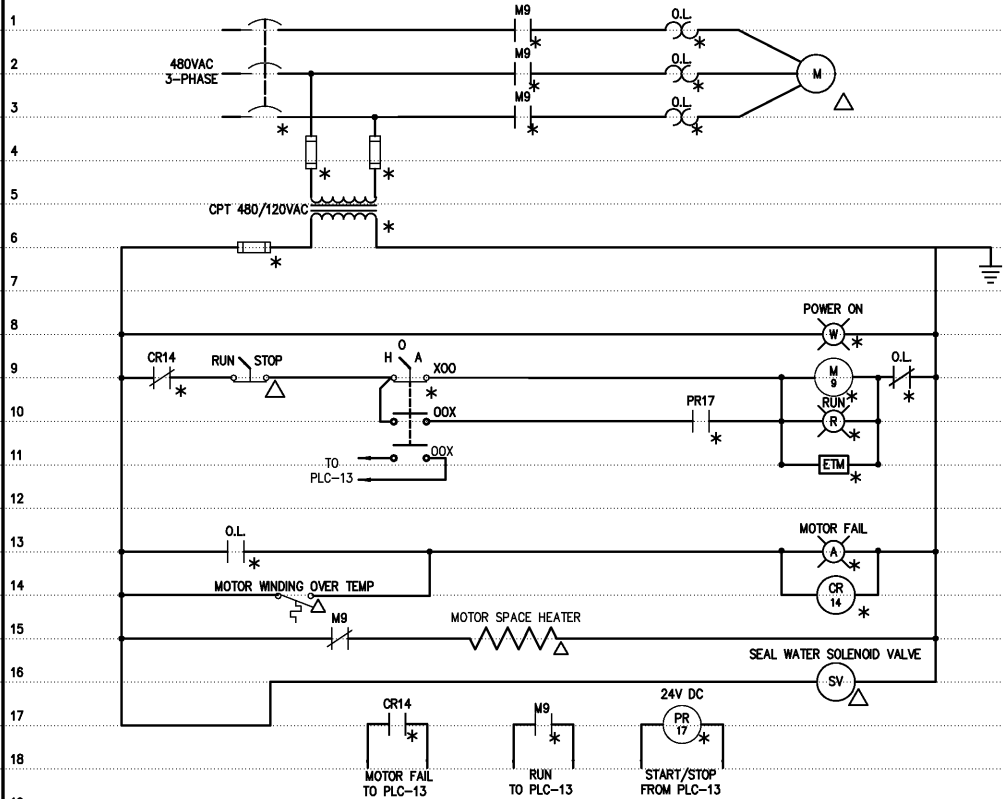


GRIT PUMPS NO.1 - NO.5

ELEMENTARY CONTROL SCHEMATIC

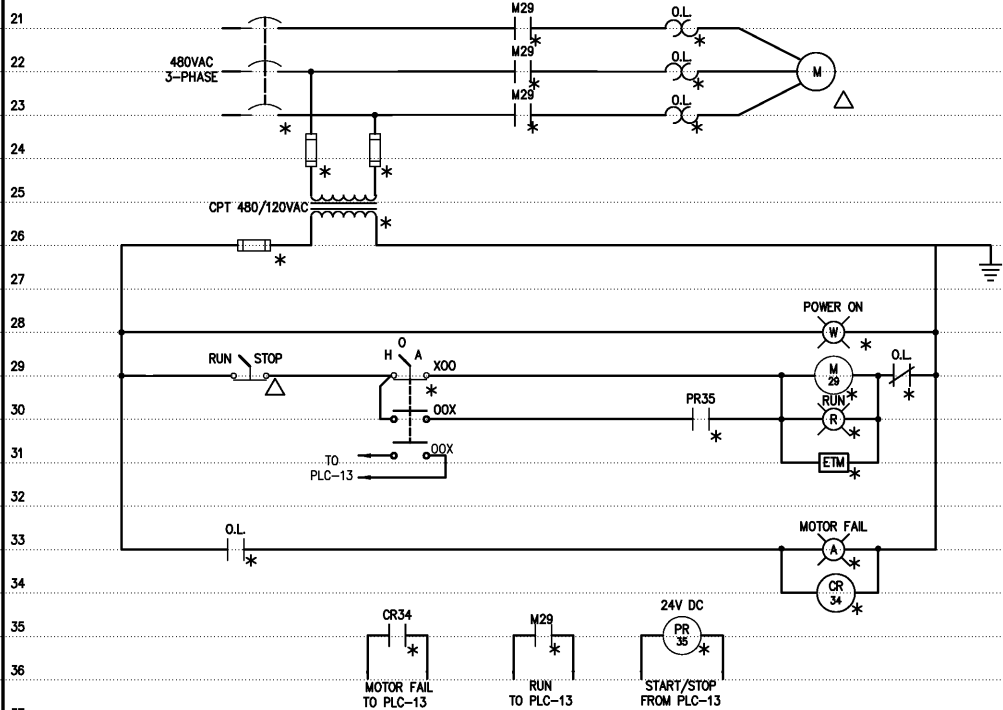


GRIT CLASSIFIERS NO.1 - NO.3

ELEMENTARY CONTROL SCHEMATIC

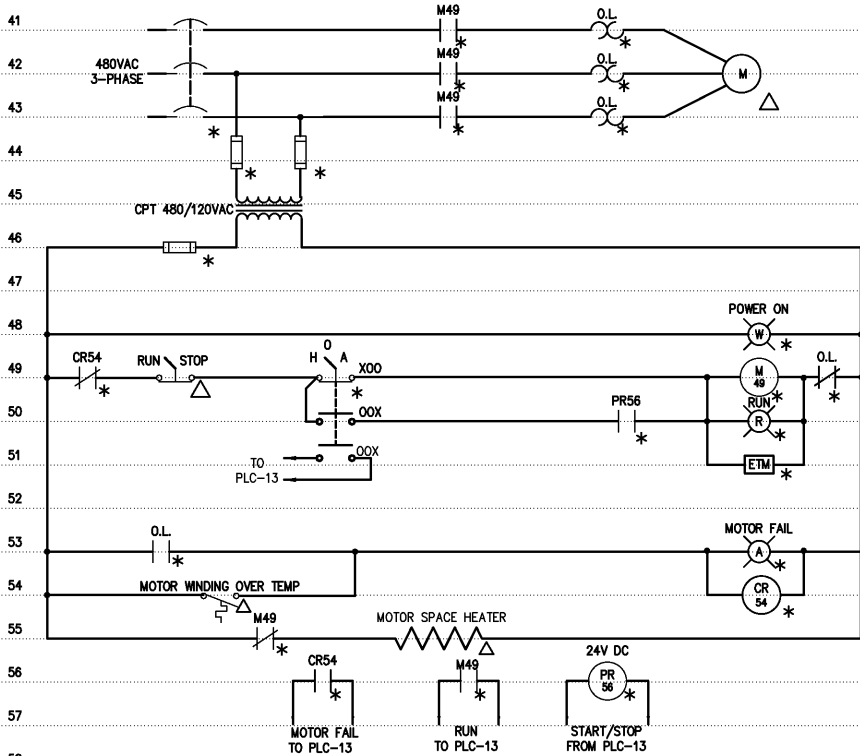


GRIT COLLECTORS NO.1 - NO.3

ELEMENTARY CONTROL SCHEMATIC

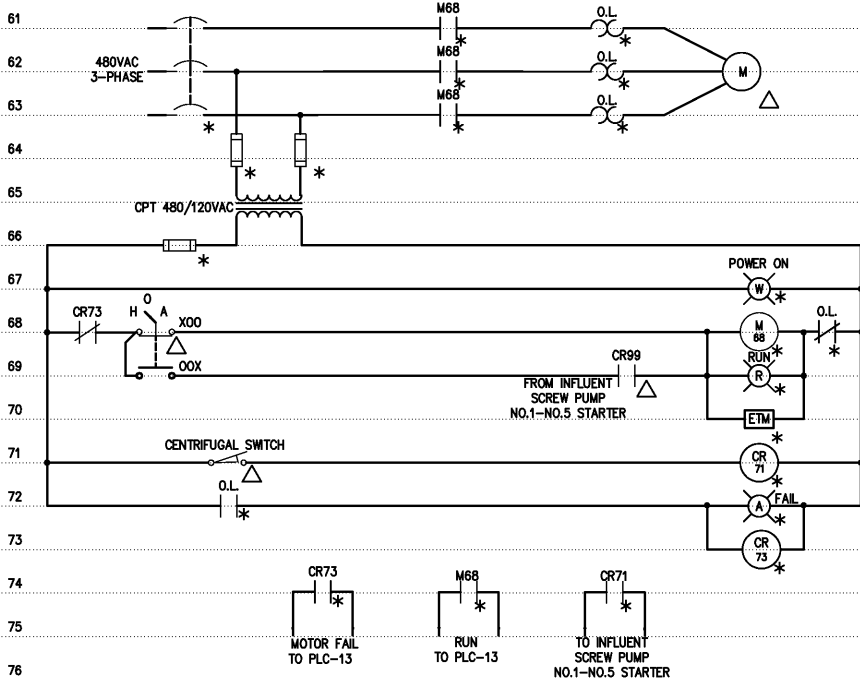

PUMP BEARING LUBRICATION SYSTEM - GREASE PUMP NO.1 - NO.5

ELEMENTARY CONTROL SCHEMATIC

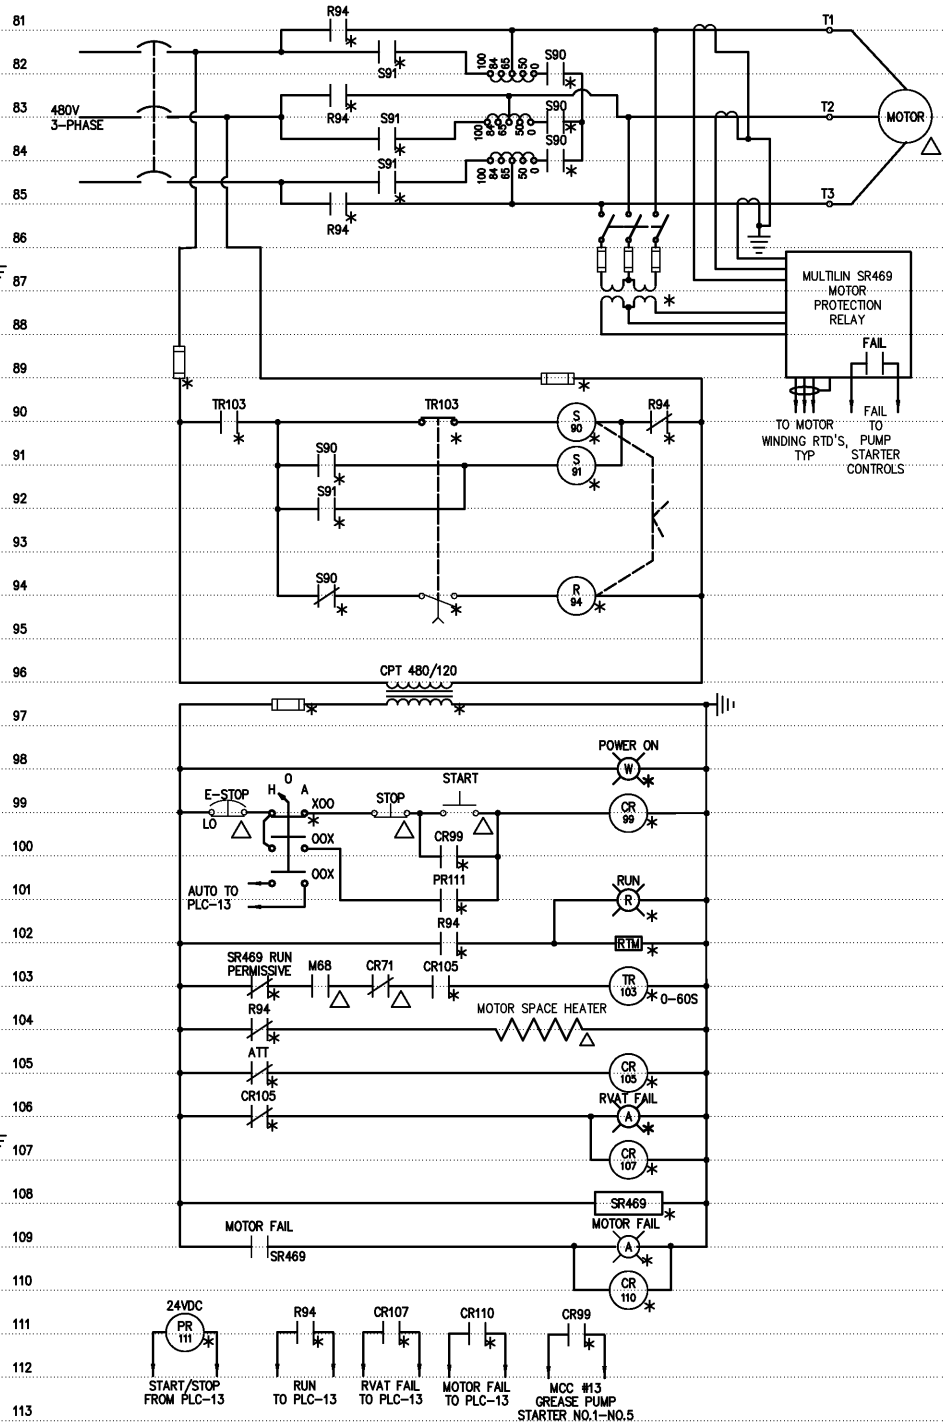

INFLUENT SCREW PUMPS NO.1 - NO.5

ELEMENTARY CONTROL SCHEMATIC

DESIGNED	BRL
DRAWN	BRL
CHECKED	
PROJ. ENGR.	DAN
APPROVED	

THIS DOCUMENT ORIGINALLY ISSUED FOR CONSTRUCTION AND SEALED BY ROBERT S. DIFIORE, SEAL NO. 22769

THIS DOCUMENT ORIGINALLY ISSUED FOR CONSTRUCTION AND SEALED BY RONALD L. TAYLOR, SEAL NO. 024649

RECORD DRAWING

THIS DRAWING HAS BEEN MODIFIED TO REFLECT FIELD CHANGES REPORTED BY THE CONTRACTOR OR ANOTHER PARTY, BUT NOT VERIFIED BY THE CERTIFYING ENGINEER. THIS DOCUMENT ORIGINALLY ISSUED AND SEALED BY GERALD J. RATASKY, 026535. THIS MEDIA SHALL NOT BE CONSIDERED A CERTIFIED DOCUMENT.

HAZEN AND SAWYER
Environmental Engineers & Scientists
4011 WestChase Blvd, Raleigh, North Carolina 27607

CITY OF ROANOKE
VIRGINIA

REGIONAL WATER POLLUTION CONTROL PLANT
WET WEATHER IMPROVEMENTS

PRELIMINARY TREATMENT FACILITIES
ELECTRICAL
ELEMENTARY CONTROL SCHEMATICS

THE SCALE BAR SHOWN BELOW MEASURES ONE INCH LONG ON THE ORIGINAL DRAWING.	DATE	JULY 2003
	H & S JOB NUMBER	30788A
	CONTRACT NUMBER	A
	DRAWING NUMBER	E129