


NOTES:

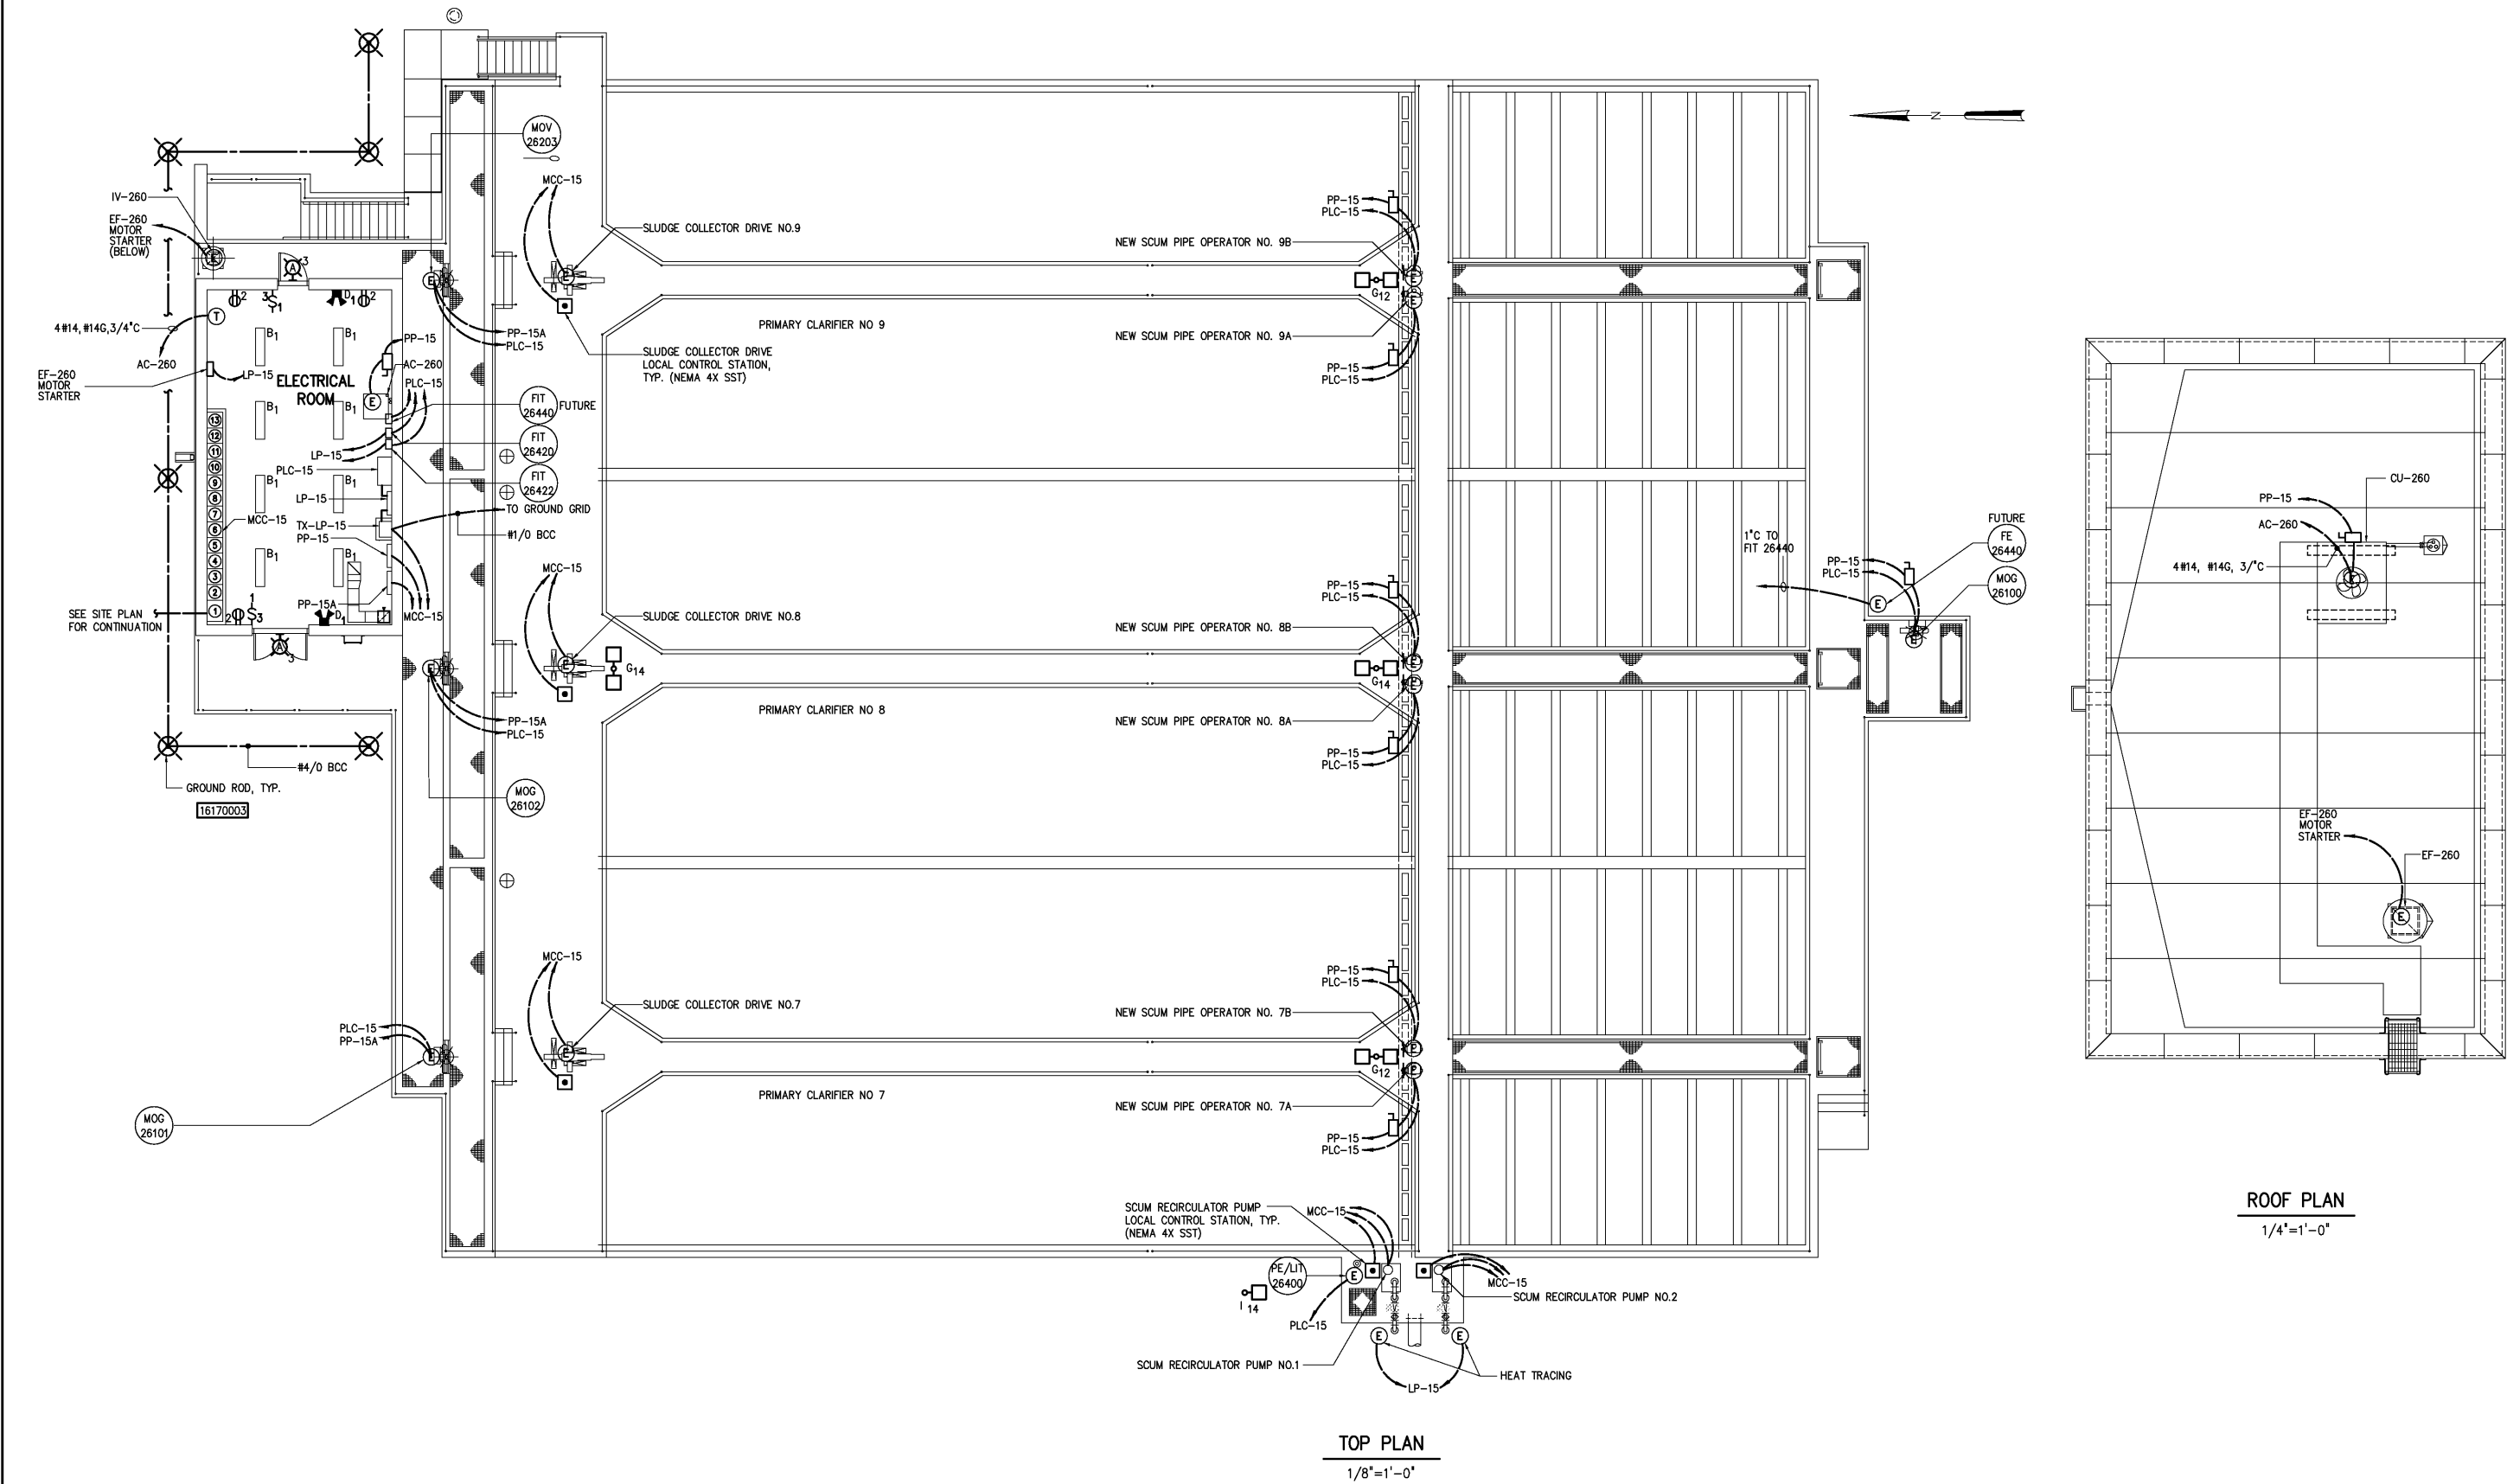

ROOF PLAN
1/4"=1'-0"

TOP PLAN
1/8"=1'-0"

				DESIGNED	BRL	THIS DOCUMENT ORIGINALLY ISSUED FOR CONSTRUCTION AND SEALED BY ROBERT S. DIFIORE, SEAL NO. 22769	RECORD DRAWING	<div>Hazen and Sawyer</div> <div>Environmental Engineers & Scientists</div> <div>4011 WestChase Blvd, Raleigh, North Carolina 27607</div>	CITY OF ROANOKE VIRGINIA	PRIMARY CLARIFIER NOS 7-9	THE SCALE BAR SHOWN BELOW MEASURES ONE INCH LONG ON THE ORIGINAL DRAWING.	DATE	JUL
				DRAWN	BRL							H & S JOB NUMBER	
				CHECKED							CONTRACT NUMBER		
	RECORD DRAWINGS CONSTRUCTION	MAR 2008	RLT	PROJ. ENGR.	DAN								
	REGULATORY APPROVAL	MAR 2004	RLT										
	PRELIMINARY DESIGN	NOV 2003	RLT			THIS DOCUMENT ORIGINALLY ISSUED FOR CONSTRUCTION AND SEALED BY RONALD L. TAYLOR, SEAL NO. 024649			REGIONAL WATER POLLUTION CONTROL PLANT WET WEATHER IMPROVEMENTS	ELECTRICAL TOP PLAN		A	
NO.	ISSUED FOR	NOV 2002	RLT	APPROVED									
		DATE	BY										