



NOTES:

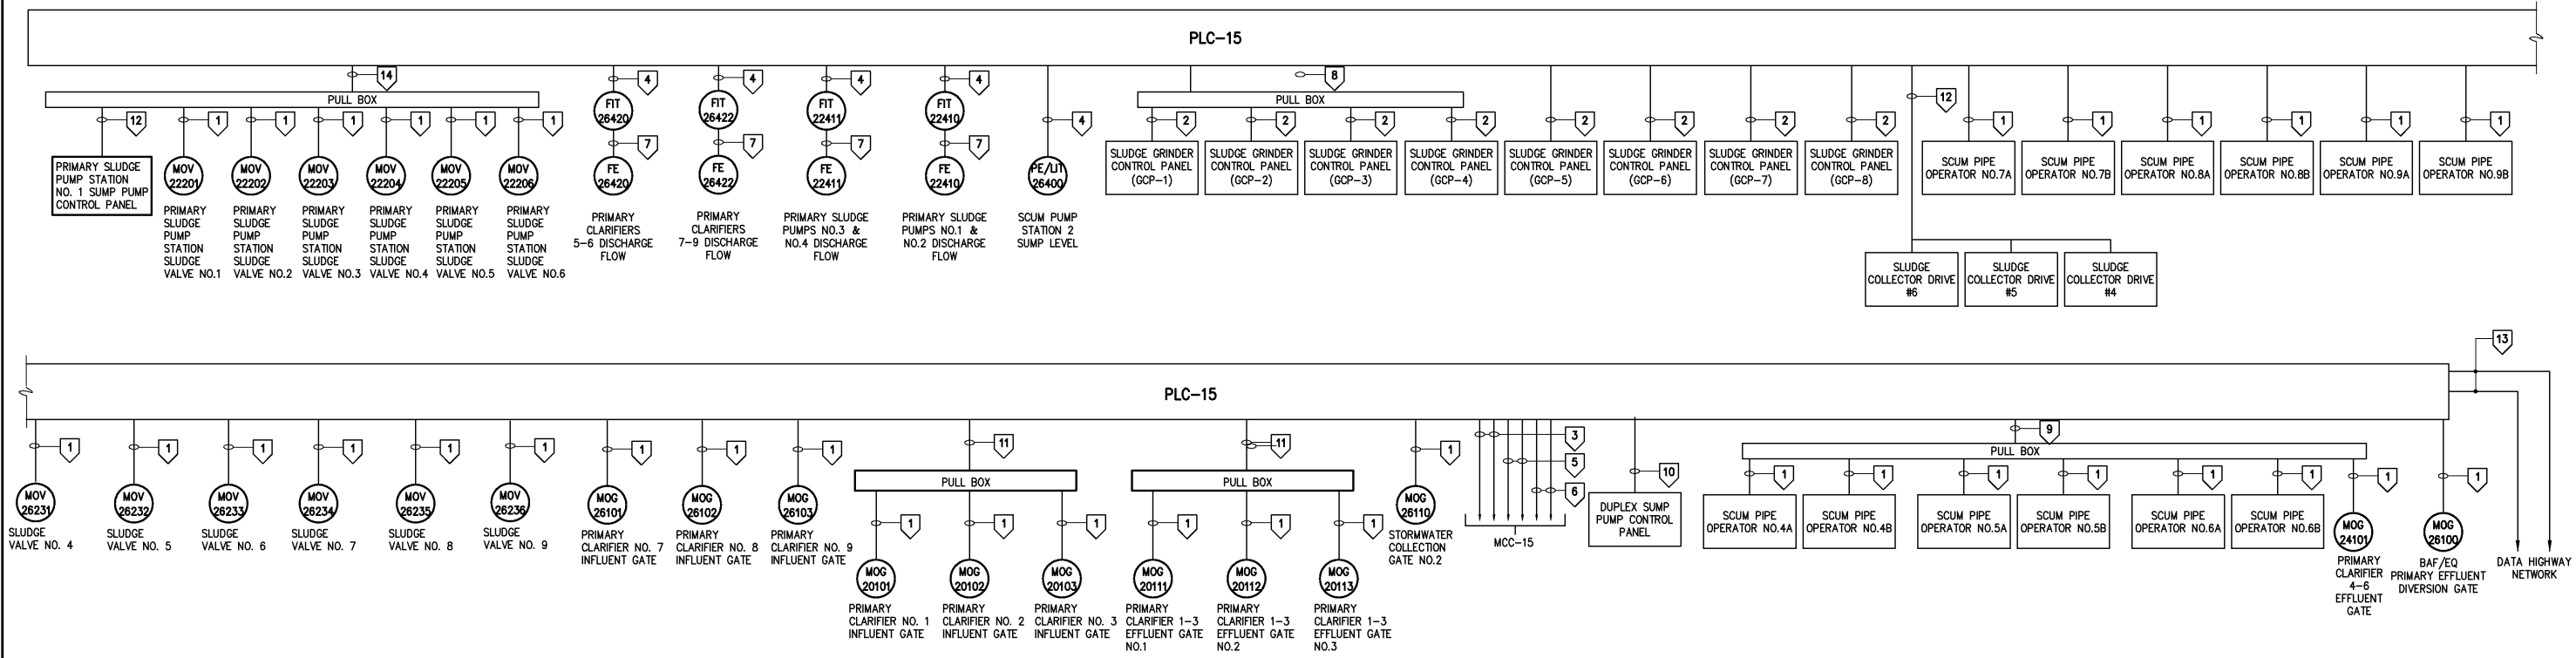

PLC-15 CONTROL ONE LINE DIAGRAM

CONDUIT AND WIRE LEGEND	
(NUMBERS REFERENCE THIS SHEET ONLY)	
NO.	DESCRIPTION
1	12 #14, #14G, 1" C
2	10 #14, #14G, 1" C
3	76 #14, #14G, 3" C
4	2-TPS, 1" C
5	10-TPS, 2" C
6	2"-SP.C.
7	CABLE BY SUPPLIER, 3/4" C
8	40 #14, #14G, 2" C
9	90 #14, #14G, 3" C
10	4 #14, #14G, 3/4" C
11	36 #14, #14G, 2" C
12	6 #14, #14G, 3/4" C
13	CABLE BY INSTRUMENTATION SUBCONTRACTOR
14	76 #14, #14G, 3" C

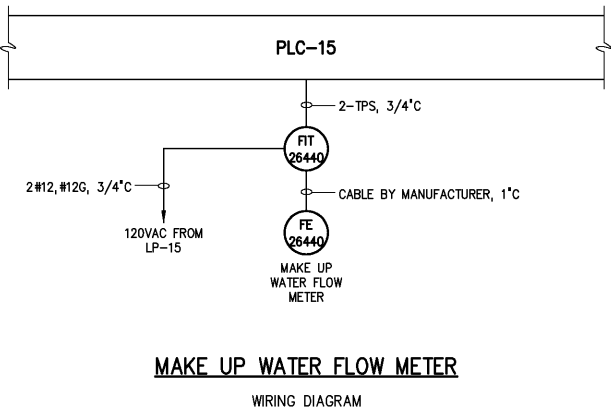

MAKE UP WATER FLOW METER  
WIRING DIAGRAM

DESIGNED BRL DRAWN BRL CHECKED PROJ. ENGR. DAN APPROVED				RECORD DRAWING THIS DRAWING HAS BEEN MODIFIED TO REFLECT FIELD CHANGES REPORTED BY THE CONTRACTOR OR ANOTHER PARTY, BUT NOT VERIFIED BY THE CERTIFYING ENGINEER. THIS DOCUMENT ORIGINALLY ISSUED AND SEALED BY GERALD J. RATASKY, 026535. THIS MEDIA SHALL NOT BE CONSIDERED A CERTIFIED DOCUMENT.		HAZEN AND SAWYER Environmental Engineers & Scientists 4011 WestChase Blvd, Raleigh, North Carolina 27607		CITY OF ROANOKE VIRGINIA REGIONAL WATER POLLUTION CONTROL PLANT WET WEATHER IMPROVEMENTS		PRIMARY CLARIFIER NOS 7-9 MODIFICATIONS ELECTRICAL CONTROL ONE LINE DIAGRAM		THE SCALE BAR SHOWN BELOW MEASURES ONE INCH LONG ON THE ORIGINAL DRAWING. DATE JULY 2003 H & S JOB NUMBER 30788A CONTRACT NUMBER A DRAWING NUMBER E264	
---	--	--	--	---	--	--	--	---	--	---	--	--	--