



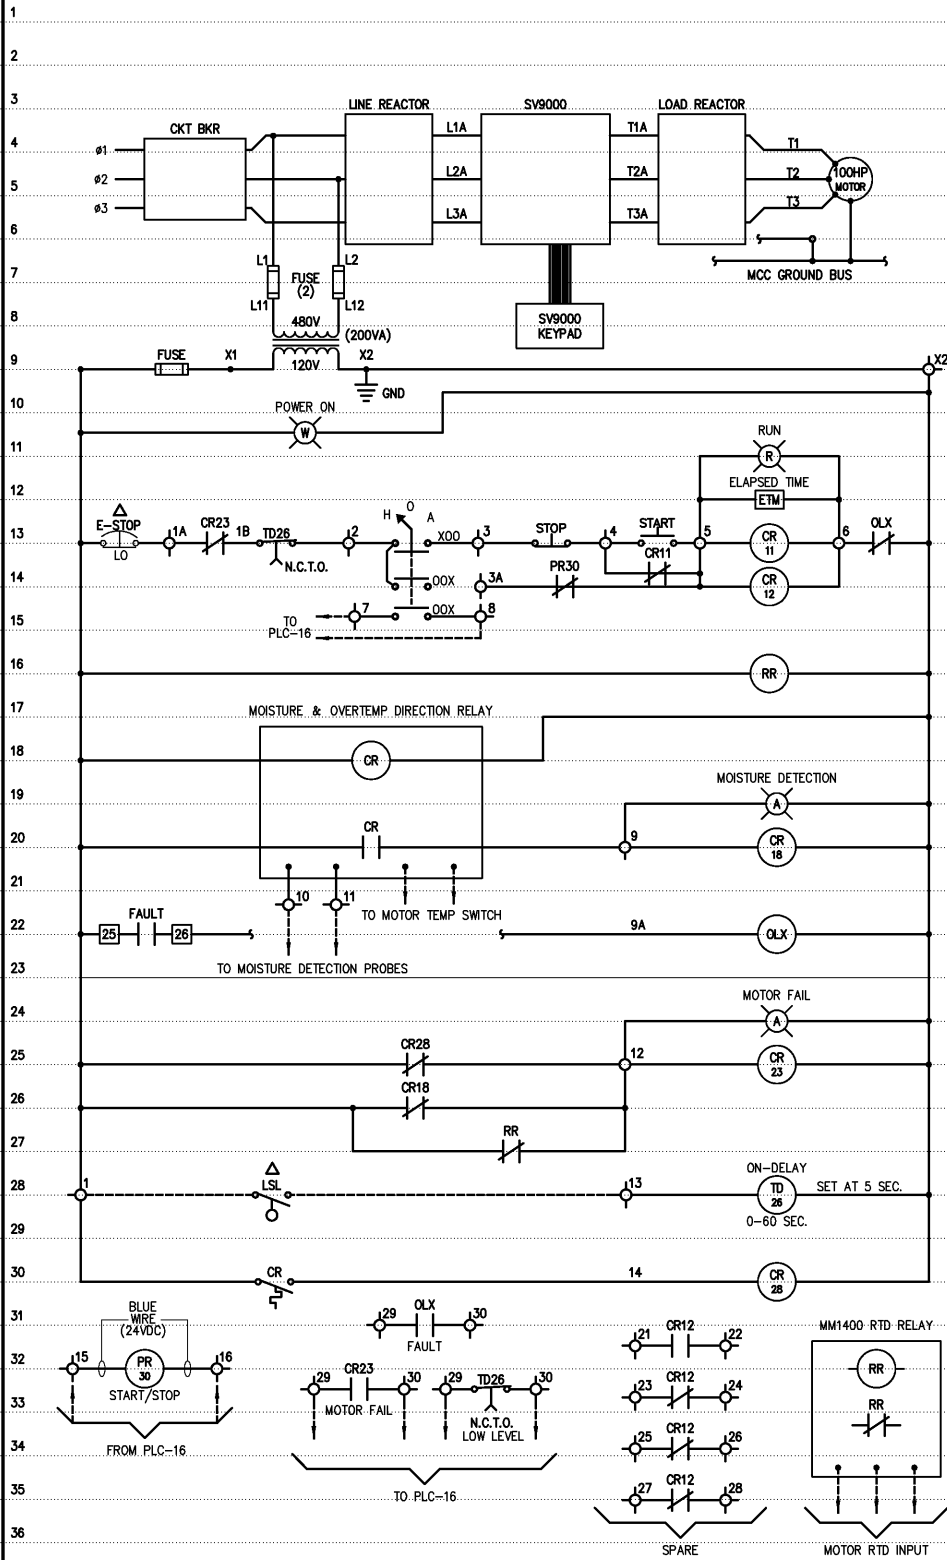

FILTER BACKWASH RECLAIM PUMPS NO.1 & NO.2

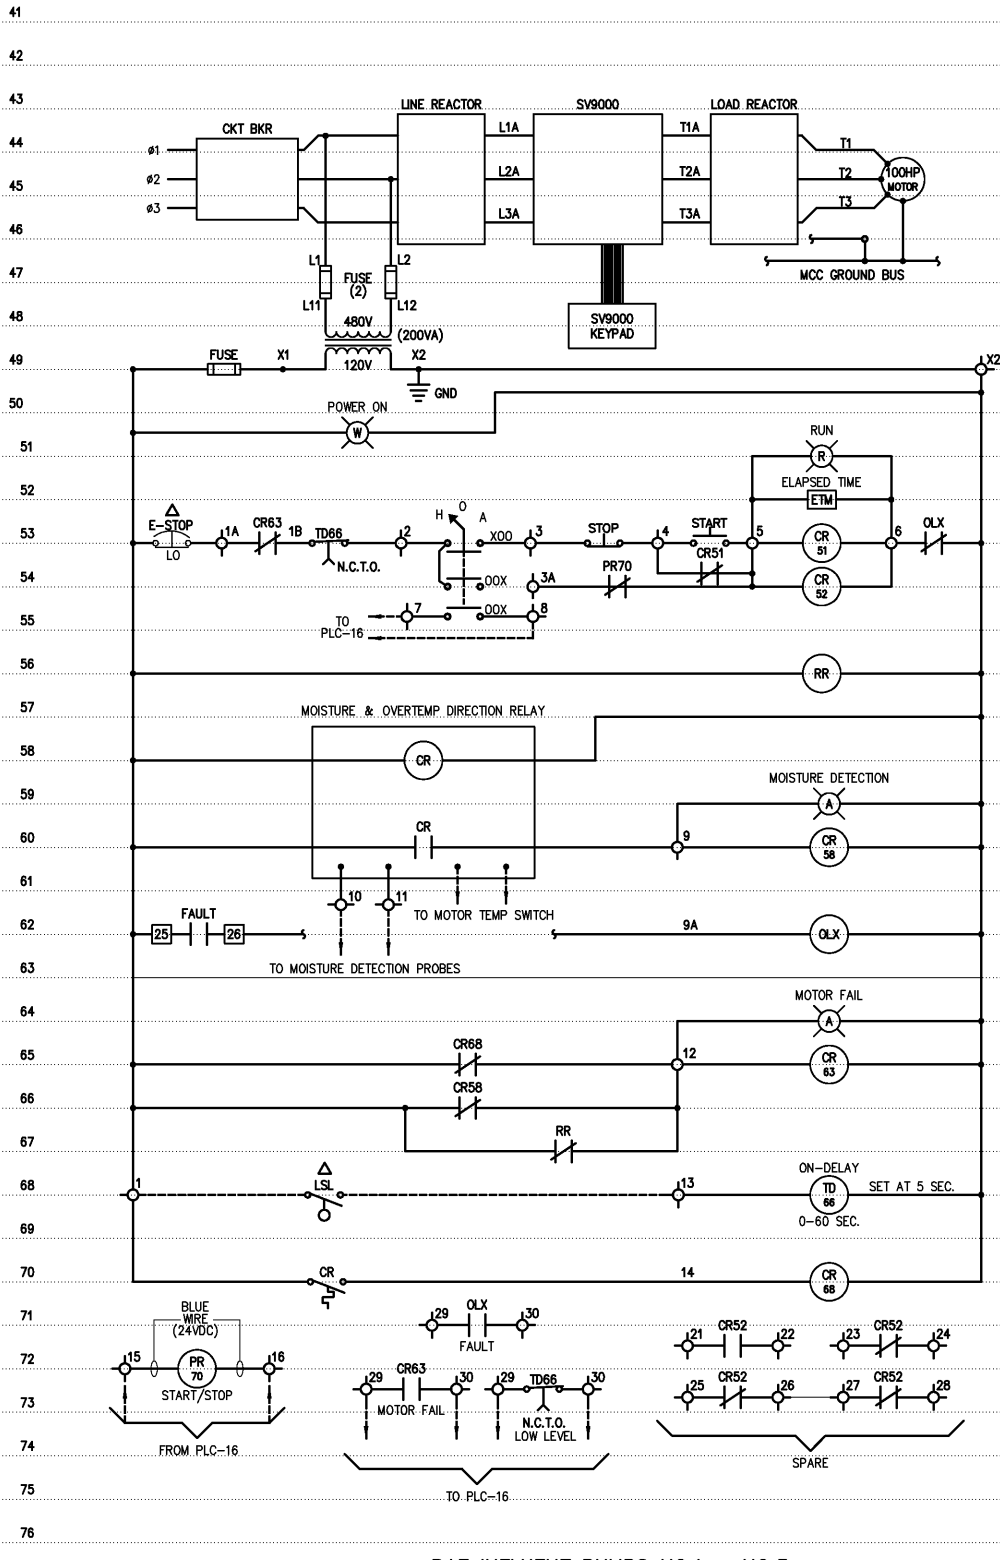

BAF INFLUENT PUMPS NO.1 - NO.3

DESIGNED	BRL
DRAWN	BRL
CHECKED	
PROJ. ENGR.	DAN
APPROVED	
NO.	

RECORD DRAWINGS	MAR 2008	RLT
CONSTRUCTION	MAR 2004	RLT
REGULATORY APPROVAL	NOV 2003	RLT
PRELIMINARY DESIGN	NOV 2002	RLT
ISSUED FOR	DATE	BY

THIS DOCUMENT ORIGINALLY ISSUED FOR CONSTRUCTION AND SEALED BY ROBERT S. DIFIORE, SEAL NO. 22769

RECORD DRAWING

THIS DRAWING HAS BEEN MODIFIED TO REFLECT FIELD CHANGES REPORTED BY THE CONTRACTOR OR ANOTHER PARTY, BUT NOT VERIFIED BY THE CERTIFYING ENGINEER. THIS DOCUMENT ORIGINALLY ISSUED AND SEALED BY GERALD J. RATASKY, 026535. THIS MEDIA SHALL NOT BE CONSIDERED A CERTIFIED DOCUMENT.

THIS DOCUMENT ORIGINALLY ISSUED FOR CONSTRUCTION AND SEALED BY RONALD L. TAYLOR, SEAL NO. 024649

HAZEN AND SAWYER
Environmental Engineers & Scientists
4011 WestChase Blvd, Raleigh, North Carolina 27607

CITY OF ROANOKE
VIRGINIA
REGIONAL WATER POLLUTION CONTROL PLANT
WET WEATHER IMPROVEMENTS

BAF/EQ PUMP STATION
ELECTRICAL
ELEMENTARY CONTROL SCHEMATICS

THE SCALE BAR SHOWN BELOW MEASURES ONE INCH LONG ON THE ORIGINAL DRAWING.	DATE JULY 2003
H & S JOB NUMBER	30788A
CONTRACT NUMBER	A
DRAWING NUMBER	E304