


NOTES:

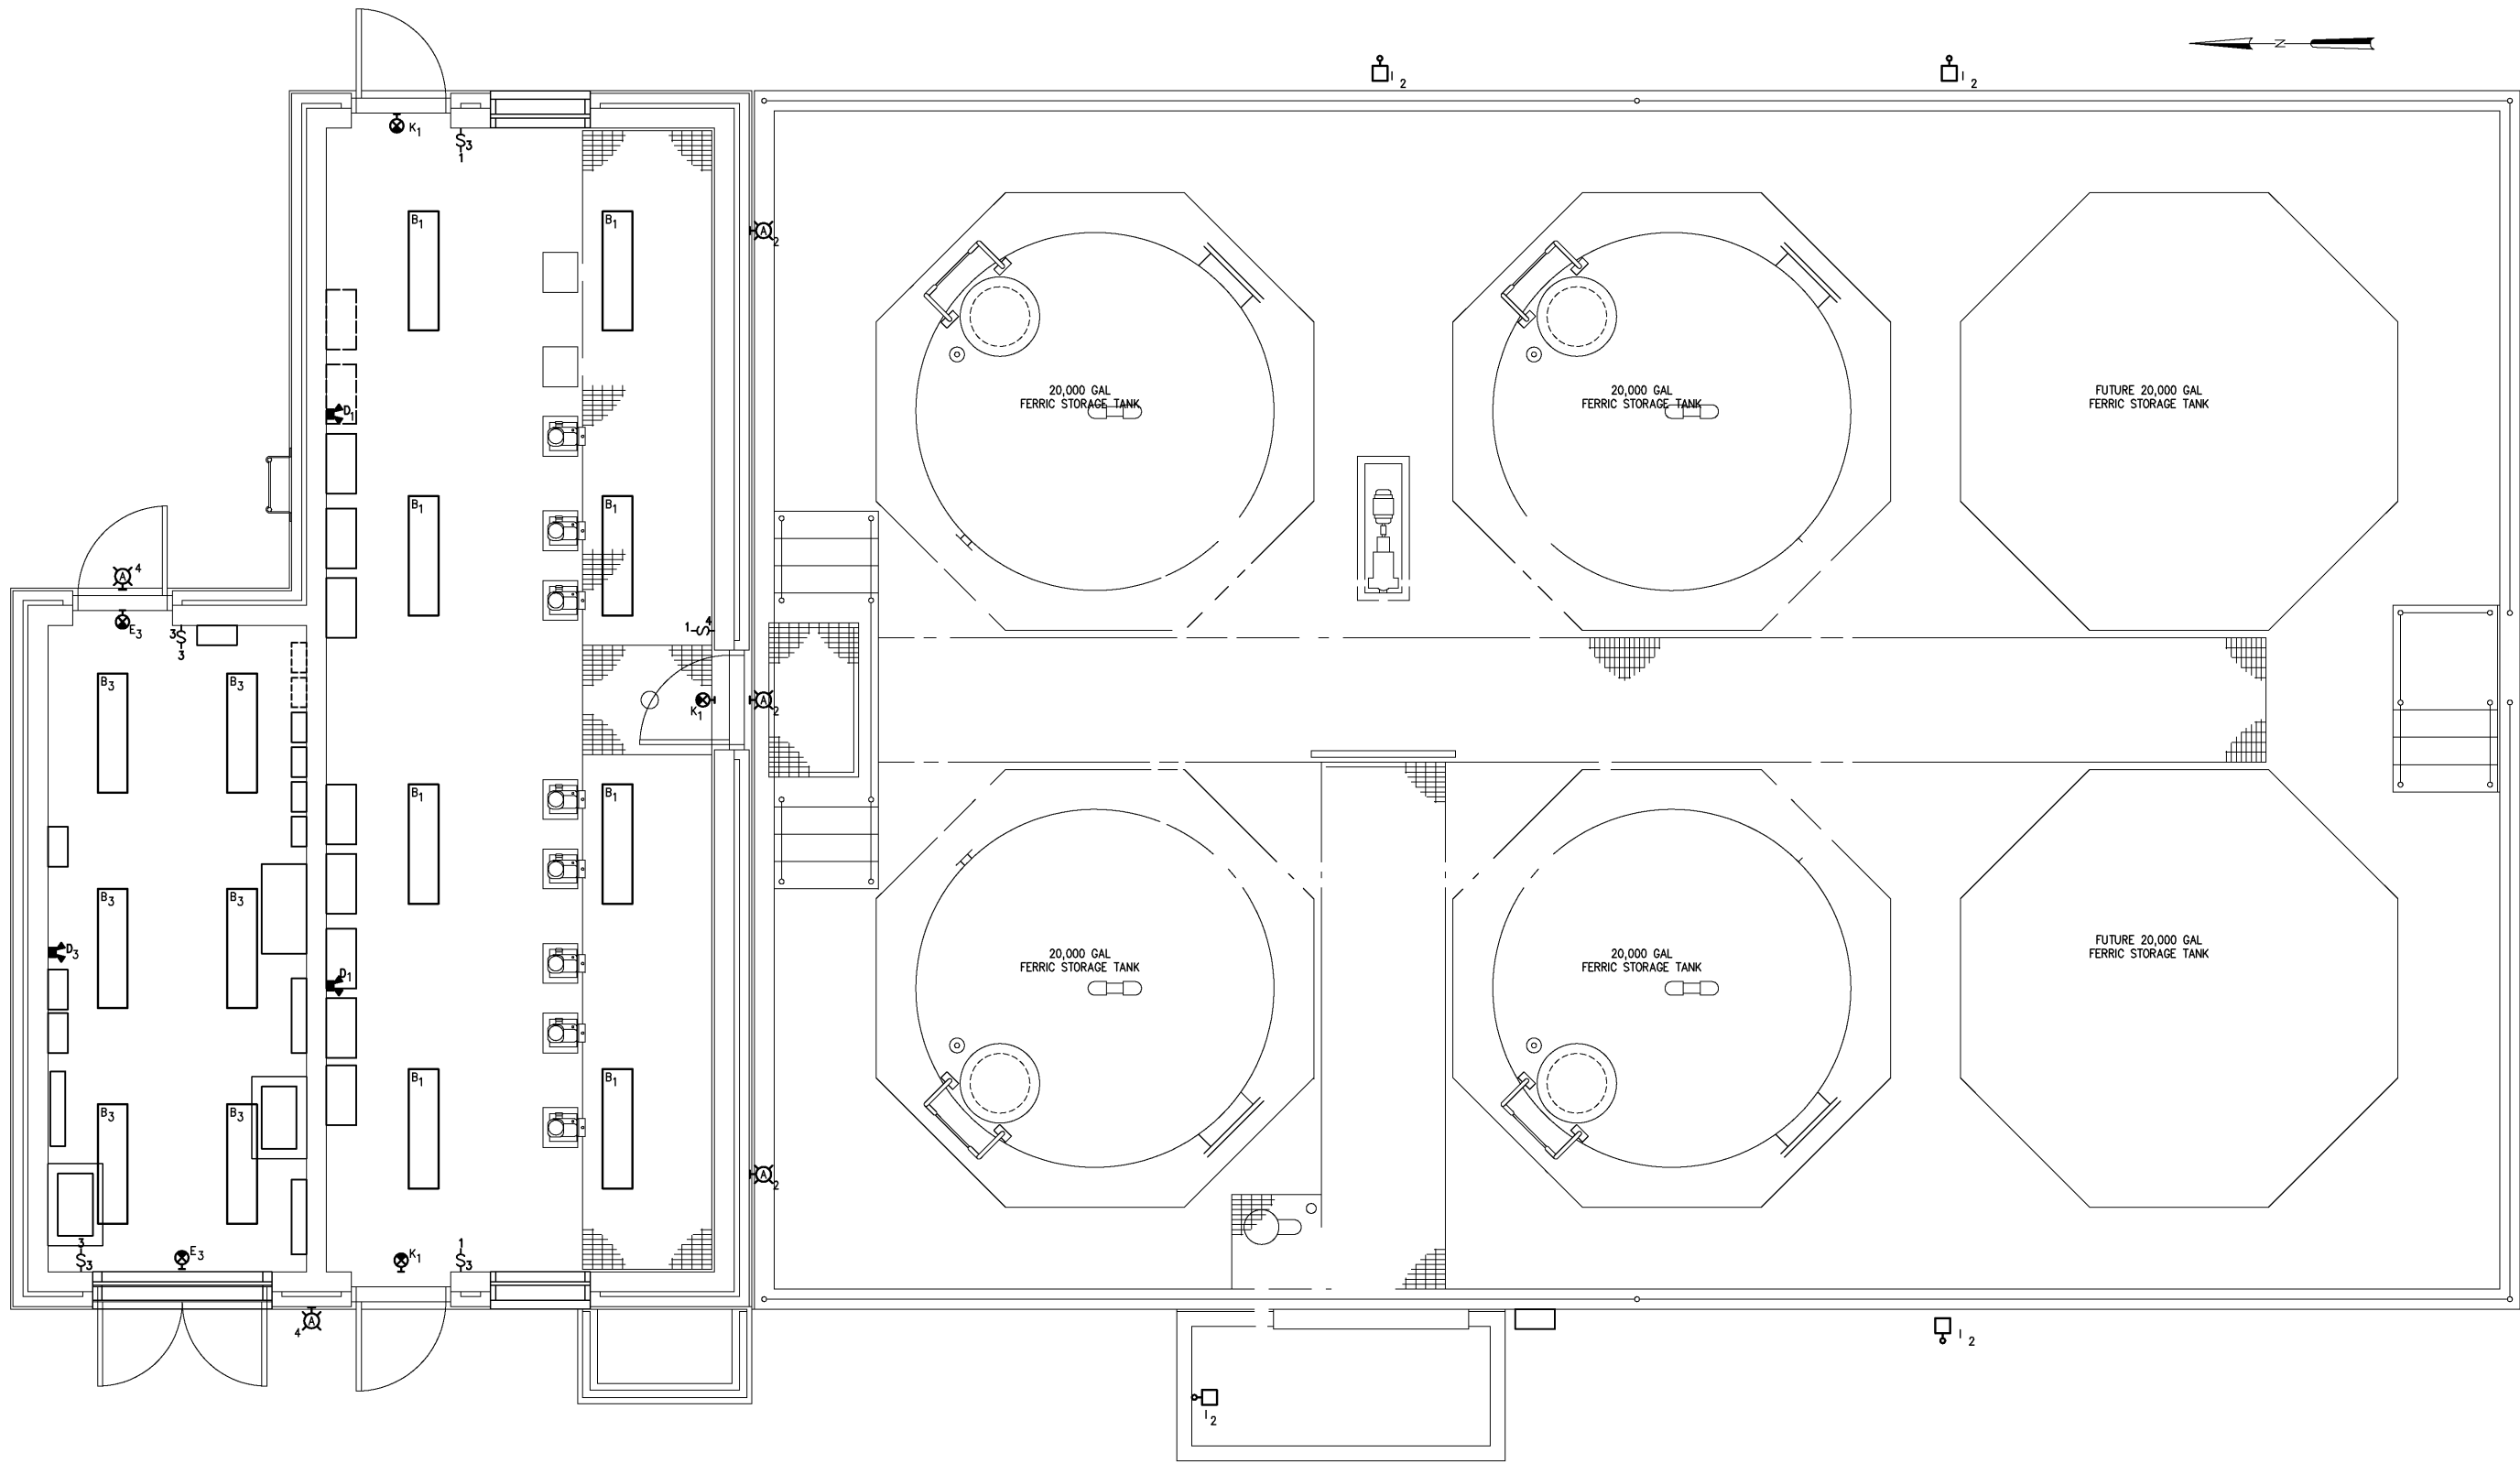

BOTTOM PLAN
3/8"=1'-0"

				DESIGNED	BRL
				DRAWN	BRL
				CHECKED	
	RECORD DRAWINGS	MAR 2008	RLT	PROJ. ENGR.	H & S
	CONSTRUCTION	MAR 2004	RLT		
	REGULATORY APPROVAL	NOV 2003	RLT		
	PRELIMINARY DESIGN	NOV 2002	RLT		
NO.	ISSUED FOR	DATE	BY	APPROVED	

THIS DOCUMENT ORIGINALLY ISSUED
FOR CONSTRUCTION AND SEALED BY
ROBERT S. DIFIORE, SEAL NO. 22769

RECORD DRAWING

THIS DRAWING HAS BEEN MODIFIED TO REFLECT FIELD
CHANGES REPORTED BY THE CONTRACTOR OR ANOTHER
PARTY, BUT NOT VERIFIED BY THE CERTIFYING ENGINEER.
THIS DOCUMENT ORIGINALLY ISSUED AND SEALED BY
GERALD J. RATASKY, 026535. THIS MEDIA SHALL NOT
BE CONSIDERED A CERTIFIED DOCUMENT.

THIS DOCUMENT ORIGINALLY ISSUED
FOR CONSTRUCTION AND SEALED BY
RONALD L. TAYLOR, SEAL NO. 024649

HAZEN AND SAWYER
Environmental Engineers & Scientists
4011 WestChase Blvd, Raleigh, North Carolina 27607

CITY OF ROANOKE
VIRGINIA

REGIONAL WATER POLLUTION CONTROL PLANT
WET WEATHER IMPROVEMENTS

COAGULATION CHEMICAL FEED FACILITIES
ELECTRICAL
LIGHTING PLAN

THE SCALE BAR
SHOWN BELOW
MEASURES ONE
INCH LONG ON
THE ORIGINAL
DRAWING.

DATE	JULY 2003
H & S JOB NUMBER	30788A
CONTRACT NUMBER	A
DRAWING NUMBER	E581