



NOTES:

- 1 ALL TYPE "F" LIGHTING FIXTURES SHALL BE MOUNTED 12 FEET ABOVE FINISHED FLOOR.
- 2 REFERENCE OF SPECIFICATION SECTION 16111 REGARDING INSTALLATION OF CONDUIT SEALS.
- 3 ALL TYPE "B" LIGHTING FIXTURES SHALL BE MOUNTED 12 FEET ABOVE FINISHED FLOOR.
- 4 ALL METAL FASTENERS, BRACKETS, MOUNTING HARDWARE AND ACCESSORIES IN SODIUM HYPOCHLORITE AREA SHALL BE CONSTRUCTED OF HASTELLOY C. ALL METAL FASTENERS, BRACKETS, MOUNTING HARDWARE AND ACCESSORIES IN SODIUM BISULFITE AREA SHALL BE CONSTRUCTED OF 316 SST.
- 5 ALL RECEPTACLES AT THE DISINFECTION FEED FACILITY SHALL BE WPCR, GFCI TYPE.

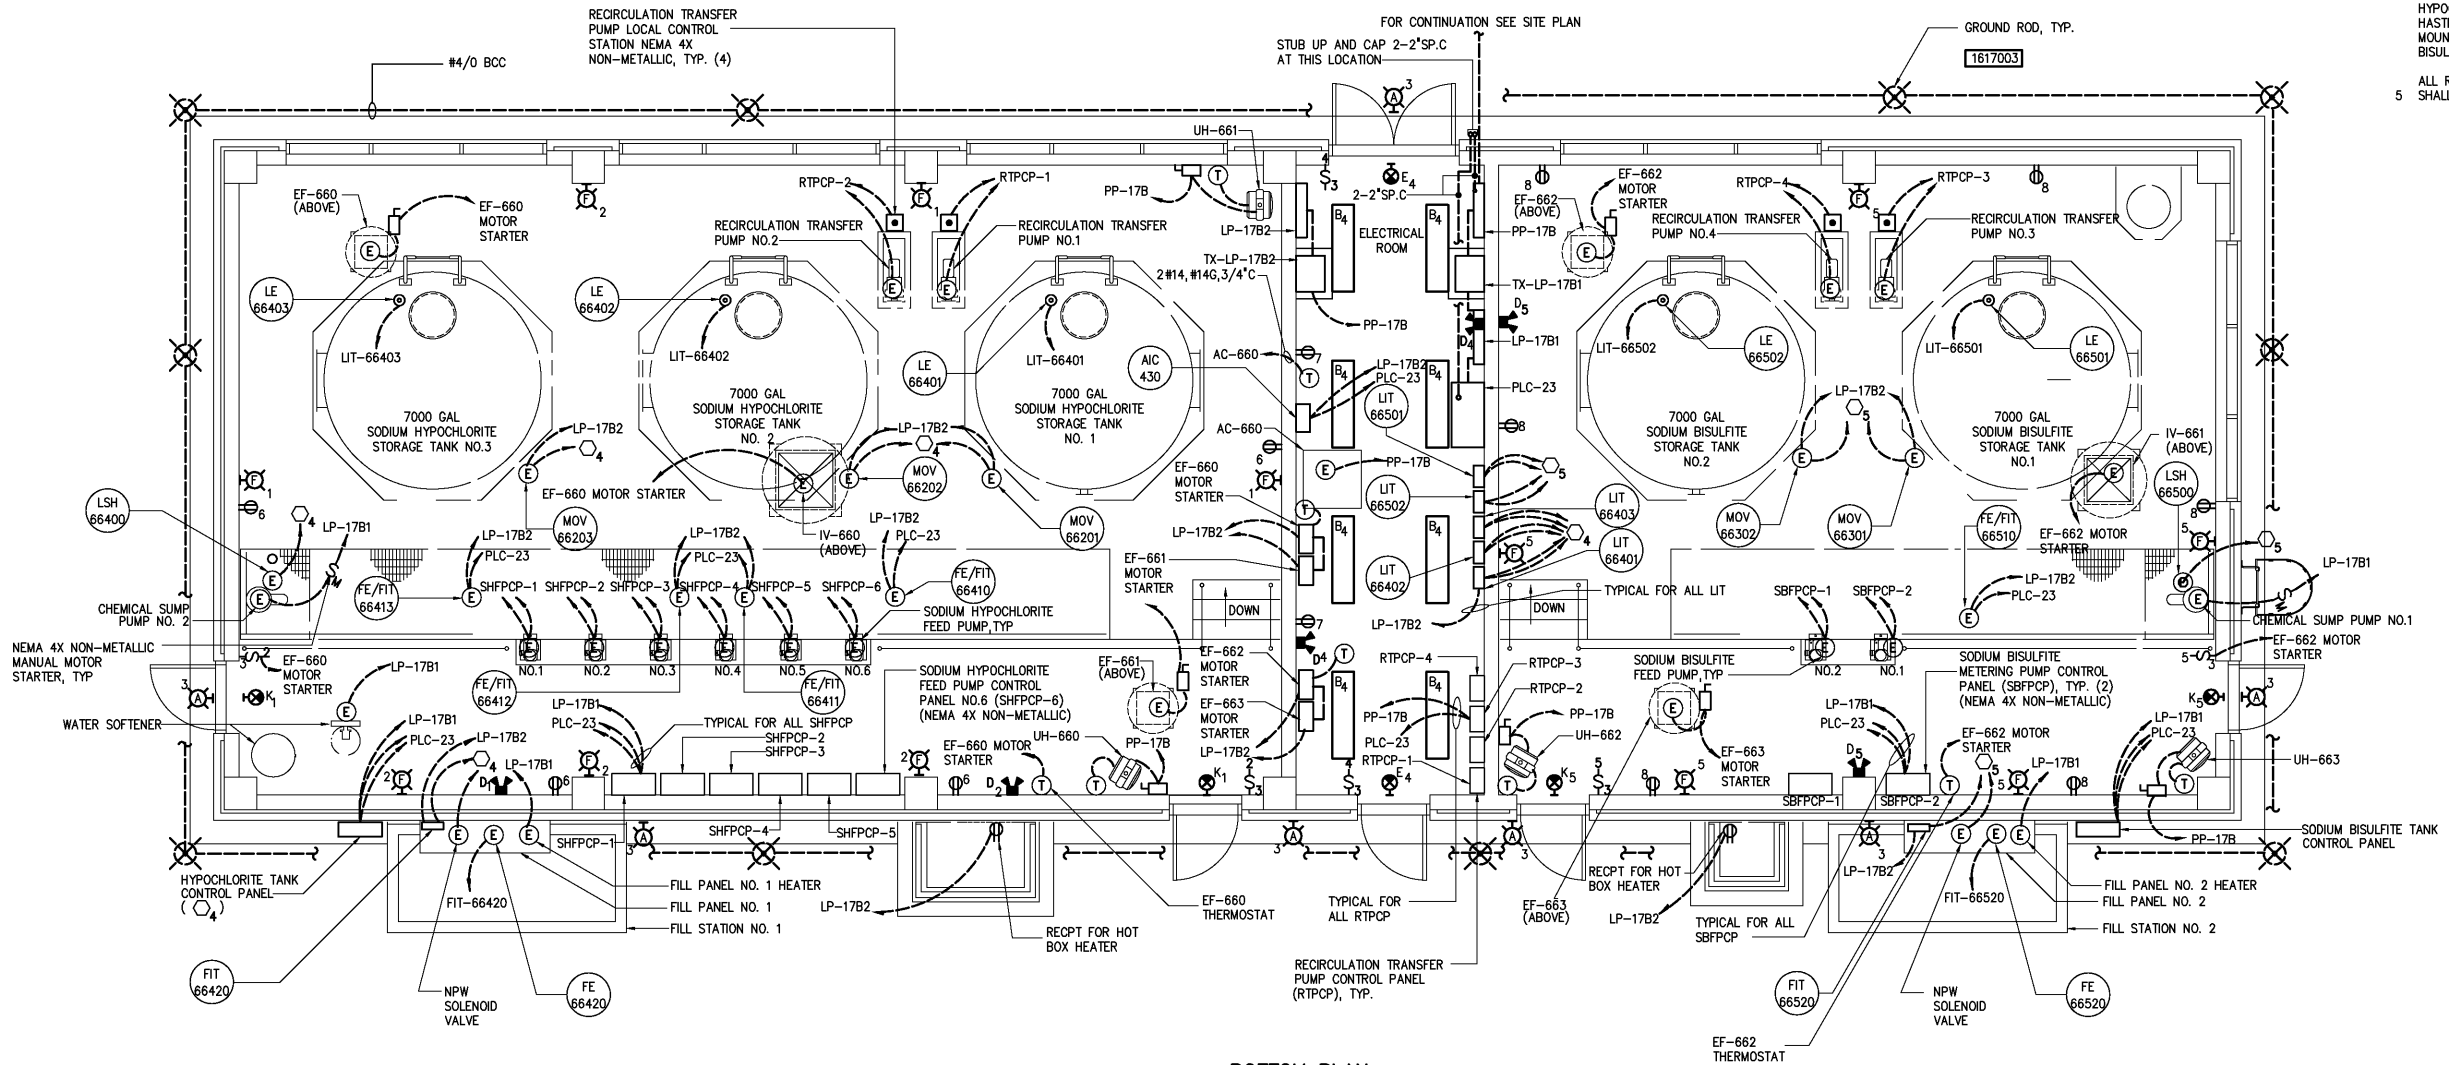

BOTTOM PLAN
1/4"=1'-0"

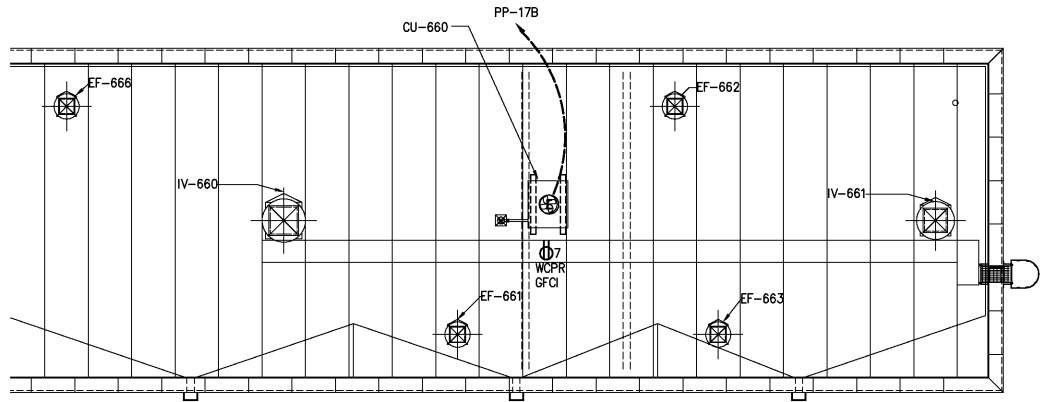

PARTIAL ROOF PLAN
1/8"=1'-0"

DESIGNED	BRL
DRAWN	BRL
CHECKED	
PROJ. ENGR.	H & S
ISSUED FOR	DATE
NO.	BY
APPROVED	

THIS DOCUMENT ORIGINALLY ISSUED FOR CONSTRUCTION AND SEALED BY ROBERT S. DIFIORE, SEAL NO. 22769

RECORD DRAWING

THIS DRAWING HAS BEEN MODIFIED TO REFLECT FIELD CHANGES REPORTED BY THE CONTRACTOR OR ANOTHER PARTY, BUT NOT VERIFIED BY THE CERTIFYING ENGINEER. THIS DOCUMENT ORIGINALLY ISSUED AND SEALED BY GERALD J. RATASKY, 026535. THIS MEDIA SHALL NOT BE CONSIDERED A CERTIFIED DOCUMENT.

THIS DOCUMENT ORIGINALLY ISSUED FOR CONSTRUCTION AND SEALED BY RONALD L. TAYLOR, SEAL NO. 024649

HAZEN AND SAWYER
Environmental Engineers & Scientists
4011 WestChase Blvd, Raleigh, North Carolina 27607

CITY OF ROANOKE
VIRGINIA

REGIONAL WATER POLLUTION CONTROL PLANT
WET WEATHER IMPROVEMENTS

DISINFECTION CHEMICAL FEED FACILITIES
ELECTRICAL
BOTTOM PLAN

THE SCALE BAR SHOWN BELOW MEASURES ONE INCH LONG ON THE ORIGINAL DRAWING.	DATE	JULY 2003
	H & S JOB NUMBER	30788A
	CONTRACT NUMBER	A
	DRAWING NUMBER	E660