
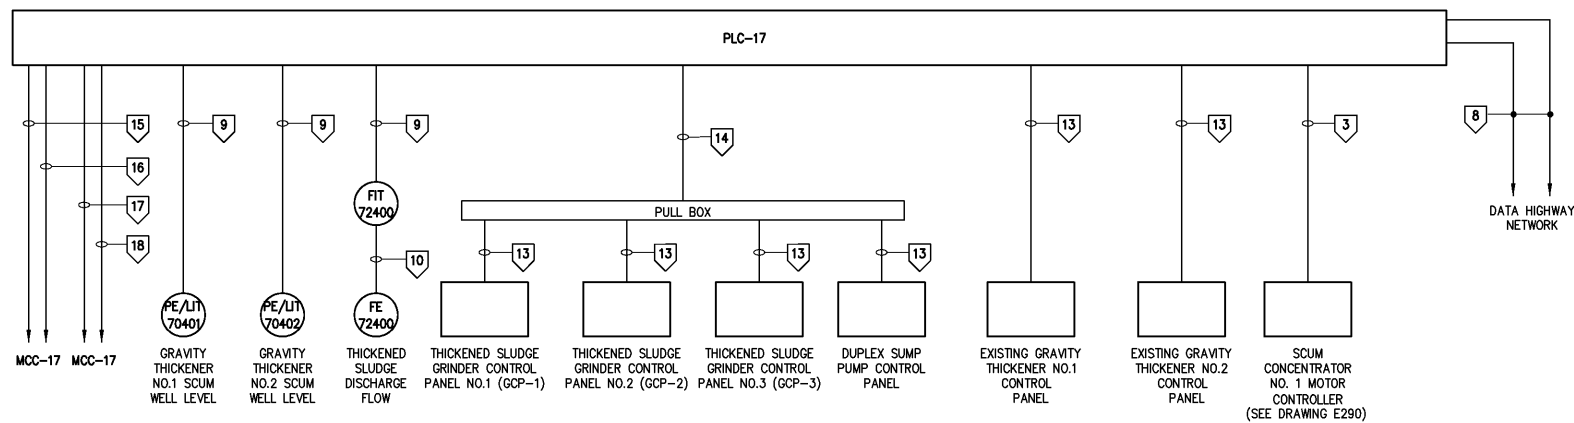


MCC-17 SINGLE LINE DIAGRAM

NO SCALE

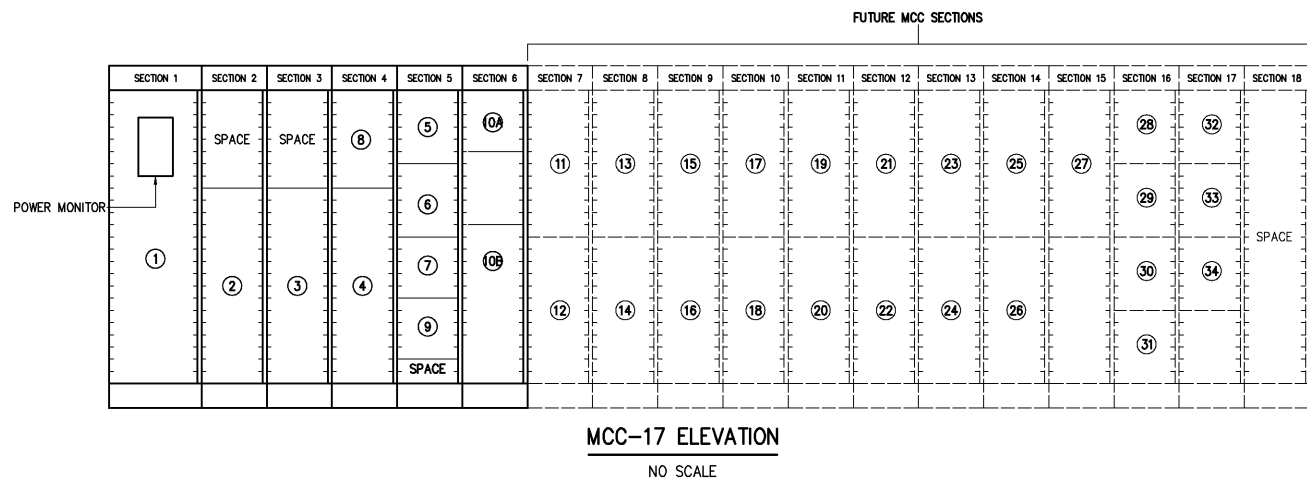

PLC-17 SINGLE LINE DIAGRAM

NO SCALE

DESIGNED	BRL	RECORD DRAWING	THIS DOCUMENT ORIGINALLY ISSUED FOR CONSTRUCTION AND SEALED BY ROBERT S. DIFIORE, SEAL NO. 22769	THIS DRAWING HAS BEEN MODIFIED TO REFLECT FIELD CHANGES REPORTED BY THE CONTRACTOR OR ANOTHER PARTY, BUT NOT VERIFIED BY THE CERTIFYING ENGINEER. THIS DOCUMENT ORIGINALLY ISSUED AND SEALED BY GERALD J. RATASKY, 026535. THIS MEDIA SHALL NOT BE CONSIDERED A CERTIFIED DOCUMENT.	HAZEN AND SAWYER Environmental Engineers & Scientists 4011 WestChase Blvd, Raleigh, North Carolina 27607	CITY OF ROANOKE VIRGINIA	REGIONAL WATER POLLUTION CONTROL PLANT WET WEATHER IMPROVEMENTS	THICKENED SLUDGE PUMP STATION ELECTRICAL SINGLE LINE DIAGRAMS AND ELEVATION	DATE	JULY 2003
DRAWN	BRL								H & S JOB NUMBER	30788A
CHECKED									CONTRACT NUMBER	A
PROJ. ENGR.	DAN								DRAWING NUMBER	E722
RECORD DRAWINGS	MAR 2008	RLT								
CONSTRUCTION	MAR 2004	RLT								
REGULATORY APPROVAL	NOV 2003	RLT								
PRELIMINARY DESIGN	NOV 2002	RLT								
ISSUED FOR	DATE	BY	APPROVED							