


NOTES:

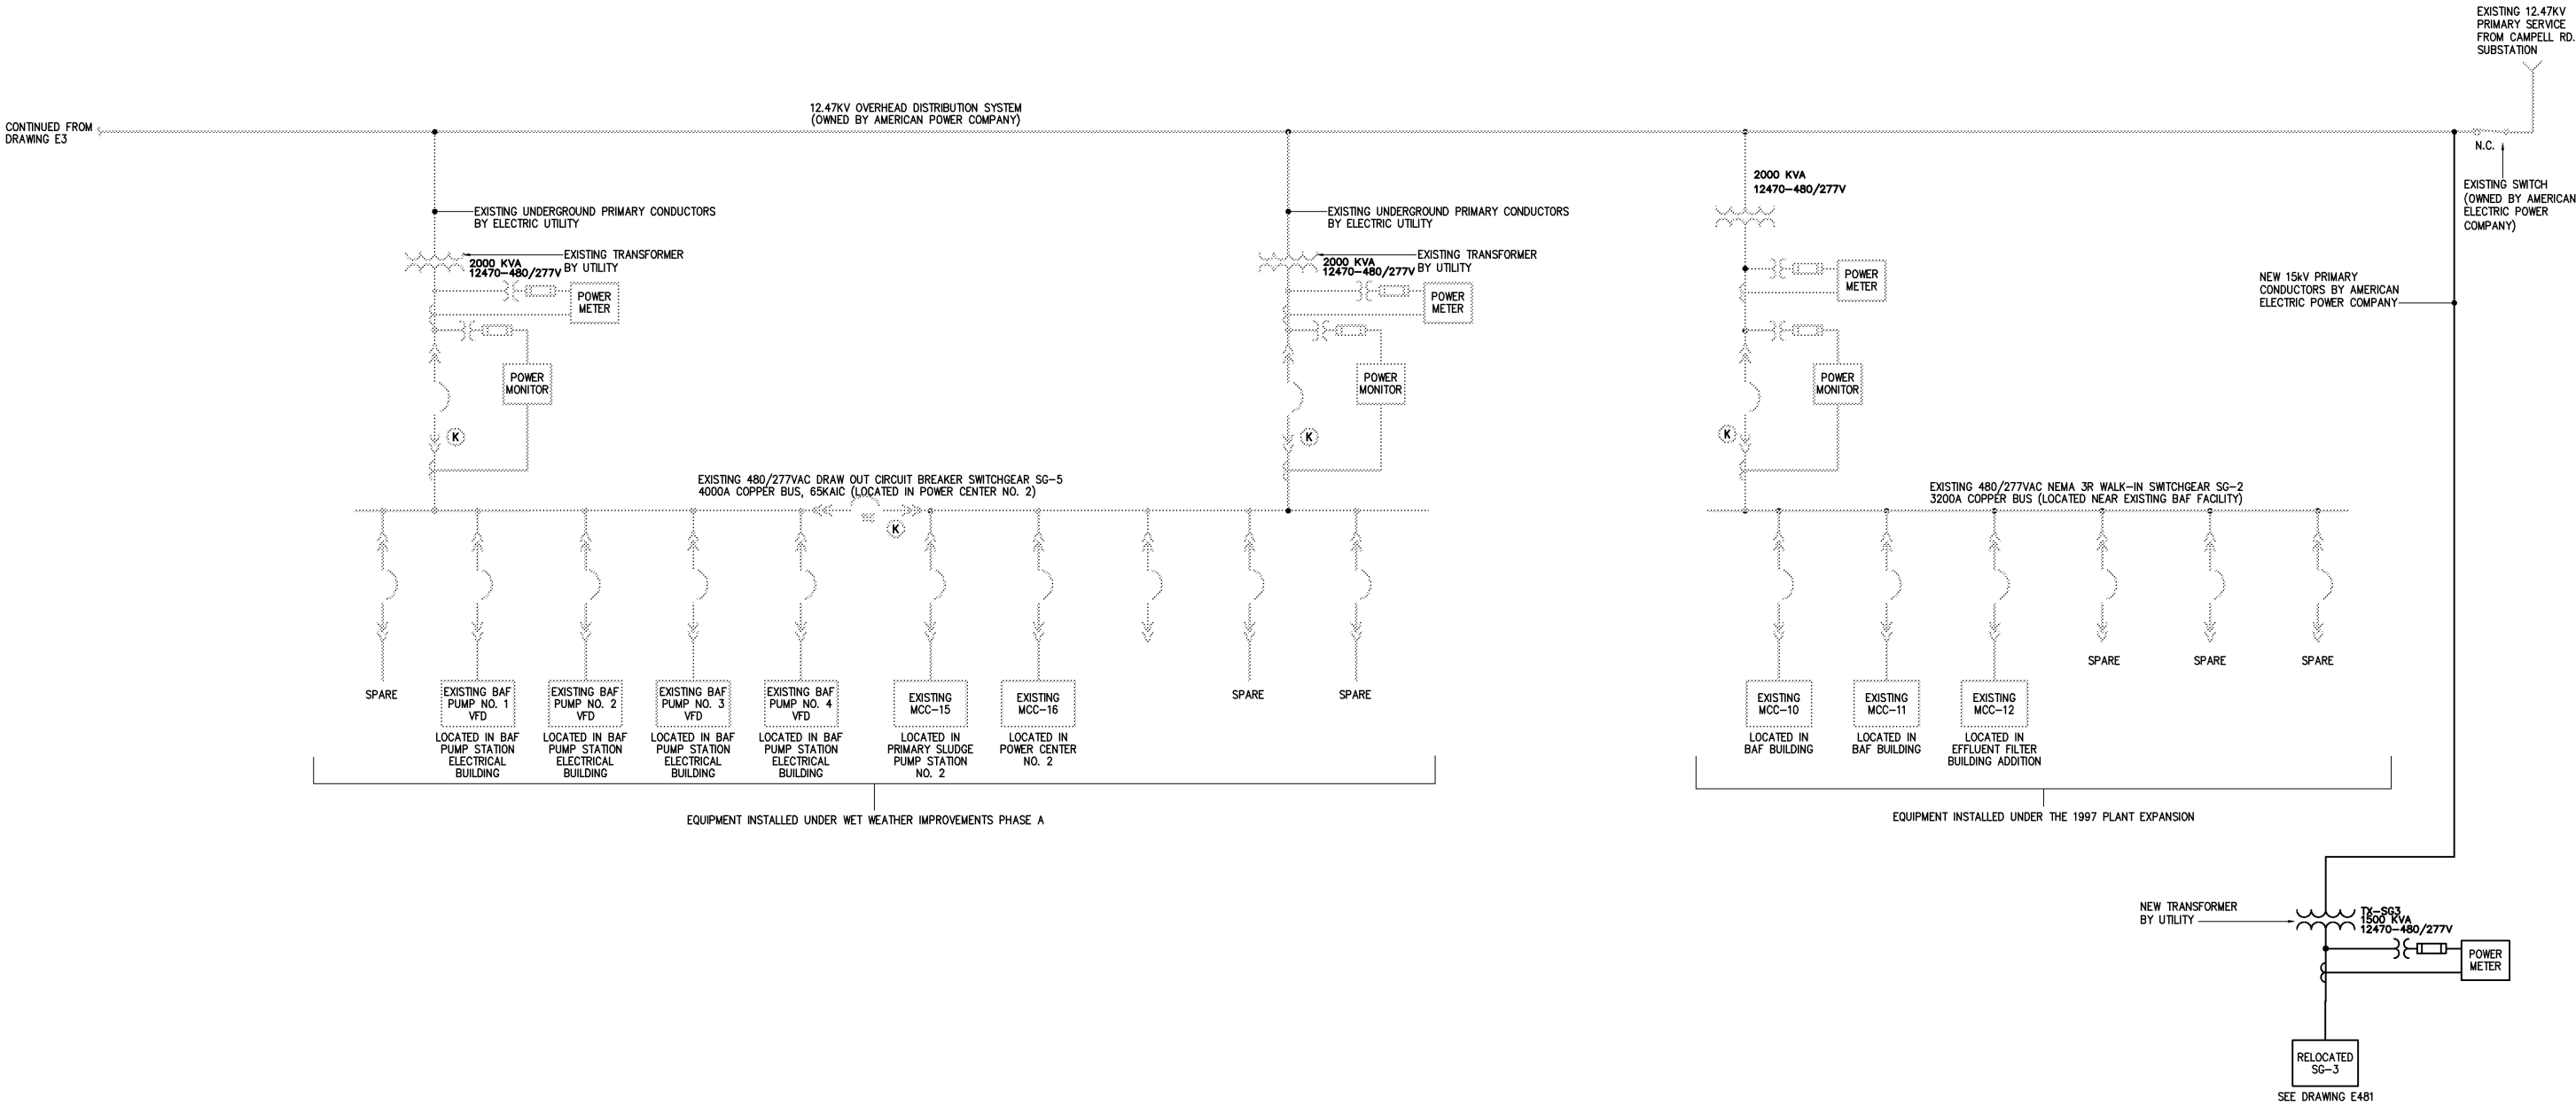

MASTER SINGLE LINE DIAGRAM (MODIFIED)

DESIGNED BRL				RECORD DRAWING		CITY OF ROANOKE VIRGINIA		ELECTRICAL		DATE MARCH 2004	
DRAWN BRL				THIS DOCUMENT ORIGINALLY ISSUED FOR CONSTRUCTION AND SEALED BY ROBERT S. DIFIORE, SEAL NO. 22769		Environmental Engineers & Scientists 4011 WestChase Blvd, Raleigh, North Carolina 27607		H & S JOB NUMBER 30788B		CONTRACT NUMBER B	
CHECKED				THIS DRAWING HAS BEEN MODIFIED TO REFLECT FIELD CHANGES REPORTED BY THE CONTRACTOR OR ANOTHER PARTY, BUT NOT VERIFIED BY THE CERTIFYING ENGINEER. THIS DOCUMENT ORIGINALLY ISSUED AND SEALED BY GERALD J. RATASKY, 026535. THIS MEDIA SHALL NOT BE CONSIDERED A CERTIFIED DOCUMENT.		REGIONAL WATER POLLUTION CONTROL PLANT PROCESS TRAIN IMPROVEMENTS		DRAWING NUMBER E4		THE SCALE BAR SHOWN BELOW MEASURES ONE INCH LONG ON THE ORIGINAL DRAWING.	
PROJ. ENGR. RLT				THIS DOCUMENT ORIGINALLY ISSUED FOR CONSTRUCTION AND SEALED BY RONALD L. TAYLOR, SEAL NO. 024649							
APPROVED											
NO.				DATE							
3				OCT 2007							
2				MAR 2004							
1				NOV 2003							
AS BUILT											
CONSTRUCTION											
REGULATORY APPROVAL											
ISSUED FOR											