


NOTES:

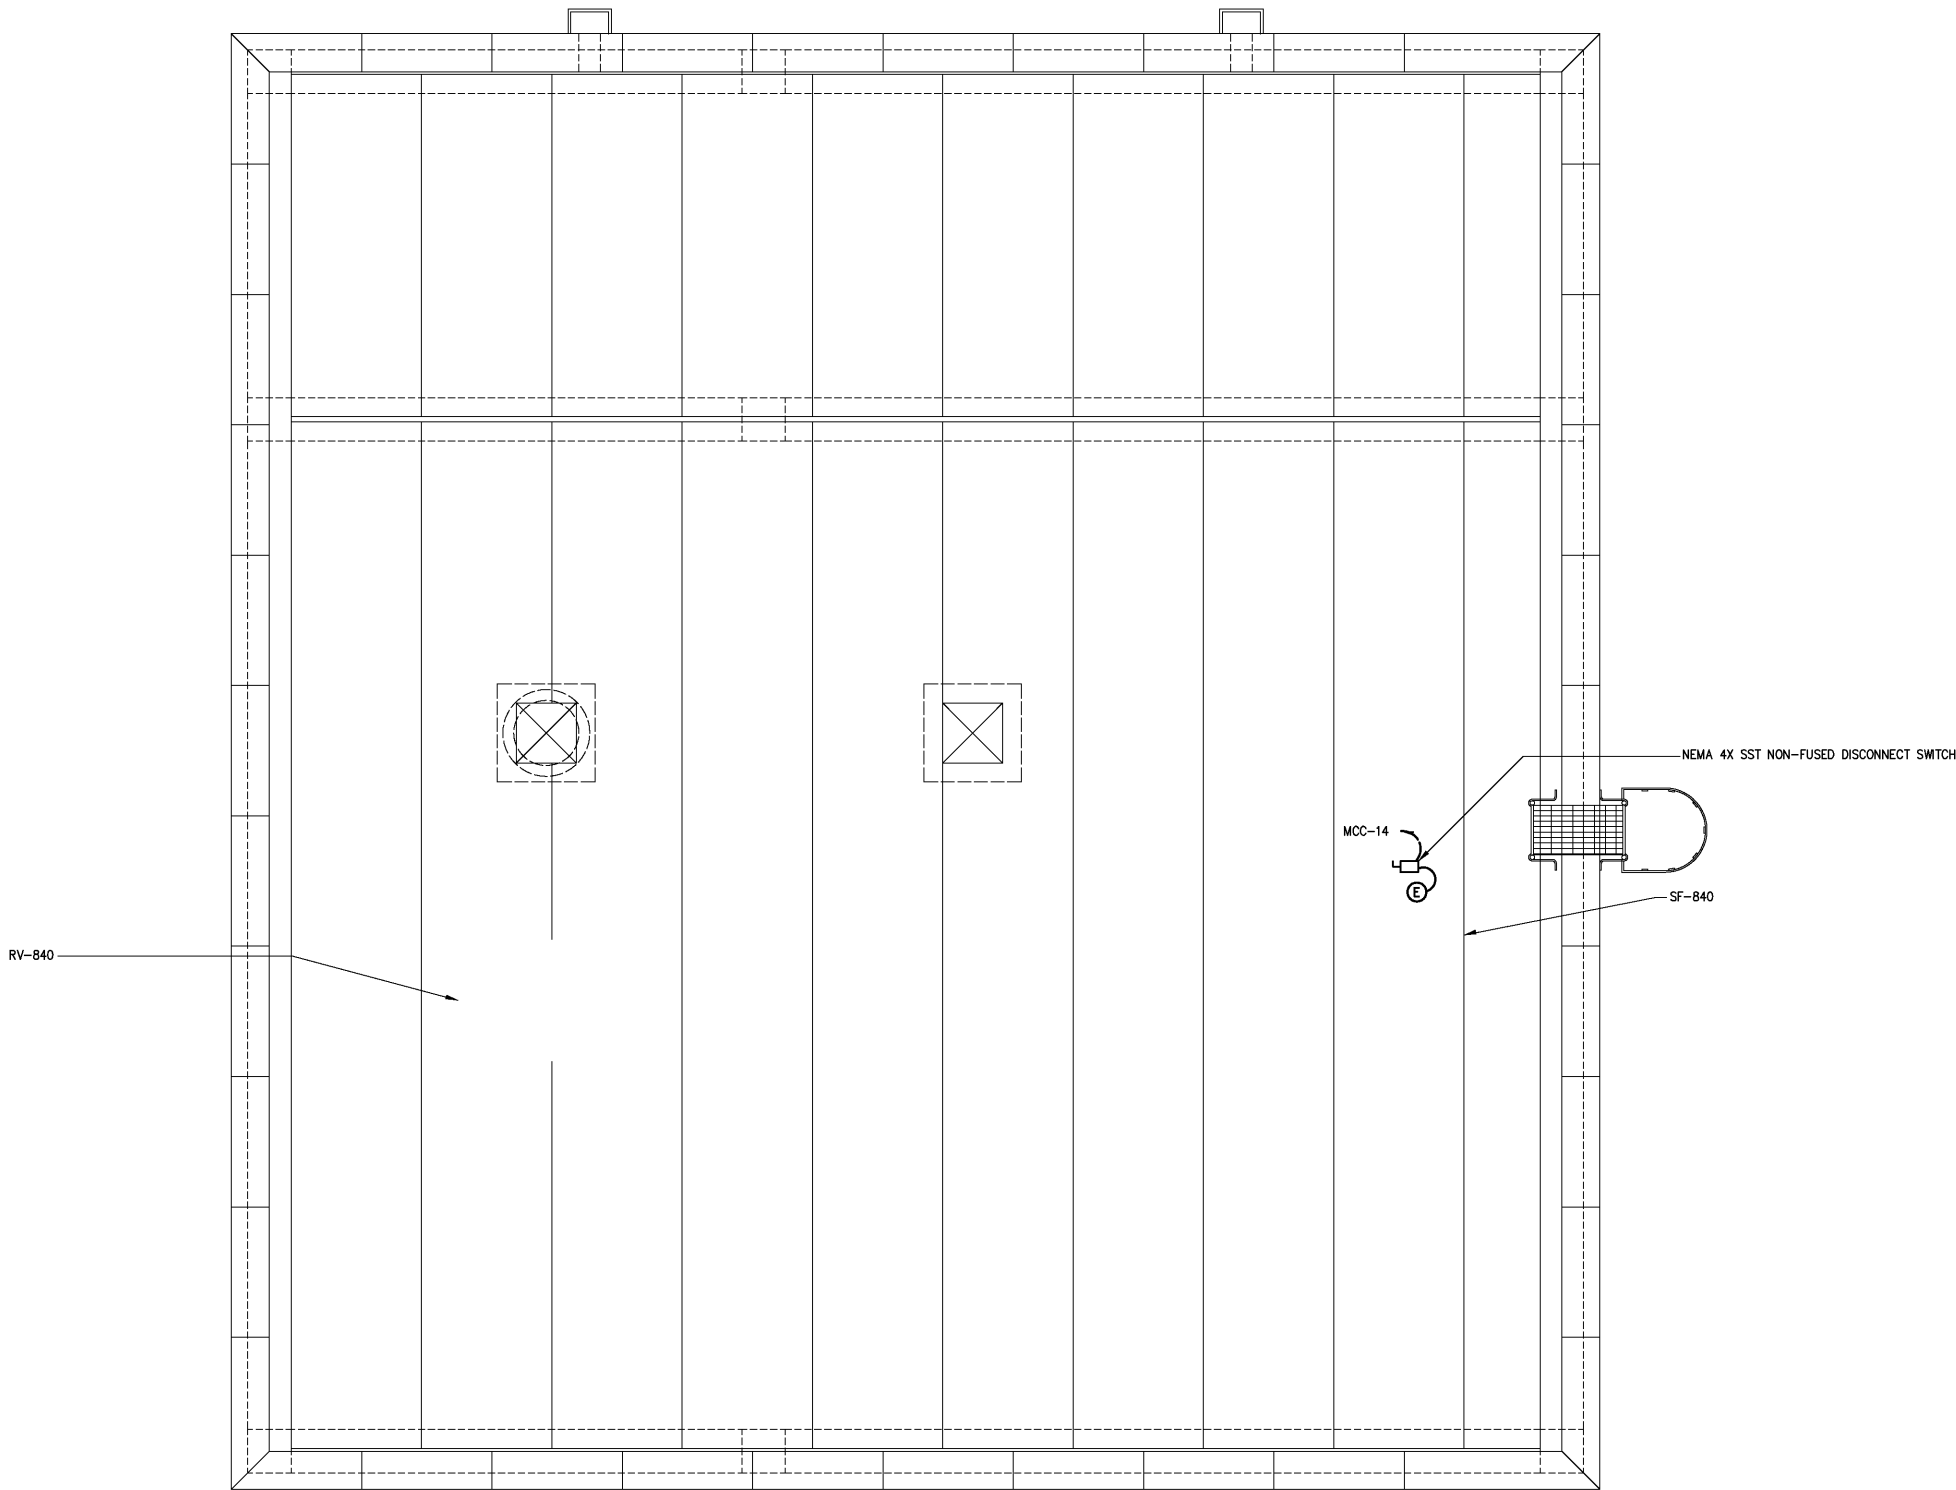

ROOF PLAN
3/8"=1'-0"

				DESIGNED	BRL	RECORD DRAWING	HAZEN AND SAWYER Environmental Engineers & Scientists 4011 WestChase Blvd, Raleigh, North Carolina 27607	CITY OF ROANOKE VIRGINIA	BOILER BUILDING ELECTRICAL ROOF PLAN	THE SCALE BAR SHOWN BELOW MEASURES ONE INCH LONG ON THE ORIGINAL DRAWING.	DATE MARCH 2004				
				DRAWN	BRL						H & S JOB NUMBER	30788B			
				CHECKED							CONTRACT NUMBER	B	DRAWING NUMBER	E841	
3	AS BUILT	OCT 2007	RLT	PROJ. ENGR.	CMB	THIS DOCUMENT ORIGINALLY ISSUED FOR CONSTRUCTION AND SEALED BY RONALD L. TAYLOR, SEAL NO. 024649									
2	CONSTRUCTION	MAR 2004	RLT												
1	REGULATORY APPROVAL	NOV 2003	RLT												
NO.	ISSUED FOR	DATE	BY	APPROVED		THIS DRAWING HAS BEEN MODIFIED TO REFLECT FIELD CHANGES REPORTED BY THE CONTRACTOR OR ANOTHER PARTY, BUT NOT VERIFIED BY THE CERTIFYING ENGINEER. THIS DOCUMENT ORIGINALLY ISSUED AND SEALED BY GERALD J. RATASKY, 026535. THIS MEDIA SHALL NOT BE CONSIDERED A CERTIFIED DOCUMENT.									

POST DATE 03/15/04 4:46pm FILE= H:\30788\30788B\ELEC\841 by BLSK 30788-30788B\mhc\30788B10, 840\840-pr, 840\840-pr-h