



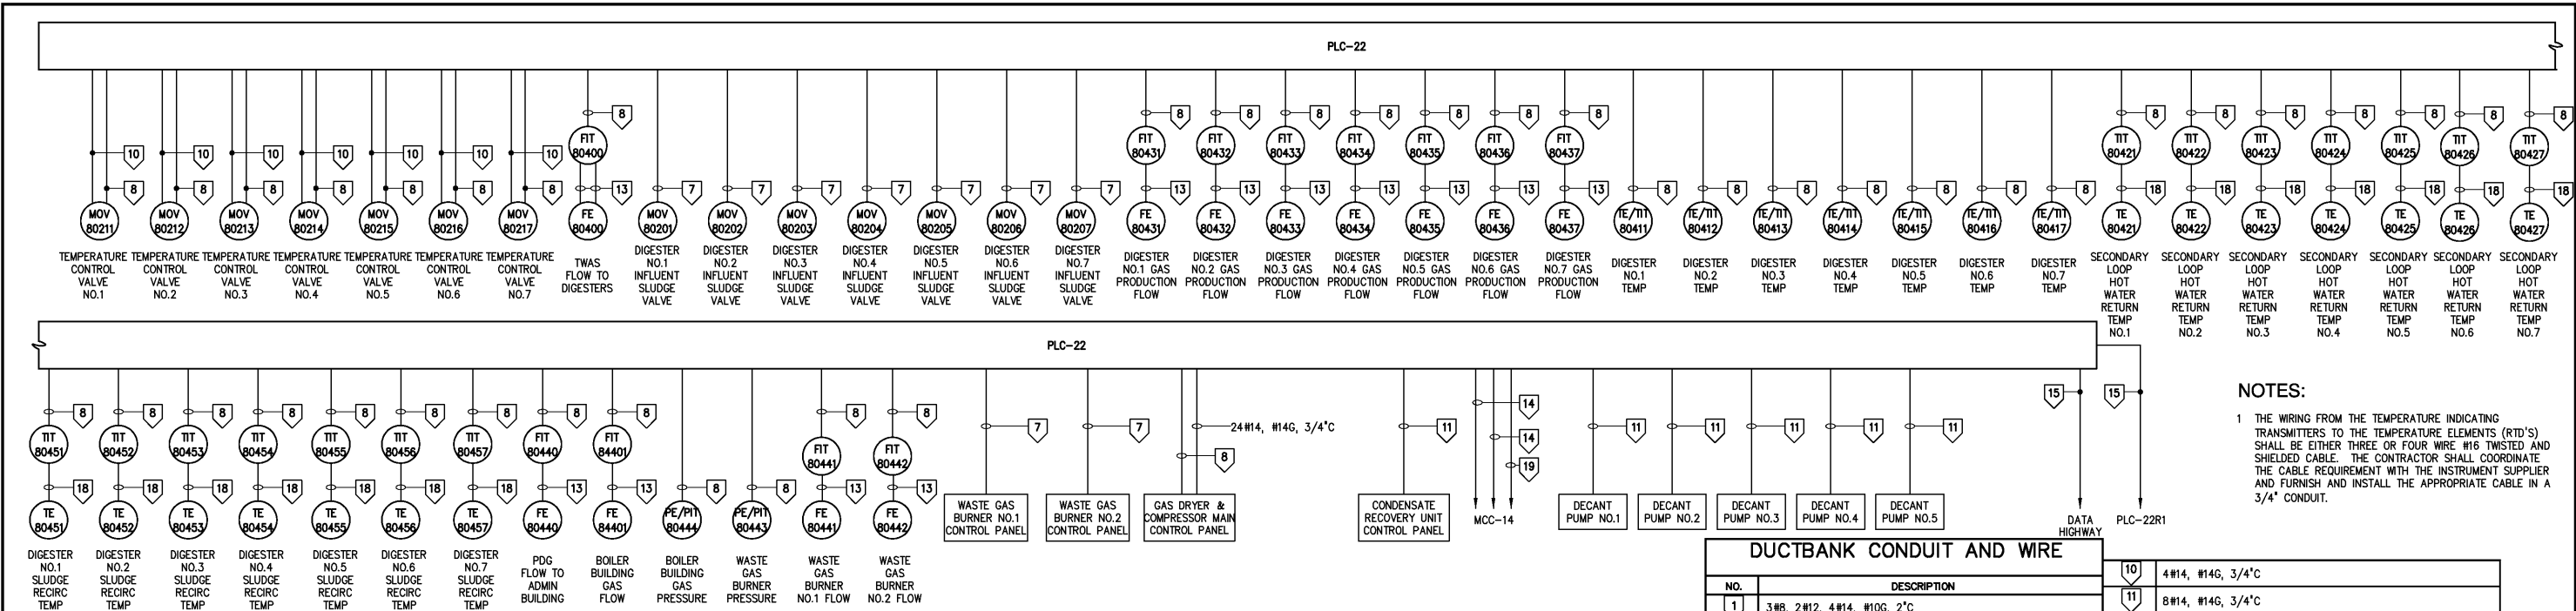

PLC-22 CONTROL ONE LINE DIAGRAM

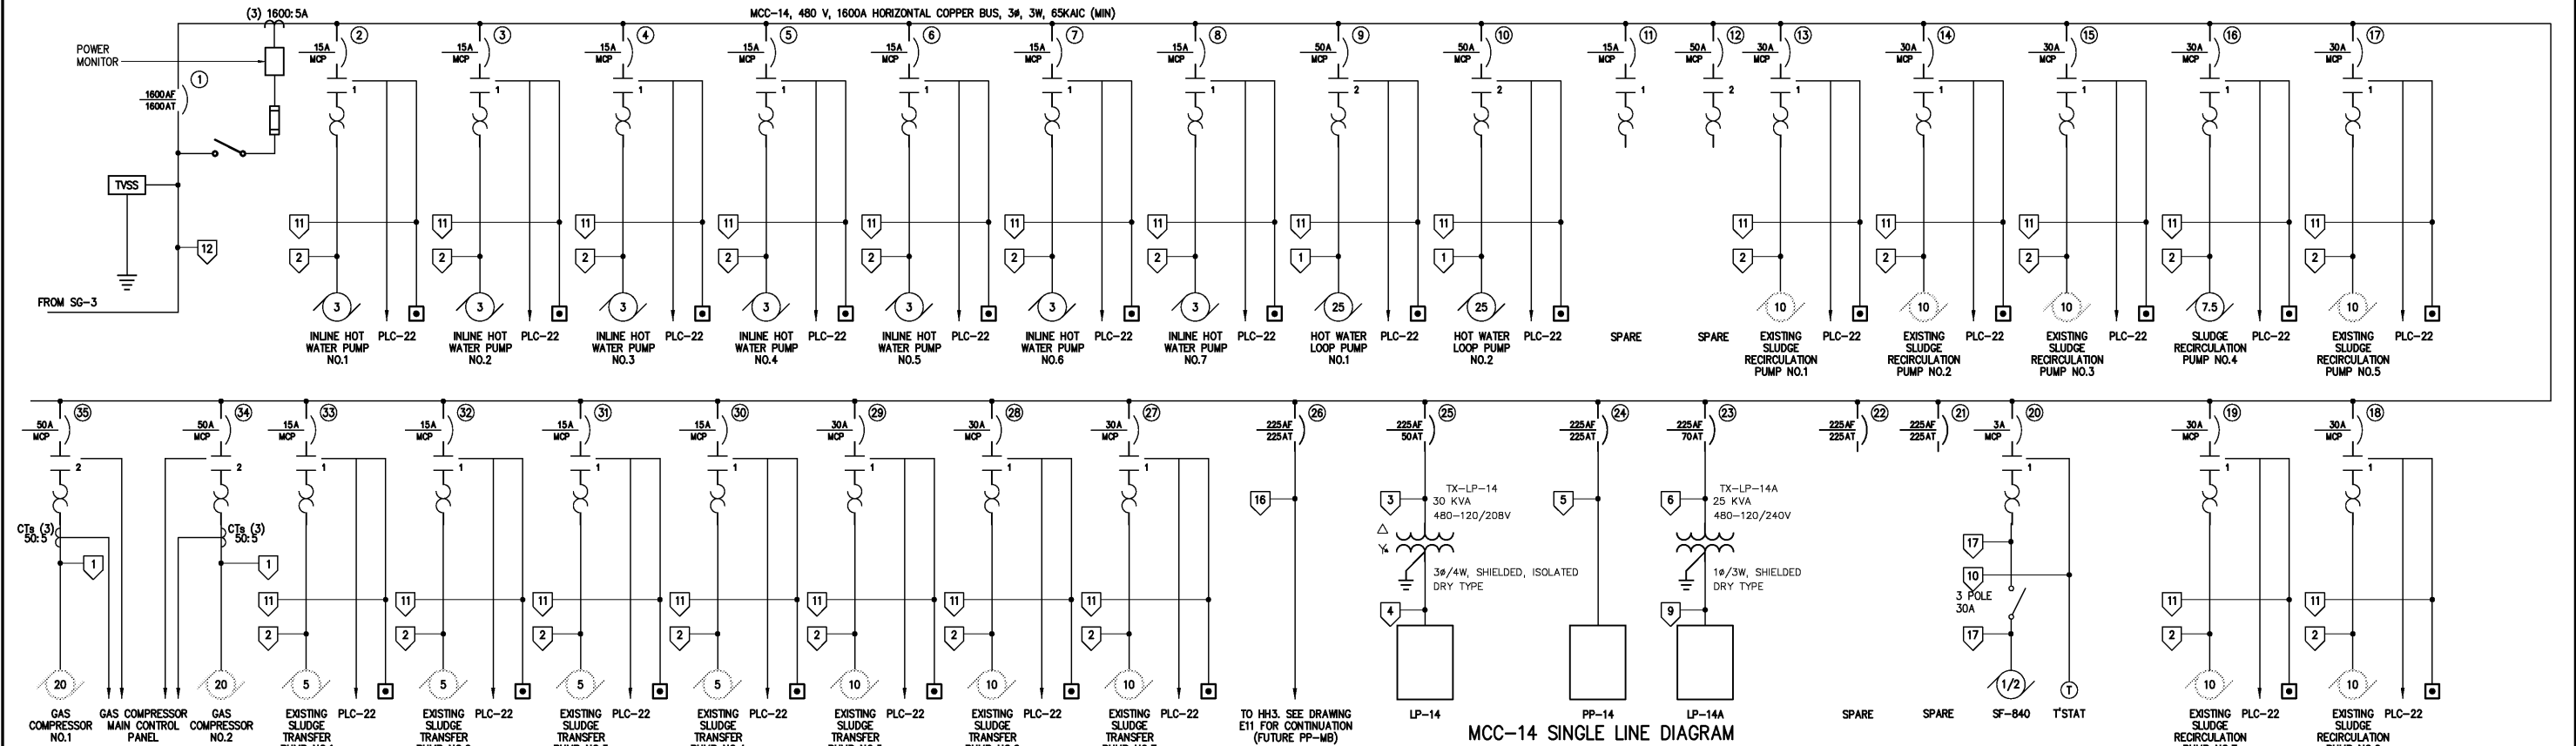

DESIGNED: BRL				RECORD DRAWING				CITY OF ROANOKE VIRGINIA				BOILER BUILDING ELECTRICAL				THE SCALE BAR SHOWN BELOW MEASURES ONE INCH LONG ON THE ORIGINAL DRAWING.				DATE: MARCH 2004			
DRAWN: BRL				THIS DOCUMENT ORIGINALLY ISSUED FOR CONSTRUCTION AND SEALED BY ROBERT S. DIFIIORE, SEAL NO. 22769				HAZEN AND SAWYER Environmental Engineers & Scientists 4011 WestChase Blvd, Raleigh, North Carolina 27607				REGIONAL WATER POLLUTION CONTROL PLANT PROCESS TRAIN IMPROVEMENTS				CONTRACT NUMBER B				H & S JOB NUMBER 30788B			
CHECKED:				THIS DRAWING HAS BEEN MODIFIED TO REFLECT FIELD CHANGES REPORTED BY THE CONTRACTOR OR ANOTHER PARTY, BUT NOT VERIFIED BY THE CERTIFYING ENGINEER. THIS DOCUMENT ORIGINALLY ISSUED AND SEALED BY GERALD J. RATASKY, 026535. THIS MEDIA SHALL NOT BE CONSIDERED A CERTIFIED DOCUMENT.												DRAWING NUMBER E842							
PROJ. ENGR. CMB																							
APPROVED																							
ADDITIONAL 1																							
CONSTRUCTION																							
REGULATORY APPROVAL																							
ISSUED FOR																							
NO.																							