



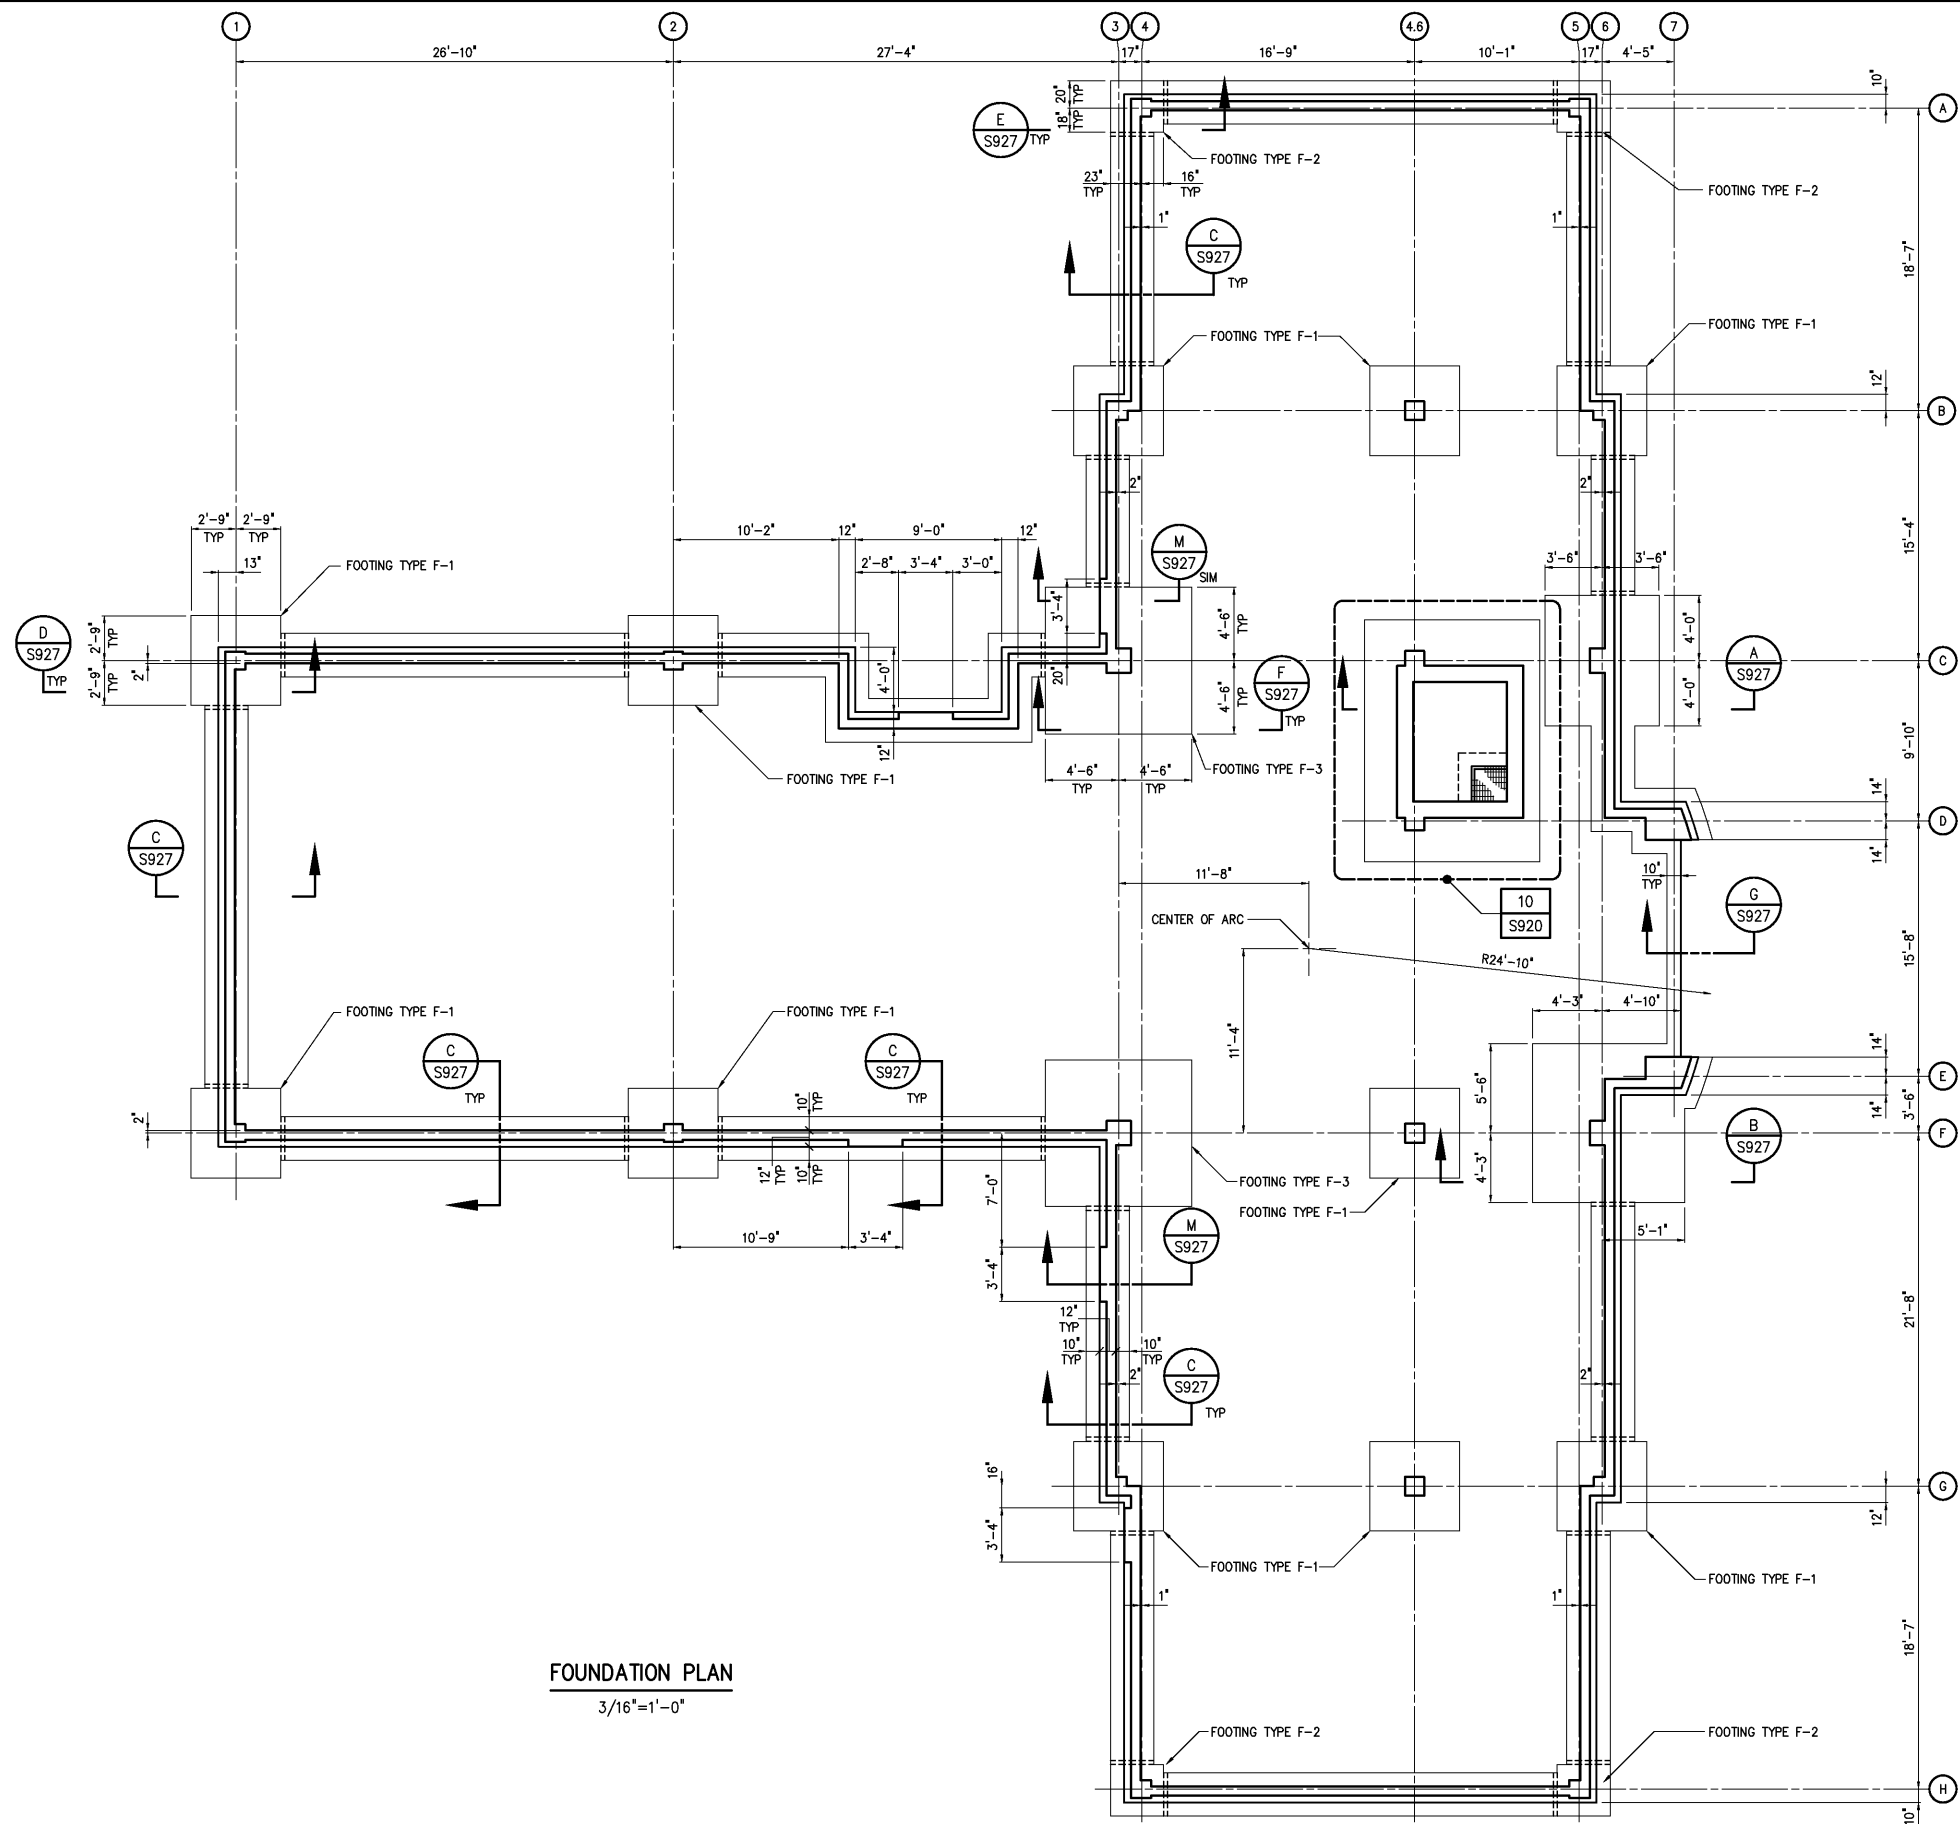

- NOTES:
- SEE DRAWING S928 FOR COLUMN ANCHOR BOLT INFORMATION.
 - SUBGRADE SHALL BE INSPECTED BY GEOTECHNICAL ENGINEER PRIOR TO PLACING OF STONE BASE.
 - CONTRACTOR SHALL COMPACT SUBGRADE BELOW ADMINISTRATION BUILDING IN ACCORDANCE WITH THE SPECIFICATIONS. A MINIMUM OF 12" #57 STONE SHALL BE PLACED BELOW ALL FOOTINGS AND THE PERIMETER STEM WALL. A MINIMUM OF 8" #57 STONE SHALL BE PLACED BELOW THE FLOATING SLAB. A VAPOR BARRIER SHALL BE PLACED ON TOP OF THE #57 STONE BASE OVER THE ENTIRE FOOTPRINT OF THE ADMINISTRATION BUILDING.
 - ELEVATOR PIT DIMENSIONS ARE BASED ON THE THYSSSEN KRUPP FLEETWOOD 21 ELEVATOR. COORDINATE PIT DIMENSIONS WITH ELEVATOR VENDOR.

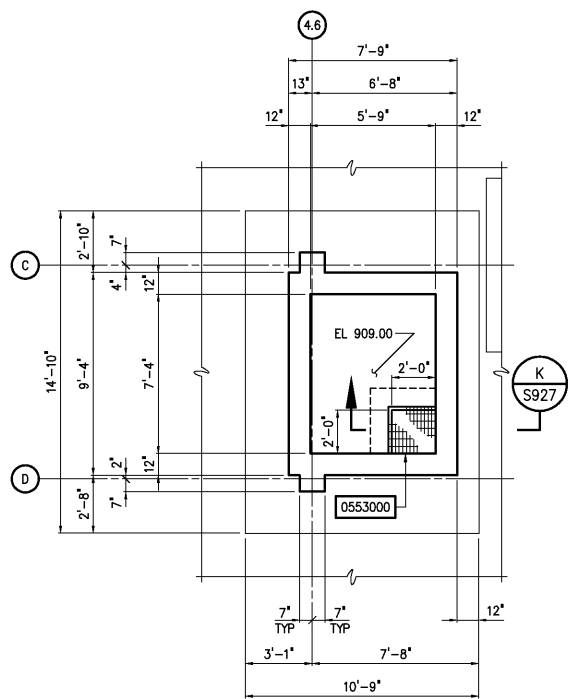

DETAIL 10
1/4"=1'-0" S920

PILASTER SCHEDULE	
COLUMN	PILASTER DETAIL
3-C, 3-F	1/S927
3-B, 3-G, 6-B, 6-G	2/S927
7-D, 7-E	3/S927
4.6-B, 4.6-F, 4.6-G,	9/S927
4.6-C, 4.6-D	12/S927
1-C, 1-F, 4-A, 4-H, 5-A, 5-H	13/S927
2-C, 2-F	14/S927
6-C, 6-F	15/S927

FOUNDATION PLAN
3/16"=1'-0"

DESIGNED BGS DRAWN BGS CHECKED PROJ. ENGR. DAN APPROVED				THIS DOCUMENT ORIGINALLY ISSUED FOR CONSTRUCTION AND SEALED BY ROBERT S. DIFIORE, SEAL NO. 22769 THIS DOCUMENT ORIGINALLY ISSUED FOR CONSTRUCTION AND SEALED BY RONALD L. TAYLOR, SEAL NO. 024649		RECORD DRAWING THIS DRAWING HAS BEEN MODIFIED TO REFLECT FIELD CHANGES REPORTED BY THE CONTRACTOR OR ANOTHER PARTY, BUT NOT VERIFIED BY THE CERTIFYING ENGINEER. THIS DOCUMENT ORIGINALLY ISSUED AND SEALED BY CHRISTOPHER T. PHILLIPS, 033796. THIS MEDIA SHALL NOT BE CONSIDERED A CERTIFIED DOCUMENT.		HAZEN AND SAWYER Environmental Engineers & Scientists 4011 WestChase Blvd, Raleigh, North Carolina 27607		CITY OF ROANOKE VIRGINIA REGIONAL WATER POLLUTION CONTROL PLANT PROCESS TRAIN IMPROVEMENTS		ADMINISTRATION BUILDING STRUCTURAL FOUNDATION PLAN		THE SCALE BAR SHOWN BELOW MEASURES ONE INCH LONG ON THE ORIGINAL DRAWING. DATE JANUARY 2004 H & S JOB NUMBER 30788C CONTRACT NUMBER C DRAWING NUMBER S920	
--	--	--	--	---	--	--	--	---	--	--	--	---	--	--	--