



- NOTES:
- 1 ALL EXISTING DIMENSIONS AND ELEVATIONS TO BE FIELD VERIFIED.
 - 2 SUBGRADE SHALL BE INSPECTED BY GEOTECHNICAL ENGINEER PRIOR TO PLACING OF STONE BASE.
 - 3 CONTRACTOR SHALL COMPACT SUBGRADE BELOW MAINTENANCE BUILDING ADDITION IN ACCORDANCE WITH THE SPECIFICATIONS. A MINIMUM OF 12" #57 STONE SHALL BE PLACED BELOW ALL FOOTINGS AND THE PERIMETER STEM WALL. A MINIMUM OF 8" #57 STONE SHALL BE PLACED BELOW THE FLOATING SLAB. A VAPOR BARRIER SHALL BE PLACED ON TOP OF THE #57 STONE BASE OVER THE ENTIRE FOOTPRINT OF THE MAINTENANCE BUILDING ADDITION.

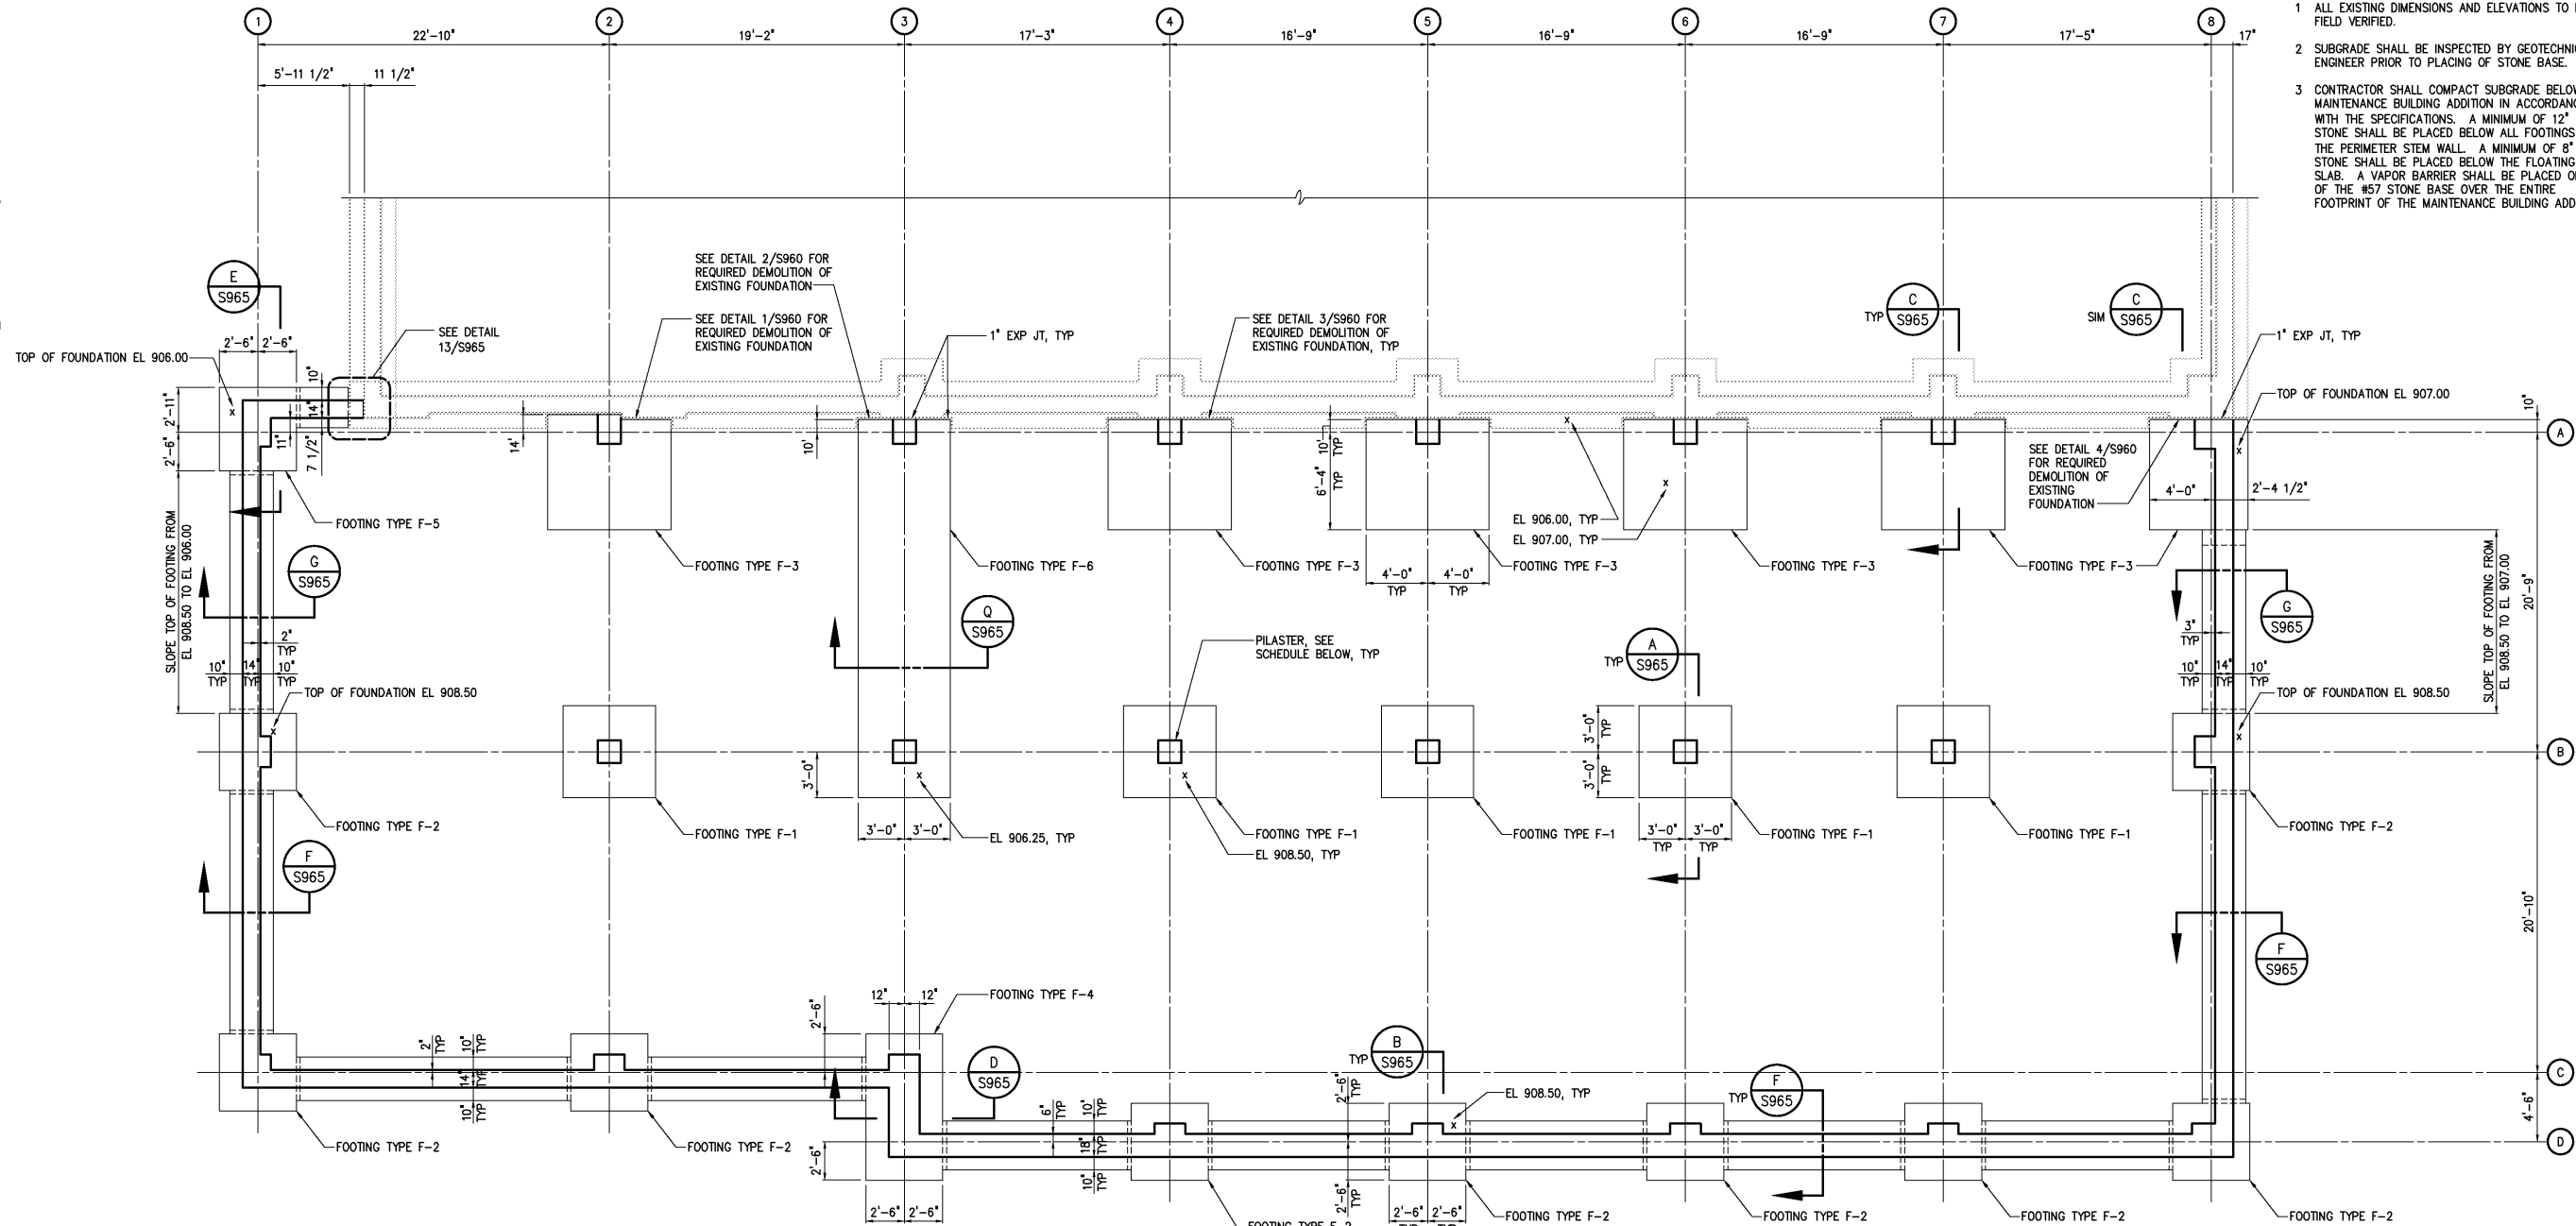


FOUNDATION PLAN

3/16"=1'-0"

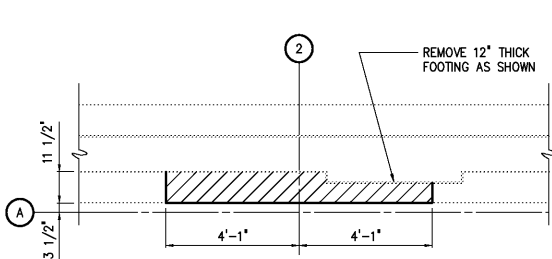


FOUNDATION DEMOLITION

DETAIL	1
3/8"=1'-0"	S960

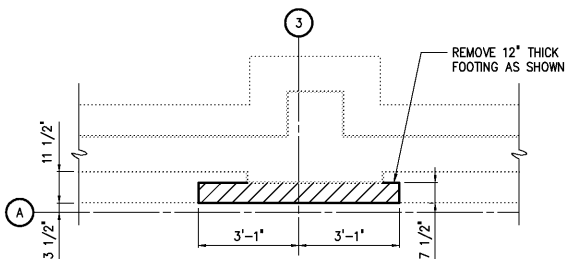


FOUNDATION DEMOLITION

DETAIL	2
3/8"=1'-0"	S960

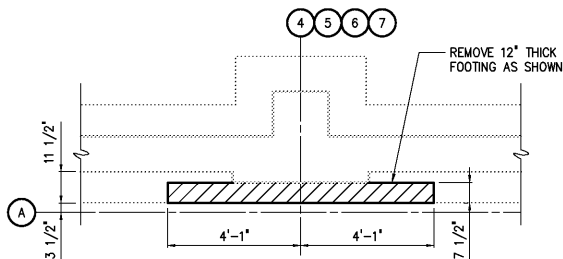

FOUNDATION DEMOLITION

DETAIL	3
3/8"=1'-0"	S960

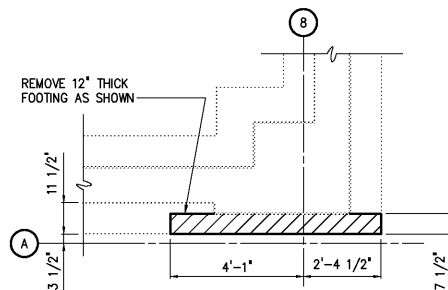

FOUNDATION DEMOLITION

DETAIL	4
3/8"=1'-0"	S960

PILASTER SCHEDULE	
COLUMN	DETAIL
1-A	1/S965
2-A	2/S965
3-A, 4-A, 5-A, 6-A & 7-A	3/S965
8-A	4/S965
1-B	5/S965
2-B, 3-B, 4-B, 5-B, 6-B & 7-B	6/S965
8-B	7/S965
1-C	8/S965
2-C	9/S965
3-C/3-D	10/S965
4-D, 5-D, 6-D & 7-D	11/S965
8-D	12/S965

DESIGNED	BGS
DRAWN	BGS
CHECKED	
PROJ. ENGR.	DAN
APPROVED	
NO.	
3	RECORD DRAWING
2	CONSTRUCTION
1	REGULATORY APPROVAL
NO.	ISSUED FOR
DATE	DATE
BY	BY
APPROVED	APPROVED

THIS DOCUMENT ORIGINALLY ISSUED FOR CONSTRUCTION AND SEALED BY ROBERT S. DIFIORE, SEAL NO. 22769

RECORD DRAWING

THIS DRAWING HAS BEEN MODIFIED TO REFLECT FIELD CHANGES REPORTED BY THE CONTRACTOR OR ANOTHER PARTY, BUT NOT VERIFIED BY THE CERTIFYING ENGINEER. THIS DOCUMENT ORIGINALLY ISSUED AND SEALED BY CHRISTOPHER T. PHILLIPS, 033796. THIS MEDIA SHALL NOT BE CONSIDERED A CERTIFIED DOCUMENT.

THIS DOCUMENT ORIGINALLY ISSUED FOR CONSTRUCTION AND SEALED BY RONALD L. TAYLOR, SEAL NO. 024649

HAZEN AND SAWYER
Environmental Engineers & Scientists
4011 WestChase Blvd, Raleigh, North Carolina 27607

CITY OF ROANOKE
VIRGINIA

REGIONAL WATER POLLUTION CONTROL PLANT
PROCESS TRAIN IMPROVEMENTS

MAINTENANCE BUILDING MODIFICATIONS
STRUCTURAL
FOUNDATION PLAN

THE SCALE BAR SHOWN BELOW MEASURES ONE INCH LONG ON THE ORIGINAL DRAWING.	DATE JANUARY 2004	H & S JOB NUMBER 30788C	CONTRACT NUMBER C	DRAWING NUMBER S960
---	-------------------	-------------------------	-------------------	---------------------