



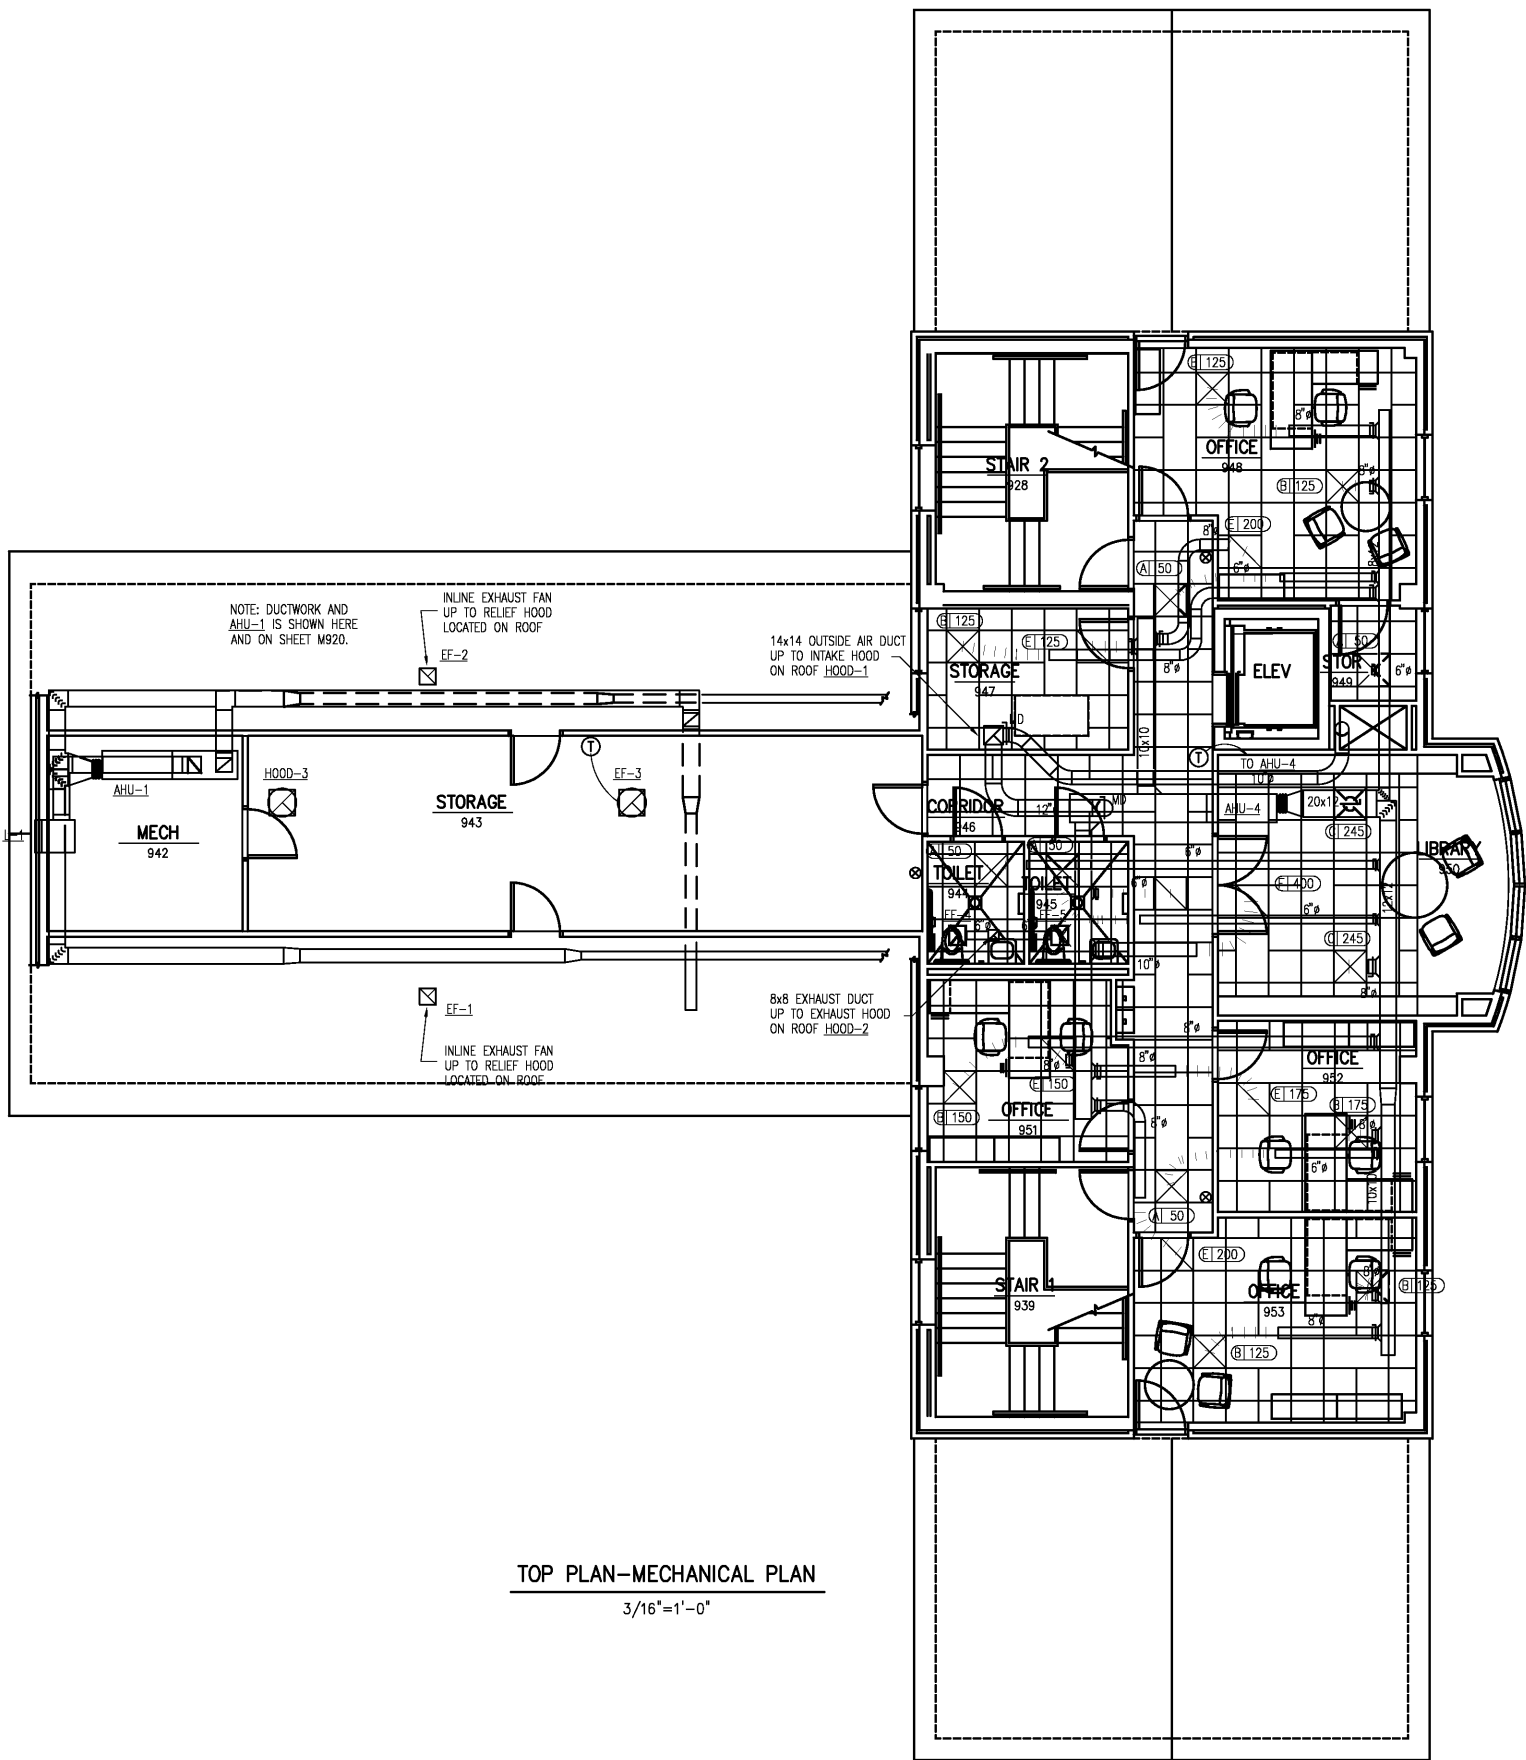

TOP PLAN-MECHANICAL PLAN
3/16"=1'-0"

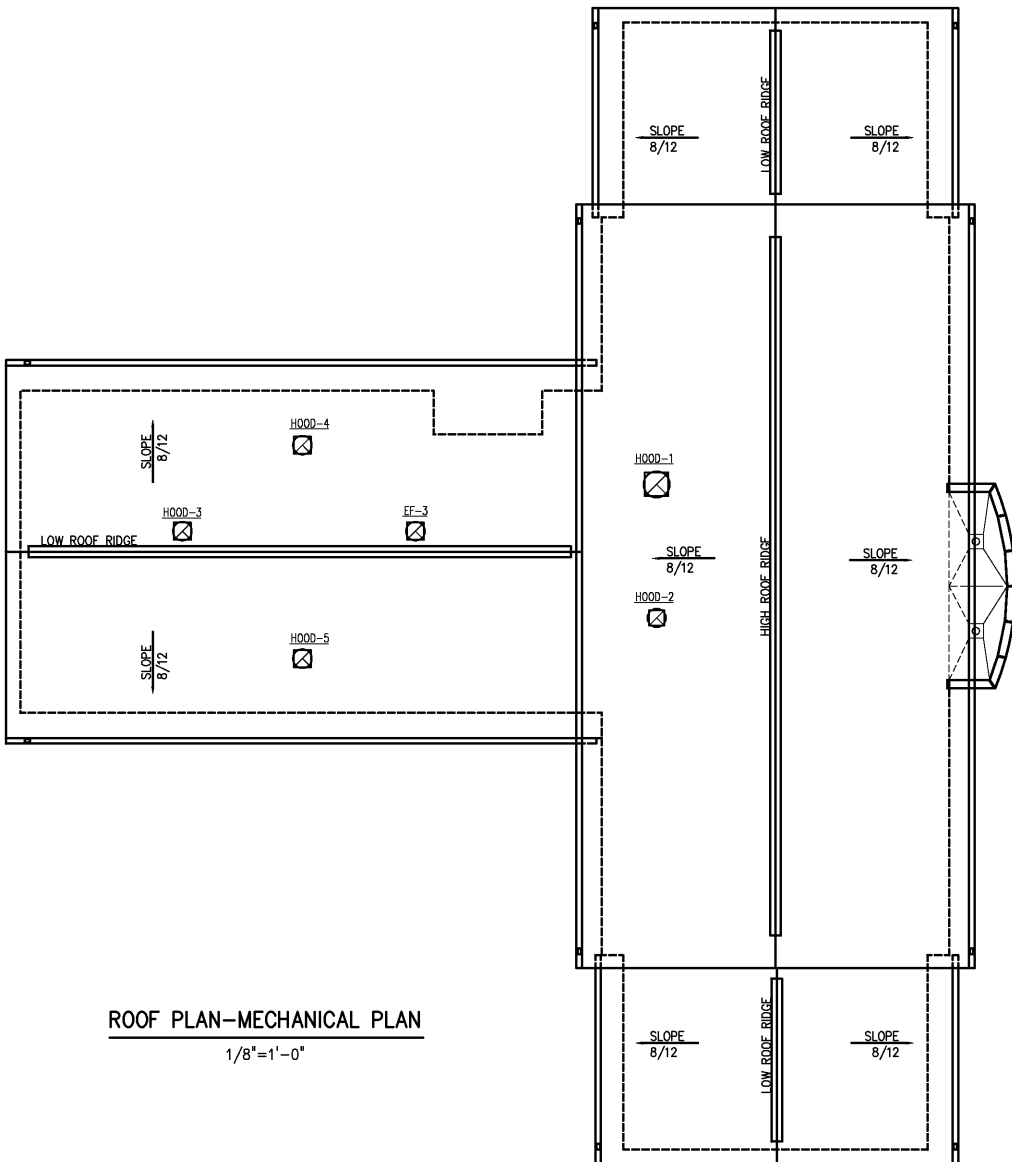

ROOF PLAN-MECHANICAL PLAN
1/8"=1'-0"

NO.	ISSUED FOR	DATE	BY	APPROVED
3	RECORD DRAWING	JAN 2006		
2	CONSTRUCTION	JAN 2004		
1	REGULATORY APPROVAL	NOV 2003		

DESIGNED RDM
DRAWN RDM
CHECKED
PROJ. ENGR. H & S
APPROVED

RECORD DRAWING
EDI
Engineered Designs, Inc.
1011 Schaub Dr. Suite 201
Raleigh, North Carolina 27606
Office: 919.851.8481
Fax: 919.851.9703

HAZEN AND SAWYER
Environmental Engineers & Scientists
4011 WestChase Blvd., Raleigh, North Carolina 27607

CITY OF ROANOKE
VIRGINIA
REGIONAL WATER POLLUTION CONTROL PLANT
ADMINISTRATION AND MAINTENANCE BUILDINGS

ADMINISTRATION BUILDING
MECHANICAL
TOP AND ROOF PLAN

THE SCALE BAR SHOWN BELOW MEASURES ONE INCH LONG ON THE ORIGINAL DRAWING.	DATE JANUARY 2004 H & S JOB NUMBER CONTRACT NUMBER C DRAWING NUMBER M921
---	---