



NOTES:


1. REMOVE EXISTING EXHAUST FAN OR HOOD AND CAP EXISTING ROOF CURB.
2. MECHANICAL CONTRACTOR SHALL CONNECT STEAM, CONDENSATE, HWS, HWHR, AND MAKE-UP WATER PIPING TO NEW PUMPING PACKAGE. SEE PIPING SCHEMATIC ON SHEET M962.
3. CONNECT STEAM SUPPLY AND CONDENSATE LINES TO STEAM AND CONDENSATE CONNECTIONS ON NEW STEAM TO HOT WATER HEAT EXCHANGER LOCATED ON MEZZANINE. SEE PIPING SCHEMATIC ON SHEET M963.

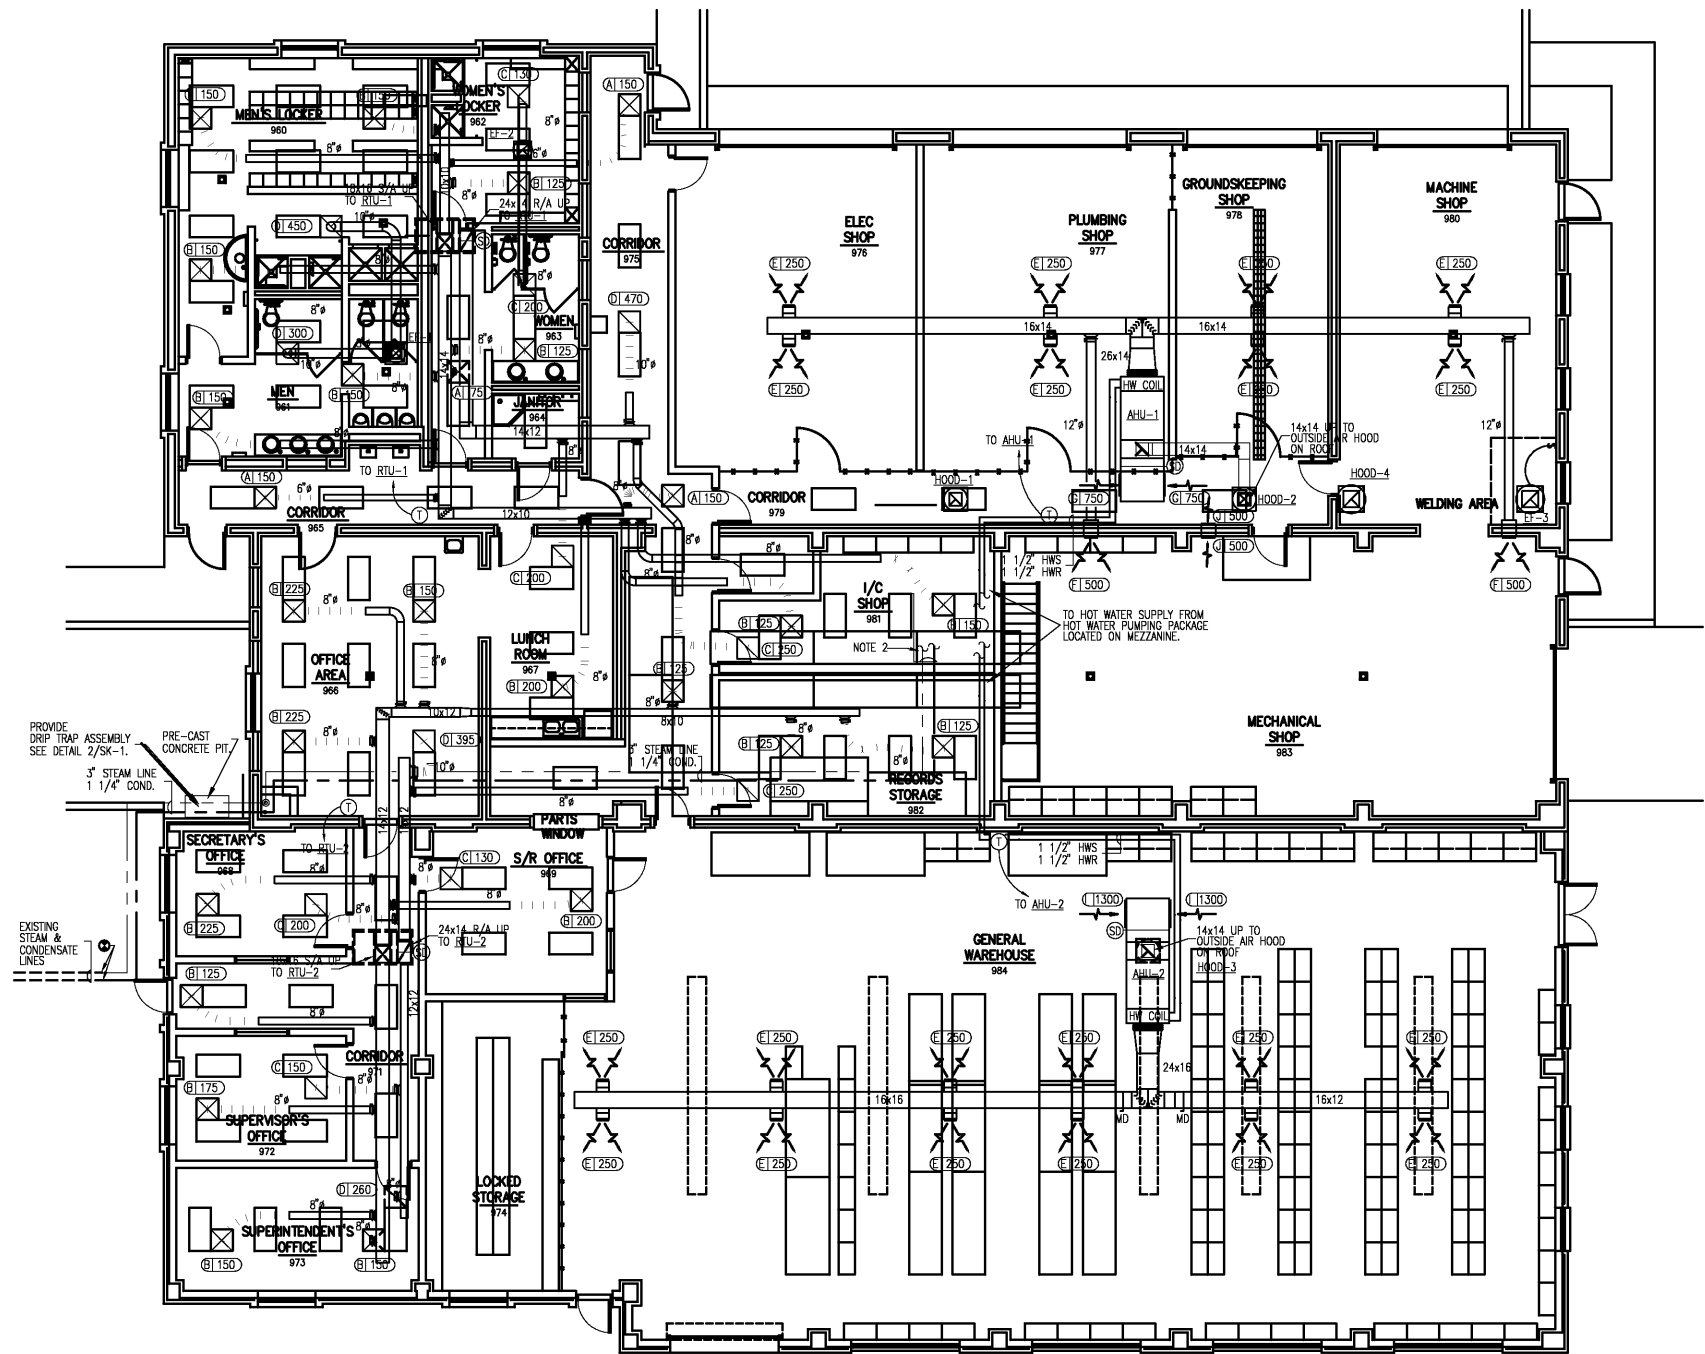

MECHANICAL PLAN
1/8"=1'-0"

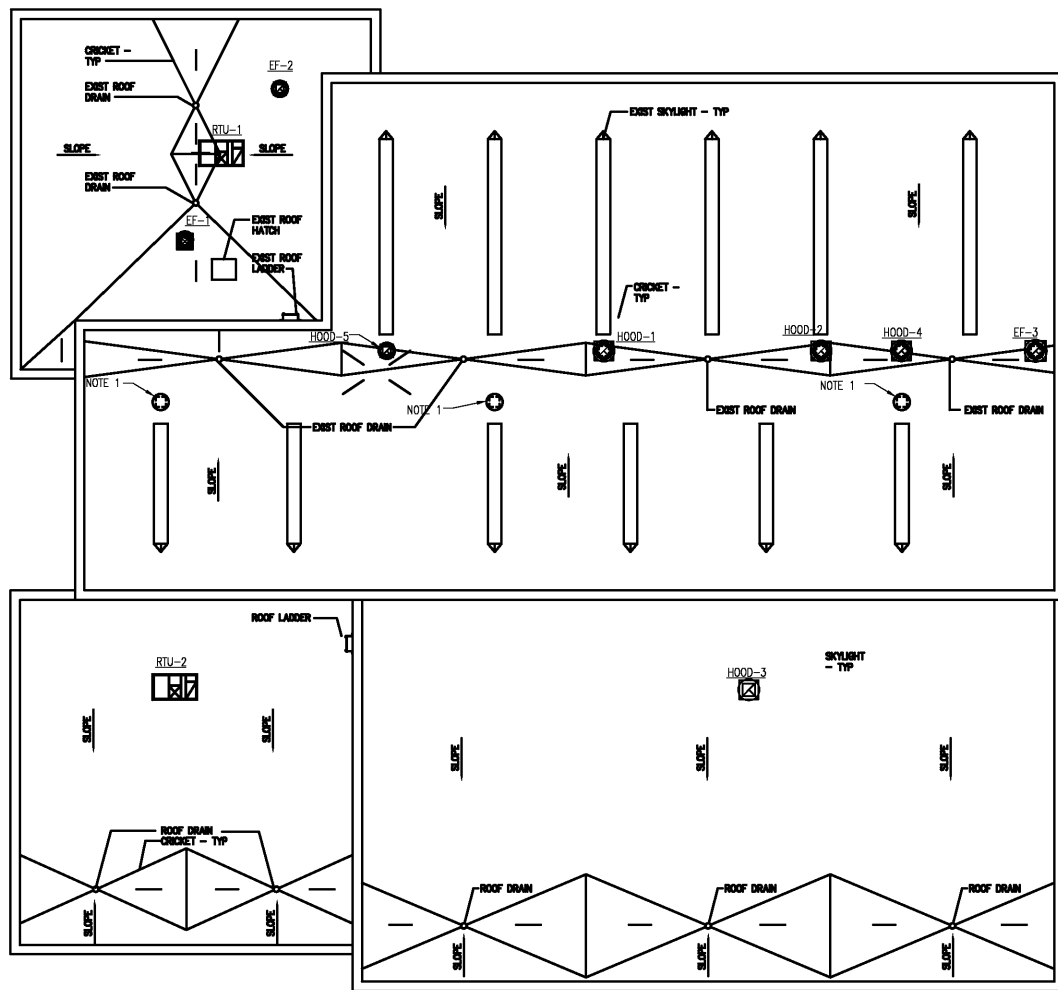

MECHANICAL ROOF PLAN
3/32"=1'-0"

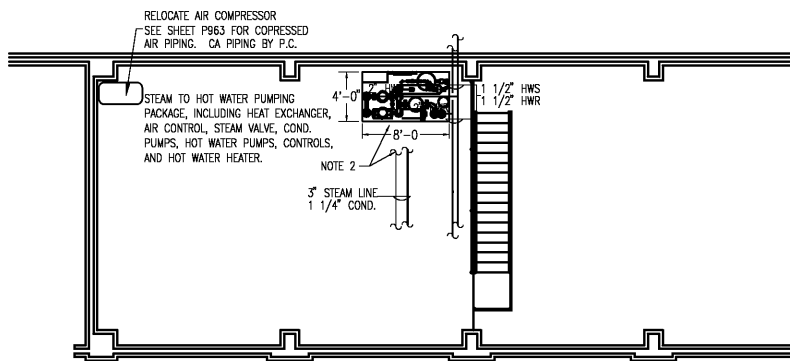

MECHANICAL MEZZANINE PLAN
1/8"=1'-0"

3 RECORD DRAWING JAN 2006 2 CONSTRUCTION JAN 2004 1 REGULATORY APPROVAL NOV 2003 NO. ISSUED FOR DATE BY	DESIGNED RDM DRAWN RDM CHECKED PROJ. ENGR. APPROVED	RECORD DRAWING THIS DOCUMENT ORIGINALLY ISSUED FOR CONSTRUCTION AND SEALED BY M. GINGER SC000334, SEAL NUMBER 0402 033234. THIS MEDIA SHALL NOT BE CONSIDERED A CERTIFIED DOCUMENT	EDI Engineered Designs, Inc. 1011 Schaub Dr. Suite 201 Raleigh, North Carolina 27606 Office: 919.851.8481 Fax: 919.851.9703	HAZEN AND SAWYER Environmental Engineers & Scientists 4011 WestChase Blvd, Raleigh, North Carolina 27607	CITY OF ROANOKE VIRGINIA REGIONAL WATER POLLUTION CONTROL PLANT ADMINISTRATION AND MAINTENANCE BUILDINGS	MAINTENANCE BUILDING MECHANICAL FLOOR PLAN	THE SCALE BAR SHOWN BELOW MEASURES ONE INCH LONG ON THE ORIGINAL DRAWING.	DATE JANUARY 2004 H & S JOB NUMBER 30788C CONTRACT NUMBER C DRAWING NUMBER M961