



INTERIOR
CLEANOUT
DETAIL 1
NOT TO SCALE P-921

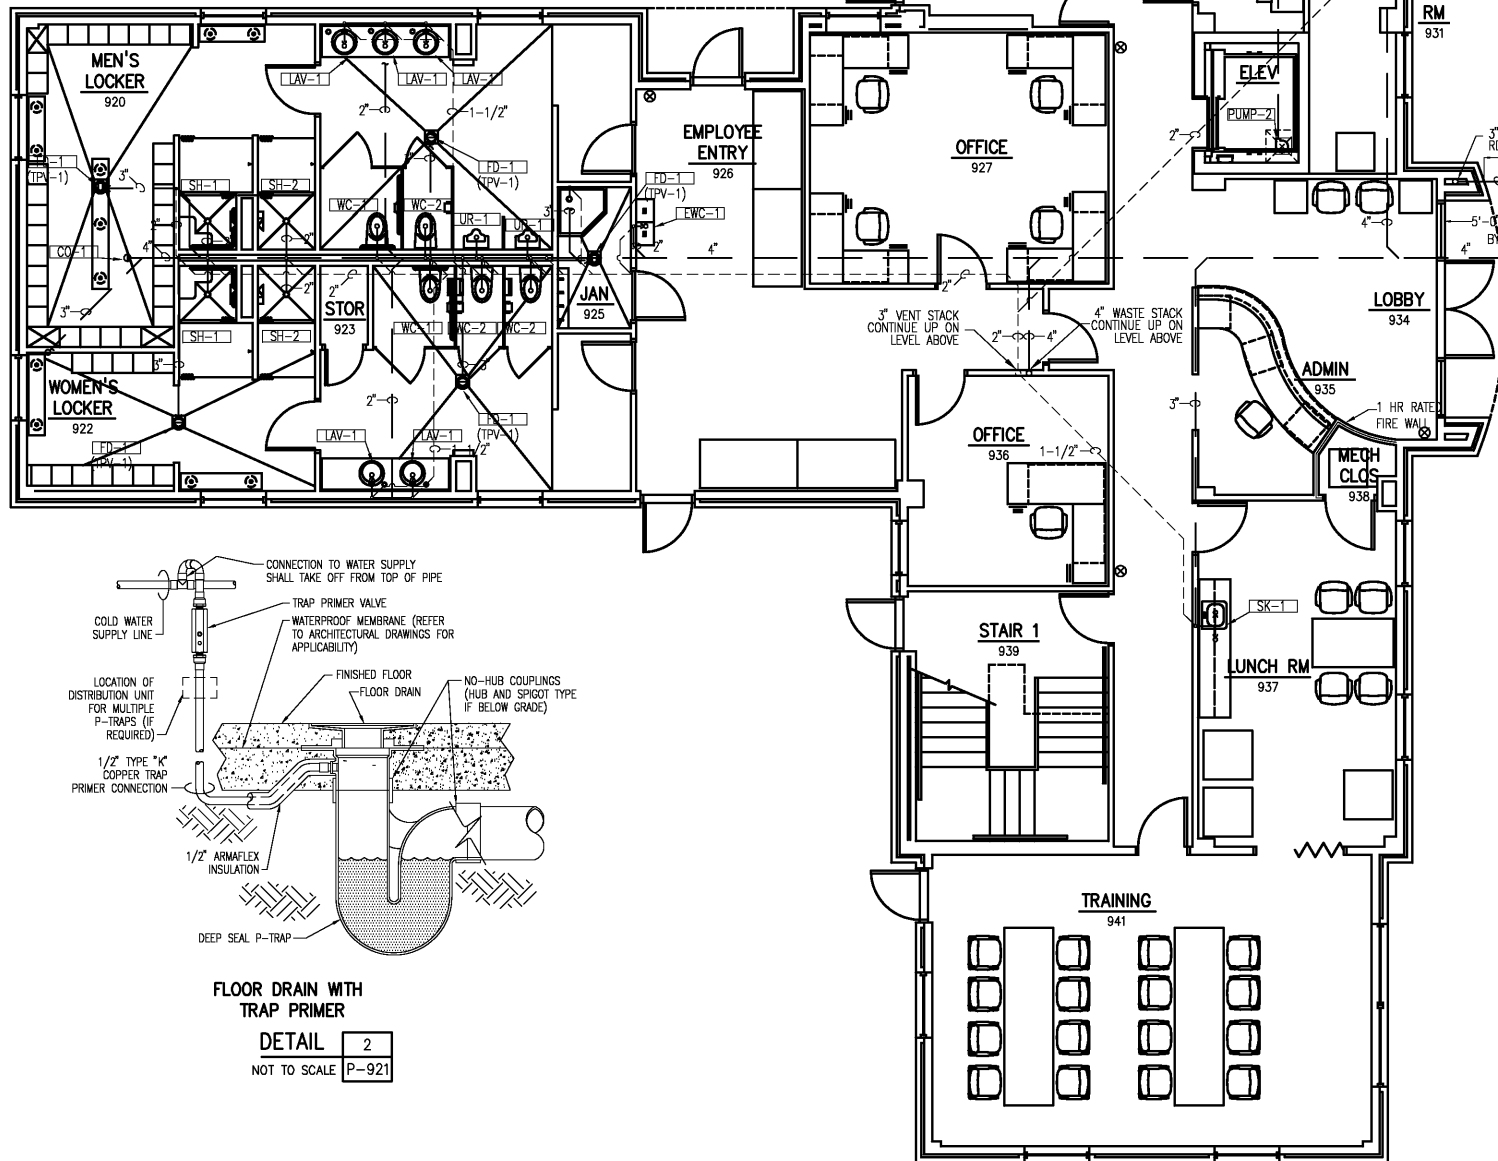


BOTTOM PLAN-SANITARY WASTE PIPING PLAN
3/16"=1'-0"

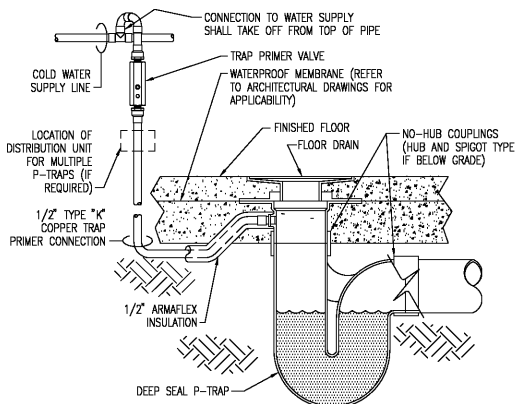


FLOOR DRAIN WITH
TRAP PRIMER
DETAIL 2
NOT TO SCALE P-921

PARTIAL TOP PLAN-SANITARY WASTE PIPING PLAN
3/16"=1'-0"

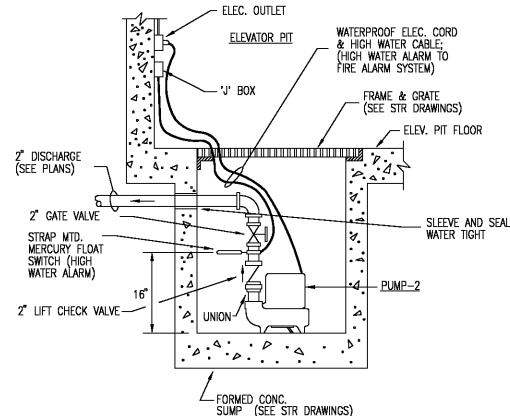

ELEVATOR SUMP
PUMP DETAIL
DETAIL 3
NOT TO SCALE P-921

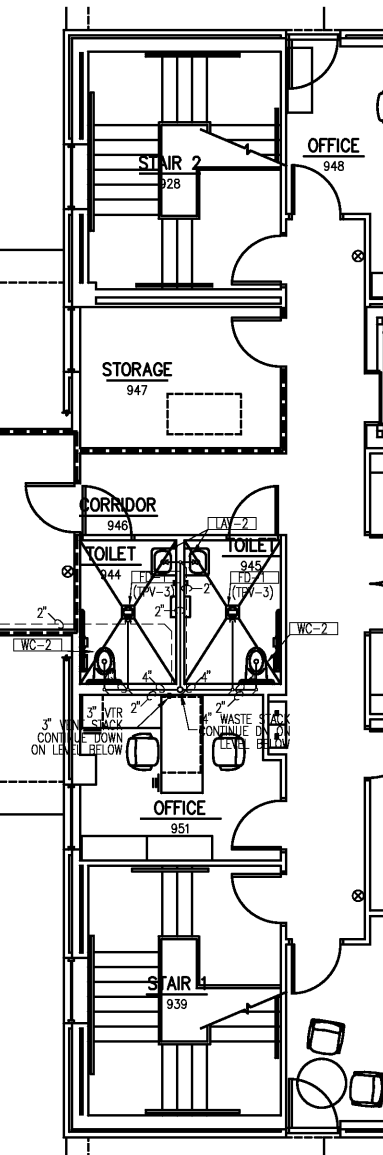

KEY PLAN
NOT TO SCALE

DESIGNED	RDM
DRAWN	RLG
CHECKED	RDM
PROJ. ENGR.	EDI
APPROVED	
NO.	
3	RECORD DRAWING
2	CONSTRUCTION
1	REGULATORY APPROVAL
	ISSUED FOR
	DATE
	BY

RECORD DRAWING

THIS DOCUMENT ORIGINALLY
ISSUED FOR CONSTRUCTION
AND SEALED BY M. GINGER
SC03234. SEAL NUMBER 0402
033234. THIS MEDIA SHALL
NOT BE CONSIDERED A
CERTIFIED DOCUMENT

EDI

Engineered Designs, Inc.
1011 Schaub Dr. Suite 201
Raleigh, North Carolina 27606
Office: 919.851.8481
Fax: 919.851.9703

HAZEN AND SAWYER

Environmental Engineers & Scientists
4011 WestChase Blvd, Raleigh, North Carolina 27607

CITY OF ROANOKE VIRGINIA

REGIONAL WATER POLLUTION CONTROL PLANT
ADMINISTRATION AND MAINTENANCE BUILDINGS

ADMINISTRATION BUILDING
PLUMBING
SANITARY WASTE PIPING PLAN

THE SCALE BAR SHOWN BELOW MEASURES ONE INCH LONG ON THE ORIGINAL DRAWING.	DATE JANUARY 2004 H & S JOB NUMBER 30788C CONTRACT NUMBER C DRAWING NUMBER P921
--	---