


NOTES:
1 MOUNT TYPE L FIXTURES SO THAT THE LOWEST PART OF THE FIXTURE IS 8FT ABOVE THE SLAB.

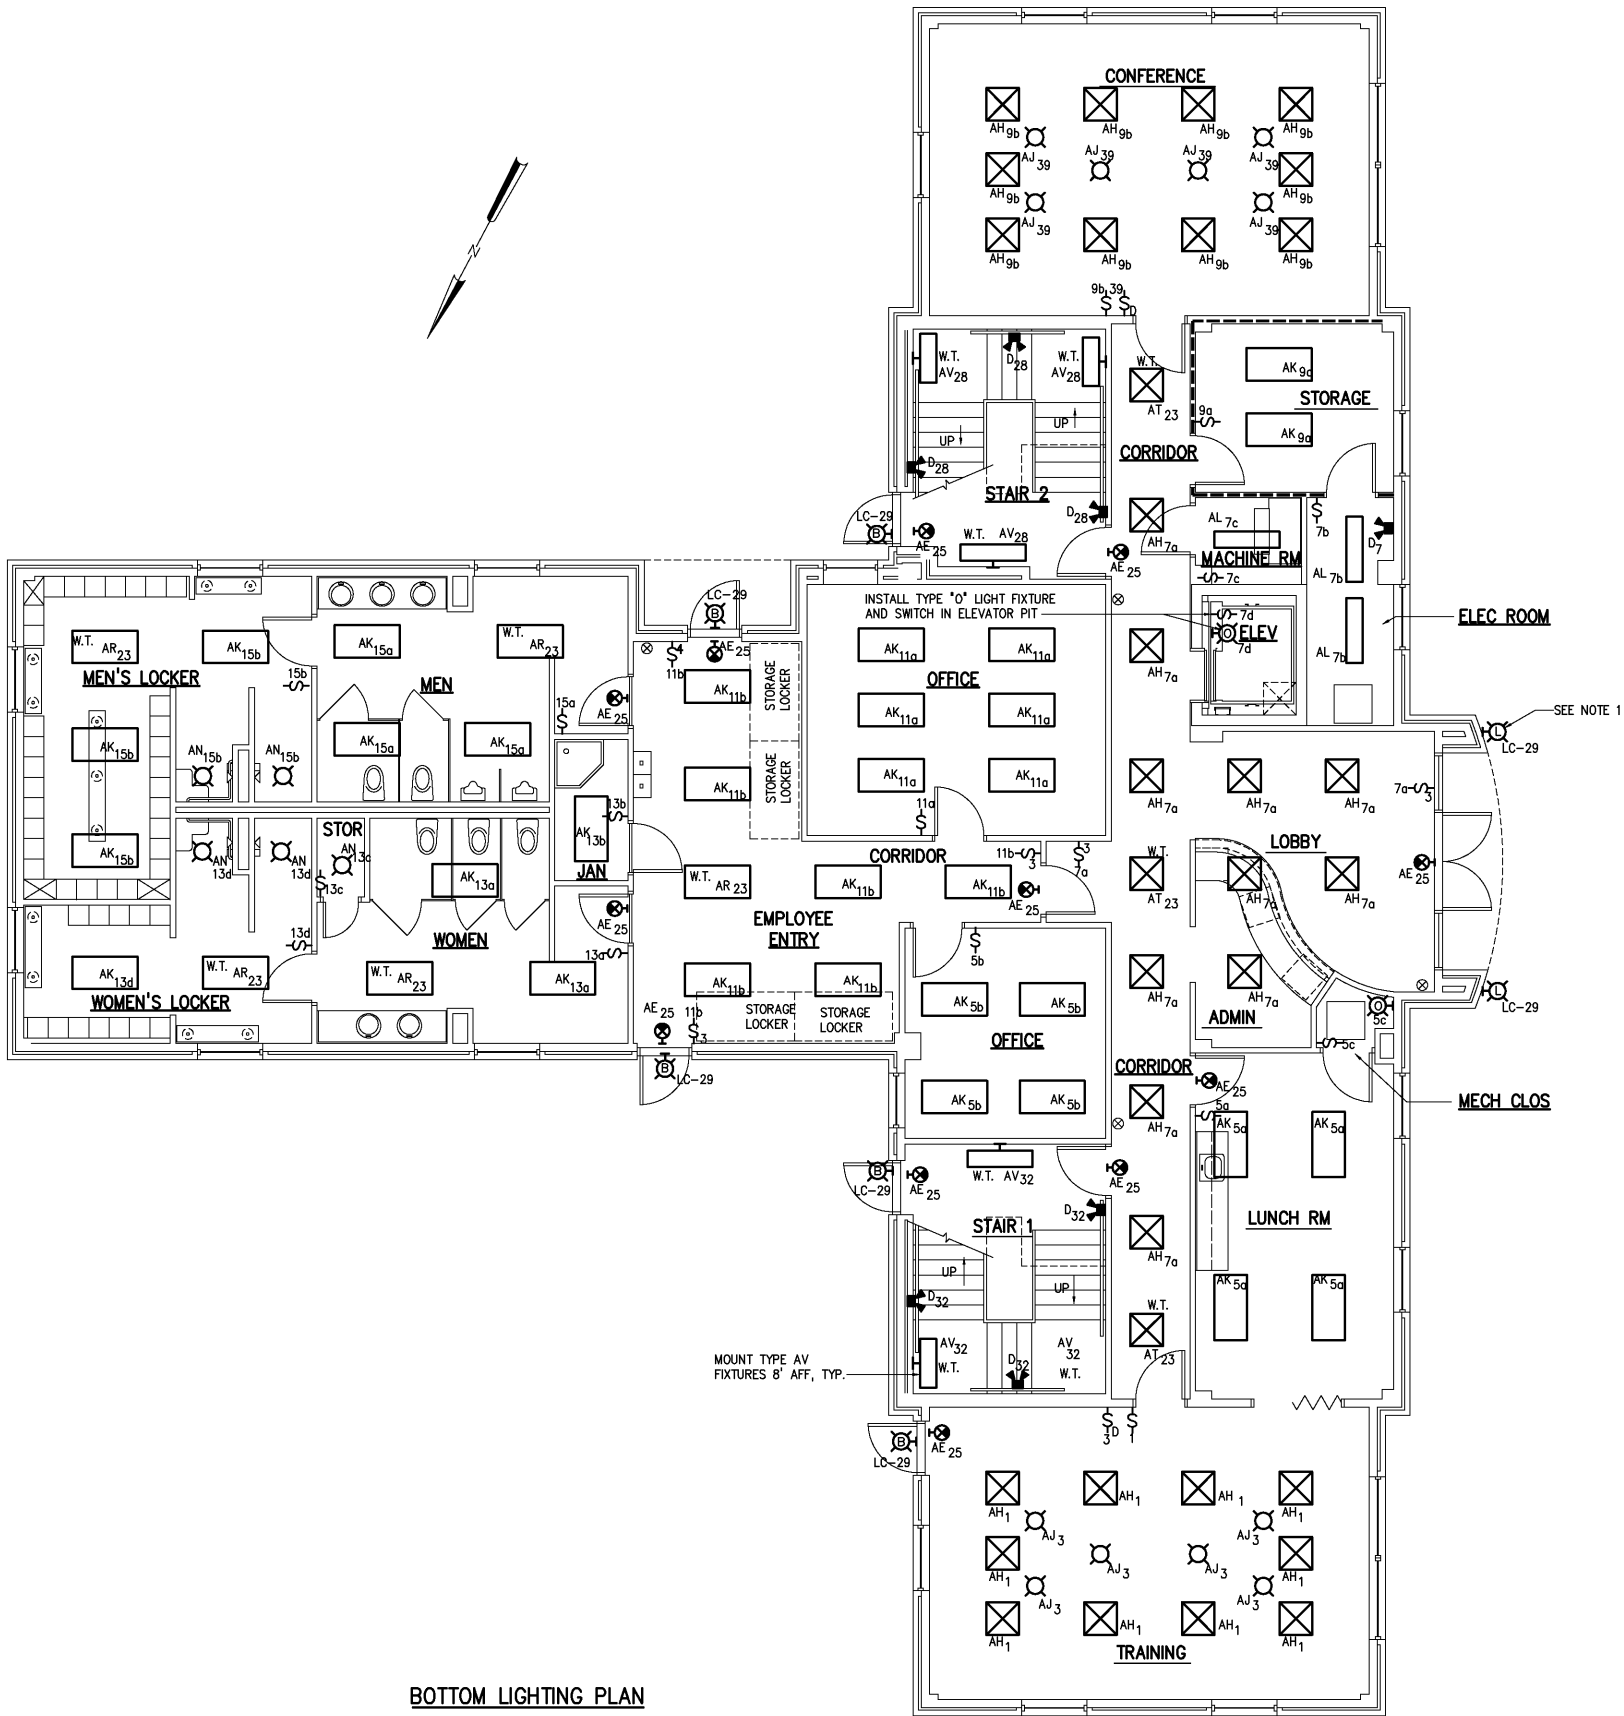

BOTTOM LIGHTING PLAN
3/16"=1'-0"

				DESIGNED	BRL	RECORD DRAWING	THIS DOCUMENT ORIGINALLY ISSUED FOR CONSTRUCTION AND SEALED BY ROBERT S. DIFIORE, SEAL NO. 22769	THIS DRAWING HAS BEEN MODIFIED TO REFLECT FIELD CHANGES REPORTED BY THE CONTRACTOR OR ANOTHER PARTY, BUT NOT VERIFIED BY THE CERTIFYING ENGINEER. THIS DOCUMENT ORIGINALLY ISSUED AND SEALED BY GERALD J. RATASKY, 026535. THIS MEDIA SHALL NOT BE CONSIDERED A CERTIFIED DOCUMENT.	HAZEN AND SAWYER Environmental Engineers & Scientists 4011 WestChase Blvd, Raleigh, North Carolina 27607	CITY OF ROANOKE VIRGINIA	REGIONAL WATER POLLUTION CONTROL PLANT PROCESS TRAIN IMPROVEMENTS	ADMINISTRATION BUILDING ELECTRICAL BOTTOM LIGHTING PLAN	THE SCALE BAR SHOWN BELOW MEASURES ONE INCH LONG ON THE ORIGINAL DRAWING.	DATE JANUARY 2004		
				DRAWN	DJG									H & S JOB NUMBER	30788C	
				CHECKED										CONTRACT NUMBER	DRAWING NUMBER	
3	RECORD DRAWING	JAN 2006	RLT	PROJ. ENGR.	H & S										C	E920
2	CONSTRUCTION	JAN 2004	RLT													
1	REGULATORY APPROVAL	NOV 2003	RLT													
NO.	ISSUED FOR	DATE	BY	APPROVED												